


KEY

LEGEND	
	Emergency Exit
	Water Fire Extinguisher
	Powder Fire Extinguisher
	CO2 Fire Extinguisher
	Foam Fire Extinguisher
	Fire Blanket
	First Aid Station
	Emergency Break Glass
	Gas Switch Off
	Water Switch Off
	Fuseboard
	Fire Panel
	CPR Mask
	Medication Press
	Carbon Monoxide detector
	Fire Door
	Heat Detector
	Smoke Detector
	Security Alarm
	O2 Cylinder
	Emergency Lighting
	Fire Hydrant
	Fire Assembly point

Rev	Revision/Issue	Date
A		

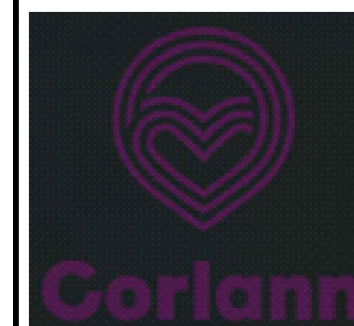


Firm Name and Address
CORLANN,
 South East Region,
 Belmont Park,
 Ferrybank,
 Waterford. X91 NCX7

Project Name and Address
NEW OFFICES AT,
 Belmont Park,
 Ferrybank,
 Waterford. X91 NCX7

Project: 2,Enabling works	Sheet: 2 of 13
Date: JUN 2026	Rev: A
Scale: 1:25 in A3	

- EXISTING RWP TO BE REMOVED(temporary (and later permanent) provision for drainage to be provided for)
- EXISTING MH TO BE REMOVED
- EXISTING WASTE WATER PIPES TO BE REMOVED
- EXISTING FUSE BOARD, TO BE DISCONNECTED AND MADE SAFE

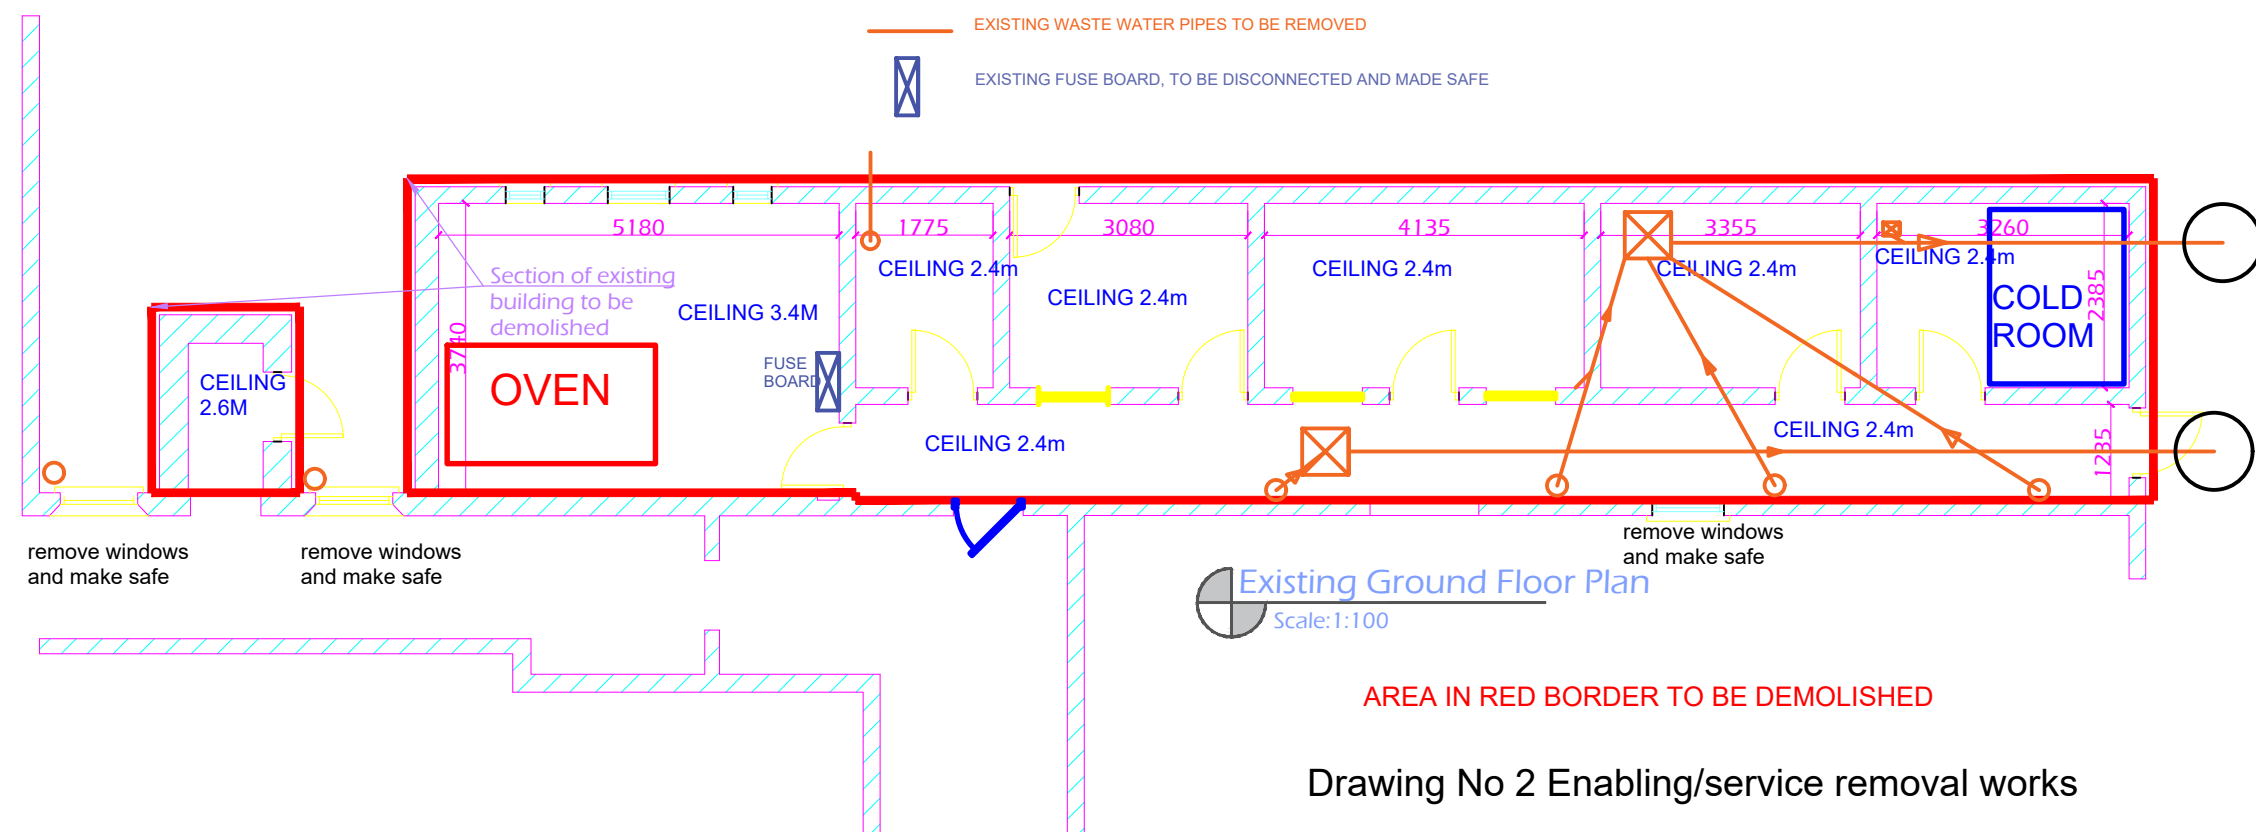

Existing Ground Floor Plan
 Scale: 1:100

AREA IN RED BORDER TO BE DEMOLISHED

Drawing No 2 Enabling/service removal works