


KEY

LEGEND	
	Emergency Exit
	Water Fire Extinguisher
	Powder Fire Extinguisher
	CO2 Fire Extinguisher
	Foam Fire Extinguisher
	Fire Blanket
	First Aid Station
	Emergency Break Glass
	Gas Switch Off
	Water Switch Off
	Fuseboard
	Fire Panel
	CPR Mask
	Medication Press
	Carbon Monoxide detector
	Fire Door
	Heat Detector
	Smoke Detector
	Security Alarm
	O2 Cylinder
	Emergency Lighting
	Fire Hydrant
	Fire Assembly point


Rev	Revision/Issue	Date
A		

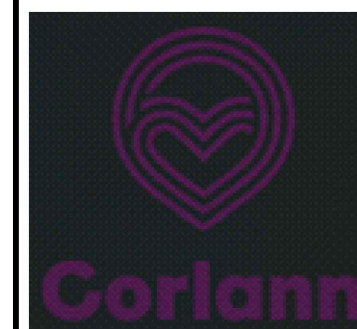

Firm Name and Address
CORLANN,
 South East Region,
 Belmont Park,
 Ferrybank,
 Waterford. X91 NCX7

Project Name and Address
NEW OFFICES AT,
 Belmont Park,
 Ferrybank,
 Waterford. X91 NCX7

Project: 10, Door plan	Sheet: 10 of 13
Date: JUN 2026	Rev: A
Scale: 1:25 in A3	

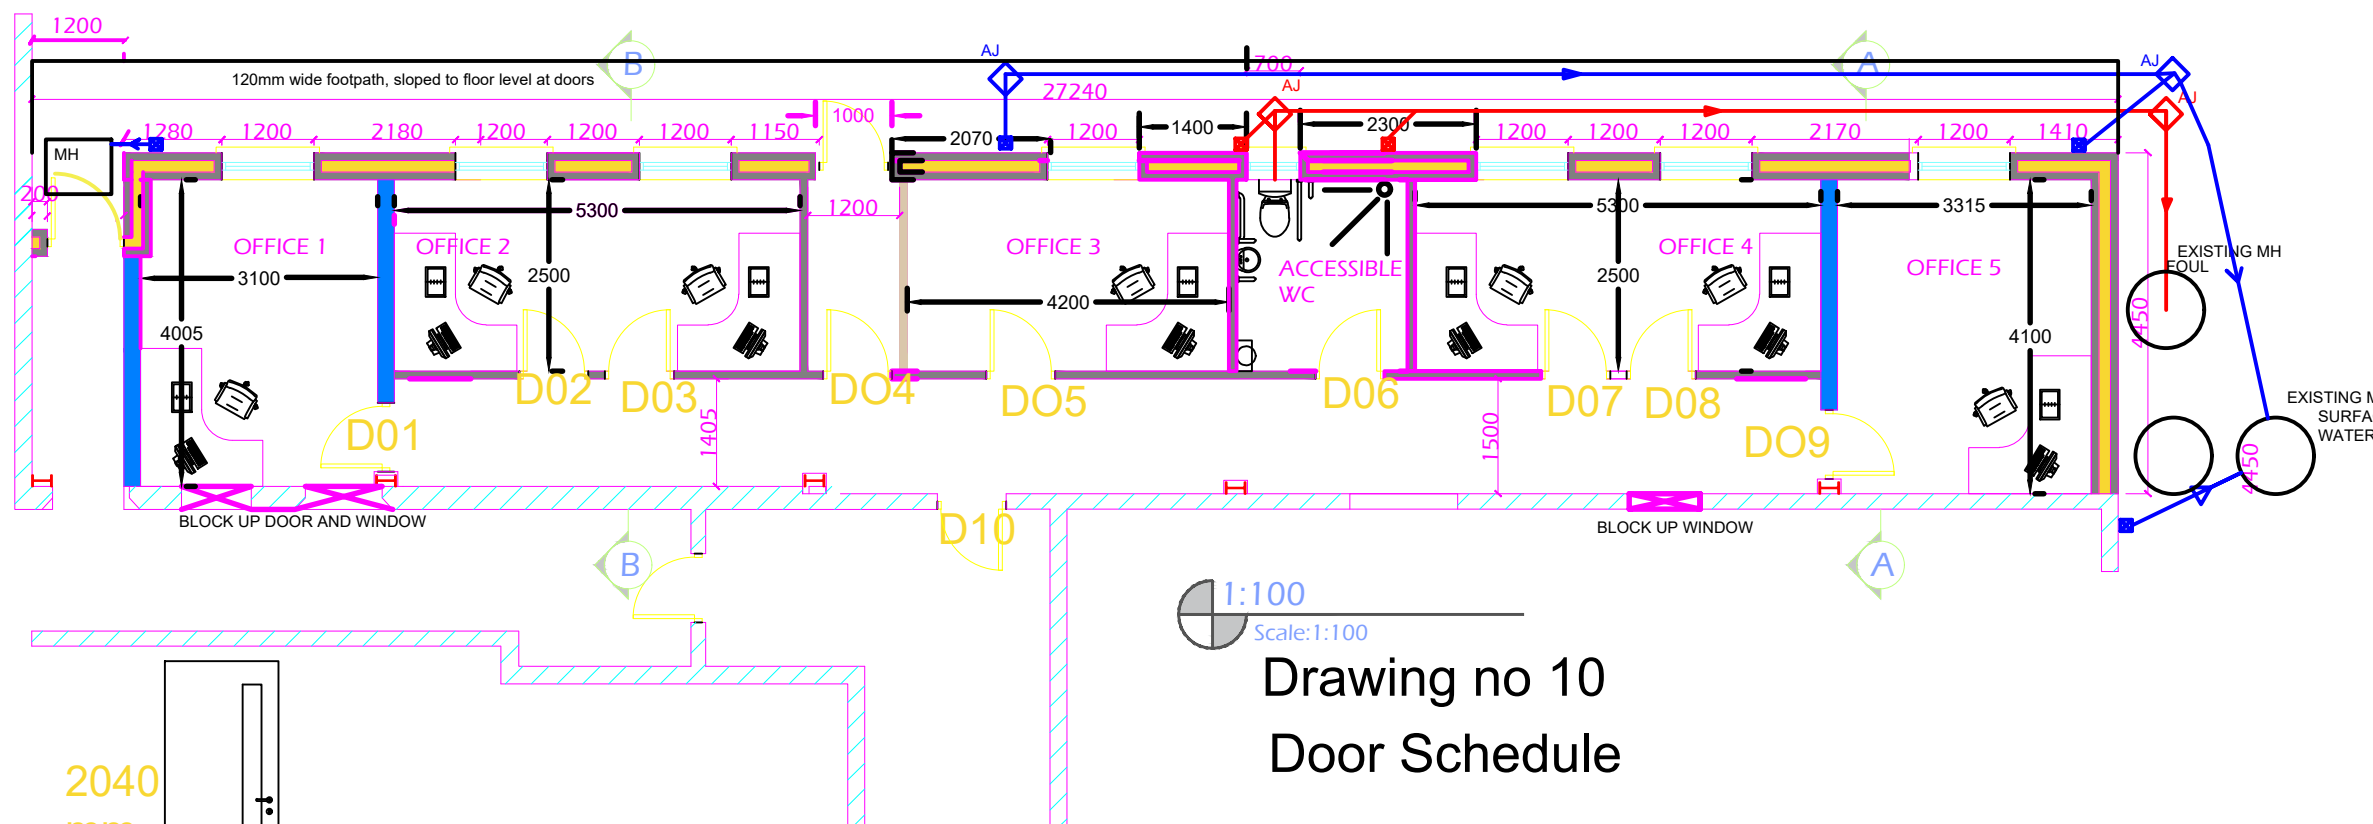

2040 mm

900mm

FD 30 Fire door, Beech veneer, complete with door closer, intumescent strip pyro glass.

D01 to D10

1:100
Scale:1:100

Drawing no 10
Door Schedule