


- EL EMERGENCY LIGHT
- ex EXIT SIGN
- LED LIGHT FITTING
- LED LIGHT FITTING
- ELECTRICAL AND DATA DADO RAIL AT 900MM
- S SMOKE HEAD
- BG BREAK GLASS
- SO SOUNDER
- FB FUZE BOARD

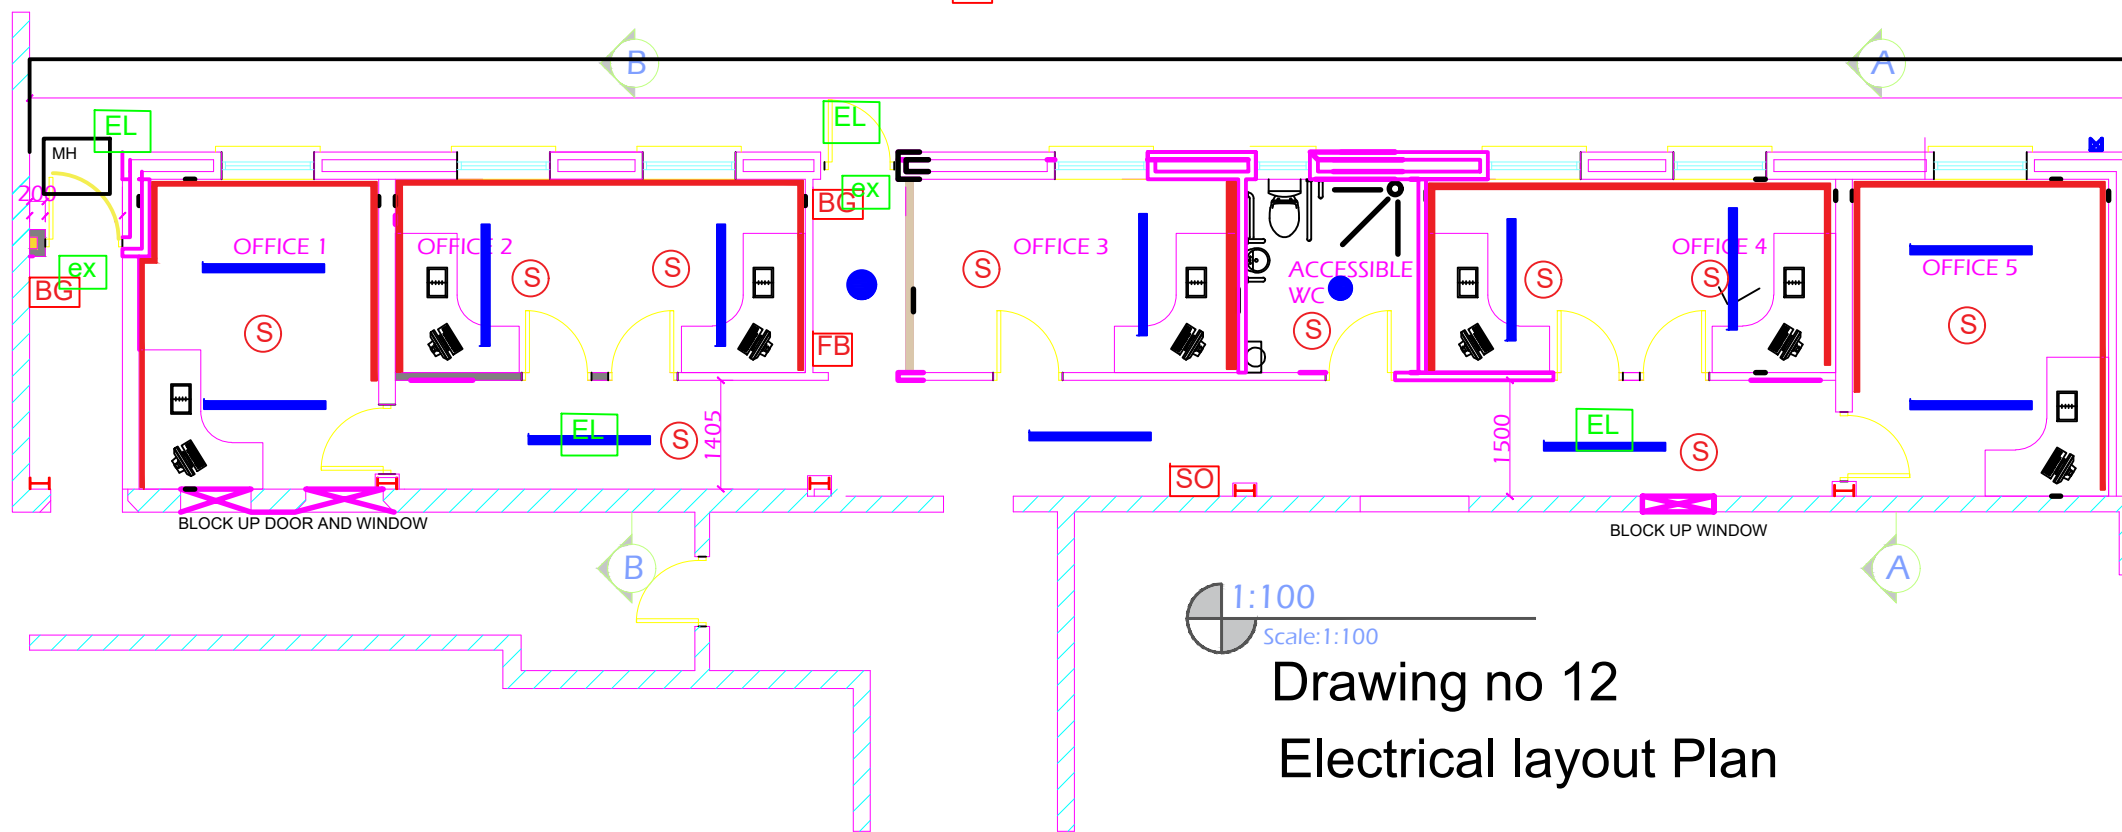


1:100
Scale: 1:100

Drawing no 12
Electrical layout Plan

KEY	
LEGEND	
EXIT	Emergency Exit
▽	Water Fire Extinguisher
▽	Powder Fire Extinguisher
▽	CO2 Fire Extinguisher
▽	Foam Fire Extinguisher
FB	Fire Blanket
+	First Aid Station
⊙	Emergency Break Glass
G	Gas Switch Off
W	Water Switch Off
F.S.B	Fuseboard
F.P	Fire Panel
CPR	CPR Mask
MP	Medication Press
CM	Carbon Monoxide detector
FD	Fire Door
⊕	Heat Detector
⊙	Smoke Detector
SA	Security Alarm
O2	O2 Cylinder
E	Emergency Lighting
HYD	Fire Hydrant
✓	Fire Assembly point

Rev	Revision/Issue	Date
A		

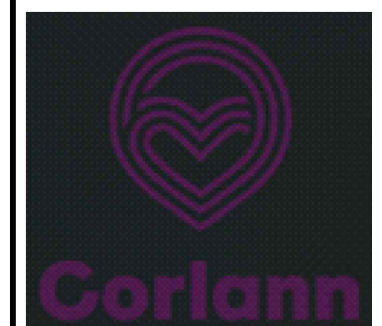

Firm Name and Address
CORLANN,
 South East Region,
 Belmont Park,
 Ferrybank,
 Waterford. X91 NCX7

Project Name and Address
NEW OFFICES AT,
 Belmont Park,
 Ferrybank,
 Waterford. X91 NCX7

Project: 12, Electrical	Sheet: 12 of 13
Date: JUN 2026	Rev: A
Scale: 1:25 in A3	