

NOTES

1. This drawing is the property of Carlow County Council, it is a confidential document and must not be copied, used, or its content divulged without prior written consent.
2. DO NOT SCALE. Use figured dimensions only, if in doubt ask.


KEY TO ELECTRICAL SYMBOLS:

NOTE 1:
INCLUDE FOR ALL NECESSARY BUILDERS WORK AND ATTENDANCES FOR MECH. & ELEC. INSTALLATIONS. ALL CHASINGS TO BE MACHINE CUT.

- ⊕ PENDANT LIGHT
- ⊙ EXTERNAL LIGHT
- 1 GANG LIGHT SWITCH
- 2 GANG LIGHT SWITCH
- ▭ STRIP LIGHT SHAVER SOCKET
- ⊗ MECHANICAL VENTILATION UNIT
- SINGLE SOCKET
- ⊖ DOUBLE SOCKET
- ⊞ COOKER SWITCH
- ⚡ FRIDGE, EXTRACTOR, WASHING MACHINE ISOLATOR SWITCHES
- ⊞ DOUBLE SOCKET-WORKTOP LEVEL
- ⊞ SINGLE SOCKET-WORKTOP LEVEL
- ⊞ EXTRACT FAN SOCKET
- ⊗ SMOKE ALARM (EI 166 RC OPTICAL)
- ⊗ HEAT DETECTOR (EI 164 RC)

DRAINAGE LEGEND:

- EXISTING FOUL DRAINAGE
 EXISTING FOUL DRAINAGE
- PROPOSED FOUL DRAINAGE
 PROPOSED FOUL DRAINAGE
- PROPOSED SURFACE WATER DRAINAGE
 PROPOSED SW DRAINAGE

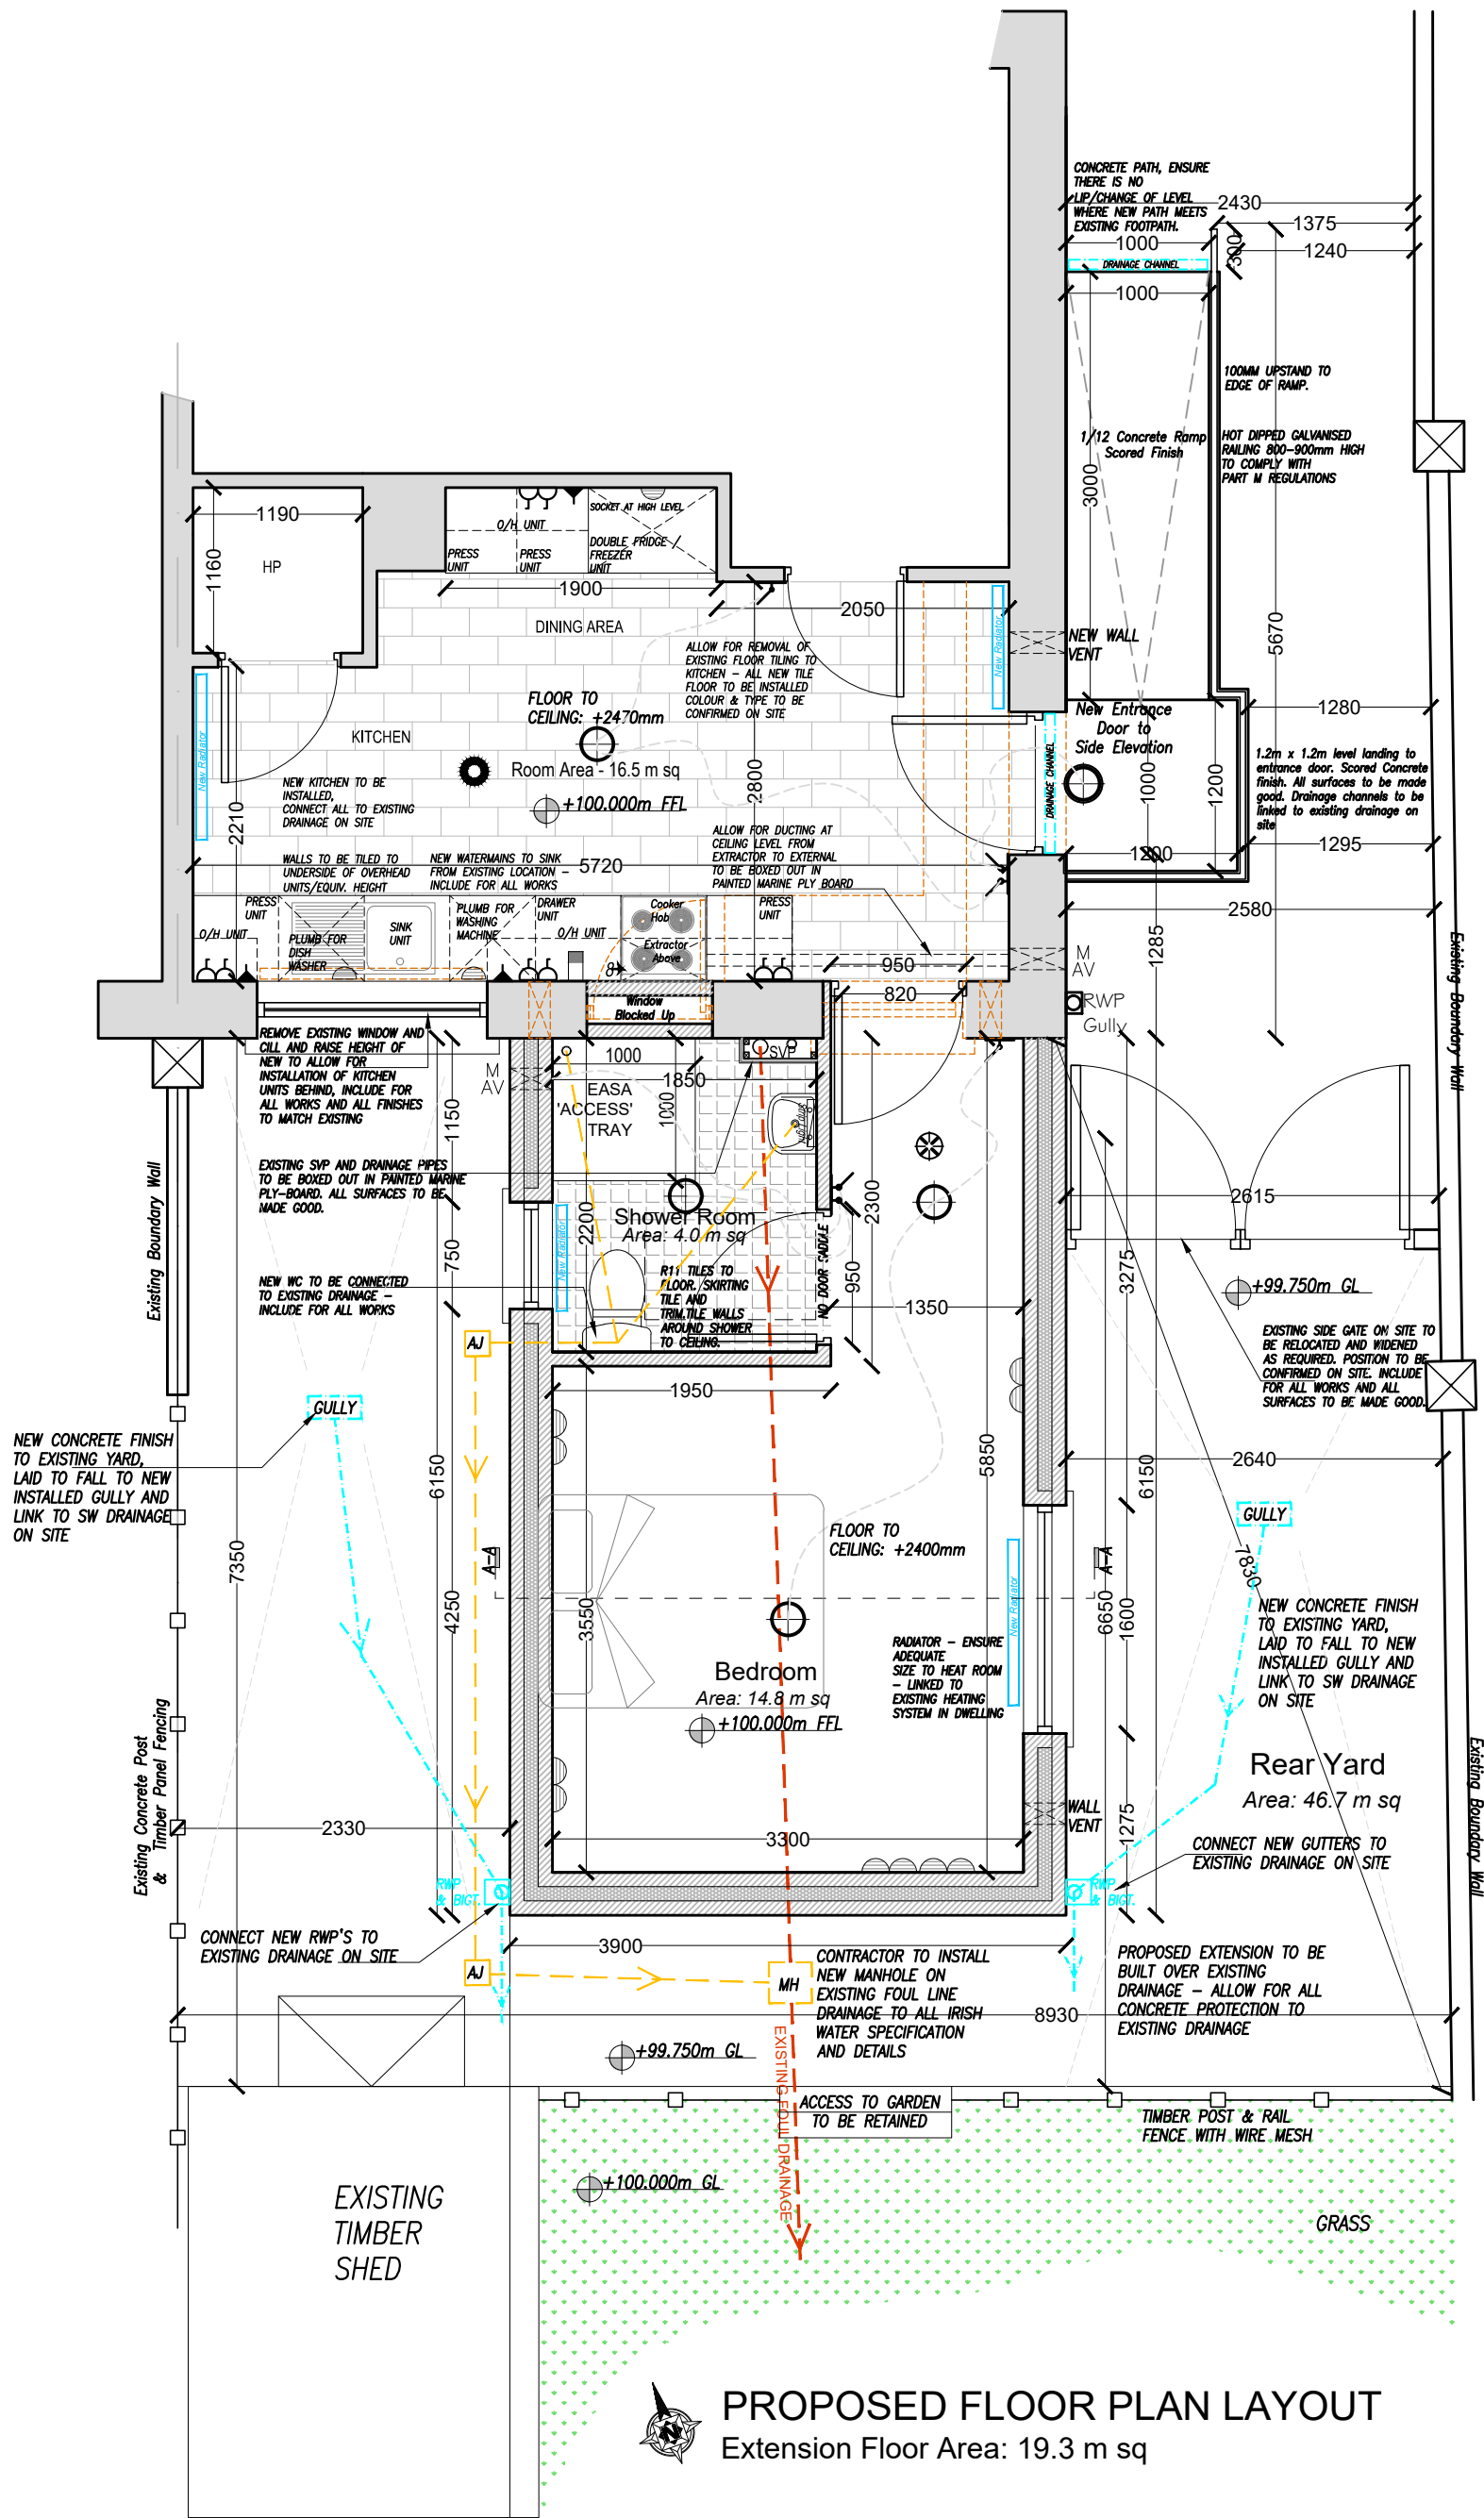

PROPOSED FLOOR PLAN LAYOUT
 Extension Floor Area: 19.3 m sq



CYAL50441107
 Tailte Éireann - Surveying.

No.	Date	Amendment / Issue	App.

CARLOW COUNTY COUNCIL
 HOUSING DEPARTMENT
 Director Of Services: Claire Hartley,
 Tullow Civic Offices, Inner Relief Road, Tullow, Co. Carlow
 Phone: (059)9136296 Fax: (059)9152156
 Email: secretar@carlowccoco.ie

Engineers Ireland
 Carlow Local Authorities, A CPD Accredited Company

Project: **EXTENSION TO 95 RIVERVIEW CLOSE, CARLOW TOWN R93V298**

Title: **PROPOSED FLOOR PLAN**

Drawn by:	FM	Job No:	
Checked by:	NB.	Drw Loc:	
Approved by:	NB.	Drw No:	
Scale:	1/50	103	
Date:	03/06/2026		