

NOTES:

- |    |                                                                                                                                                                               |
|----|-------------------------------------------------------------------------------------------------------------------------------------------------------------------------------|
| 1. | THIS DRAWING IS TO BE READ IN CONJUNCTION WITH ALL OTHER DRAWINGS AND THE SPECIFICATION.                                                                                      |
| 2. | ALL LEVELS ARE IN METRES O.D. MALIN HEAD.                                                                                                                                     |
| 3. | FOR DETAILS OF BEDDING, REFER TO DRAWING No. 21011-TJOC-00-XX-DR-C-0200.                                                                                                      |
| 4. | FOR VALVE CHAMBER DETAILS REFER TO DRAWING No. 21011-TJOC-00-XX-DR-C-0201.                                                                                                    |
| 5. | FOR MENHOL REINFORCEMENT DETAILS REFER TO DRAWING No. 21011-TJOC-00-XX-DR-C-0202.                                                                                             |
| 6. | THE POSITION & LEVELS OF EXISTING SERVICES INsofar AS THEY ARE KNOWN AND AS SHOWN ON THE DRAWINGS MAY NOT BE ACCURATE AND MERELY INDICATE THEIR PRESENCE IN THE WORKING AREA. |

### LEGEND

## SCOUR VALVE



## SLUICE VALVE



## AIR VALVE



## FIRE HYDRANT



### PROPOSED WATERMAIN



**EXISTING WATERMAIN**




 
**HOUSE CONNECTION  
NUMBER / METER**



### PRESSURE RELEASE VALVE



JUNCTION NUMBER

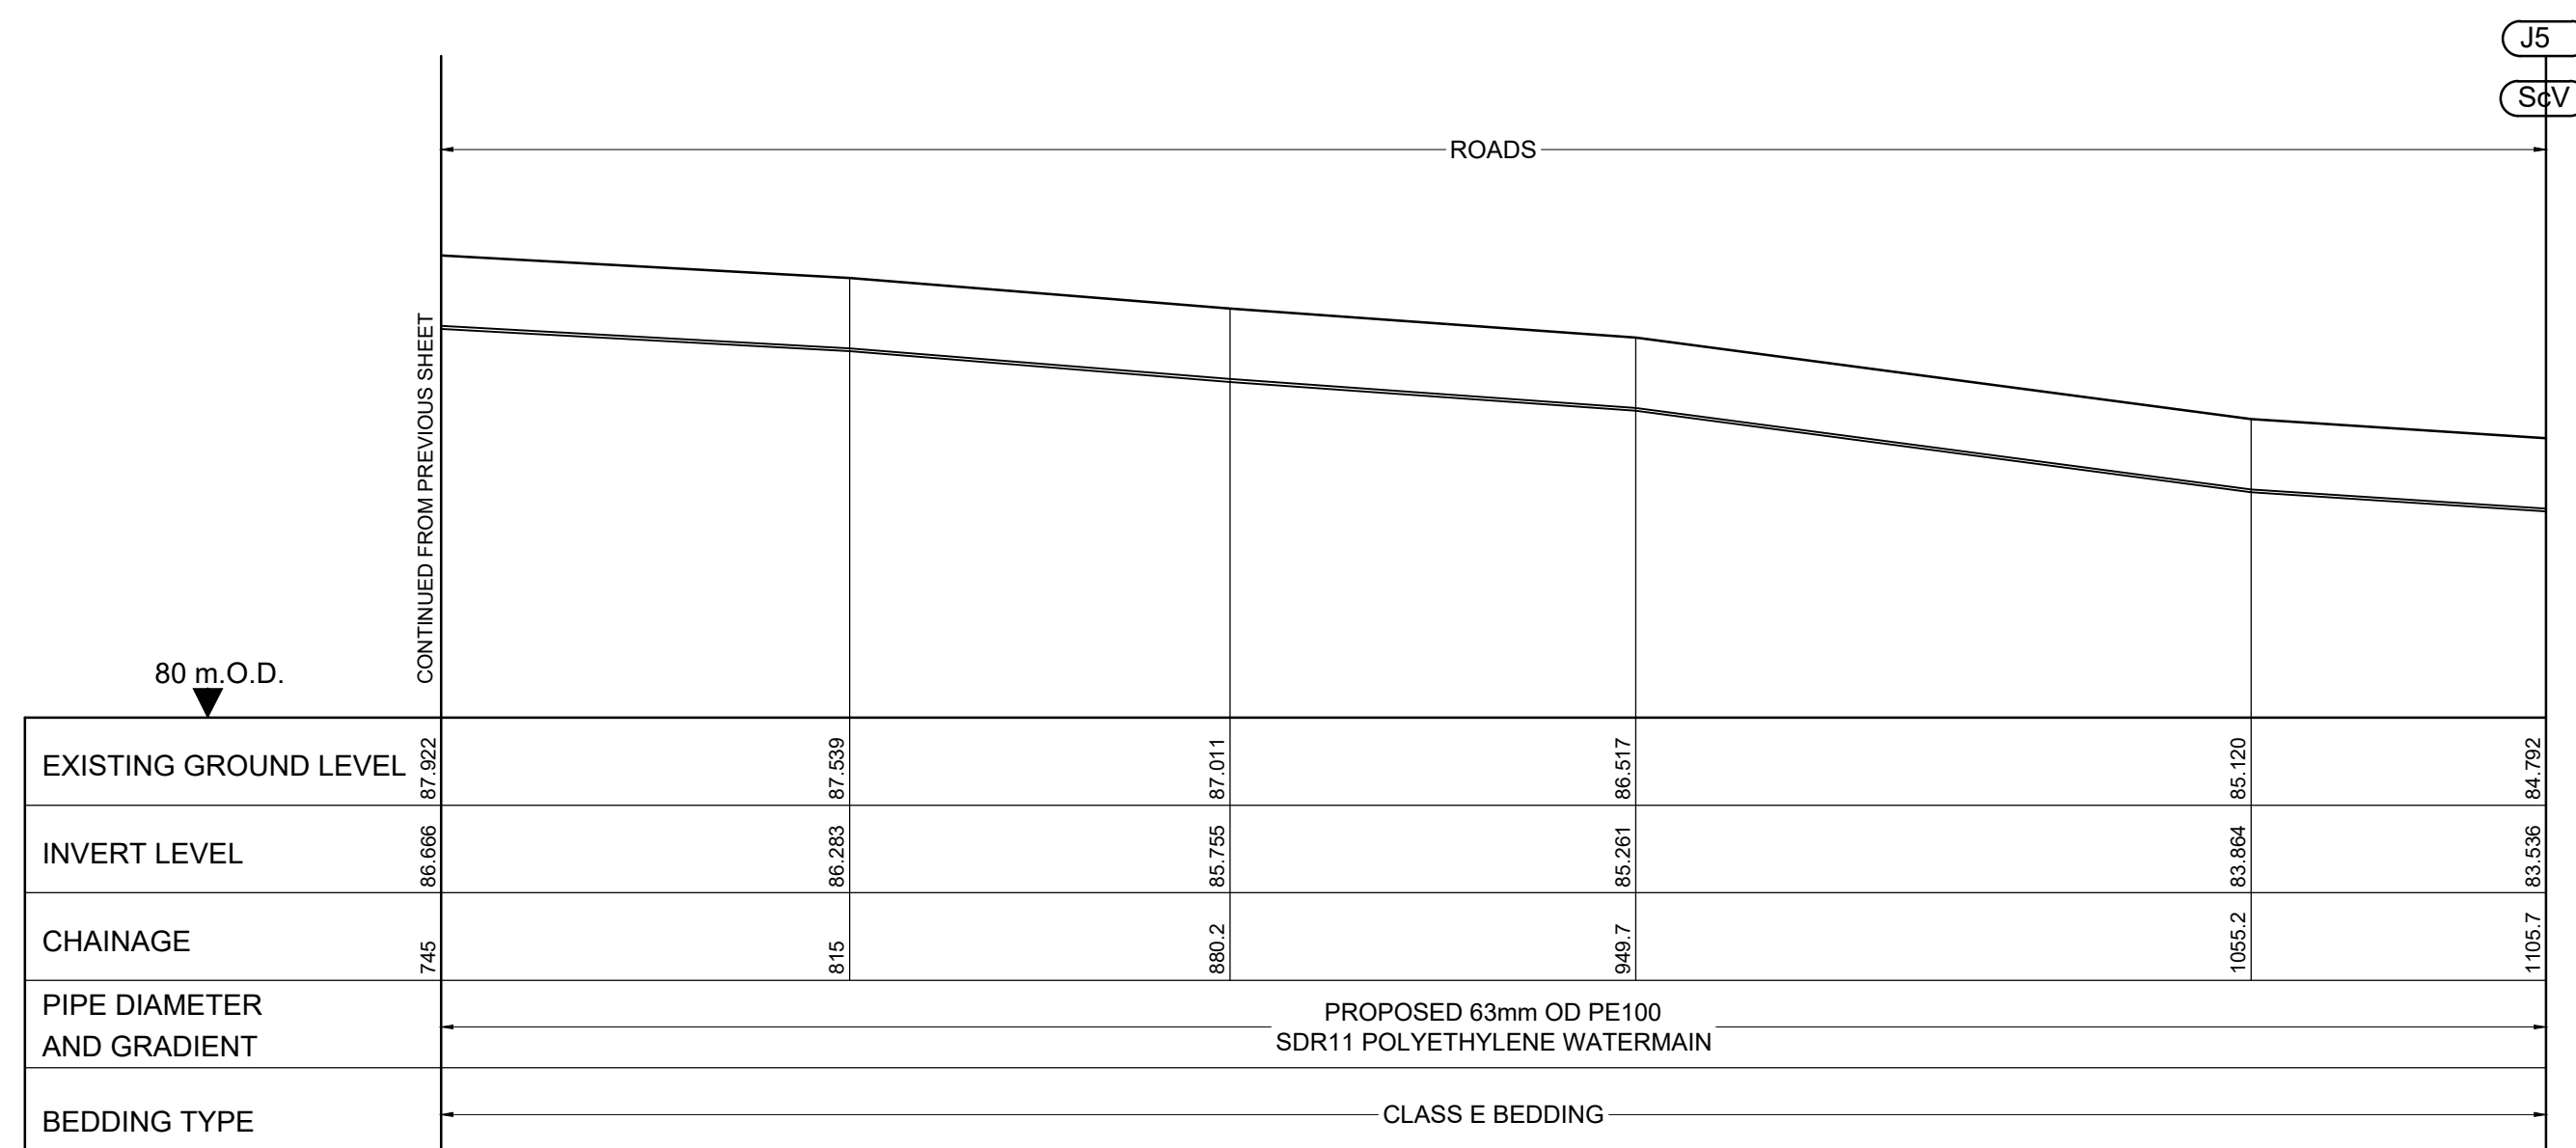

## SECTION J2-J5 (Contd.)

Scale 1:1250H, 1:125V

|     |  |  |  |
|-----|--|--|--|
| P01 |  |  |  |
|-----|--|--|--|

| REV | STAT | DESCRIPTION | DATE |
|-----|------|-------------|------|
|-----|------|-------------|------|

DRAWING STATUS: FOR REVIEW

|                   |                    |                    |
|-------------------|--------------------|--------------------|
| CHECKED BY:<br>GD | REVIEWED BY:<br>LC | APPROVED BY:<br>LC |
|-------------------|--------------------|--------------------|

NO PART OF THIS DOCUMENT MAY BE RE-PRODUCED OR TRANSMITTED IN ANY FORM OR STORED IN ANY RETRIEVAL SYSTEM OF ANY NATURE WITHOUT THE WRITTEN PERMISSION OF THE CONSULTING ENGINEER AS COPYRIGHT HOLDER EXCEPT AS AGREED FOR USE ON THE PROJECT FOR WHICH THE DOCUMENT WAS ORIGINALLY ISSUED.



## CONSULTING ENGINEERS

CORRIG HOUSE, CORRIG ROAD, SANDYFORD, DUBLIN 18.  
Tel: 01-295 2321 Fax: 01-295 4541 Email: [tjoc@tjoc.ie](mailto:tjoc@tjoc.ie) Web: [www.tjoc.ie](http://www.tjoc.ie)

PROJECT: PEAKE MANTUA GWS TO CORRACREIGH GWS  
INTERCONNECTOR

|         |                  |
|---------|------------------|
| CLIENT: | PEAKE MANTUA GWS |
|---------|------------------|

DRAWING TITLE:  
WATERMAIN LONGITUDINAL SECTIONS  
SECTION J2 TO J5 - SHEET 2 OF 2

SCALE: 1:1250 (A1)

|                                                                 |      |
|-----------------------------------------------------------------|------|
| PROJECT - ORIGINATOR - VOLUME - LOCATION - TYPE - ROLE - NUMBER | REV: |
| 21011-TJOC-XX-XX-DR-C-0110                                      | P01  |