



Existing boiler room layout

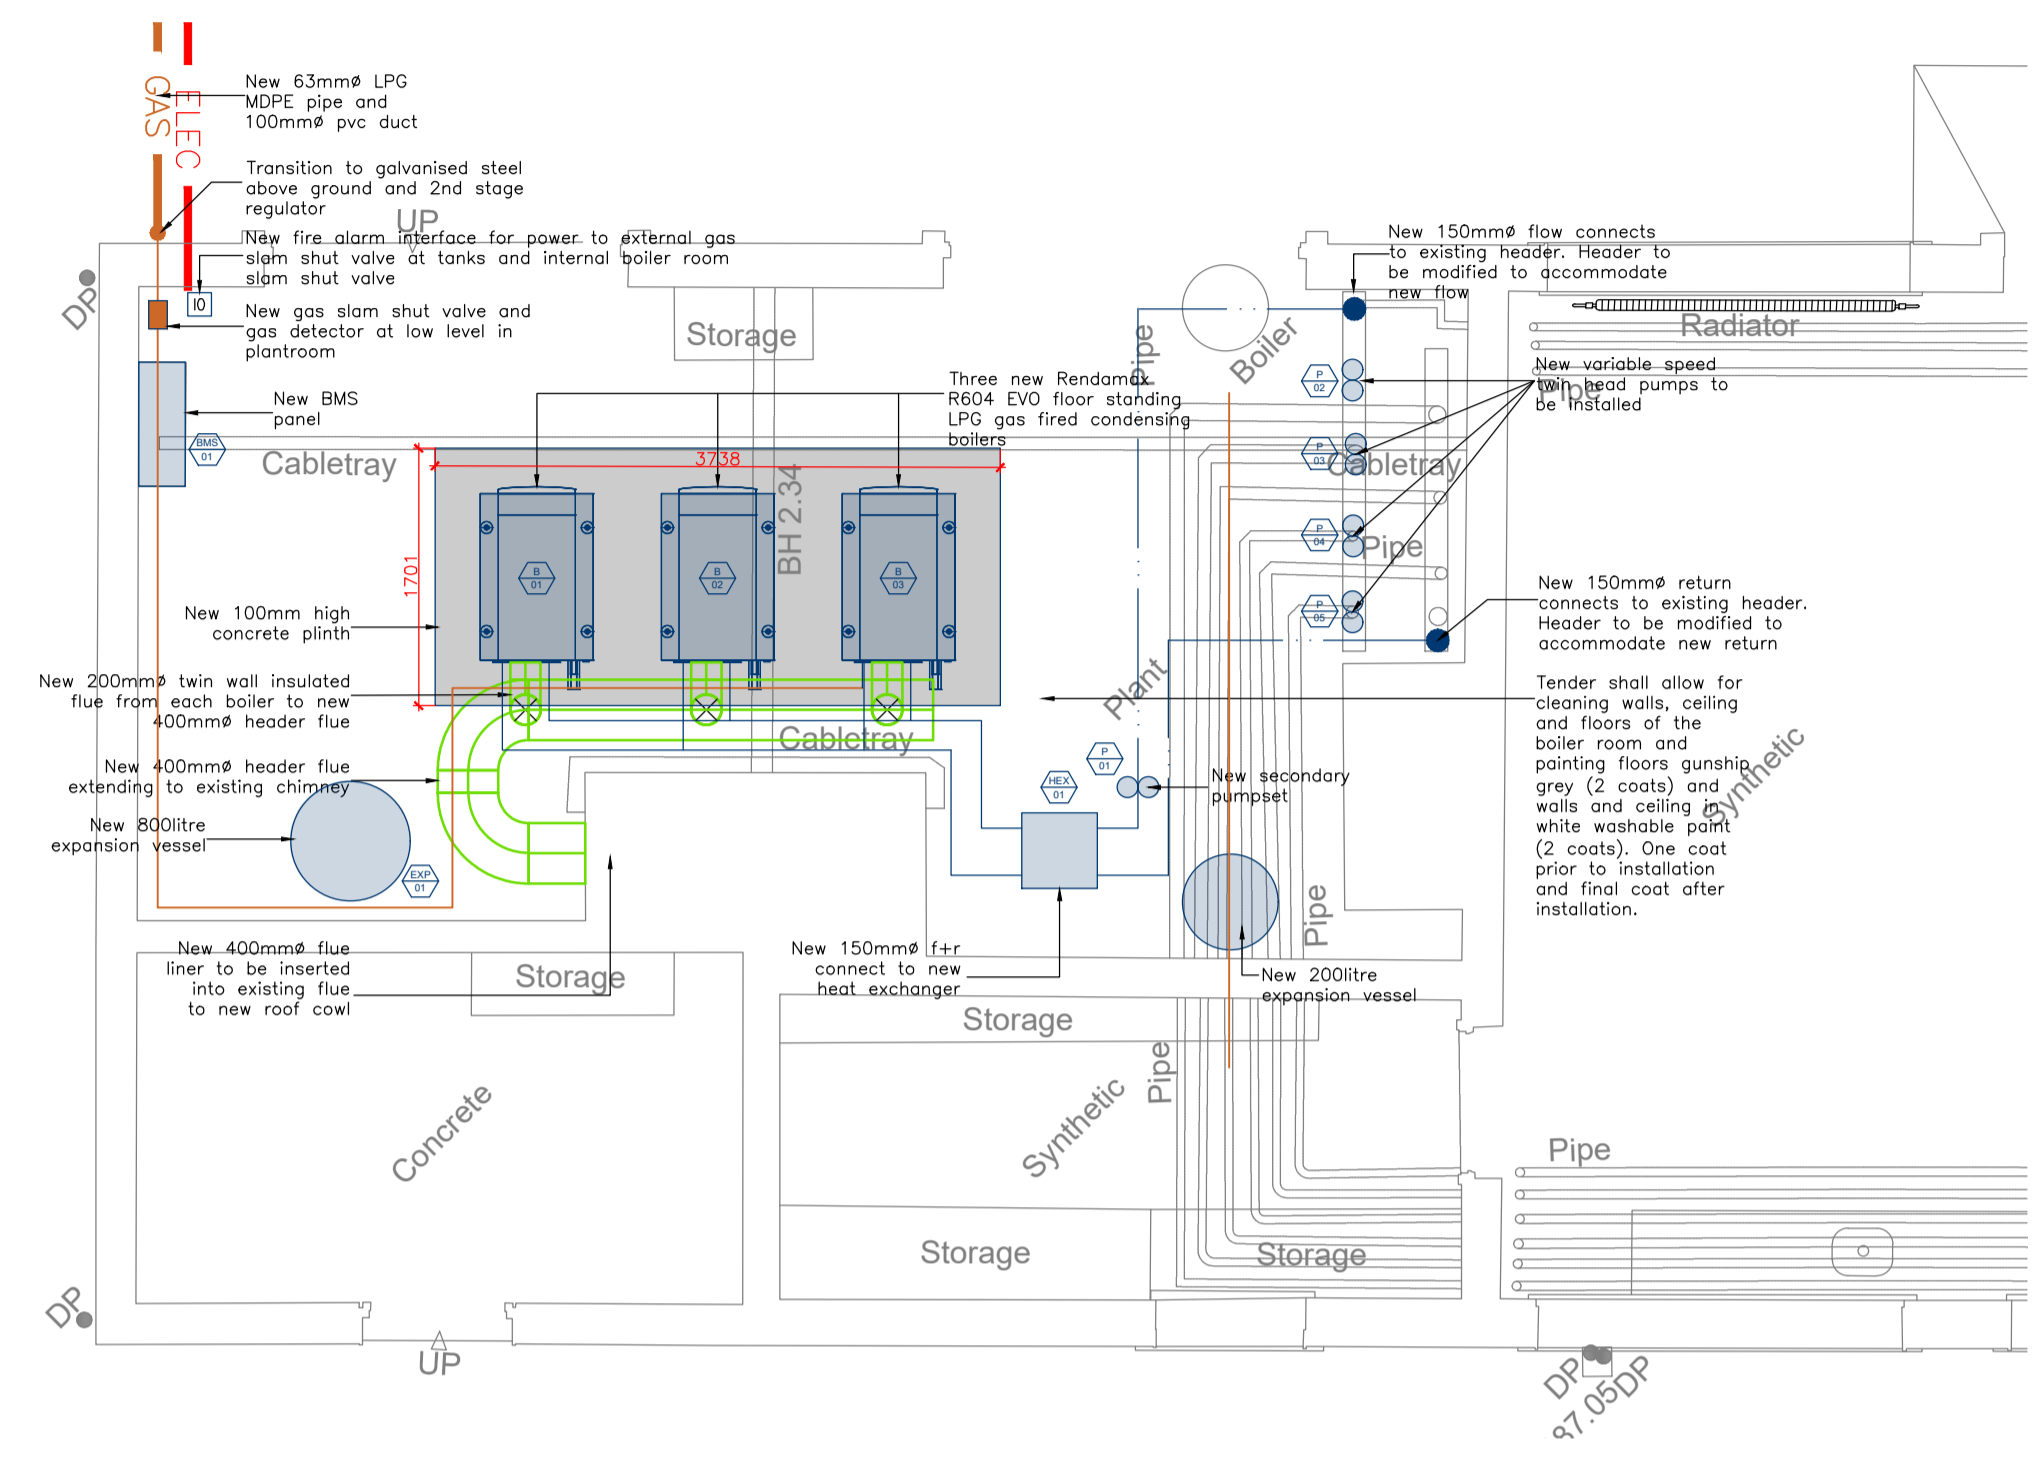

Proposed boiler room layout

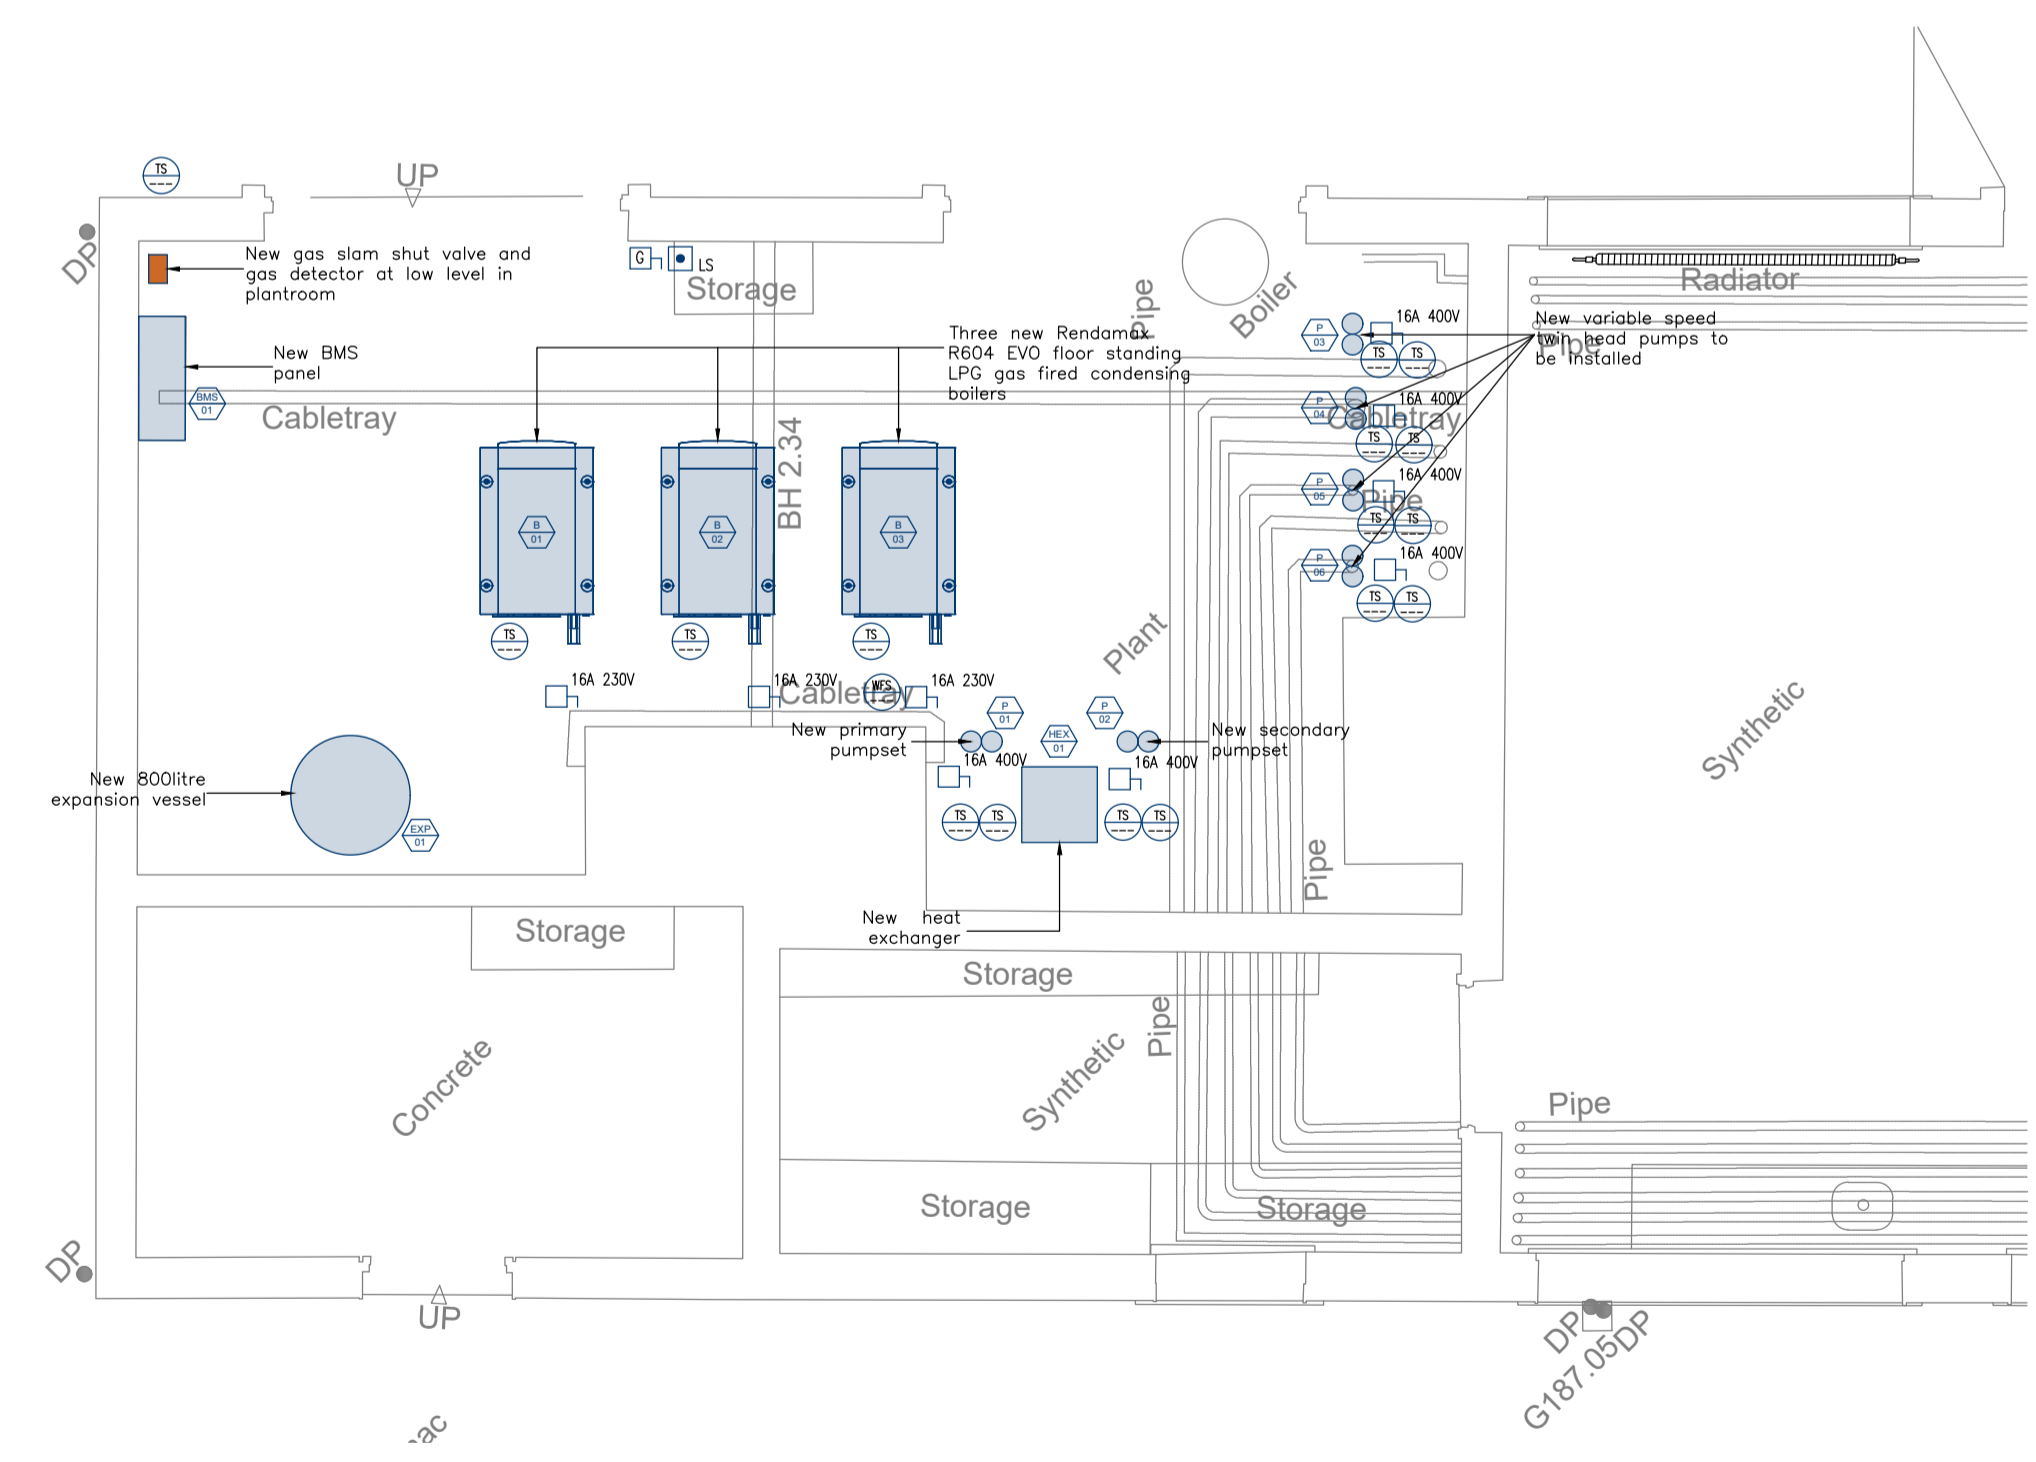

Proposed electrical layout

- Notes:
1. Heating pipework shall be thermally insulated with foil back fibre insulation
  2. All pipework to be adequately supported
  3. All pipework to be labelled
  4. All pipework to be mild steel



TENDER



RONAN MEALLY CONSULTING ENGINEERS LTD  
 1 City Wall, James Street  
 Kilkenny  
 Ireland  
 R95 XF97  
 Telephone: 056 7795428  
 Email: info@rmce.ie

2 Ardliath  
 Rosstownagh  
 Co Donegal  
 F94 FC89  
 Telephone: 087 7460260  
 Email: info@rmce.ie

PROJECT  
**COLAISTE EOIN  
 HACKETSTOWN  
 CO CARLOW**

DRAWING TITLE  
**MECHANICAL SERVICES  
 BOILER ROOM LAYOUT**

NO	DATE	BY	CHECKED	SCALE
1	JUNE 2026	RM	RM	1:50

PROJECT	ORIGINATOR	ZONE	LEVEL	TYPE	DISC	NUMBER	REVISION
26K13	RMCE	X1	ZZ	DR	M	100	T1