


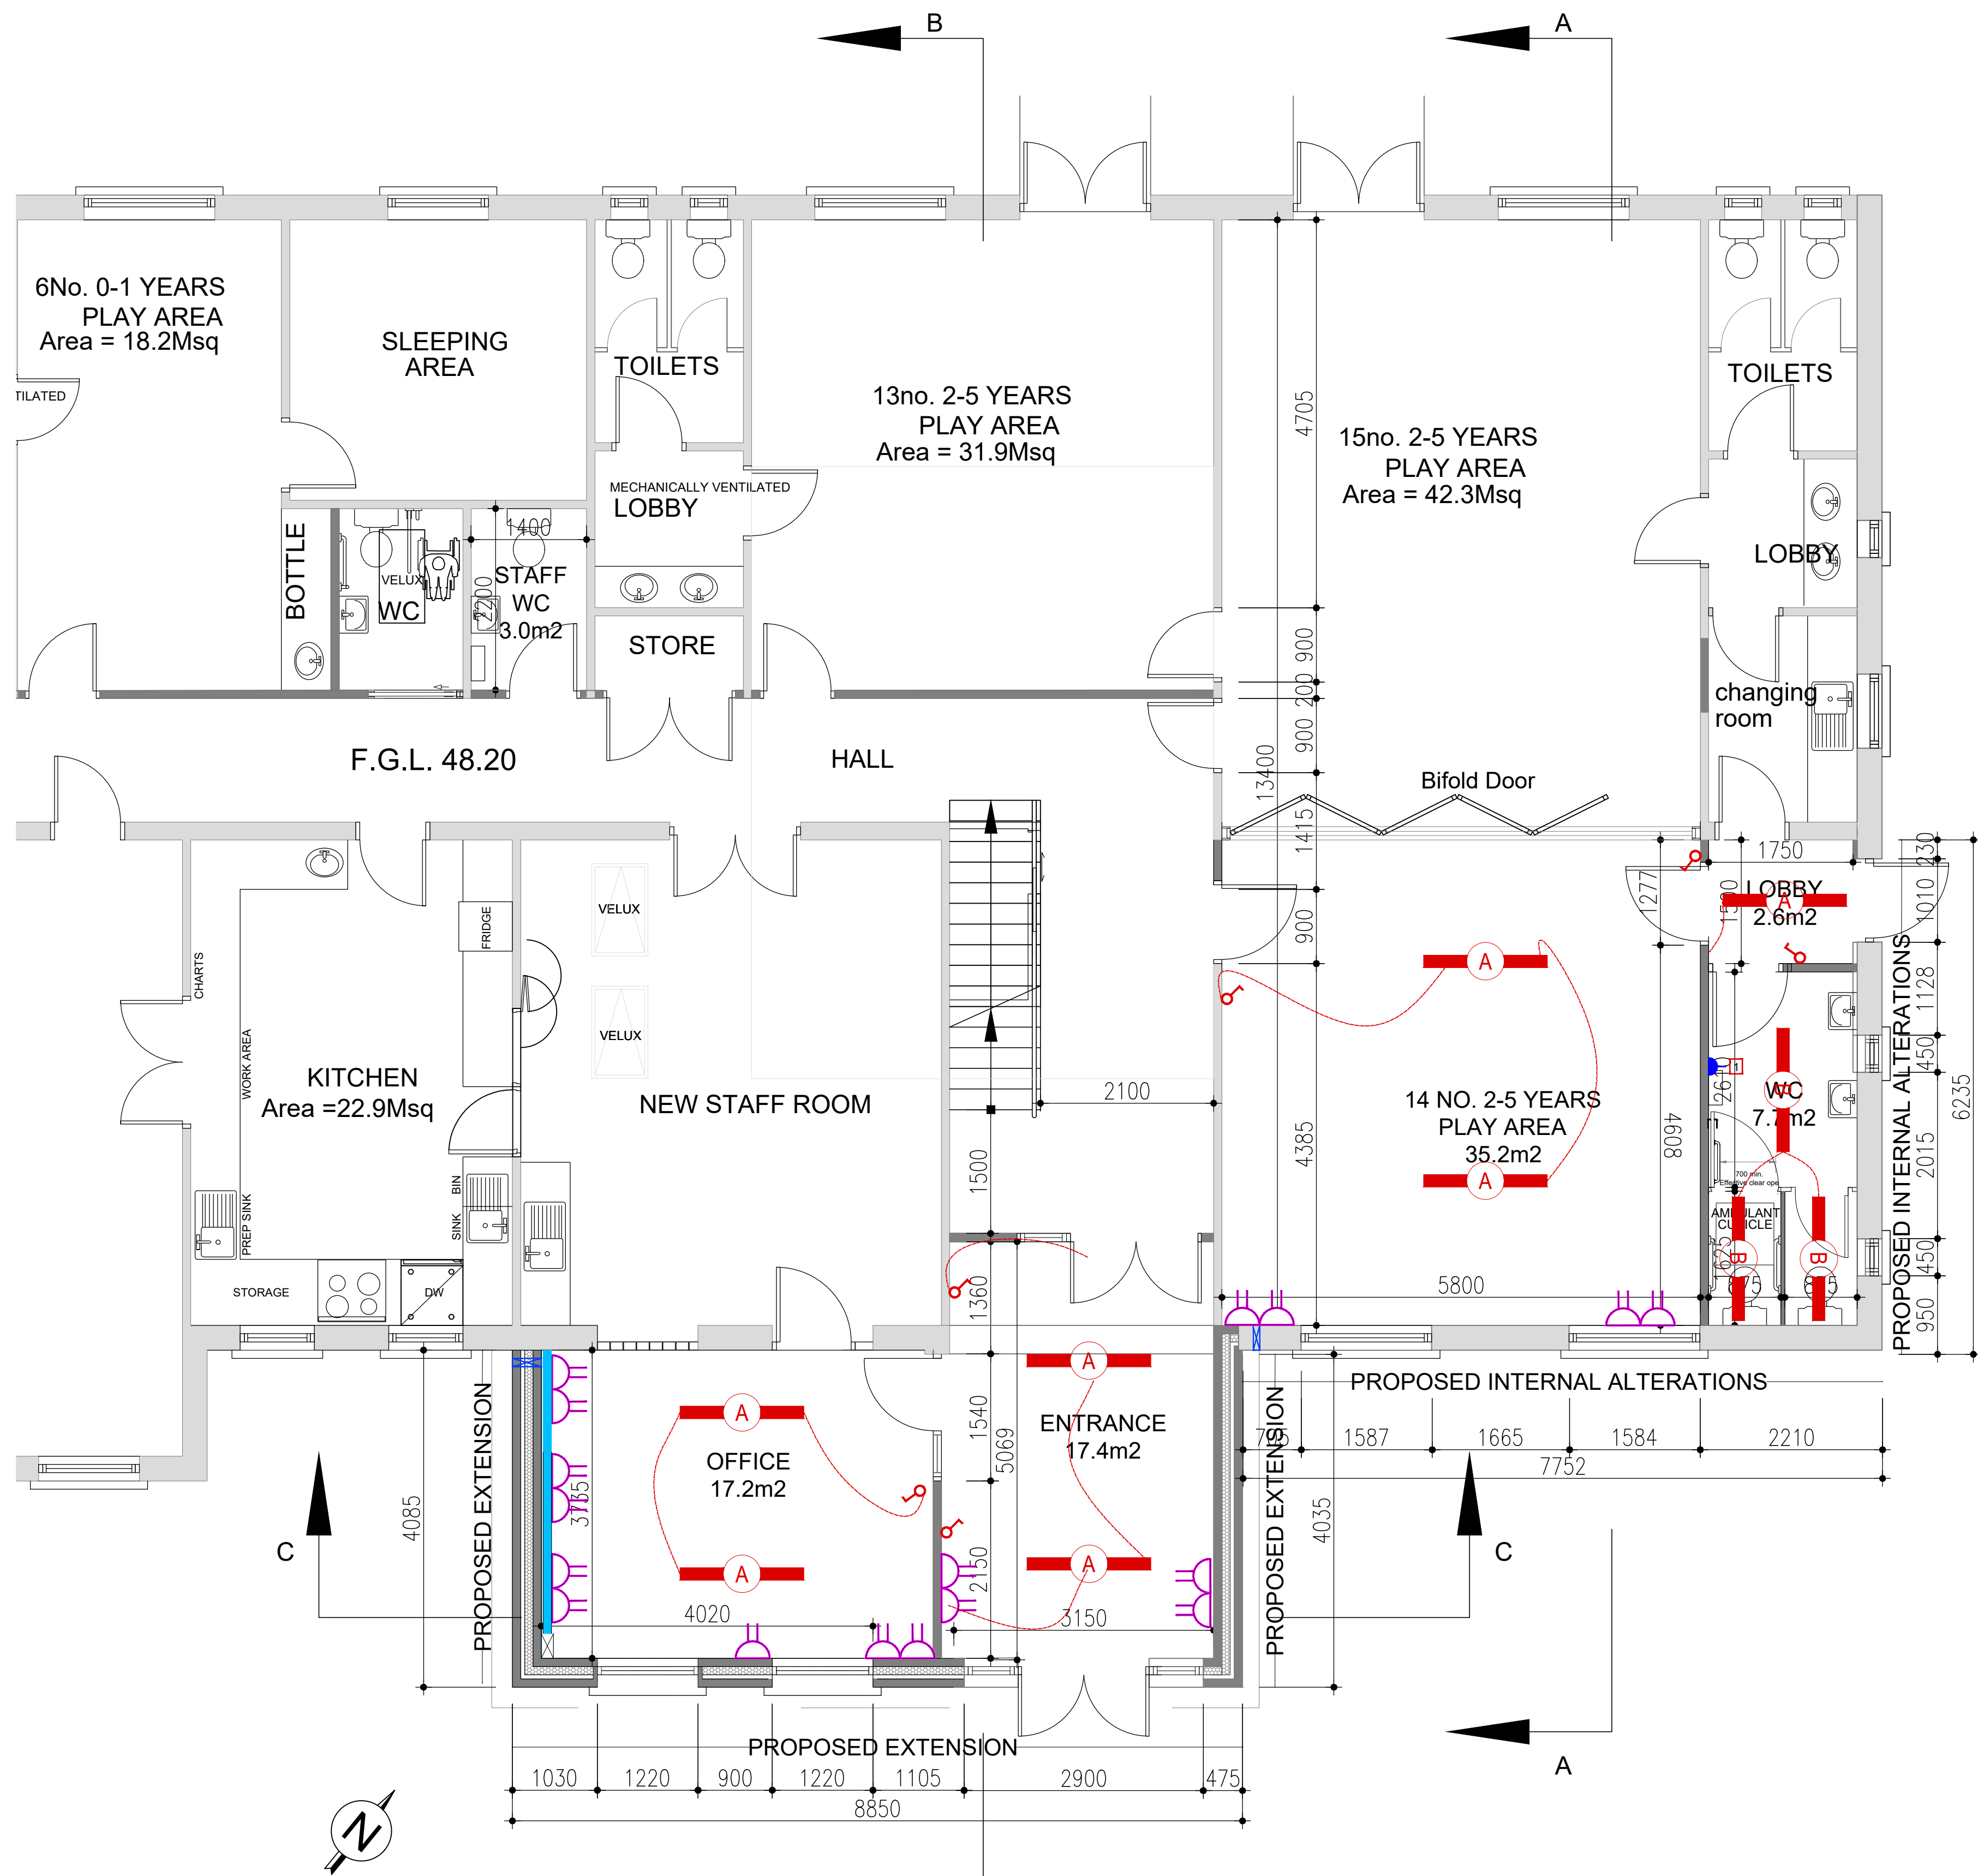

LEGEND

GENERAL LIGHTING

-  1 X 38W SURFACE MOUNTED LED LINEAR WITH OPAL DIFFUSER AS ANSELL OXFORD (AOXLED2X4) OR E/A. AUTOMATIC DIMMING - VERSION IN LONG SHAPE, ADJUSTABLE LUMINOUS COLOUR.
-  1 X 23W SURFACE MOUNTED LED LINEAR WITH OPAL DIFFUSER AS ANSELL OXFORD (AOXLED2X4) OR E/A. AUTOMATIC DIMMING - VERSION IN LONG SHAPE, ADJUSTABLE LUMINOUS COLOUR.
-  CEILING MOUNTED DAYLIGHT/MOVEMENT SENSOR.
-  MOVEMENT SENSOR.
-  LIGHT SWITCH (LOCATED 900MM - 1200MM ABOVE FFL)
-  DIMMABLE LIGHT SWITCH (LOCATED 900MM X 1200MM ABOVE FFL)

POWER & DATA

-  MID DADO RAIL TRUNKING AND DROP
-  TWIN SWITCHED 13 A DOUBLE SOCKET OUTLET
-  TWIN SWITCHED 13 A DOUBLE SOCKET OUTLET
-  1 UNSWITCHED SPUR FOR HANDRYER.

IMPORTANT NOTE:

SKETCH AND DESIGN STAGE:
All drawings are for discussion purposes only. Drawings are not to be used for any other purpose.

PLANNING STAGE:
All drawings are for planning application purposes only. Drawings are not to be used for any other purpose. Any changes made to these drawings are subject to immediate approval by Brendan Moore Architects. Figured dimensions only to be used from this drawing.

CONSTRUCTION STAGE:
All drawings are for construction purposes only. Drawings are not to be used for any other purpose. Drawings to be checked on site by the contractor prior to commencement of any work. Brendan Moore Architects to be informed of any discrepancies immediately. Figured dimensions only to be used from this drawing.

NOTES:



BRENDAN MOORE ARCHITECTS
38 ST. KIERAN'S STREET, KILKENNY, R95 KN80, IRELAND
PROJECT: Proposed Extension to Urlingford Community Childcare Centre, St. Kierans Place, Urlingford, Co.Kilkenny, E41 T6Y7

CLIENT: Michael Kenny

SCALE: 1/50@A1

DRAWING: Tender

General Lighting, Power & Data Layout

353-87-4120718 brendan@bmarchitects.ie www.bmarchitects.ie

Job No:
24-152

Drwg No:
24-152

T-500

Date:
May.2026

Drawn By: SP

