


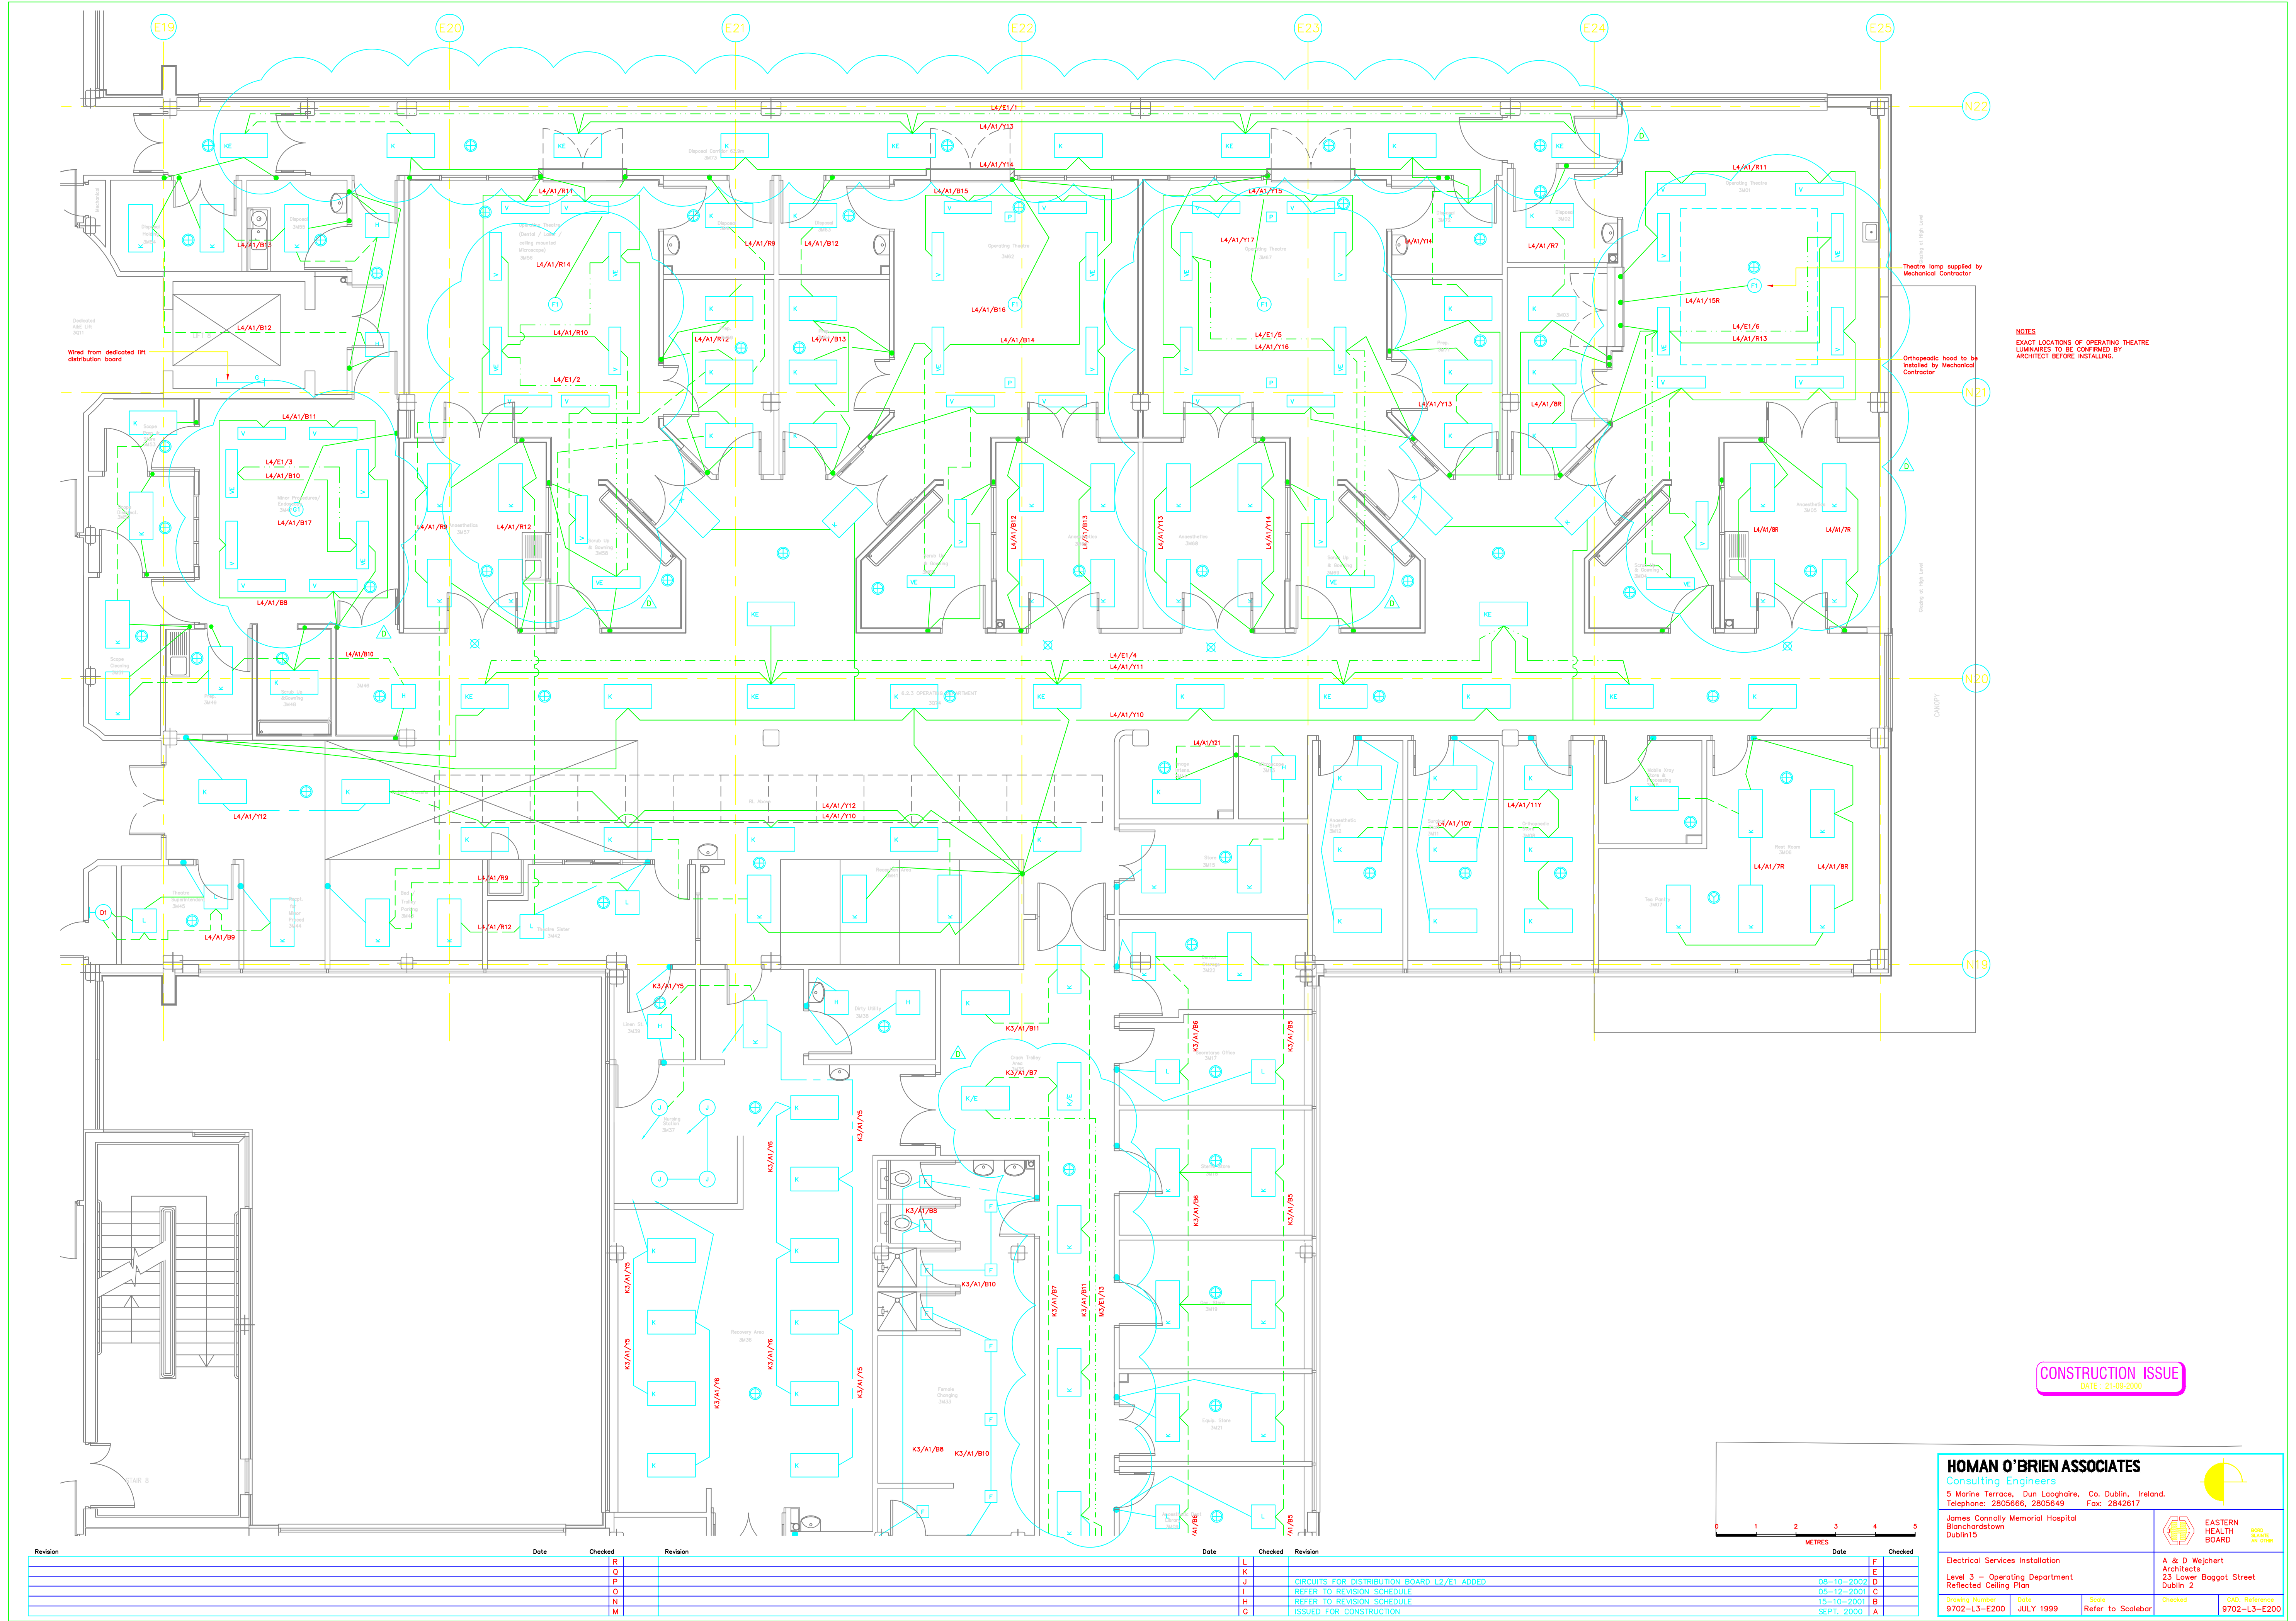

NOTES
EXACT LOCATIONS OF OPERATING THEATRE
LUMINAIRES TO BE CONFIRMED BY
ARCHITECT BEFORE INSTALLING.

CONSTRUCTION ISSUE
DATE: 21-08-2000

HOMAN O'BRIEN ASSOCIATES
Consulting Engineers

5 Marine Terrace, Dun Laoghaire, Co. Dublin, Ireland.
Telephone: 2805666, 2805649 Fax: 2842617

James Connolly Memorial Hospital
Blanchardstown
Dublin 15

**EASTERN
HEALTH
BOARD**

Electrical Services Installation
Level 3 - Operating Department
Reflected Ceiling Plan

A & D Weichert
Architects
23 Lower Baggot Street
Dublin 2

Drawing Number: 9702-L3-E200
Date: JULY 1999

Scale: Refer to Scalebar

Checked: [Signature]
CAD Reference: 9702-L3-E200

Revision	Date	Checked	Revision	Date	Checked
L			L		
K			K		
O			O		
P			P		
O			O		
N			N		
M			M		

Revision	Date	Checked
F		
E		
D		
C		
B		
A		

CIRCUITS FOR DISTRIBUTION BOARD L2/E1 ADDED
REFER TO REVISION SCHEDULE
REFER TO REVISION SCHEDULE
ISSUED FOR CONSTRUCTION

08-10-2002
05-12-2001
15-10-2001
SEPT. 2000