
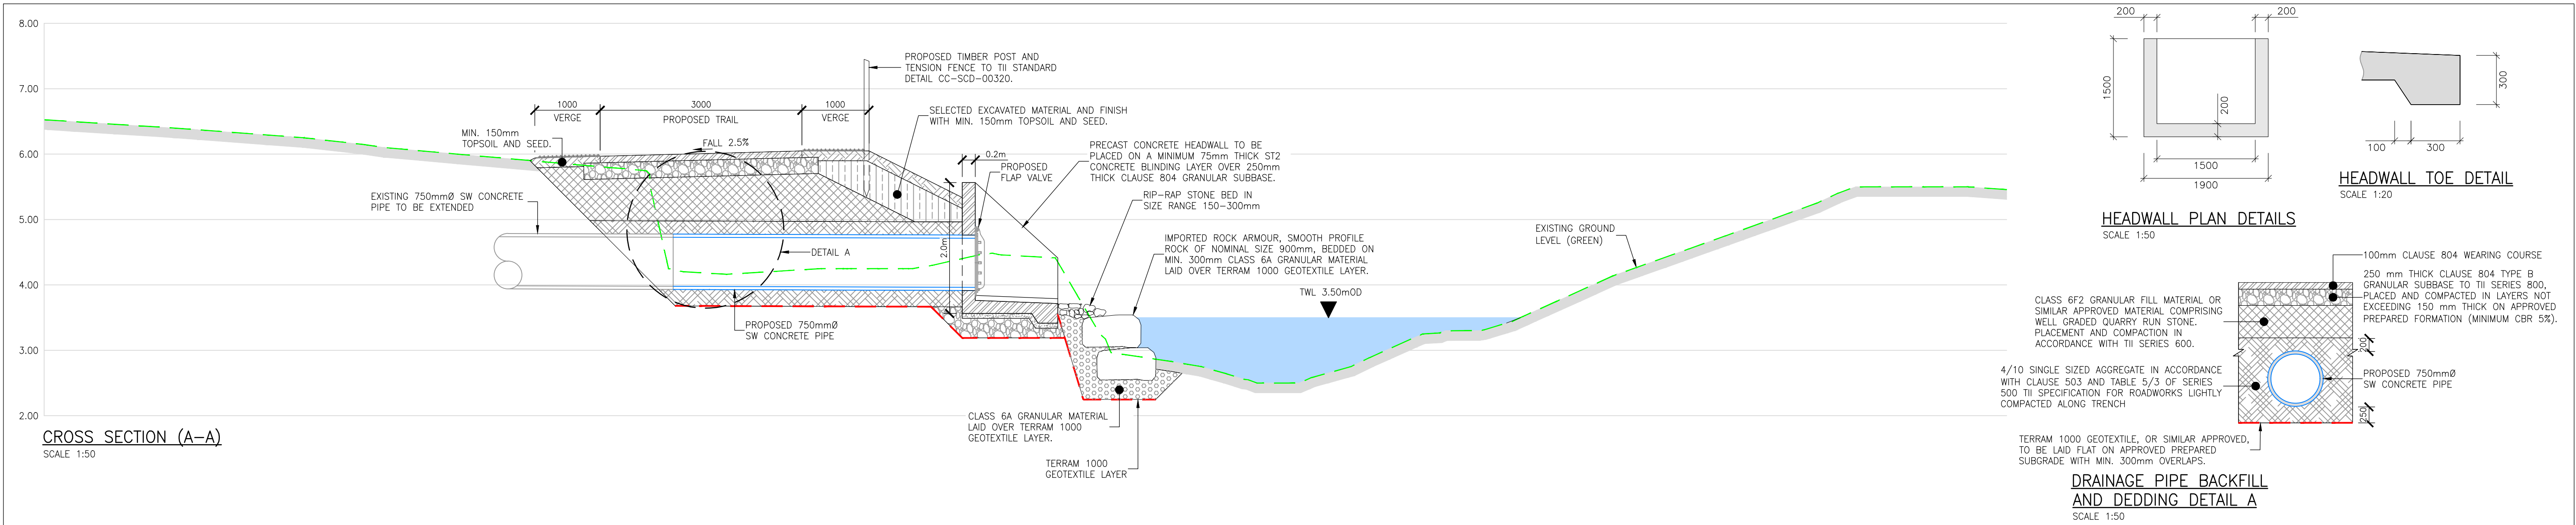


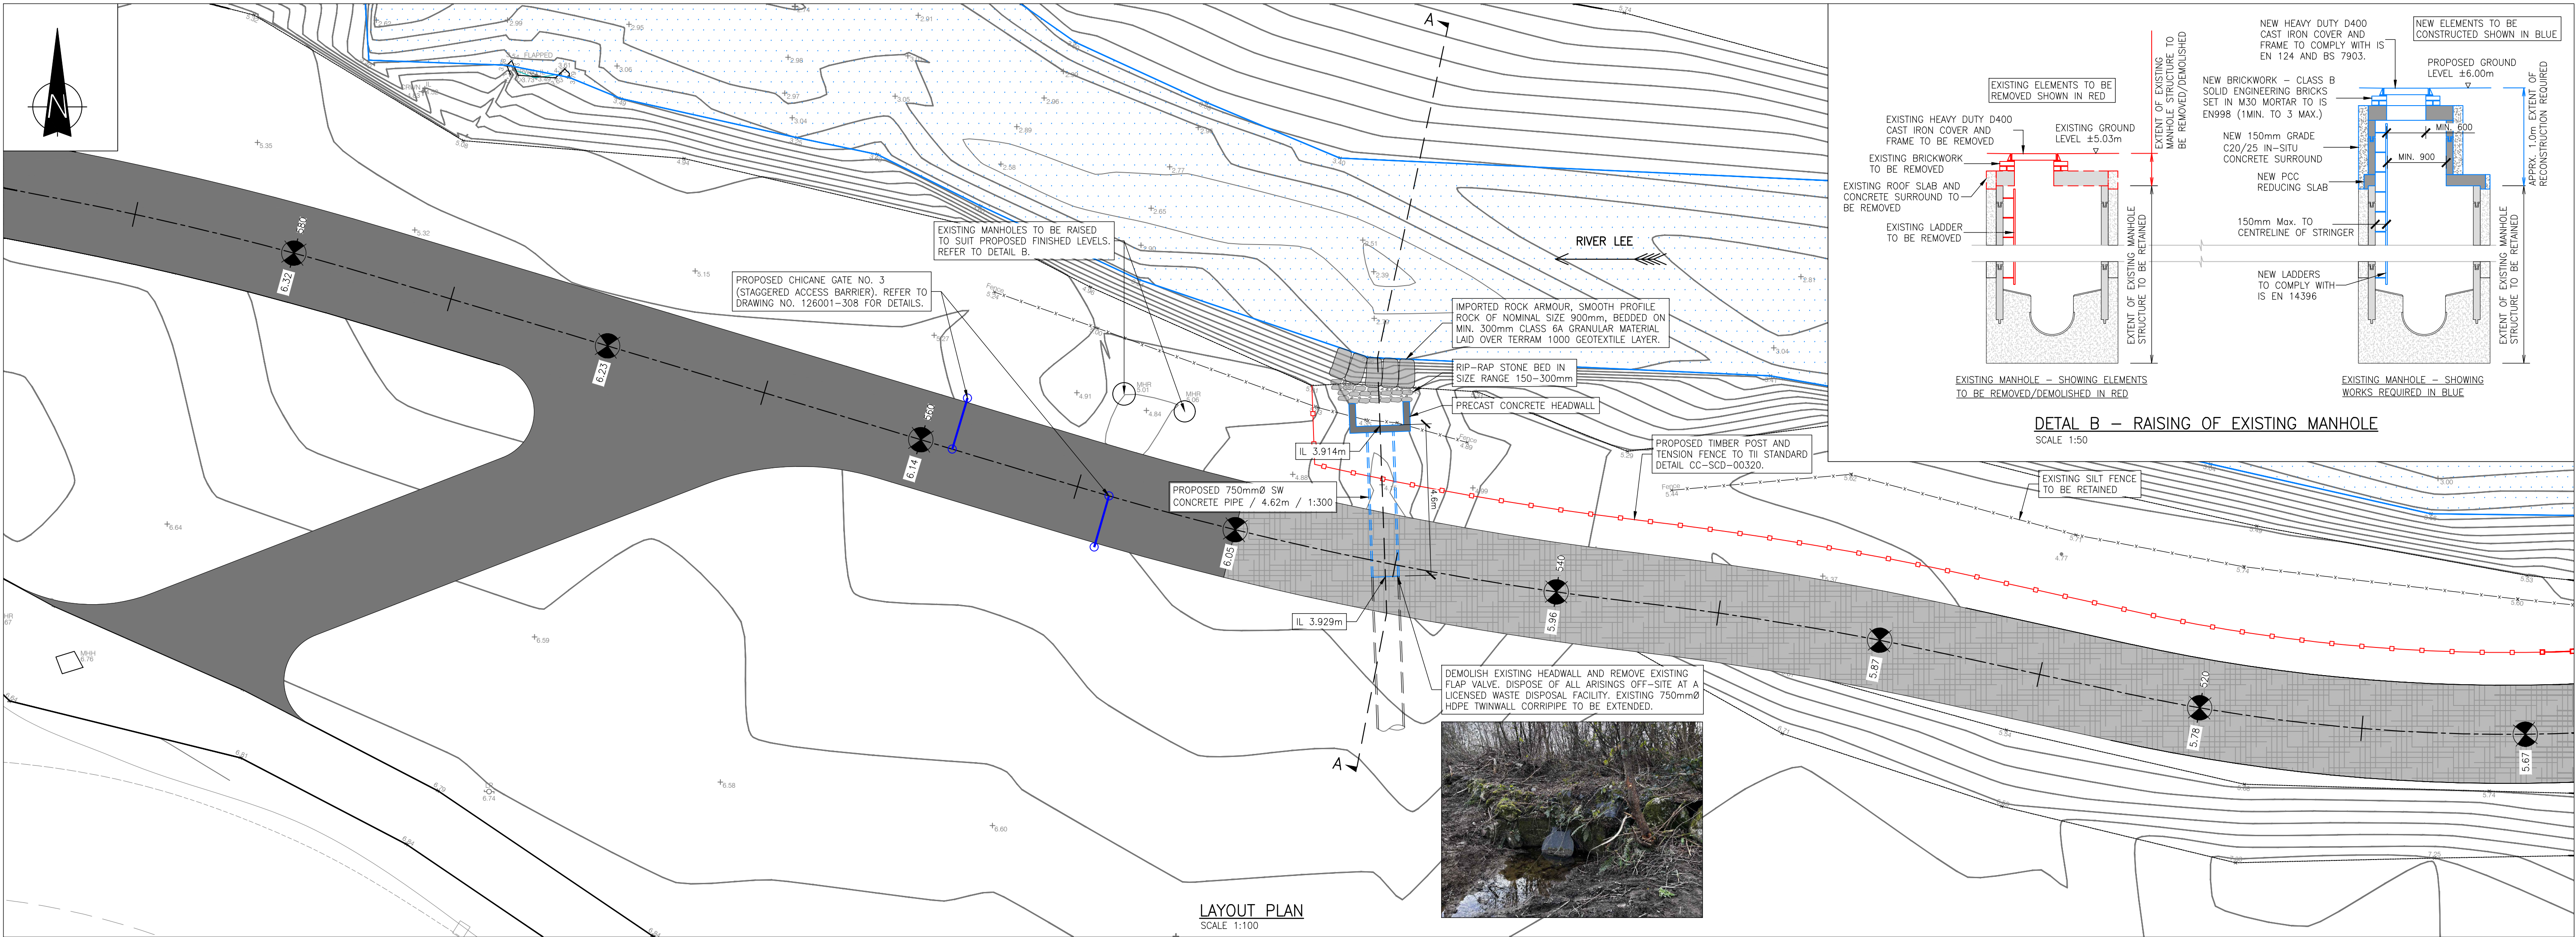

NOTES:

- ALL LEVELS ARE IN METRES AND RELATED TO ORDNANCE MALIN HEAD.
- ALL SETTING OUT CO-ORDINATES ARE IN ITM COORDINATE SYSTEM.
- ALL DIMENSIONS ARE IN MILLIMETRES UNLESS NOTED OTHERWISE.
- ALL WORKS TO BE CARRIED OUT IN ACCORDANCE WITH INLAND FISHERIES IRELAND AND EPA GUIDELINES FOR PROTECTION OF WATERCOURSES DURING CONSTRUCTION.
- SITE COMPOUND, SPOIL HEAPS, AND FUEL STORAGE MUST BE LOCATED A MINIMUM OF 10m AWAY FROM ANY STREAM OR DRAINAGE DITCH.
- CONTRACTOR TO INSPECT AND MAINTAIN SILT FENCES WEEKLY AND AFTER HEAVY RAINFALL. REPAIR OR REPLACE AS REQUIRED.
- NO DISCHARGE OF SILTY WATER OR OTHER POLLUTANTS TO BE PERMITTED INTO THE WATERCOURSE.
- IN AREAS IDENTIFIED TO CONTAIN INVASIVE SPECIES (HIMALAYAN BALSAM OR ANY OTHER SPECIES) WITHIN THE WORKS, THE CONTRACTOR SHALL NOTIFY THE EMPLOYER AND CARRY OUT ANY AGREED DISPOSAL WORKS IN ACCORDANCE WITH BEST PRACTICE GUIDELINES ISSUED BY THE NATIONAL PARKS & WILDLIFE SERVICE (NPWS) AND INLAND FISHERIES IRELAND (IFI).
- IN THE EVENT THAT VEGETATION OR EARTHWORKS MATERIAL ARE FOUND TO CONTAIN INVASIVE PLANT SPECIES, SUCH MATERIAL SHALL BE DISPOSED OF ON SITE AT A LOCATION AGREED WITH THE EMPLOYER.

LEGEND:

PROPOSED LEVEL OF AMENITY TRAIL SURFACE, DENOTED THUS....

PROPOSED TIMBER POST AND TENSION MESH FENCE TO TII STANDARD DETAIL CC-SCD-00320. DENOTED THUS....

PROPOSED ASPHALT SURFACE TO ROAD/AMENITY TRAIL REFER TO DRAWING NO. 126001-305-307 FOR CONSTRUCTION DETAILS. DENOTED THUS....

PROPOSED GRAVEL SURFACE COURSE TO ROAD/AMENITY TRAIL. REFER TO DRAWING NO. 126001-305-307 FOR CONSTRUCTION DETAILS. DENOTED THUS....

EXISTING WATER EDGE/RIVER/STREAM, DENOTED THUS....

EXISTING FENCE, DENOTED THUS....

Issue	Date	Revisions	Drawn	Checked	Approved
T1	22.06.26	ISSUED FOR TENDER	SL	CS	CS

Comhairle Contae Chiarraí
Kerry County Council

MRG
consulting engineers

No.4 Day Place, Tralee, County Kerry.
T : (066)7123130 Fax : (066)7123364 E-Mail : info@mrng.ie
also: Kilaullen House, Dublin Pike, Cork

MRG Consulting Engineers Limited **Civil Structural Architectural Environmental**

Project	BALLYSEEDY WOOD AMENITY TRAIL PHASE: 3	
Drawing	SURFACE WATER DRAINAGE LAYOUT, CROSS SECTION AND DETAILS	
Drawn	S LIWANI	Project No.
Date	22.06.2026	126001
Scale	AS SHOWN @ A1	Drawing No.
		126001-502