
 


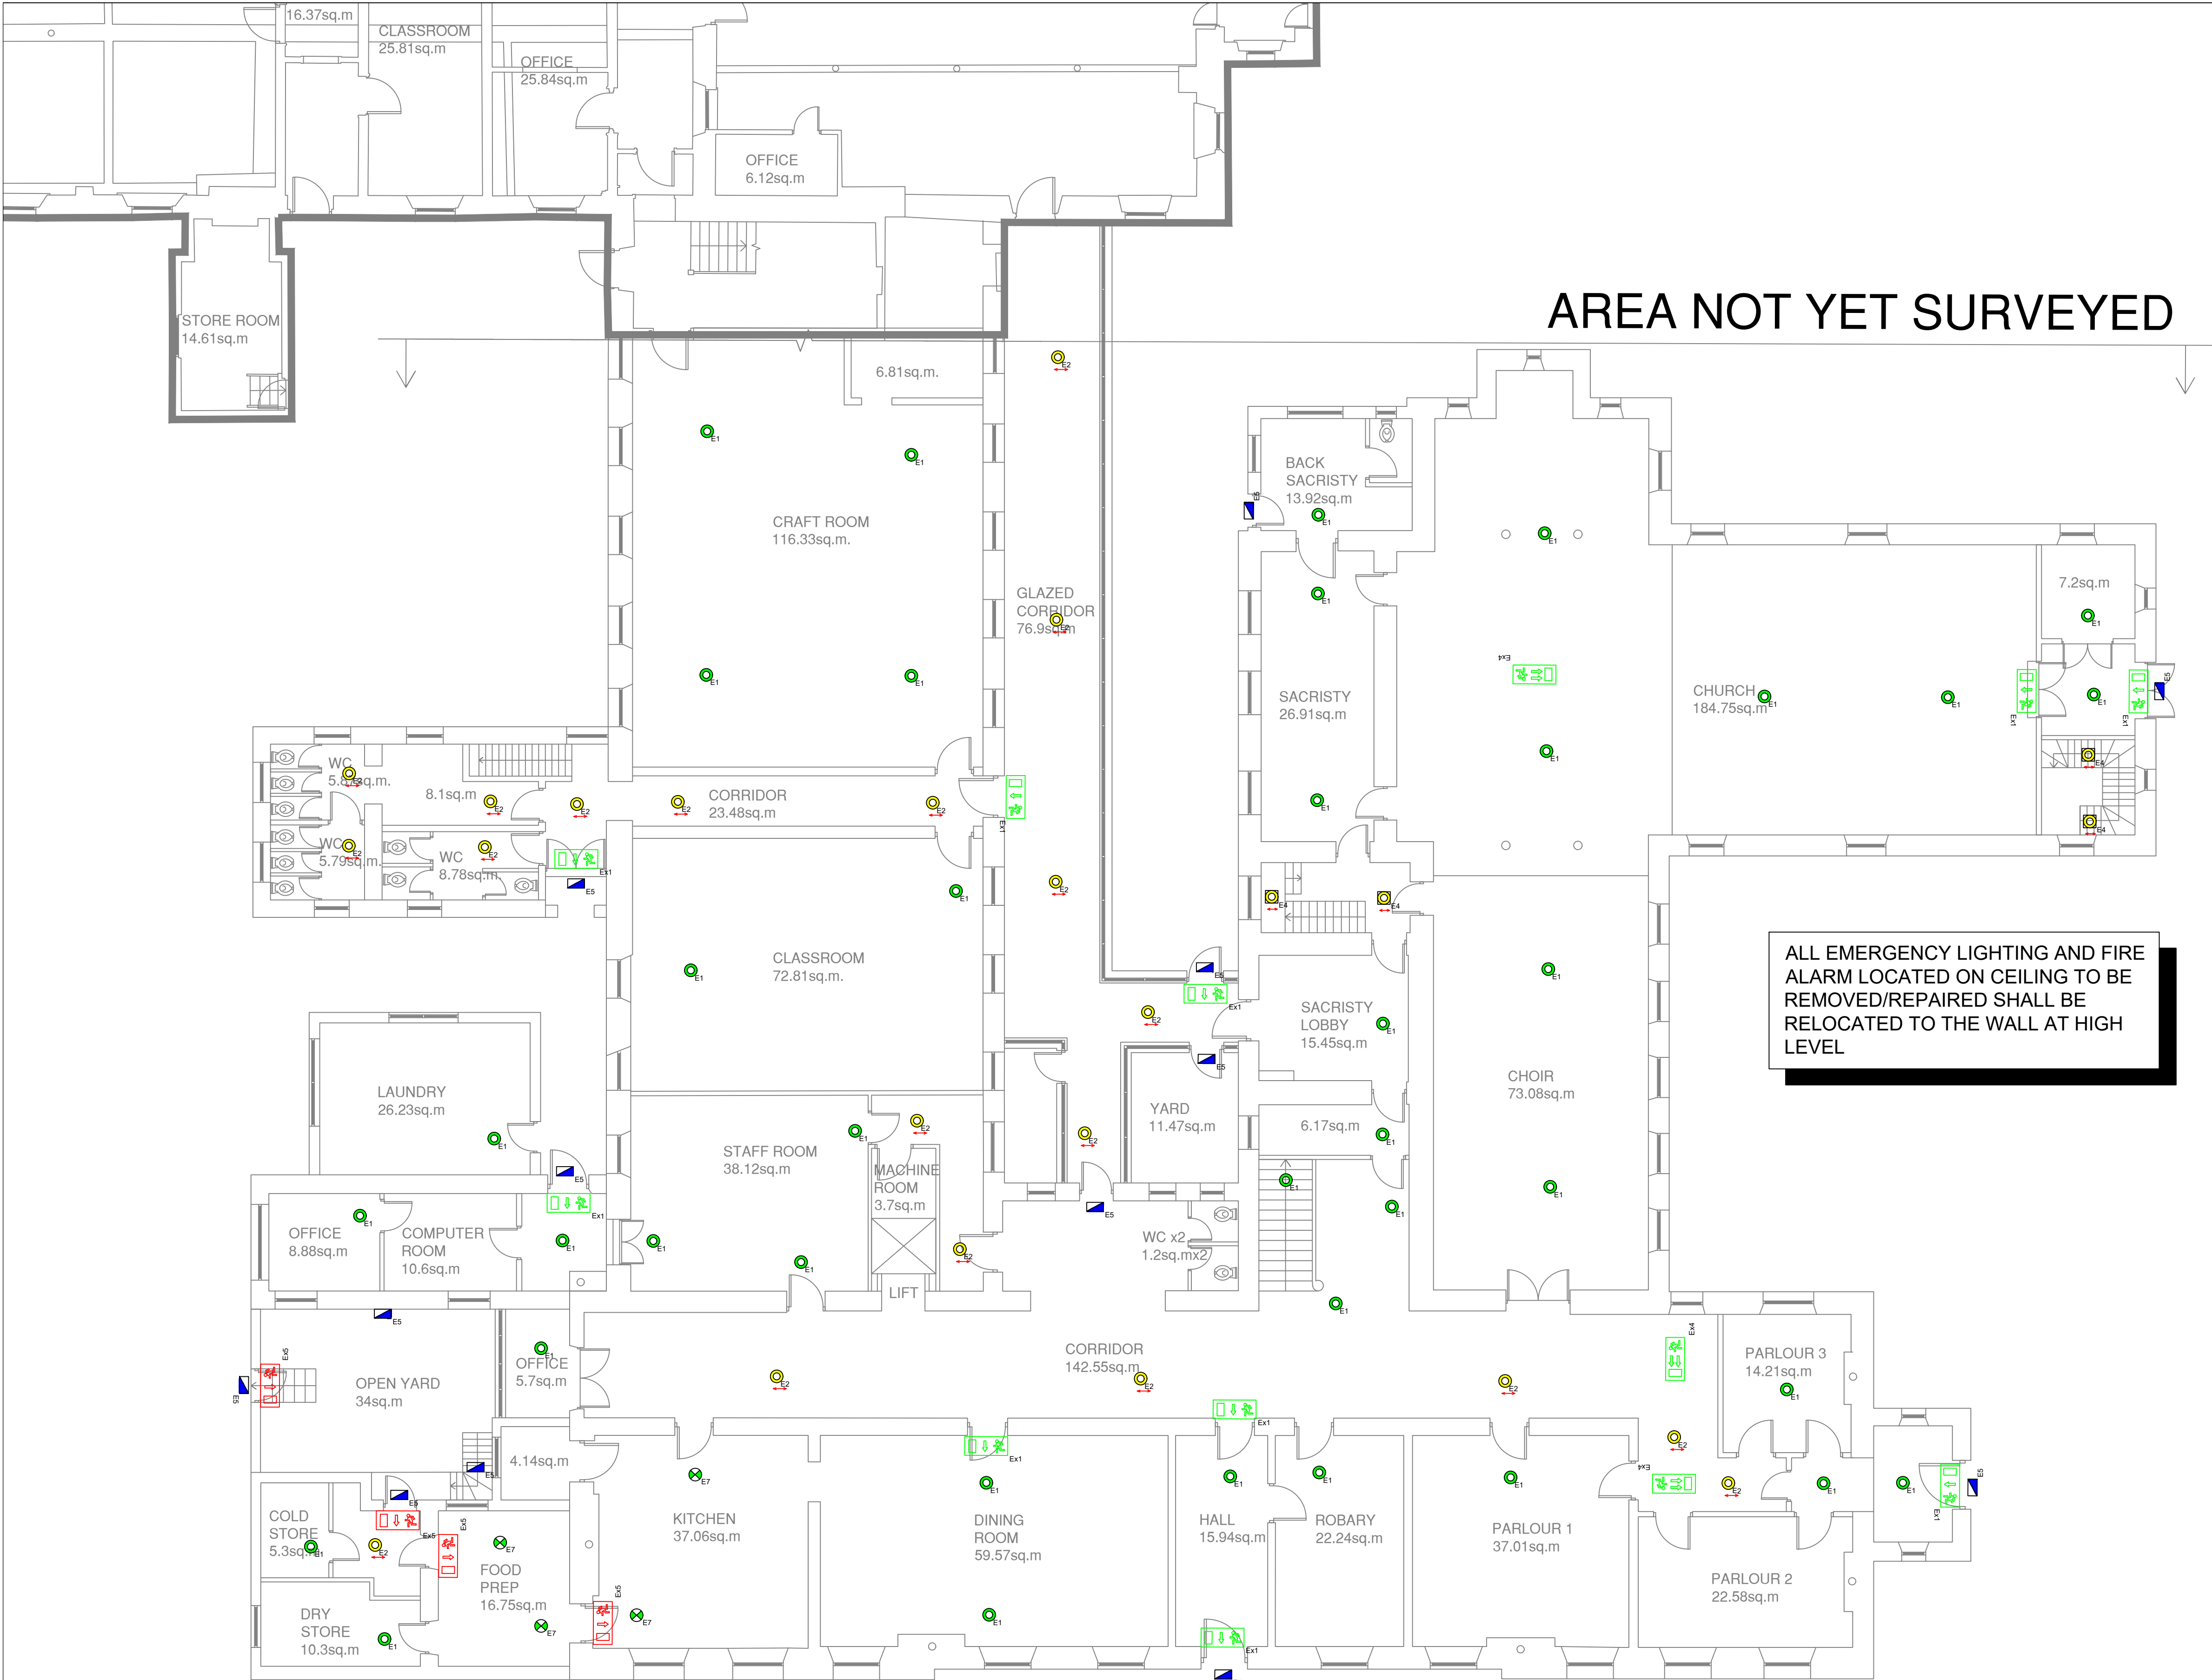

THIS DRAWING IS THE PROPERTY OF DELAP & WALLER AND MAY ONLY BE USED WITH THEIR WRITTEN APPROVAL.  
DO NOT SCALE FROM THIS DRAWING.  
**GENERAL NOTES.**  
THIS DRAWING TO BE READ IN CONJUNCTION WITH ALL OTHER RELEVANT DRAWINGS AND SPECIFICATIONS  
ALL DIMENSIONS ARE IN MILLIMETRES UNLESS OTHERWISE STATED.  
THIS DRAWING IS NOT AN INSTALLATION DRAWING THE CONTRACTOR SHALL BE RESPONSIBLE FOR THE PRODUCTION OF FABRICATION AND INSTALLATION DRAWINGS. SHALL BE FAMILIAR WITH OTHER WORKS PACKAGES WHICH DIRECTLY INTERFERE WITH HIS PACKAGE AND COORDINATE WITH THE FABRICATION AND INSTALLATION DRAWINGS ACCORDINGLY.  
THE CONTRACTOR SHALL BE RESPONSIBLE FOR THE DESIGN, SUPPLY AND INSTALLATION OF SUPPORTS, BRACKETING SYSTEMS, AND SECONDARY STEELWORK SUPPORTS REQUIRED FOR THIS WORKS PACKAGE, UNLESS OTHERWISE STATED.  
SHOULD ANY DISCREPANCIES BE APPARENT IN THIS DRAWING, THE ENGINEER SHALL BE MADE AWARE OF THIS FOR FURTHER ACTION.

| Type | Product                                                  | Block Symbol                                                                            |
|------|----------------------------------------------------------|-----------------------------------------------------------------------------------------|
| E1   | Optilens Recessed Open Plan (OPNM3/LED/OP)               |  E1  |
| E2   | Optilens Recessed Escape Route (OLNM3/LED/ES)            |  E2  |
| E3   | Optilens Open Plan Surface Mount (OLNM3/LED/3W/OP/SM)    |  E3  |
| E4   | Optilens Escape Route Surface Mount (OLNM3/LED/3W/ES/SM) |  E4  |
| E5   | Weatherproof B/Head IP65 Non Maintained (WPNM3/LED/3W)   |  E5  |
| E6   | Optic LED Open Plan Surface Mounted (OPNM3/LED/OP/SM)    |  E6  |
| E7   | Optic LED Open Plan (OPNM3/LED/OP)                       |  E7  |
| Ex1  | FUSION EXIT LIGHT - DOWN                                 |  Ex1 |
| Ex2  | FUSION EXIT LIGHT - LEFT                                 |  Ex2 |
| Ex3  | FUSION EXIT LIGHT - RIGHT                                |  Ex3 |
| Ex4  | FUSION EXIT LIGHT DOUBLE SIDED                           |  Ex4 |
| Ex5  | VISOR EXIT IP65 - DOWN                                   |  Ex5 |

|          |            |              |     |      |
|----------|------------|--------------|-----|------|
| T1       | 02-04-2026 | TENDER ISSUE | CL  | PB   |
| T        | 08-09-2022 | TENDER ISSUE | CD  | PB   |
| Revision | Date       | Details      | Drn | Chkd |



**DELAP & WALLER**  
+353 1 535 5900  
dublin@delapandwaller.com  
www.delapandwaller.com

☐ Antrim

☒ Dublin

☐ London

ARCHITECT  
**KOBW**

PROJECT  
**SACRED HEART SECONDARY SCHOOL, CONVENT ROAD, CLONAKILTY, CO. CORK**

TITLE  
**EMERGENCY LIGHTING LAYOUT BUILDINGS 1-3**

|          |            |              |
|----------|------------|--------------|
| DESIGNED | DATE       | FLOOR        |
| PB       | SEPT. 2022 | GROUND FLOOR |
| DRAWN    | SCALE      |              |
| CD       | 1:100 @ A1 |              |

|         |             |          |    |
|---------|-------------|----------|----|
| DRG No. | 22004-E-100 | DRG REV. | T1 |
|---------|-------------|----------|----|

DRG STATUS  
**TENDER ISSUE**