
 
 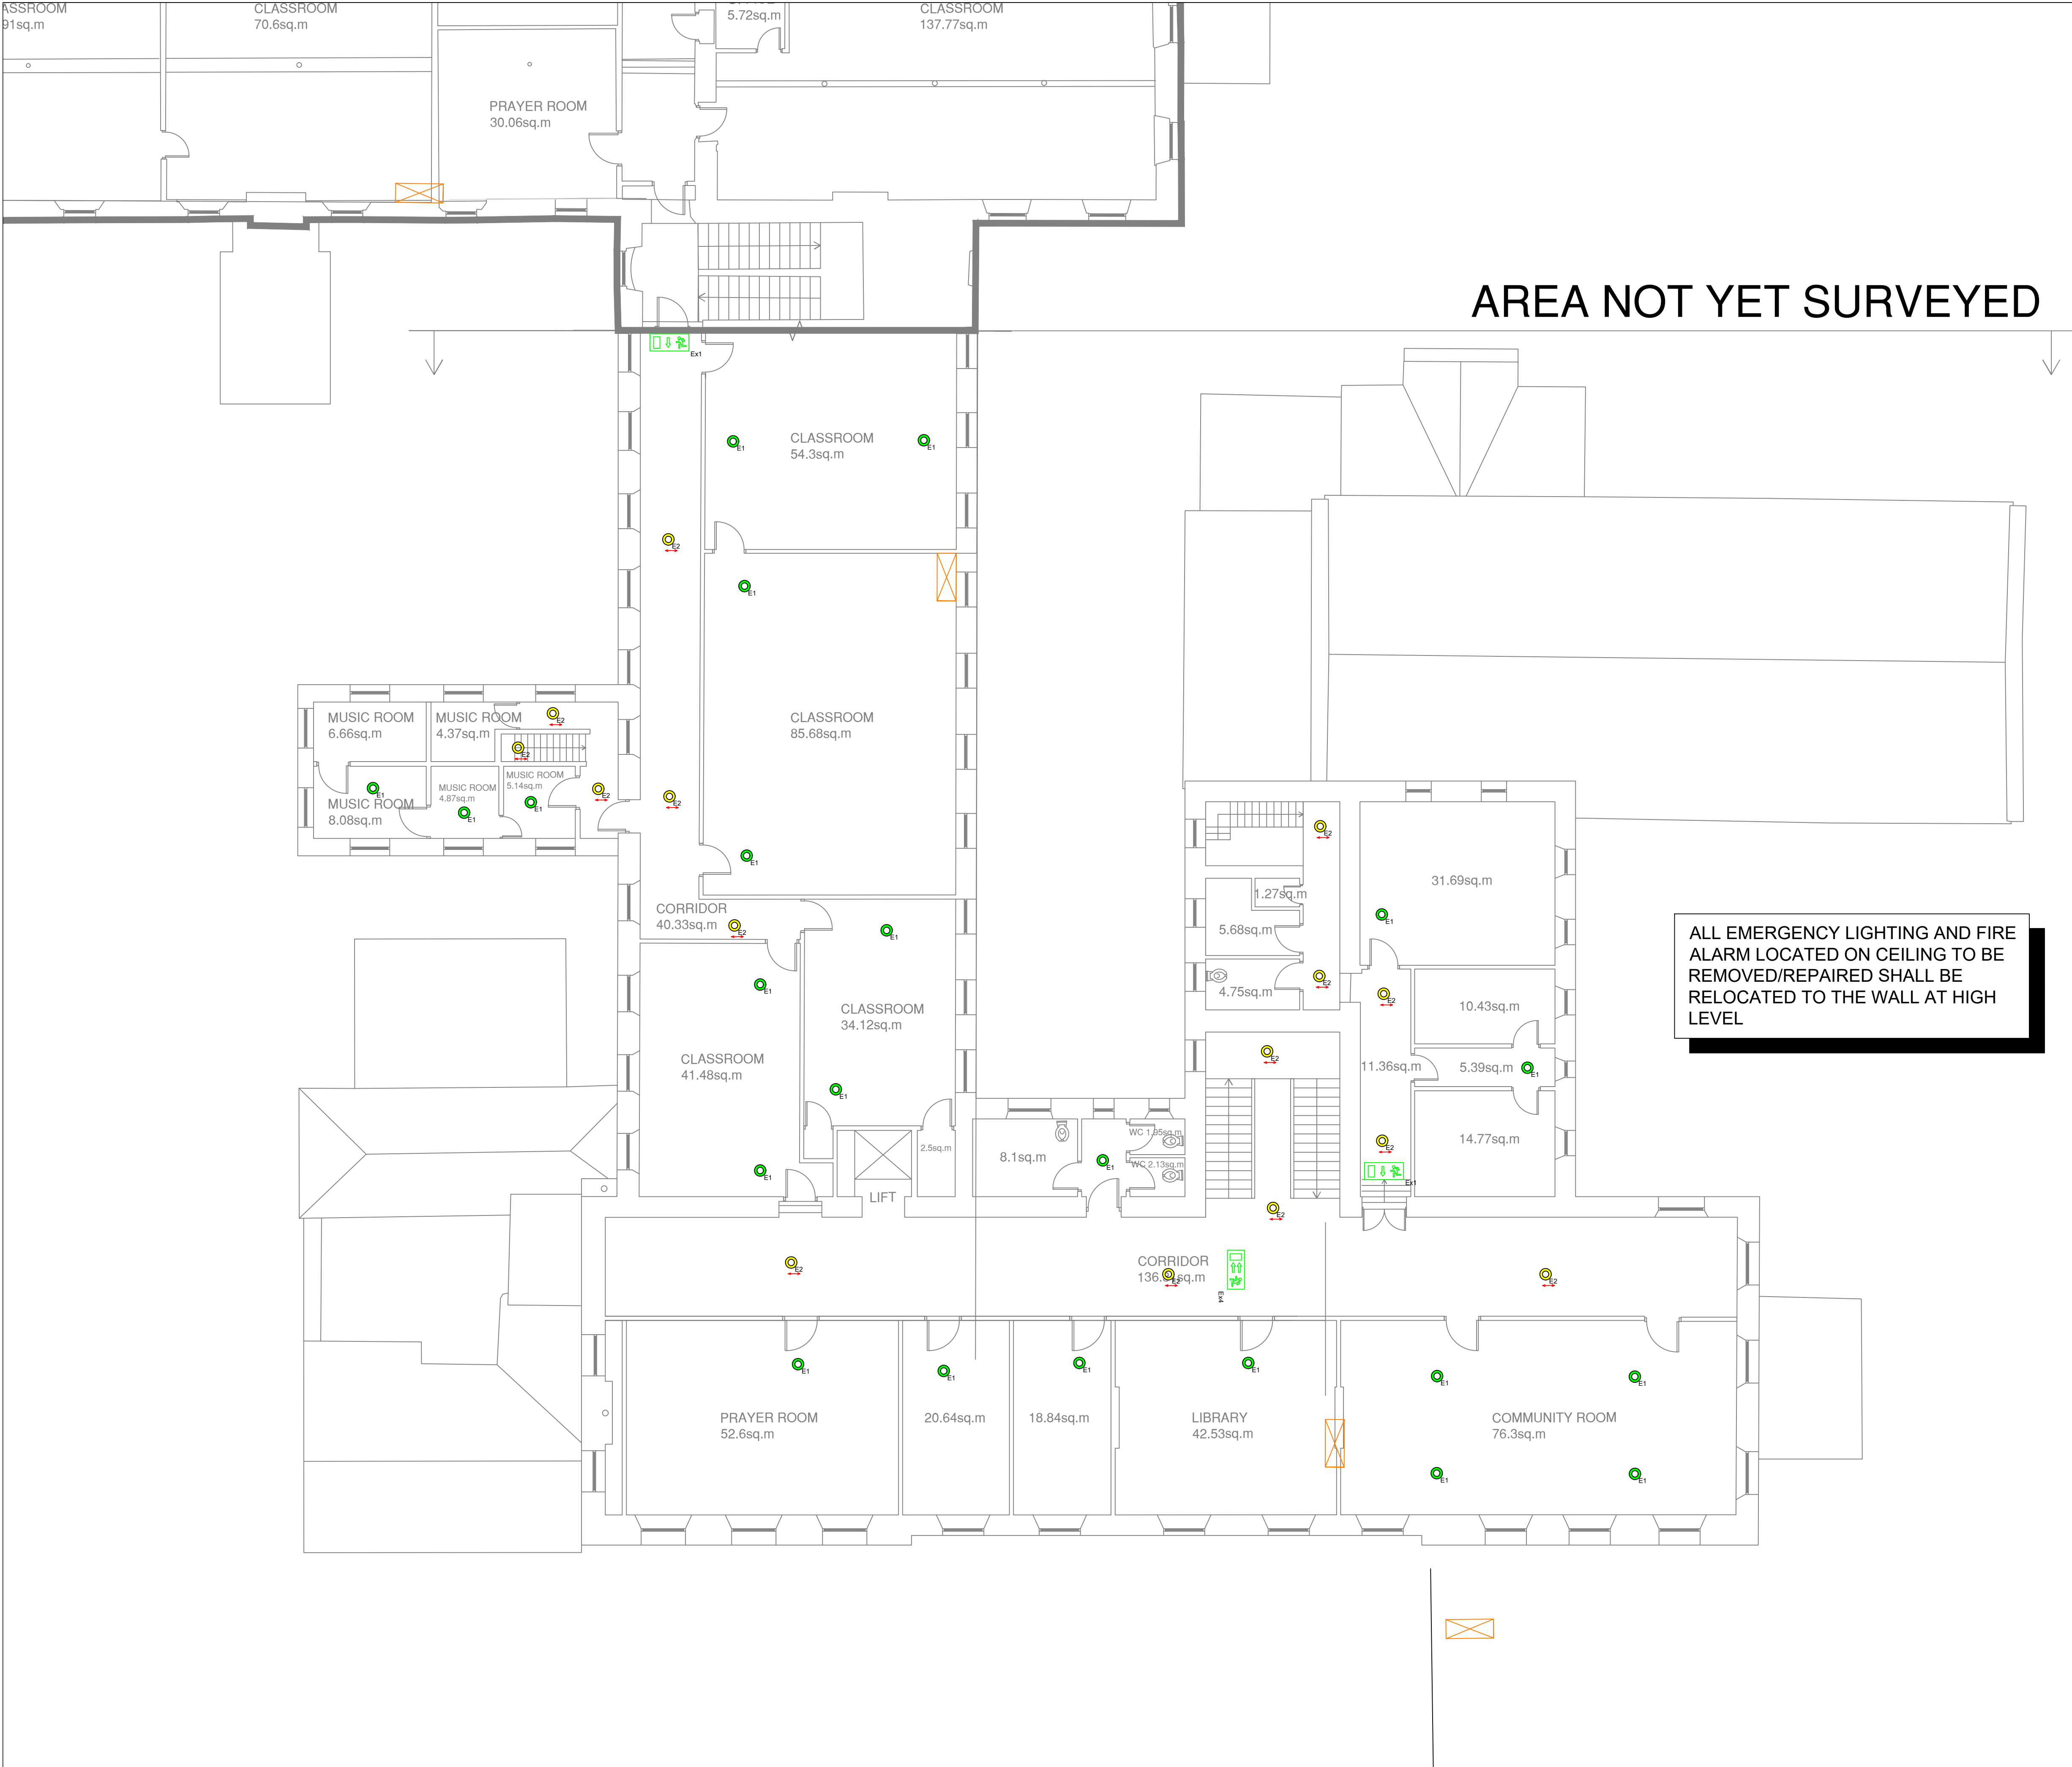
 




THIS DRAWING IS THE PROPERTY OF DELAP & WALLER AND MAY ONLY BE USED WITH THEIR WRITTEN APPROVAL.
DO NOT SCALE FROM THIS DRAWING.
GENERAL NOTES.
THIS DRAWING TO BE READ IN CONJUNCTION WITH ALL OTHER RELEVANT DRAWINGS AND SPECIFICATIONS
ALL DIMENSIONS ARE IN MILLIMETRES UNLESS OTHERWISE STATED.
THIS DRAWING IS NOT AN INSTALLATION DRAWING. THE CONTRACTOR SHALL BE RESPONSIBLE FOR THE PRODUCTION OF FABRICATION AND INSTALLATION DRAWINGS, SHALL BE FAMILIAR WITH OTHER WORKS PACKAGES WHICH DIRECTLY INTERFERENCE WITH HIS PACKAGE AND COORDINATE WITH THE FABRICATION AND INSTALLATION DRAWINGS ACCORDINGLY.
THE CONTRACTOR SHALL BE RESPONSIBLE FOR THE DESIGN, SUPPLY AND INSTALLATION OF SUPPORTS, BRACKETING SYSTEMS, AND SECONDARY STEELWORK SUPPORTS REQUIRED FOR THIS WORKS PACKAGE, UNLESS OTHERWISE STATED.
SHOULD ANY DISCREPANCIES BE APPARENT IN THIS DRAWING, THE ENGINEER SHALL BE MADE AWARE OF THIS FOR FURTHER ACTION.

Type	Product	Block Symbol
E1	Optilens Recessed Open Plan (OPNM3/LED/OP)	 E1
E2	Optilens Recessed Escape Route (OLNM3/LED/ES)	 E2
E3	Optilens Open Plan Surface Mount (OLNM3/LED/3W/OP/SM)	 E3
E4	Optilens Escape Route Surface Mount (OLNM3/LED/3W/ES/SM)	 E4
E5	Weatherproof B/Head IP65 Non Maintained (WPNM3/LED/3W)	 E5
E6	Optic LED Open Plan Surface Mounted (OPNM3/LED/OP/SM)	 E6
E7	Optic LED Open Plan (OPNM3/LED/OP)	 E7
Ex1	FUSION EXIT LIGHT - DOWN	 Ex1
Ex2	FUSION EXIT LIGHT - LEFT	 Ex2
Ex3	FUSION EXIT LIGHT - RIGHT	 Ex3
Ex4	FUSION EXIT LIGHT DOUBLE SIDED	 Ex4
Ex5	VISOR EXIT IP65 - DOWN	 Ex5

T1	02-04-2026	TENDER ISSUE	CL	PB
T	08-09-2022	TENDER ISSUE	CD	PB
Revision	Date	Details	Drn	Chkd



DELAP & WALLER
+353 1 535 5900
dublin@delapandwaller.com
www.delapandwaller.com

☐ Antrim

☒ Dublin

☐ London

ARCHITECT
KOBW

PROJECT
SACRED HEART SECONDARY SCHOOL, CONVENT ROAD, CLONAKILTY, CO. CORK

TITLE
EMERGENCY LIGHTING LAYOUT BUILDINGS 1-3

DESIGNED PB	DATE SEPT. 2022	FLOOR FIRST FLOOR
DRAWN CD	SCALE 1:100 @ A1	

DRG No. 22004-E-101	DRG REV. T1
-------------------------------	-----------------------

DRG STATUS
TENDER ISSUE