


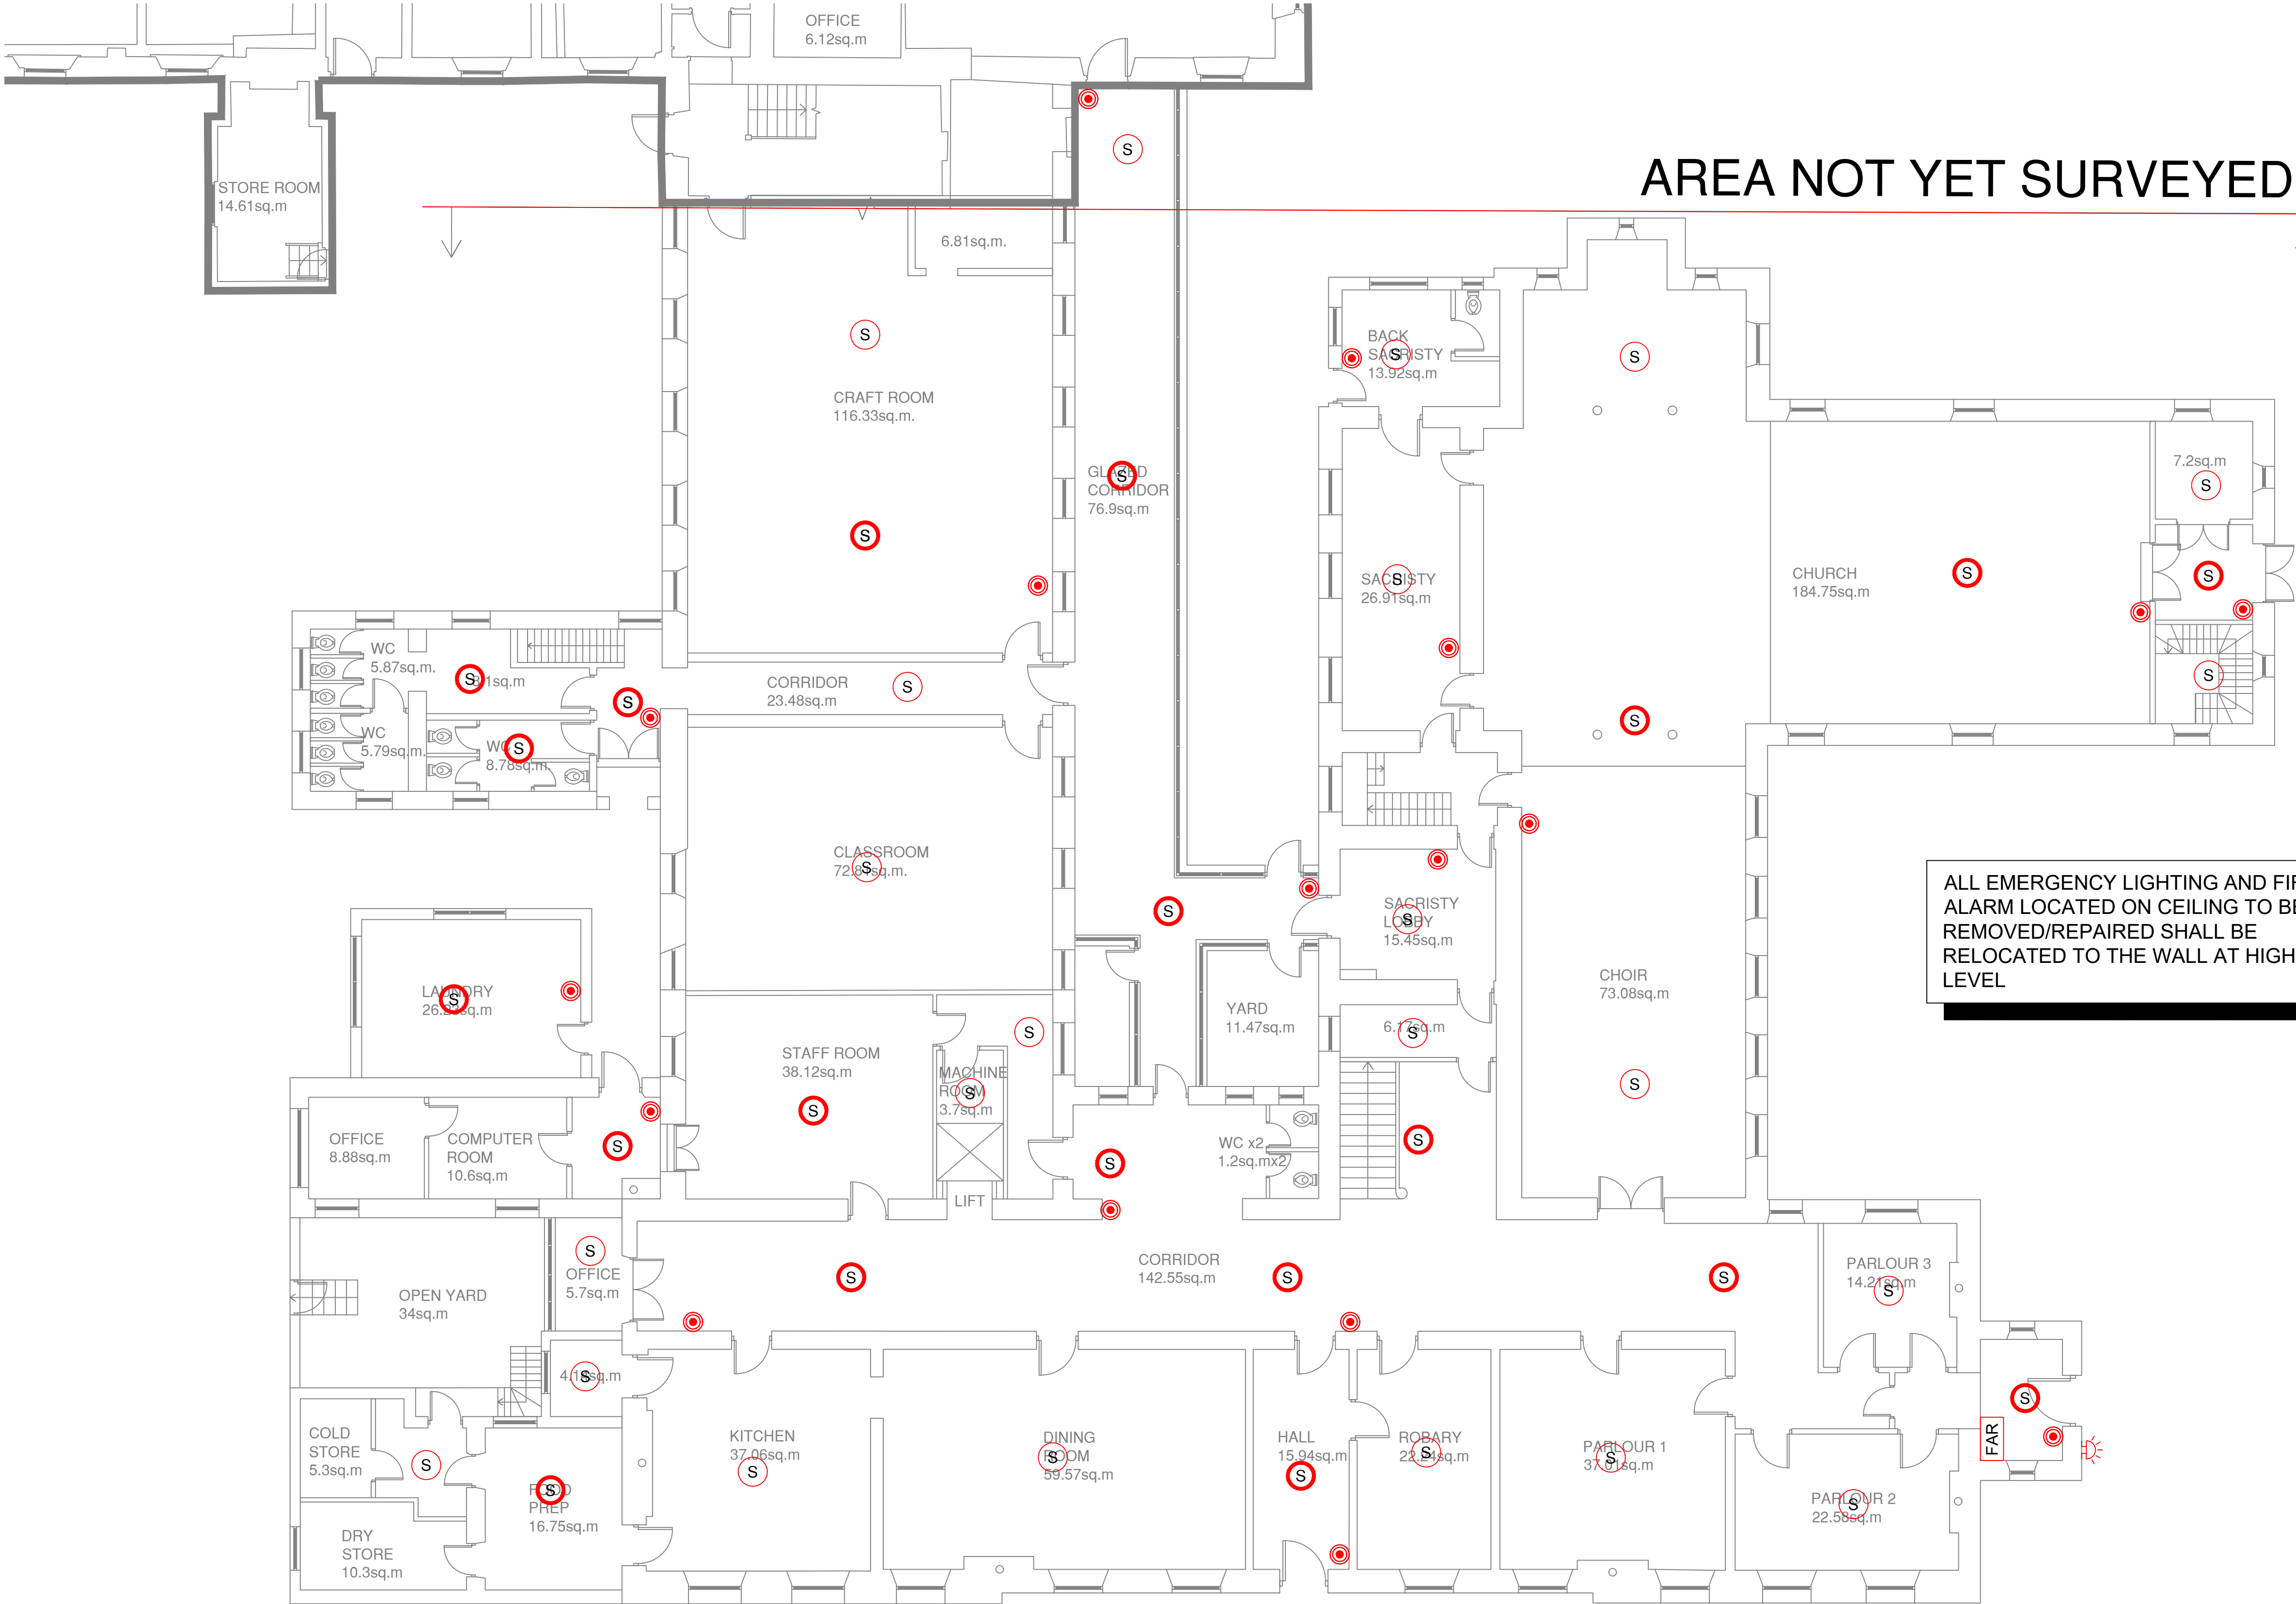

THIS DRAWING IS THE PROPERTY OF DELAP & WALLER AND MAY ONLY BE USED WITH THEIR WRITTEN APPROVAL.
DO NOT SCALE FROM THIS DRAWING.
GENERAL NOTES.
THIS DRAWING TO BE READ IN CONJUNCTION WITH ALL OTHER RELEVANT DRAWINGS AND SPECIFICATIONS
ALL DIMENSIONS ARE IN MILLIMETRES UNLESS OTHERWISE STATED.
THIS DRAWING IS NOT AN INSTALLATION DRAWING. THE CONTRACTOR SHALL BE RESPONSIBLE FOR THE PRODUCTION OF FABRICATION AND INSTALLATION DRAWINGS, SHALL BE FAMILIAR WITH OTHER WORKS PACKAGES WHICH DIRECTLY INTERFACE WITH HIS PACKAGE AND COORDINATE WITH THE FABRICATION AND INSTALLATION DRAWINGS ACCORDINGLY.
THE CONTRACTOR SHALL BE RESPONSIBLE FOR THE DESIGN, SUPPLY AND INSTALLATION OF SUPPORTS, BRACKETING SYSTEMS, AND SECONDARY STEELWORK SUPPORTS REQUIRED FOR THIS WORKS PACKAGE, UNLESS OTHERWISE STATED.
SHOULD ANY DISCREPANCIES BE APPARENT IN THIS DRAWING, THE ENGINEER SHALL BE MADE AWARE OF THIS FOR FURTHER ACTION.

PROTECTIVE SERVICES (ELEMENT 68)

- 68.23 FAR FIRE ALARM REPEATER PANEL
68.02 S SMOKE DETECTOR
68.05 S SMOKE DETECTOR C/W SOUNDER BASE
68.14 ● MANUAL CALL POINT

T1	02-04-2026	TENDER ISSUE	CL	PB
T	08-09-2022	TENDER ISSUE	CD	PB
Revision	Date	Details	Drn	Chkd



DELAP & WALLER
+353 1 535 5900
dublin@delapandwaller.com
www.delapandwaller.com

☐ Antrim

☒ Dublin

☐ London

ARCHITECT
KOBW

PROJECT
**SACRED HEART SECONDARY
SCHOOL, CONVENT ROAD,
CLONAKILTY, CO. CORK**

TITLE
**FIRE ALARM LAYOUT
BUILDINGS 1-3**

DESIGNED	DATE	FLOOR
PB	SEPT. 2022	GROUND FLOOR
DRAWN	SCALE	
CD	1:100 @ A1	

DRG No.	22004-E-300	DRG REV	T1
---------	-------------	---------	----

DRG STATUS
TENDER ISSUE