


THIS DRAWING IS THE PROPERTY OF DELAP & WALLER AND MAY ONLY BE USED WITH THEIR WRITTEN APPROVAL.
DO NOT SCALE FROM THIS DRAWING.
GENERAL NOTES.
THIS DRAWING TO BE READ IN CONJUNCTION WITH ALL OTHER RELEVANT DRAWINGS AND SPECIFICATIONS
ALL DIMENSIONS ARE IN MILLIMETRES UNLESS OTHERWISE STATED.
THIS DRAWING IS NOT AN INSTALLATION DRAWING; THE CONTRACTOR SHALL BE RESPONSIBLE FOR THE PRODUCTION OF FABRICATION AND INSTALLATION DRAWINGS, SHALL BE FAMILIAR WITH OTHER WORKS PACKAGES WHICH DIRECTLY INTERFACE WITH HIS PACKAGE AND COORDINATE WITH THE FABRICATION AND INSTALLATION DRAWINGS ACCORDINGLY.
THE CONTRACTOR SHALL BE RESPONSIBLE FOR THE DESIGN, SUPPLY AND INSTALLATION OF SUPPORTS, BRACKETING SYSTEMS, AND SECONDARY STEELWORK SUPPORTS REQUIRED FOR THIS WORKS PACKAGE, UNLESS OTHERWISE STATED.
SHOULD ANY DISCREPANCIES BE APPARENT IN THIS DRAWING, THE ENGINEER SHALL BE MADE AWARE OF THIS FOR FURTHER ACTION.

ALL EMERGENCY LIGHTING AND FIRE ALARM LOCATED ON CEILING TO BE REMOVED/REPAIRED SHALL BE RELOCATED TO THE WALL AT HIGH LEVEL

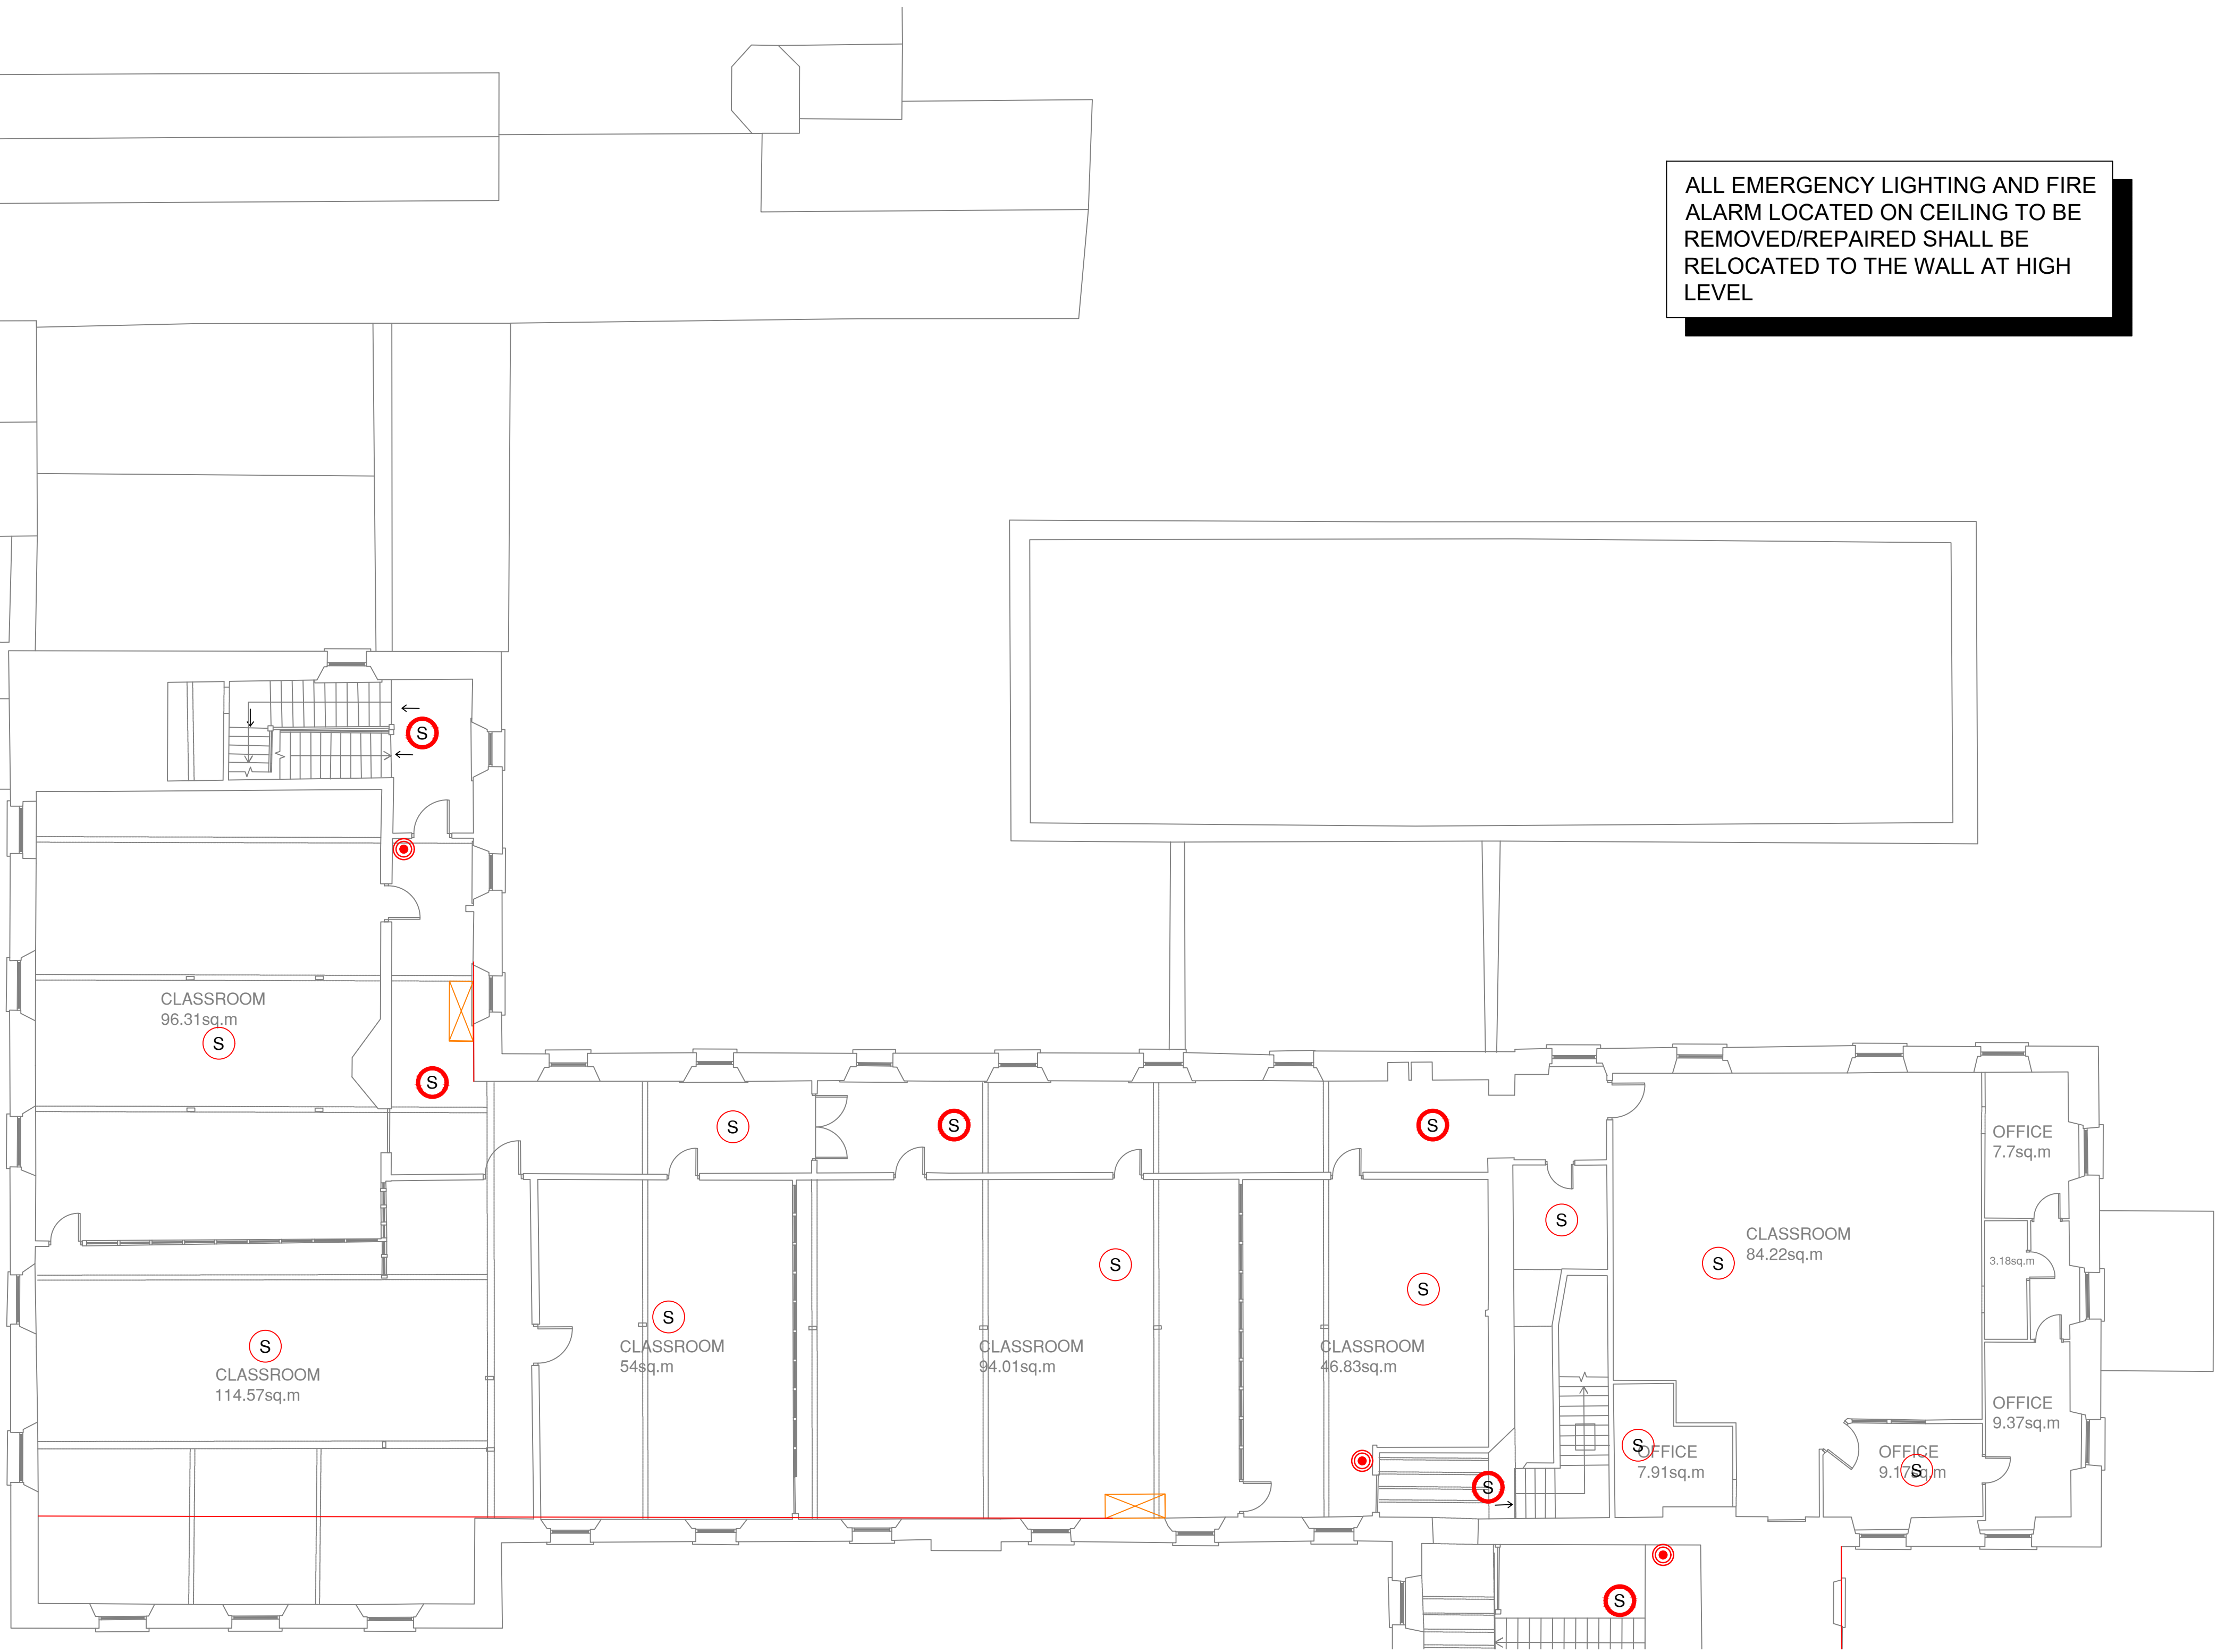

T1	02-04-2026	TENDER ISSUE	CL	PB
T	08-09-2022	TENDER ISSUE	CD	PB
Revision	Date	Details	Drm	Chkd



DELAP & WALLER
+353 1 535 5900
dublin@delapandwaller.com
www.delapandwaller.com

☐ Antrim

☒ Dublin

☐ London

ARCHITECT
KOBW

PROJECT
SACRED HEART SECONDARY
SCHOOL, CONVENT ROAD,
CLONAKILTY, CO. CORK

TITLE
FIRE ALARM LAYOUT
BUILDING 4

DESIGNED	DATE	FLOOR
PB	SEPT. 2022	SECOND FLOOR
DRAWN	SCALE	(OCCUPIED)
CD	1:100 @ A1	

DRG No.	22004-E-302-1	DRG REV.
		T1

DRG STATUS
TENDER ISSUE