

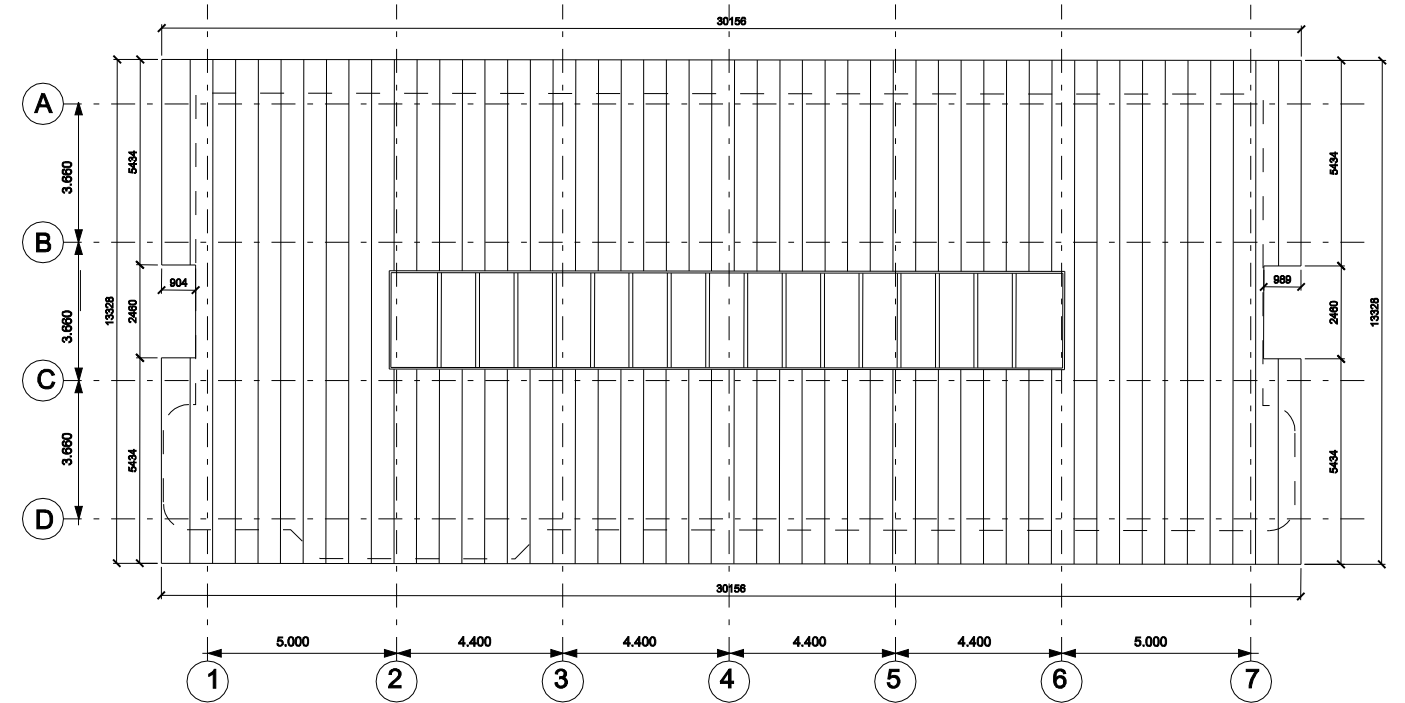


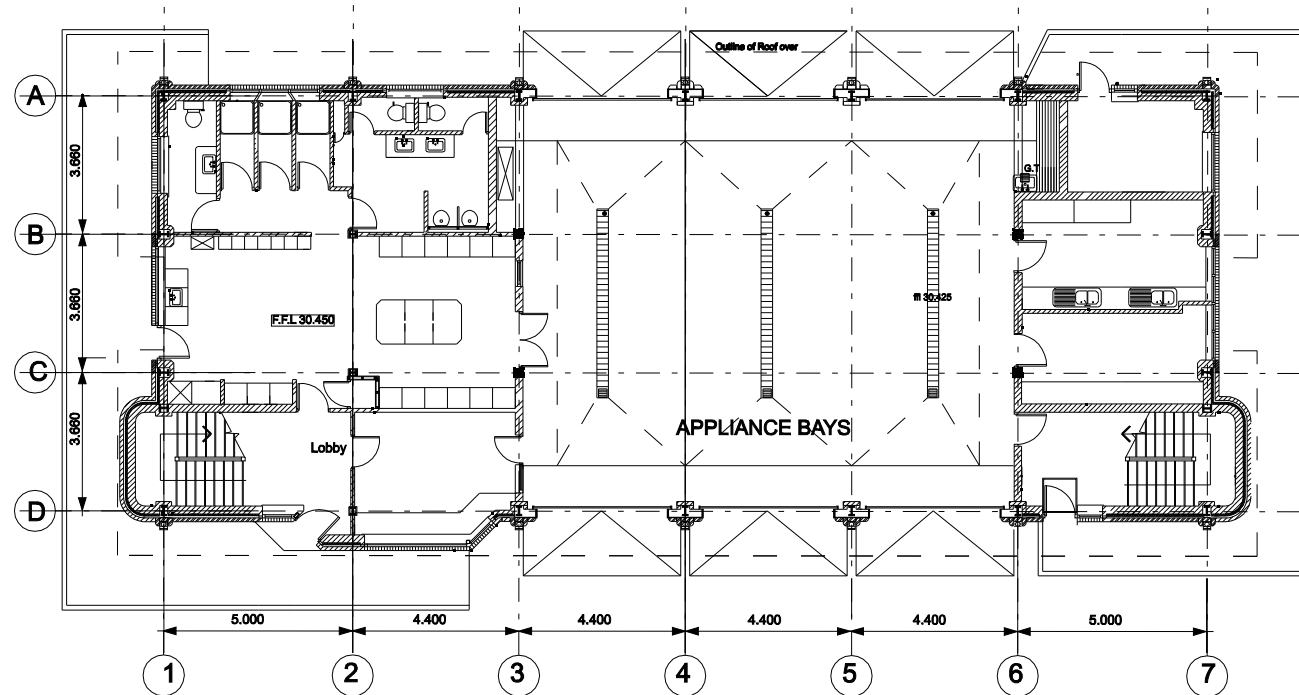


01
2011 Ground floor plan of Existing Fire Station

03
2011 Roof plan of Existing Fire Station

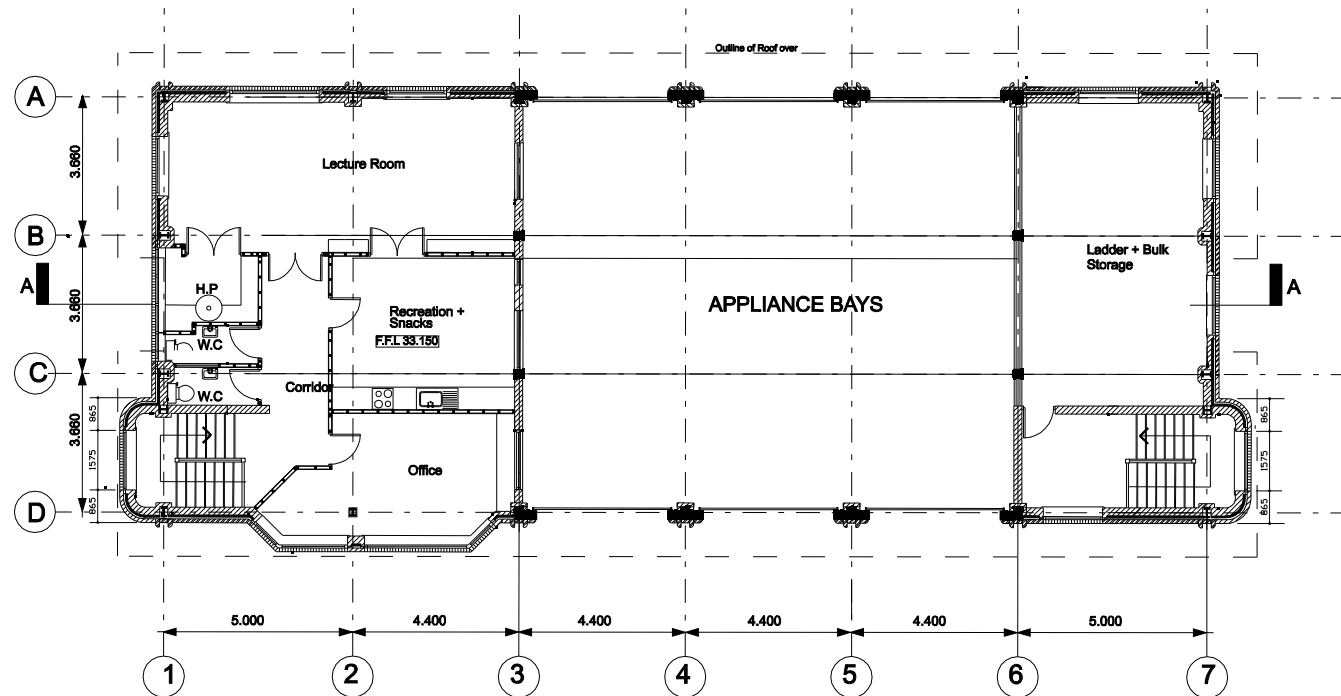

02
2011 First floor plan of Existing Fire Station

 NOTES / LEGEND



Revision	Date	Description	By
00	22.12.08	ISSUED FOR PLANNING	DM

Drawing Status: **PLANNING**

Reply Address:
No.3 Victoria Road
Cork,
Ireland.

General Notes
* DO NOT SCALE. USE DIMENSIONS ONLY.
* THIS DRAWING IS TO BE READ IN CONJUNCTION WITH ALL RELEVANT SPECIFICATIONS AND DRAWINGS.
* ALL DIMENSIONS TO BE CHECKED ON SITE.
* IN THE EVENT OF ANY DISCREPANCIES BETWEEN DRAWINGS THE CONTRACTOR IS TO INFORM THE ARCHITECT IMMEDIATELY.

murrayolaoire architects

ARCHITECTS ■ PLANNERS ■ URBAN DESIGNERS ■
Client: Cork County Council
Project: Fire and Building Control Services Head Quarters
Drawing: Existing Plans of Fire Station
Date: DEC 08 Scale: 1:100 @ A1
Drawn by: EC Plot Check: Stage: 3: Dig No: 2011 Rev: 00
Approved: Job No: 08013

© COPYRIGHT This drawing or design may not be reproduced without permission