


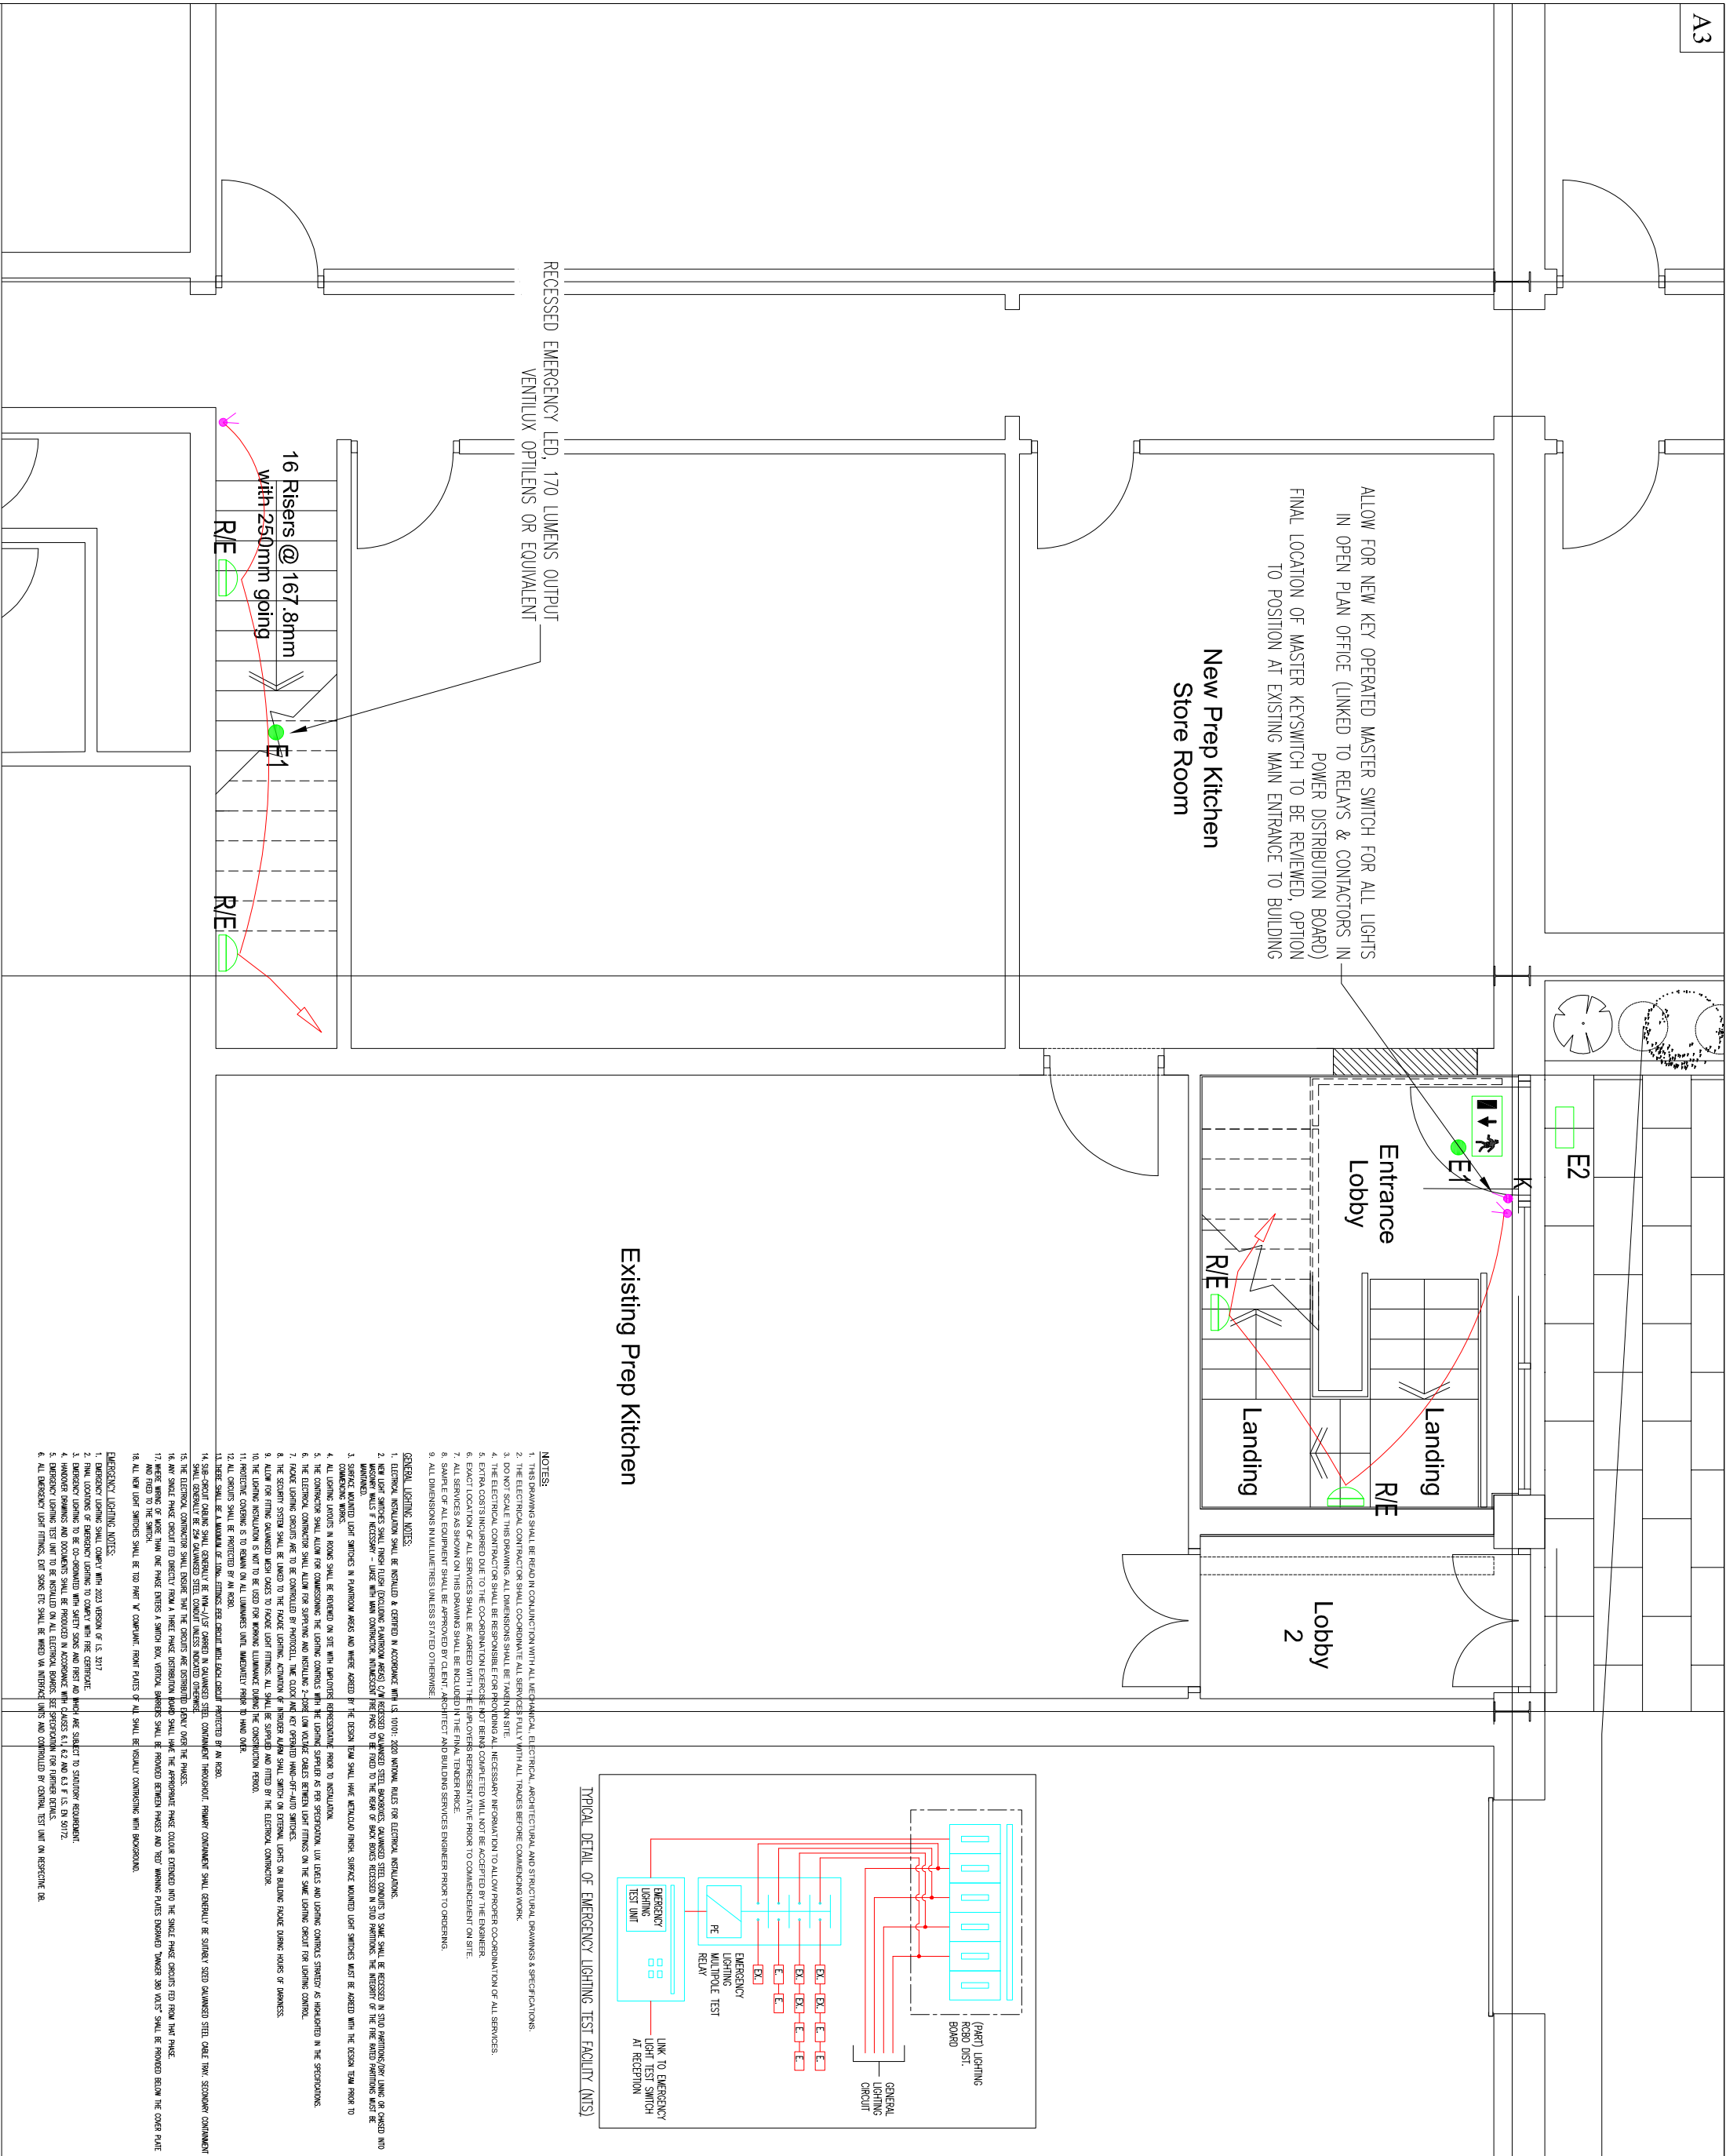


GENERAL NOTES

- 1) Do not scale services equipment from this drawing.
- 2) All dimensions should be checked on site.
- 3) Any drawings errors or divergences should be brought to the attention of Geacny Engineering Consultants at the address shown below.
- 4) Drawing to be read in conjunction with all other drawings and documentation.

GENERAL & EMERGENCY LIGHTING LEGEND:

- | | |
|---|---|
|  | LIGHT SWITCH, ONE WAY |
|  | LIGHT SWITCH, TWO WAY |
|  | P.I.R. MOVEMENT SENSOR, 8.0m RANGE |
|  | STENEL OR EQUIVALENT |
|  | DAYLIGHT DIMMING & P.I.R. MOVEMENT SENSOR, 8.0m RANGE |
|  | STENEL OR EQUIVALENT |
|  | LIGHTING CONTROL MODULE |

TYPICAL DETAIL OF EMERGENCY LIGHTING TEST FACILITY (NTS)

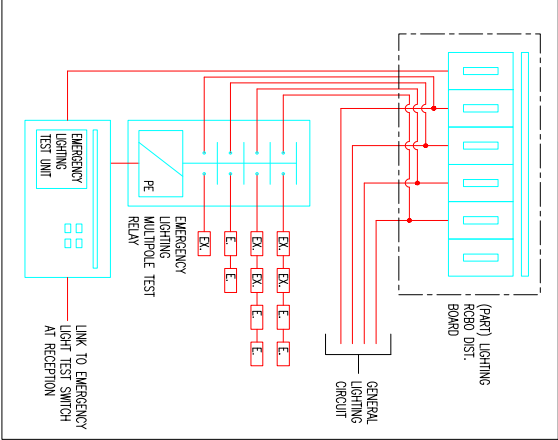

NOTES:

1. THE DRAWING SHALL BE AVOID IN CONJUNCTION WITH ALL MECHANICAL, ELECTRICAL, ARCHITECTURAL AND STRUCTURAL DRAWINGS & SPECIFICATIONS.
2. THE ELECTRICAL CONTRACTOR SHALL CO-ORDINATE ALL SERVICES WITH ALL TRADES BEFORE COMMENCING WORK.
3. DO NOT SCALE THIS DRAWING. ALL DIMENSIONS SHALL BE INDICATED BY DIMENSION LINES.
4. IF ANY DIMENSIONS ARE NOT SPECIFIED, THE CONTRACTOR SHALL OBTAIN NECESSARY INFORMATION TO ALLOW PROPER COORDINATION OF ALL SERVICES.
5. EXTRA COSTS INCURRED DUE TO THE COORDINATION DEFECTS, NOT BEING COMPLETED, WILL NOT BE ACCEPTED BY THE ENGINEER.
6. EXACT LOCATION OF ALL SERVICES SHALL BE AGREED WITH THE EMPLOYER REPRESENTATIVE PRIOR TO COMMENCEMENT ON SITE.
7. ALL SERVICES AS SHOWN ON THIS DRAWING SHALL BE ACCURATE AND IN THE FINAL TENDER PRICE.
8. STATE OF ALL EQUIPMENT SHALL BE APPROVED BY CLIENT, ARCHITECT AND BUILDING SERVICES ENGINEER PRIOR TO ORDERING.
9. ALL DIMENSIONS IN MILLIMETERS UNLESS STATED OTHERWISE.

GENERAL LIGHTING NOTES

- [illegible]

EMERGENCY LIGHTING NOTES:

1. DERRISIGN LIGHTING SHALL COMPLY WITH 2023 VERSION OF I.S. 2017
2. FINAL LOCATIONS OF DERRISIGN LIGHTING TO COMPLY WITH FIRE CERTIFICATE.
3. DERRISIGN LIGHTING TO BE CO-GROUNDED WITH SAFETY SIGNS AND REST AND WHICH ARE SUBJECT TO STATUTORY REQUIREMENT.
4. HANDOVER DRAWINGS AND DOCUMENTS SHALL BE PROVIDED IN ACCORDANCE WITH CLASSES 6.1, 6.2 AND 6.3 FIVE I.S. 2017/2.
5. DERRISIGN LIGHTING TEST UNIT TO BE INSTALLED ON ALL ELECTRICAL BOARDS, SEE SPECIFICATION FOR FURTHER DETAILS.
6. ALL DERRISIGN LIGHT FITTINGS, END SOCKS ETC SHALL BE WHEED VIA INTERLOCK UNITS AND CONTROLLED BY CENTRAL TEST UNIT ON RESPECTIVE DE

**SEANEY
ENGINEERING
CONSULTANTS**

31 O'NEILL ZEE,
WATERFORD BUSINESS PARK,
CORK ROAD,
WATERFORD,
IRELAND.

TEL: 051-479371
FAX: 051-453188
EMAIL: info@seaneyengineering.ie

Dunhill Eco Centre
Proposed Offices
Dunhill, Co. Waterford

General & Emergency Lighting Layout
Ground Floor

The E Project Chartered Architects

1:50 @ A3

drawing number:	project number:
-----------------	-----------------

EL4 0000