


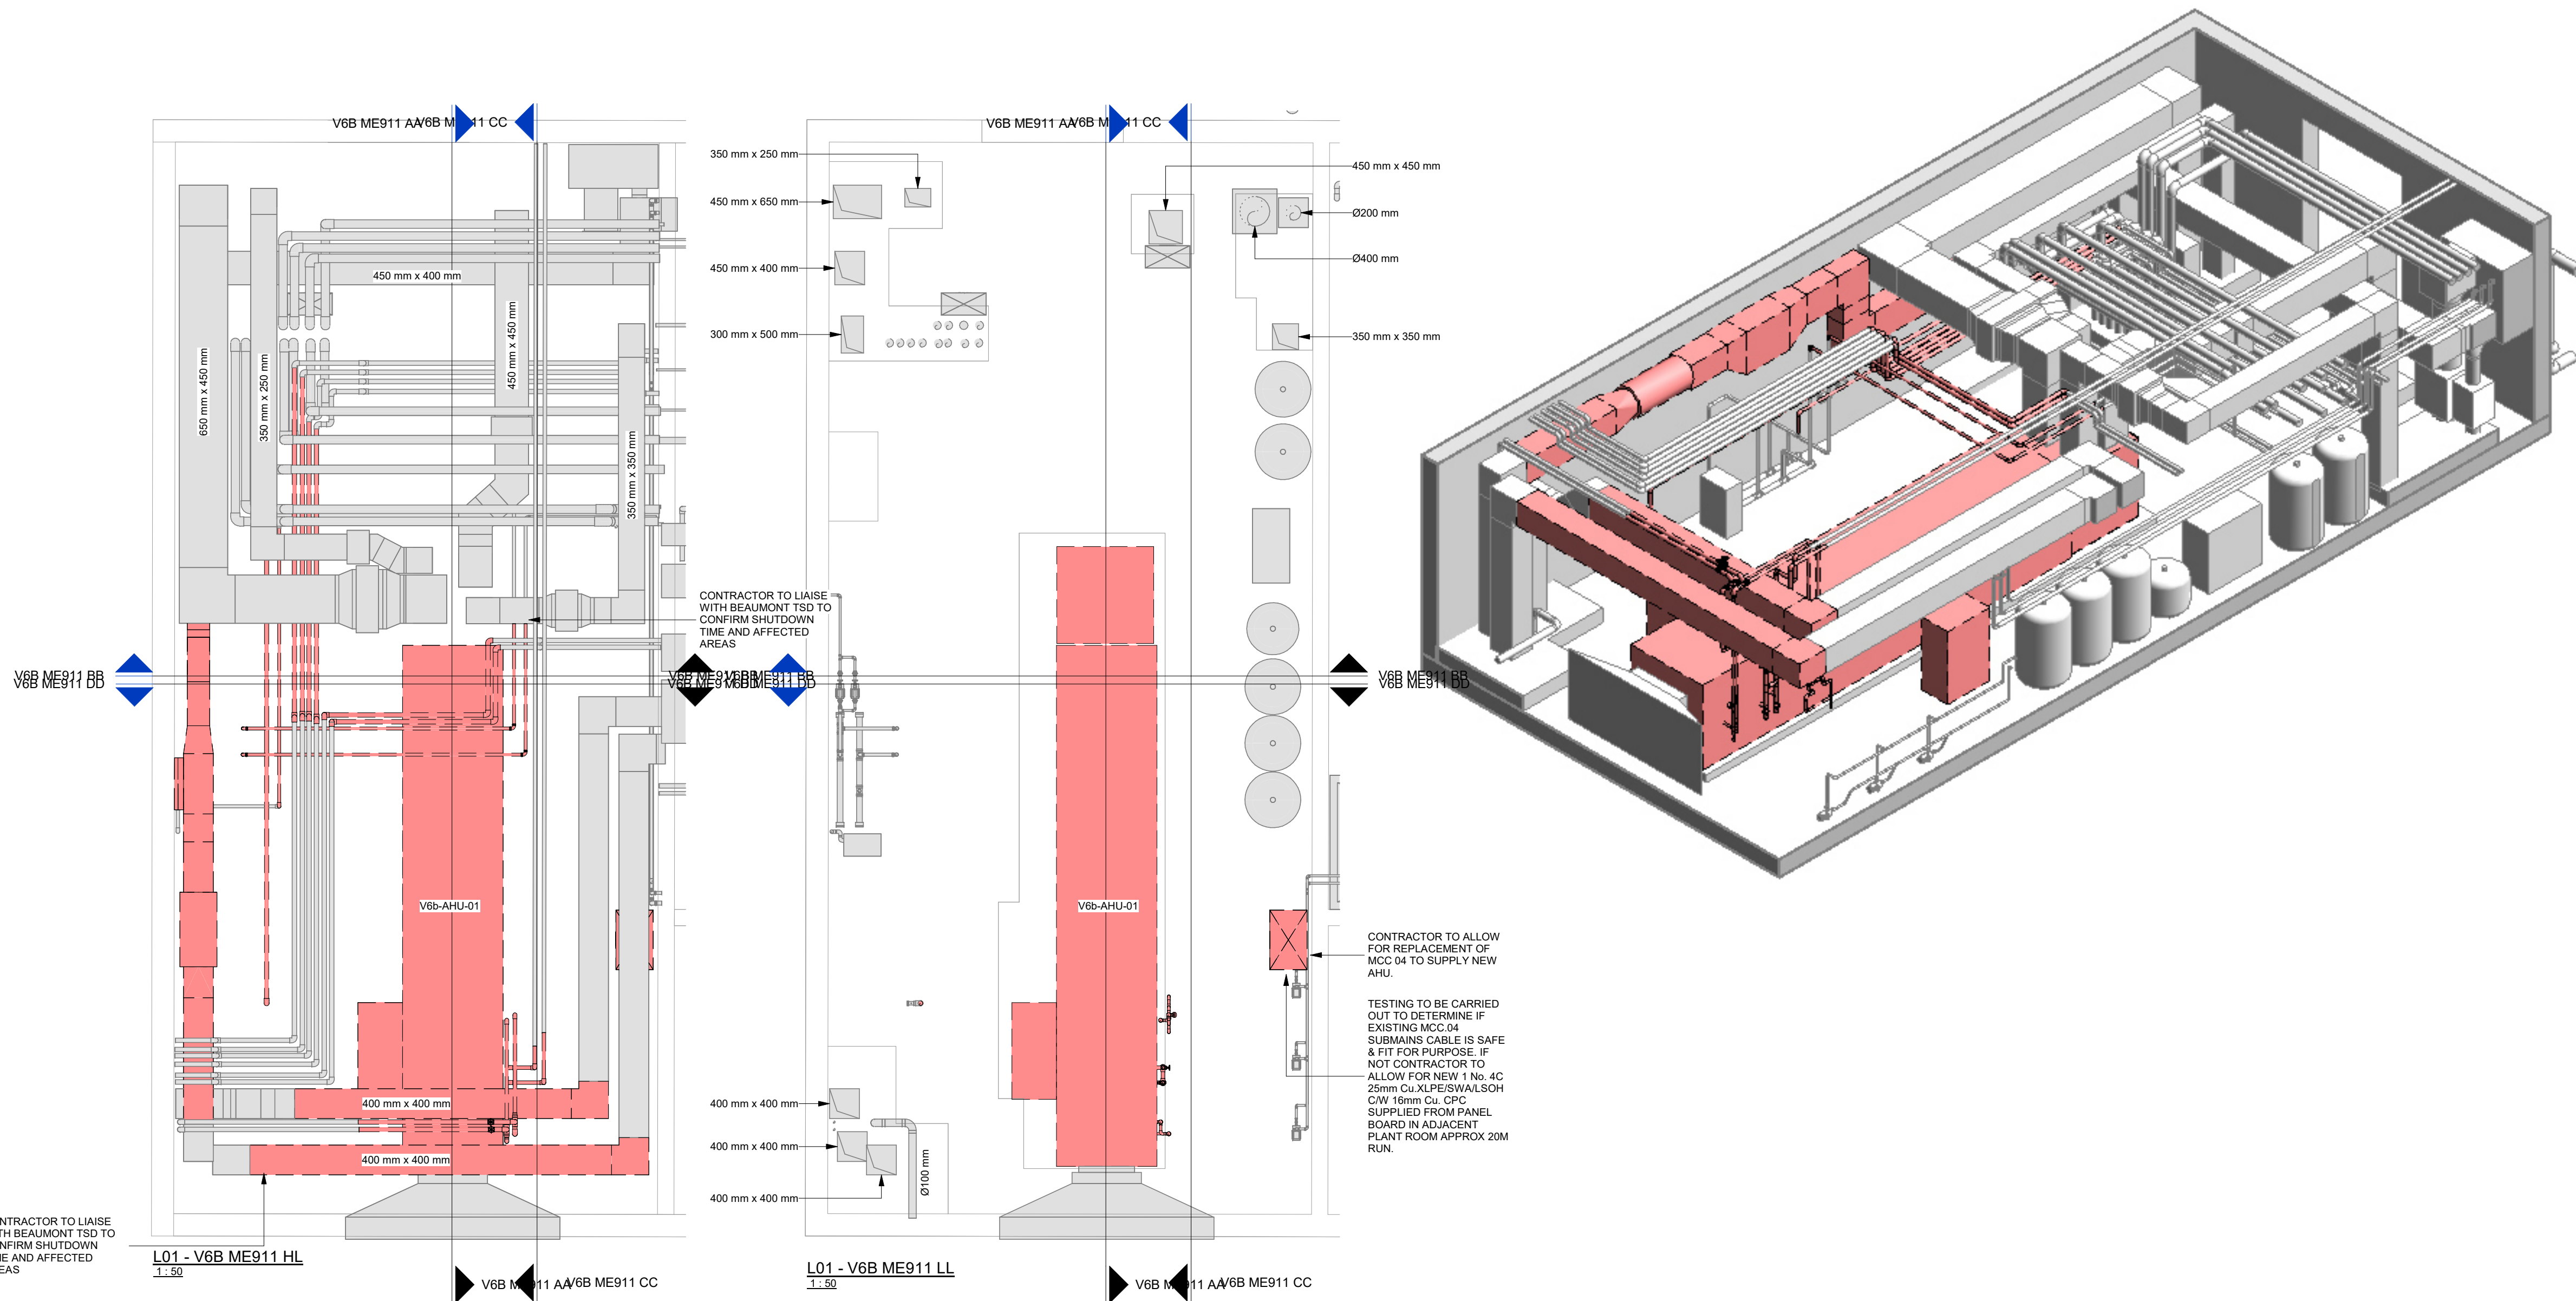

COMBINED SERVICES PIPEWORK REFERENCE KEY


- LTHW-F PIPEWORK
- LTHW-R PIPEWORK
- MTHW-F PIPEWORK
- MTHW-R PIPEWORK
- STEAM PIPEWORK
- CONDENSATE PIPEWORK
- CWS PIPEWORK

COMBINED SERVICES DUCTWORK REFERENCE KEY


- RETURN AIR DUCTWORK
- SUPPLY AIR DUCTWORK
- FRESH AIR DUCTWORK
- EXHAUST AIR DUCTWORK

STRIP-OUT SERVICES NOTES


- THIS DRAWING TO BE READ IN CONJUNCTION WITH ALL OTHER ARCHITECTS, STRUCTURAL ENGINEERS AND BUILDING SERVICES ENGINEERS DRAWINGS, SPECIFICATIONS AND SCHEDULES.
- CONTRACTOR TO CARRY OUT SITE SURVEY AS PART OF PRICING WORKS.
- CONTRACTOR TO ALLOW FOR THE DRAINING & REBALANCING OF THE LTHW SYSTEM IN THIS AREA TO ENABLE EXISTING PIPEWORK TO BE DIVERTED
- CONTRACTOR TO DRAIN DOWN WET SERVICES PRIOR TO DISCONNECTING PIPEWORK.
- CONTRACTOR TO LIAISE WITH ELECTRICAL CONTRACTOR TO ENSURE POWER IS DEAD PRIOR TO DISCONNECTING ITEMS OF MECHANICAL PLANT.
- CONTRACTOR SHALL LIAISE WITH THE BEAUMONT HOSPITAL IN ADVANCE OF ISOLATION & DRAIN DOWN OF M&E SYSTEMS.
- CONTRACTOR TO ALLOW EXISTING M&E SERVICES WHICH IMPACT THE SCOPE OF WORKS ARE TO BE REROUTED & STRIPPED OUT AS NECESSARY IF DEEMED REDUNDANT.
- ALL BUILDERS WORKS SHALL BE CARRIED OUT BY THE MAIN CONTRACTOR.
- ANY M&E SERVICES PASSING THROUGH FIRE COMPARTMENTS WALLS & FLOORS TO BE FIRE DAMPED, STOPPED & SLEEVED BY THE CONTRACTOR.
- CONTRACTOR TO VISIT SITE TO ASCERTAIN THE FULL EXTENT OF THE WORKS REQUIRED & PRICE ACCORDINGLY.

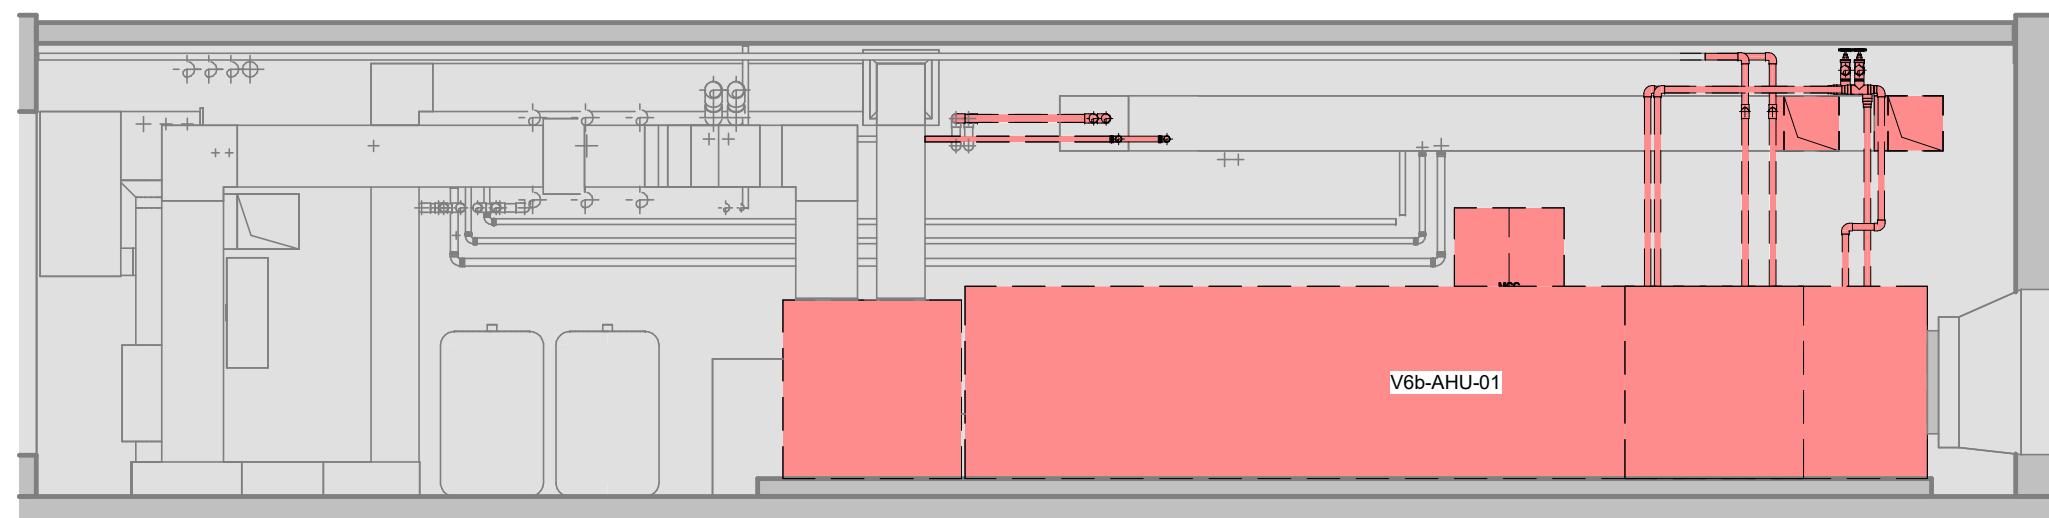


V6B ME911 AA
1:50

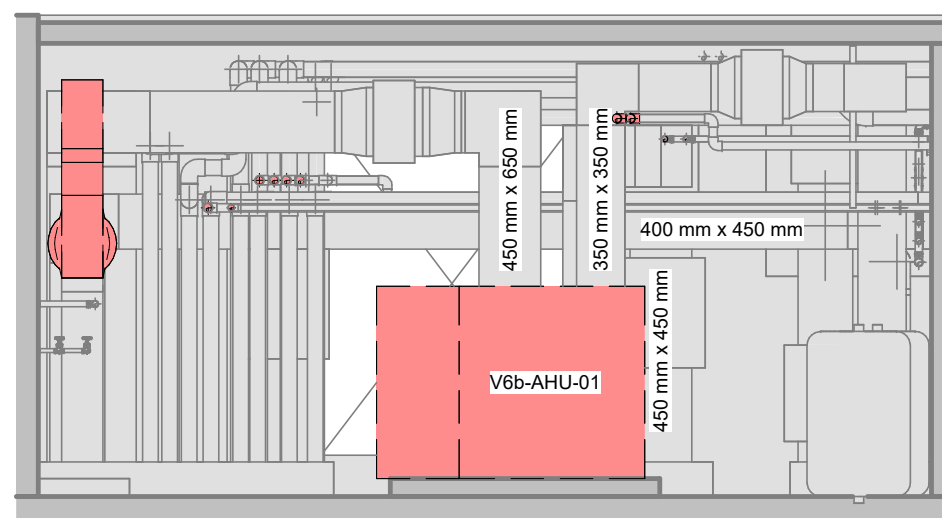


V6B ME911 BB
1:50

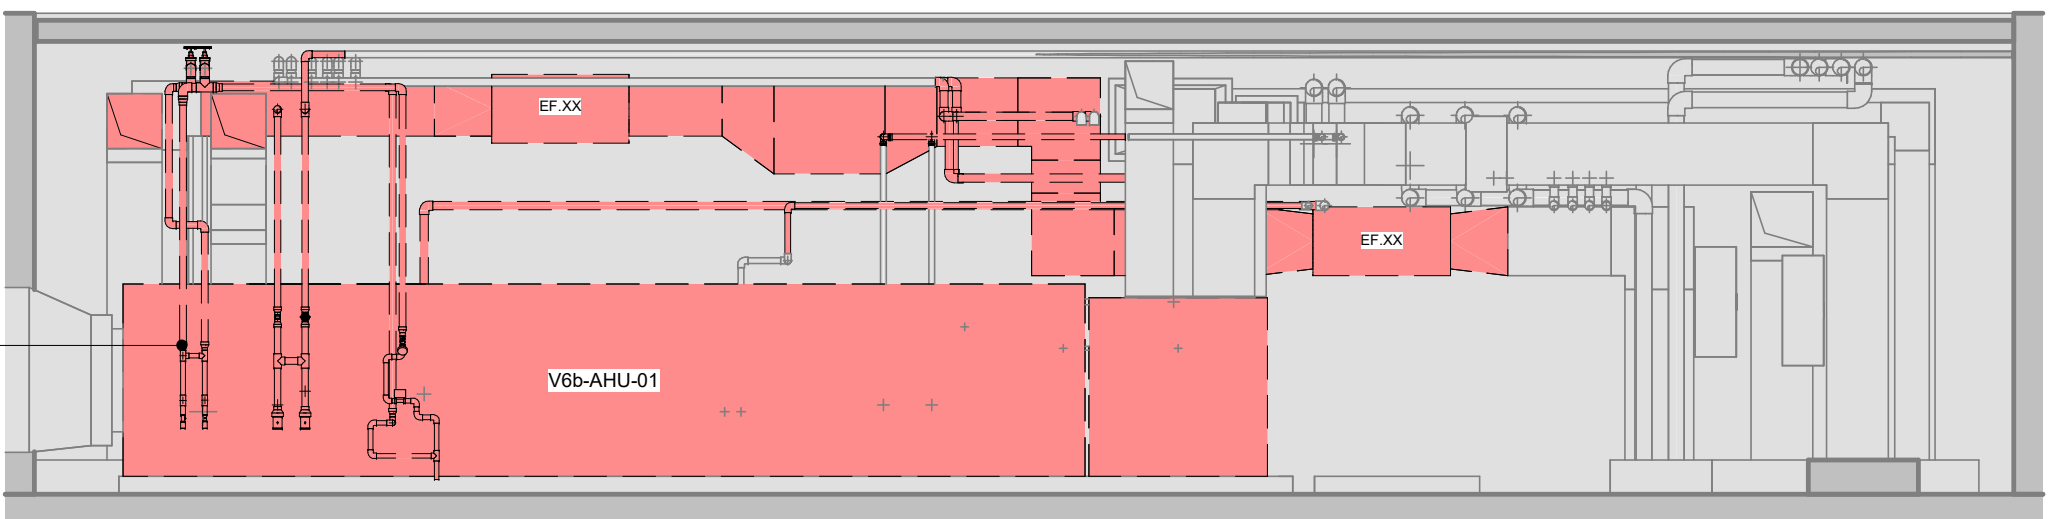

V6B ME911 CC
1:50

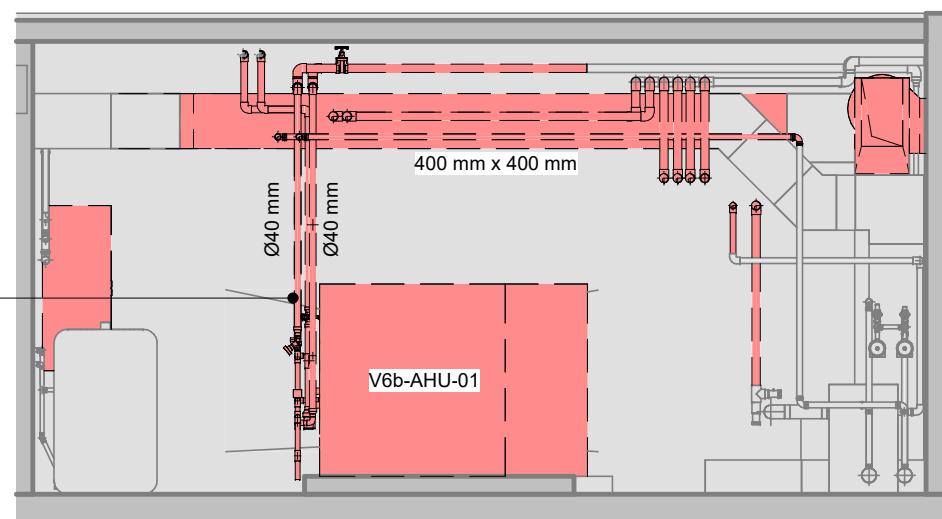

V6B ME911 DD
1:50

 

13.05.2026	TENDER ISSUE	C.O'N	J.F.	S.S.	S0	P01
DATE	DESCRIPTION	DRN	ENG	APP	STATUS	REV
CLIENT						
BEAUMONT HOSPITAL						
ARCHITECT						
PROJECT						
BMT AHU & CHILLER REPLACEMENT						
DRAWING TITLE						
MECHANICAL SERVICES INSTALLATION						
V6B PLANTROOM						
DEMOLITIONS COMBINED SERVICES LAYOUT						
DRAWING No.						
B2506-IN2-V6B-01-DR-ME-0911						
IN2 Engineering 2nd Floor, 5-23 Hill Street, Belfast, BT1 2LA						
in2engineering.com						
STAGE		SIZE		STATUS		
		A1		S0		
SCALE		REVISION				
IN2 REF.		1:50		P01		
B2605						