
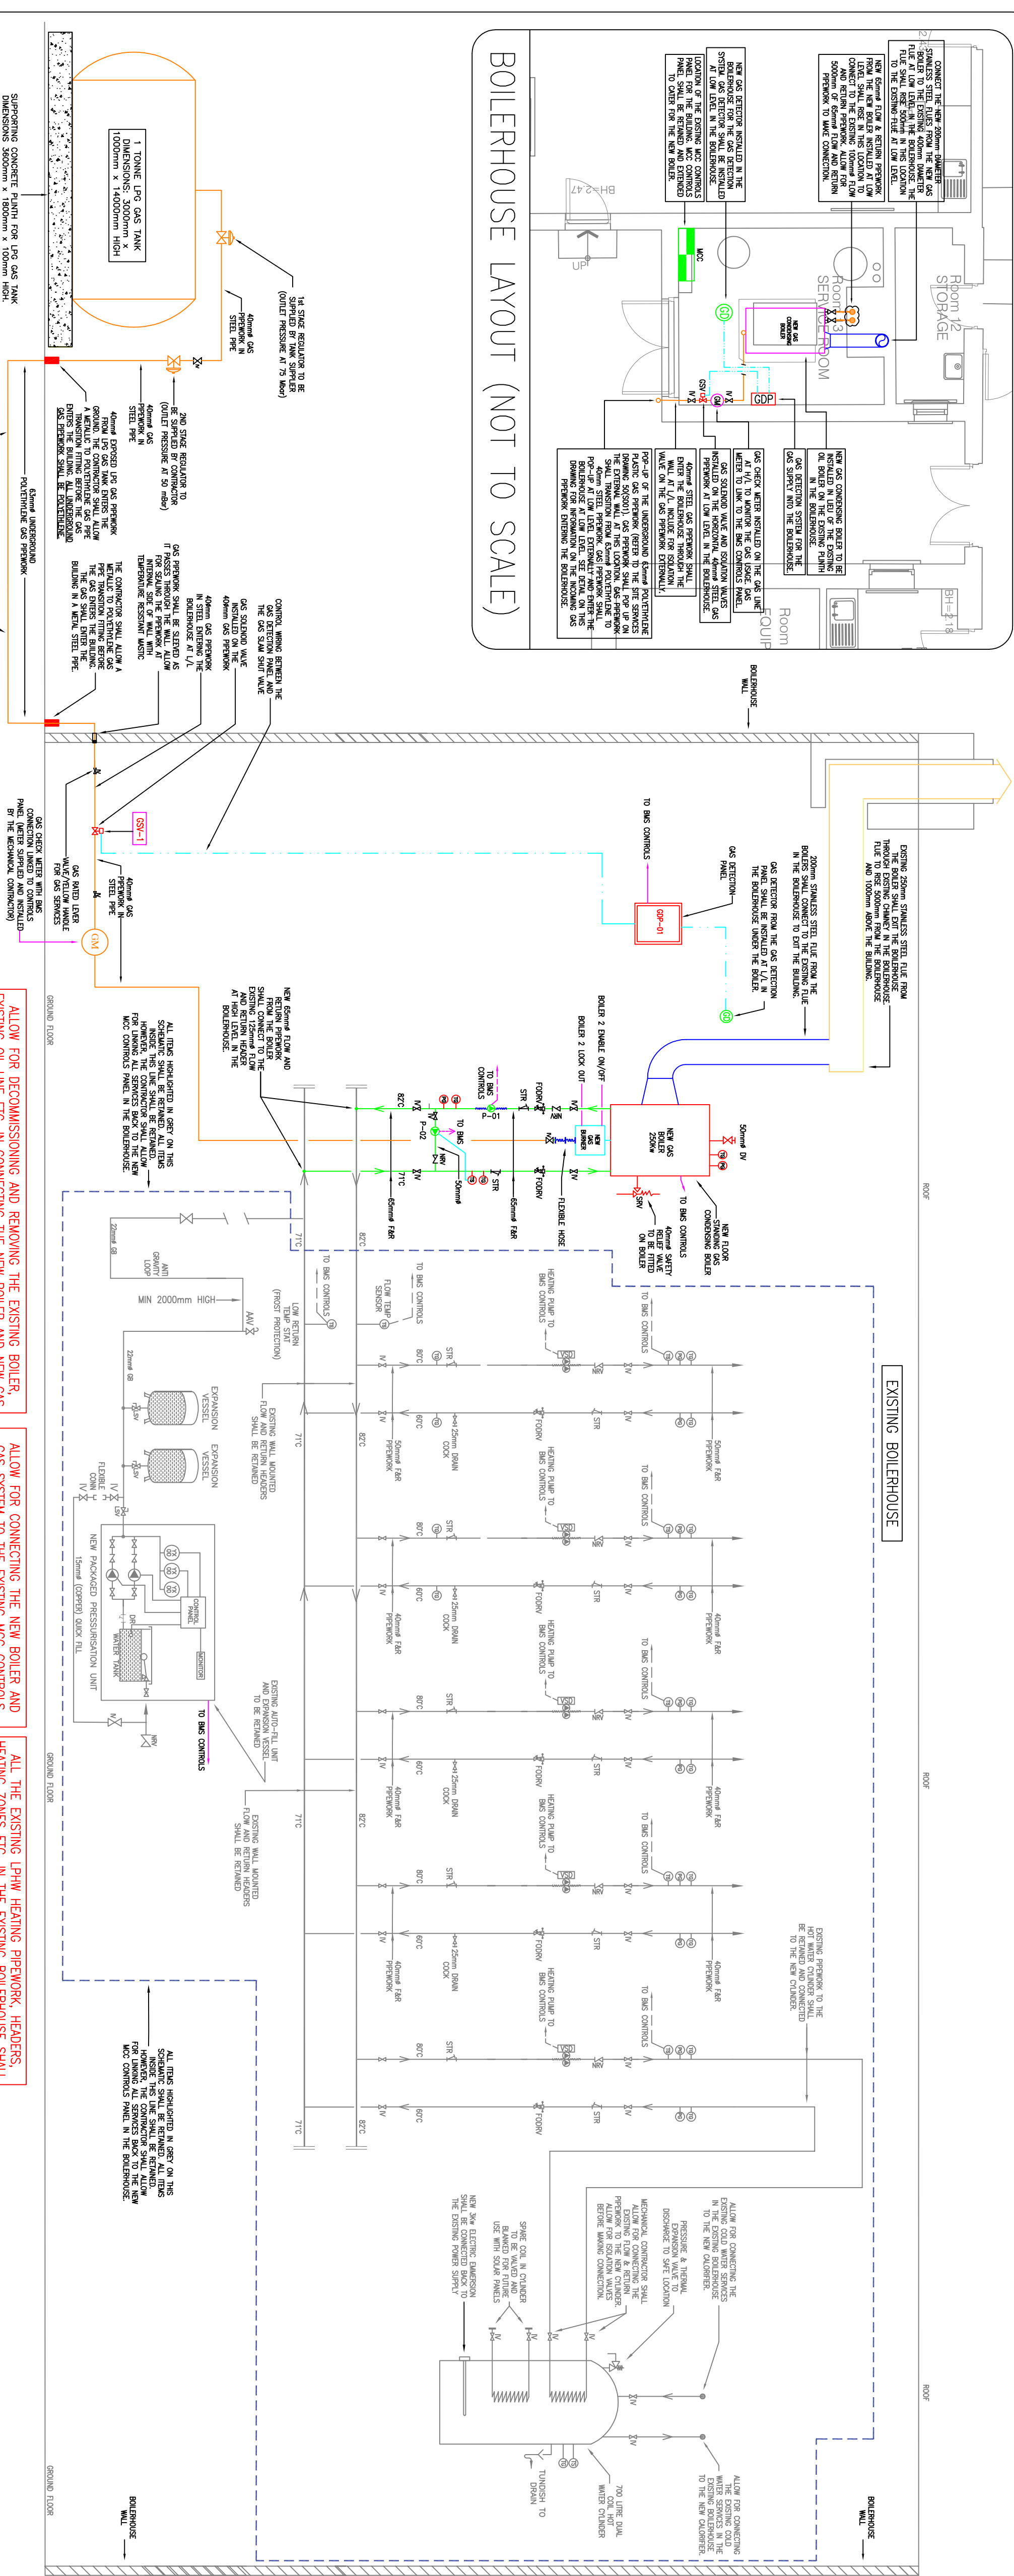


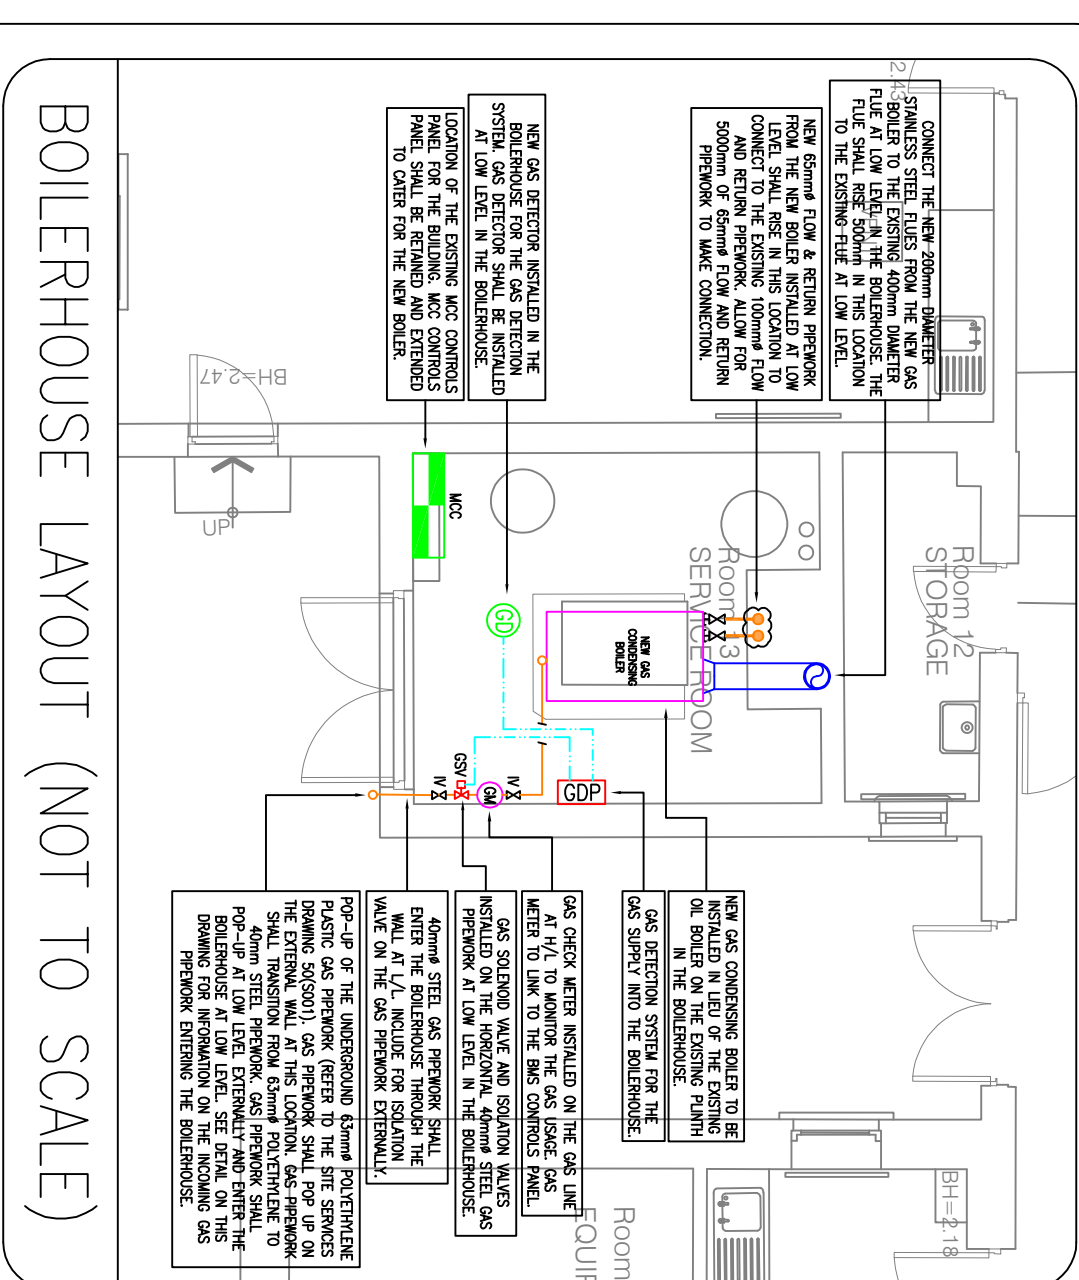

GENERAL NOTES:

- [illegible]

MECHANICAL SCHEMATIC NOTES


- [illegible]

MCC CONTROL NOTES:




- [illegible]

MCC CONTROLS SCHEMATIC LEGENDS AND SYMBOLS

	TS	TEMPERATURE SENSOR
	TS1	TEMPERATURE STAT
	HS	HUMIDITY SENSOR
	Paw	PRESSURE DETECTION SWITCH
	DS1	FROST CONTROL THERMOSTAT
	DM	MOISTURE DAMPER
	D/S	WIND/STANDBY SELECTOR SWITCH
	PF	PERFUM
	OUT	OUT-OF-HOURS PUSH BUTTON
	HP	HIGH PRESSURE
	LP	LOW PRESSURE
	HWS	HOT WATER SYSTEM
	SOL	SOLAR
	PW	POWER
	X	FIELD MOUNTED INSTRUMENT
	XV	PANEL MOUNTED INSTRUMENT
	R	RANGE
	SP	SET POINT
	GD	GAS DETECTOR
	MV	MOISTURED VALVE
	MAY	MOISTURED MAKING VALVE
	EM	ELECTRICITY METER
	QM	GAS METER
	WM	WATER METER
	CF	COMMON FAULT
	X	FUSE DISCONNECT SWITCH
	S	POWER AND CONTROL WIRING
	SD	VALUABLE SPEED DRIVE

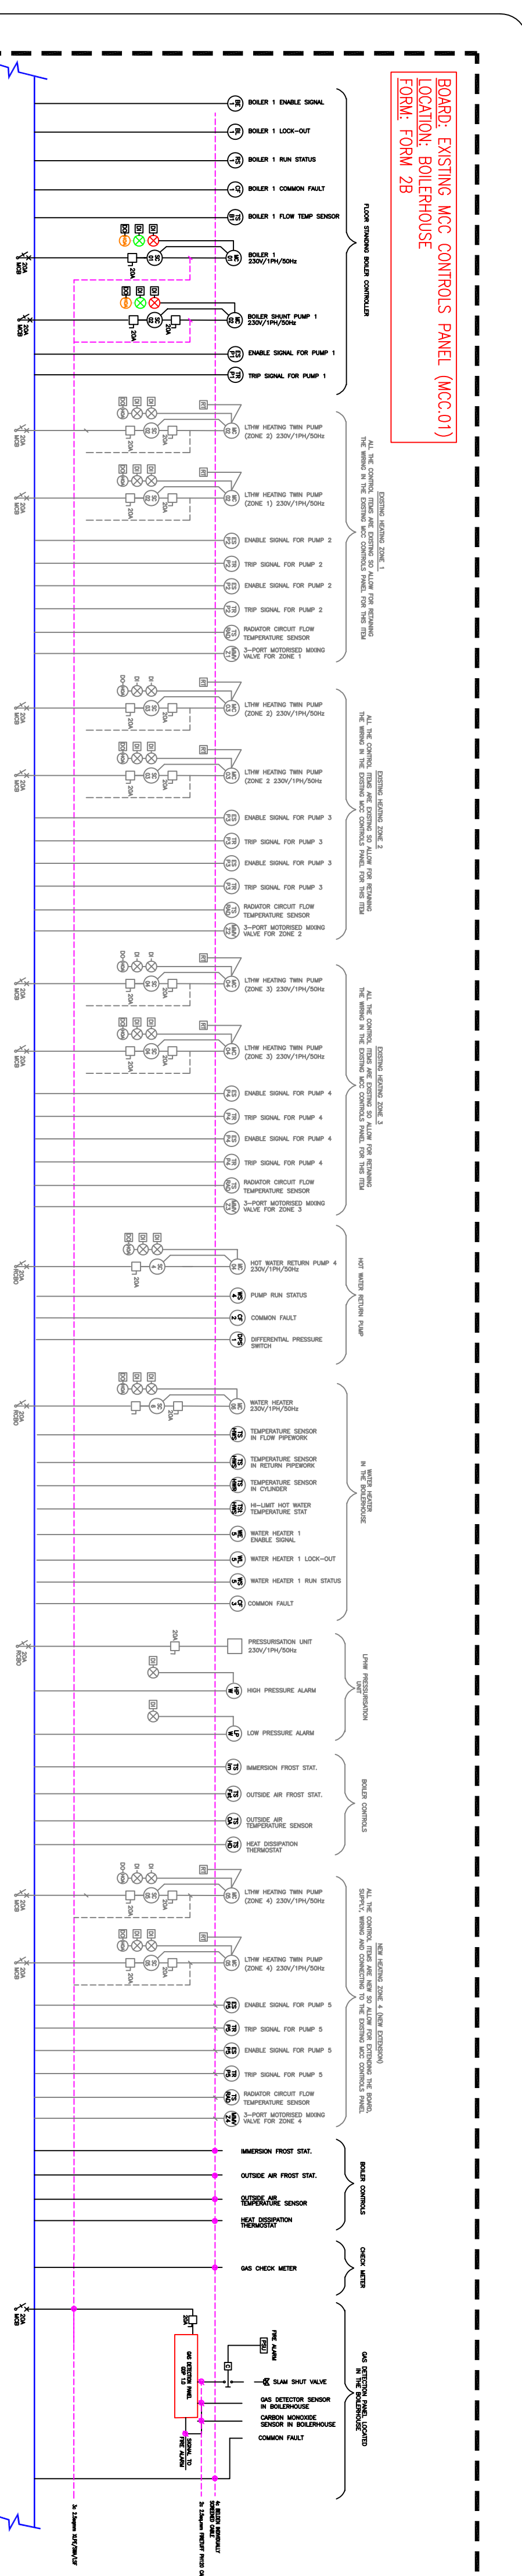

MECHANICAL MCC CONTROLS SCHEMATIC LAYOUT (NOT TO SCALE)

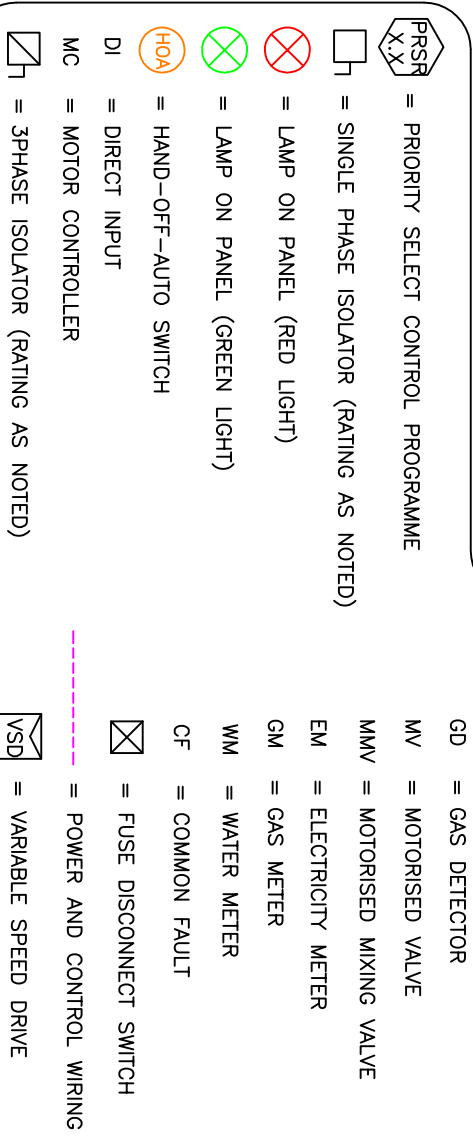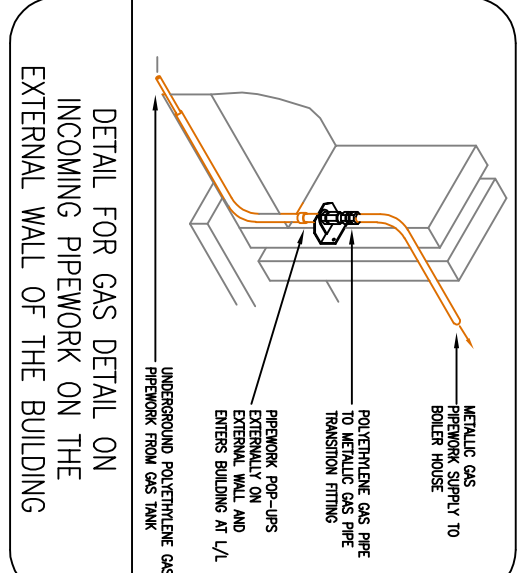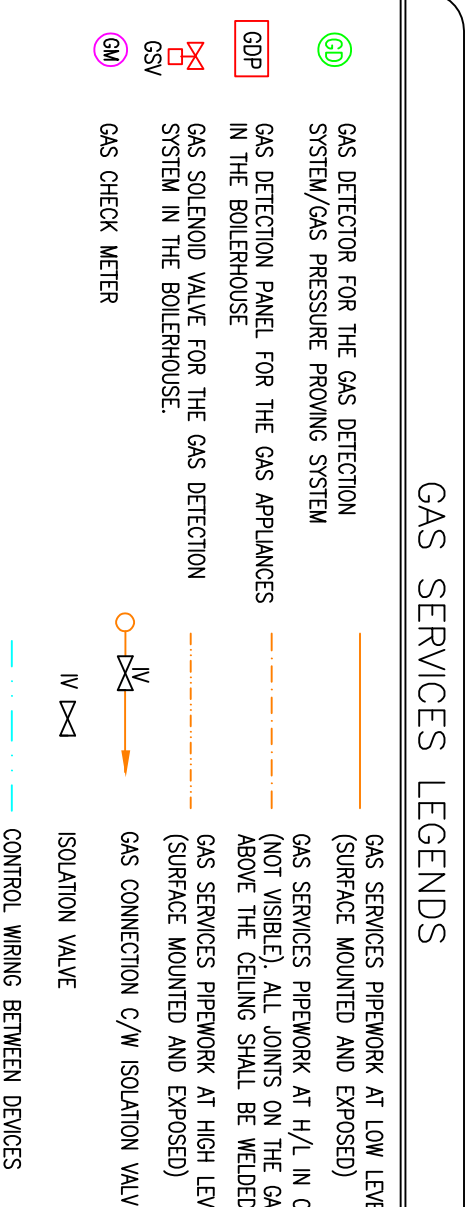

Job No.	Drawn By	Scale	Revised
21-008	JOS	AS INDICATED	T



GALLEO ENERGY SERVICE

UNIT A6, M4 BUSINESS PARK,
CELBRIDGE, CO. KILDARE.
Tel: 01-6274103
www.galleoenergy.ie

Copyright © 2008 Galleo Energy Service Ltd.

Architect	Client	Drawn Status	Job Title
McLOUGHLIN ARCHITECTURE Unit 4B, Elm House Corkillade, Ireland	22.06.26 J. O'SULLIVAN	TENDER	KILMACANOGUE, N.S. KILMACANOGUE, BRAY, CO. WICKLOW.

Drawing Title

BOILERHOUSE AND MCC CONTROL SCHEMATIC LAYOUT.

Maker	Date	Prepared By	Product Engineer	Quality Check By
MAE CONSULTANT	22.06.26	J. O'SULLIVAN	G. BENNORR	