
NOTES:

1. THIS DRAWING SHALL BE READ IN CONJUNCTION WITH ALL MECHANICAL, ELECTRICAL, ARCHITECTURAL AND STRUCTURAL DRAWINGS & SPECIFICATIONS.
2. THE ELECTRICAL CONTRACTOR SHALL CO-ORDINATE ALL SERVICES FULLY WITH ALL TRADES

3. DO NOT SCALE THIS DRAWING. ALL DIMENSIONS SHALL BE TAKEN ON SITE.
4. THE ELECTRICAL CONTRACTOR SHALL BE RESPONSIBLE FOR PROVIDING ALL NECESSARY INFORMATION TO ALLOW PROPER CO-ORDINATION OF ALL SERVICES.
5. EXTRA COSTS INCURRED DUE TO THE CO-ORDINATION EXERCISE NOT BEING COMPLETED WILL BE THE RESPONSIBILITY OF THE ELECTRICAL CONTRACTOR.

6. EXACT LOCATION OF ALL SERVICES SHALL BE AGREED WITH THE EMPLOYERS REPRESENTATIVE PRIOR TO COMMENCEMENT ON SITE.

7. ALL SERVICES AS SHOWN ON THE DRAWING SHALL BE INCLUDED IN THE FINAL TENDER PRICE


8. SAMPLE OF ALL EQUIPMENT SHALL BE APPROVED BY CLIENT, ARCHITECT AND BUILDING SERVICES ENGINEER PRIOR TO ORDERING.

9. ALL DIMENSIONS IN MILLIMETRES UNLESS STATED OTHERWISE.


FIRE ALARM & DETECTION LEGEND:

746	EXISTING FIRE ALARM PANEL
-----	---------------------------



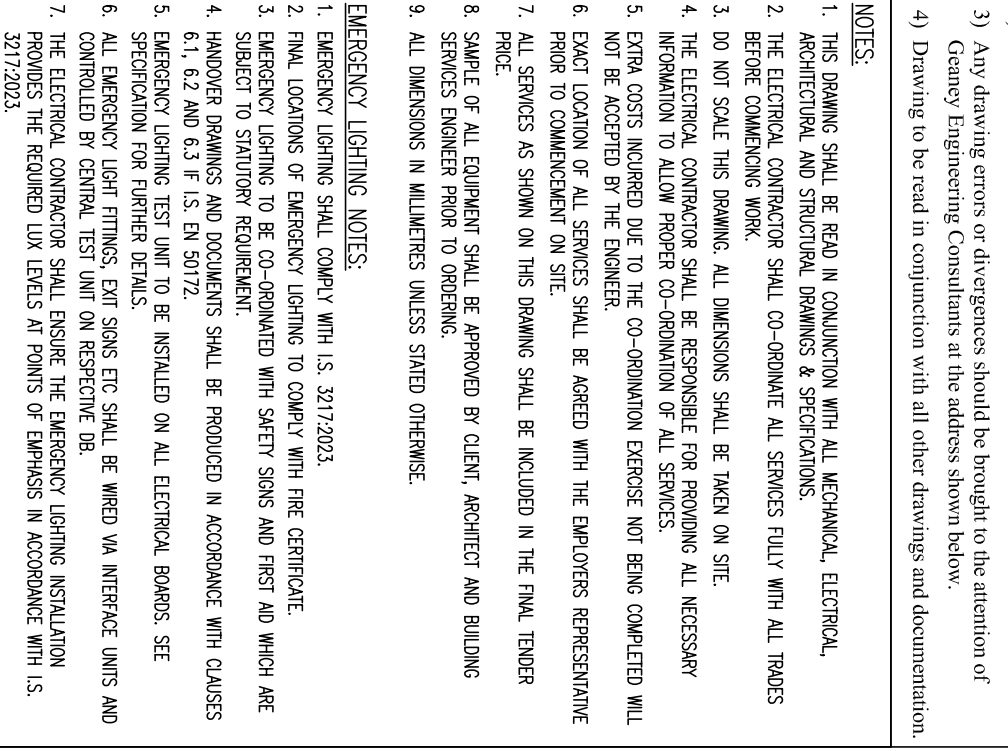

3)	Any drawing orders or requests should be brought to the attention of Client Engineering Consultants at the address shown below.
4)	Drawing to be used in conjunction with all other drawings and documentation.
NOTES:	
1)	THE DRAWING SHALL BE READ IN CONJUNCTION WITH ALL MECHANICAL, ELECTRICAL, PNEUMATICAL AND STRUCTURAL DRAWINGS & SPECIFICATIONS.
2)	REFER TO THE DRAWING INDEX TO LOCATE ALL SERVICES TIED WITH ALL PROGS.
3)	TO USE THIS DRAWING, ALL DRAWINGS SHALL BE OPENED ON SITE.
4)	THE ELECTRICAL COMPANOR SHALL BE RESPONSIBLE FOR PROVIDING ALL NECESSARY INFORMATION TO ALLOW PROPG TO COMPLY WITH ALL NECESSARY
5)	PROPG SHALL OBTAIN THE CO-ORDINATION SERVICES WITH OTHER COMPETITOR WILL BE NOT ACCEPTED BY THE CLIENT.
6)	ALL DRAWINGS SHALL BE ISSUED WITH THE DRAWING REPRESENTATIVE
7)	ALL SERVICES SHOWN ON THE DRAWING SHALL BE INCLUDED IN THE FINAL TENDER PRICE.
8)	STATUS OF ALL EQUIPMENT SHALL BE APPROVED BY CLIENT AGENTS AND BLINDING
9)	ALL SERVICES SHOWN SHALL BE PREPARED BY CLIENT AGENTS

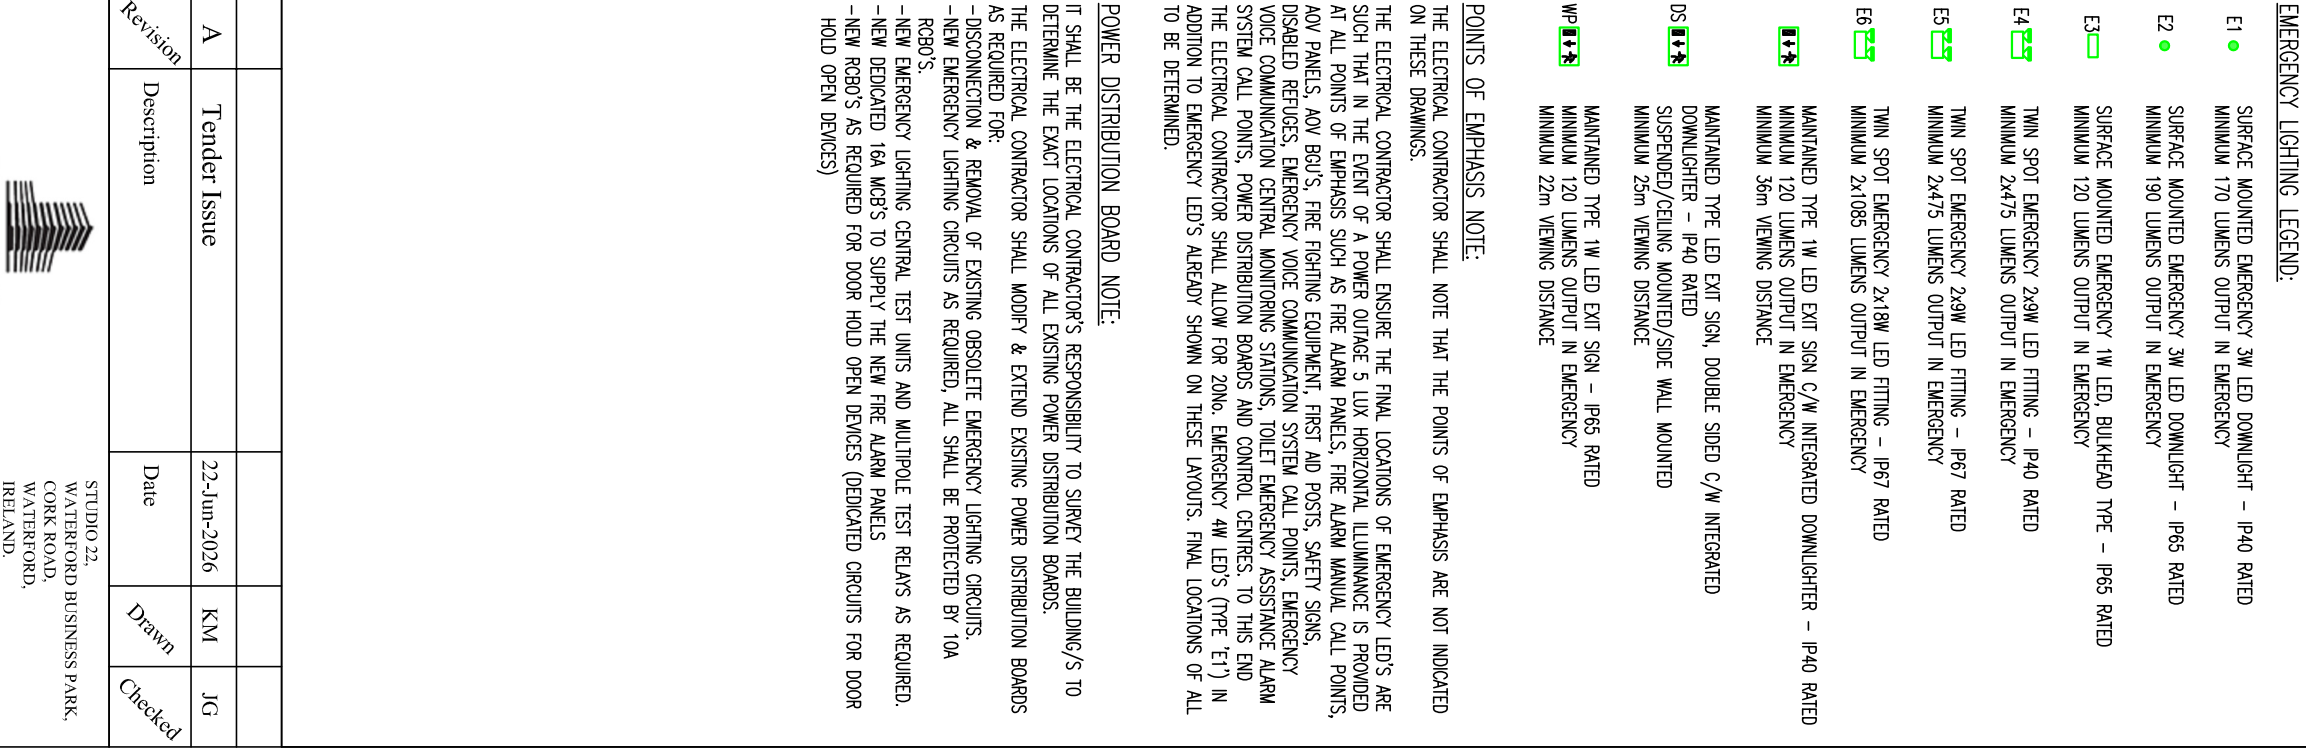

A	Tender Issue	22-Jun-2026	KM	JG
Revision	Description	Date	Drawn	Checked

**GEANEY
ENGINEERING
CONSULTANTS**



STUDIO 22
1000 WEST 10TH AVENUE
SUITE 200
CORK ROAD
WATERFORD,
IRELAND

TEL: 051-809371
FAX: 051-853188
E-MAIL: info@geaney-engineering.ie

Life Safety and General Upgrade at
FET Templemore College
Tipperary

Proposed Emergency Lighting Floor Plan Layout


scale:
1:150 @A1

architect: N/A

project number:	drawing number:
-----------------	-----------------

0834	Volume 3.3 - EL101
------	--------------------

DENSTALLATION NOTES:
THE ELECTRICAL CONTRACTOR SHALL ALLOW FOR DISCONNECTING & REMOVING OFF SITE ALL EXISTING EMERGENCY LIGHTING FITTINGS IN THE SCHOOL - BUILDINGS TOGETHER WITH ALL OBSOLETE CABLING, CONTAINMENT, FIXINGS & SUPPORTS
THE EXISTING EMERGENCY LIGHTING INSTALLATION IS NOT INDICATED ON THIS DRAWING. IT SHALL BE THE ELECTRICAL CONTRACTORS RESPONSIBILITY TO CARRY OUT A SURVEY TO TRACE AND IDENTIFY ALL EXISTING EMERGENCY LIGHTING SERVICES WITHIN THE AREAS OF WORKS.
THE ELECTRICAL CONTRACTOR IS STRONGLY RECOMMENDED TO VISIT SITE PRIOR TO TENDER TO SURVEY THE AREAS OF WORKS AND FAMILIARISE THEMSELVES WITH THE SCOPE OF WORK INVOLVED WITH THE ABOVE AND ALL OTHER WORKS INDICATED ON THIS DRAWING AND THE ACCOMPANYING DRAWINGS TO ENSURE THAT ALL DUE ALLOWANCES AND NECESSARY COSTS ARE ACCOUNTED FOR IN THEIR TENDER SUBMISSION - ADDITIONAL COSTS INCURRED DUE TO THIS EXERCISE NOT BEING CARRIED OUT WILL NOT BE ACCEPTED.
WHEN THE EXISTING EMERGENCY LIGHTING SYSTEM IS DECOMMISSIONED AND REMOVED, INCLUDING CONTAINMENT SYSTEM, ALL EXISTING SURFACES AFFECTED SHALL BE MADE GOOD AND PAINTED TO MATCH EXISTING DECOR.

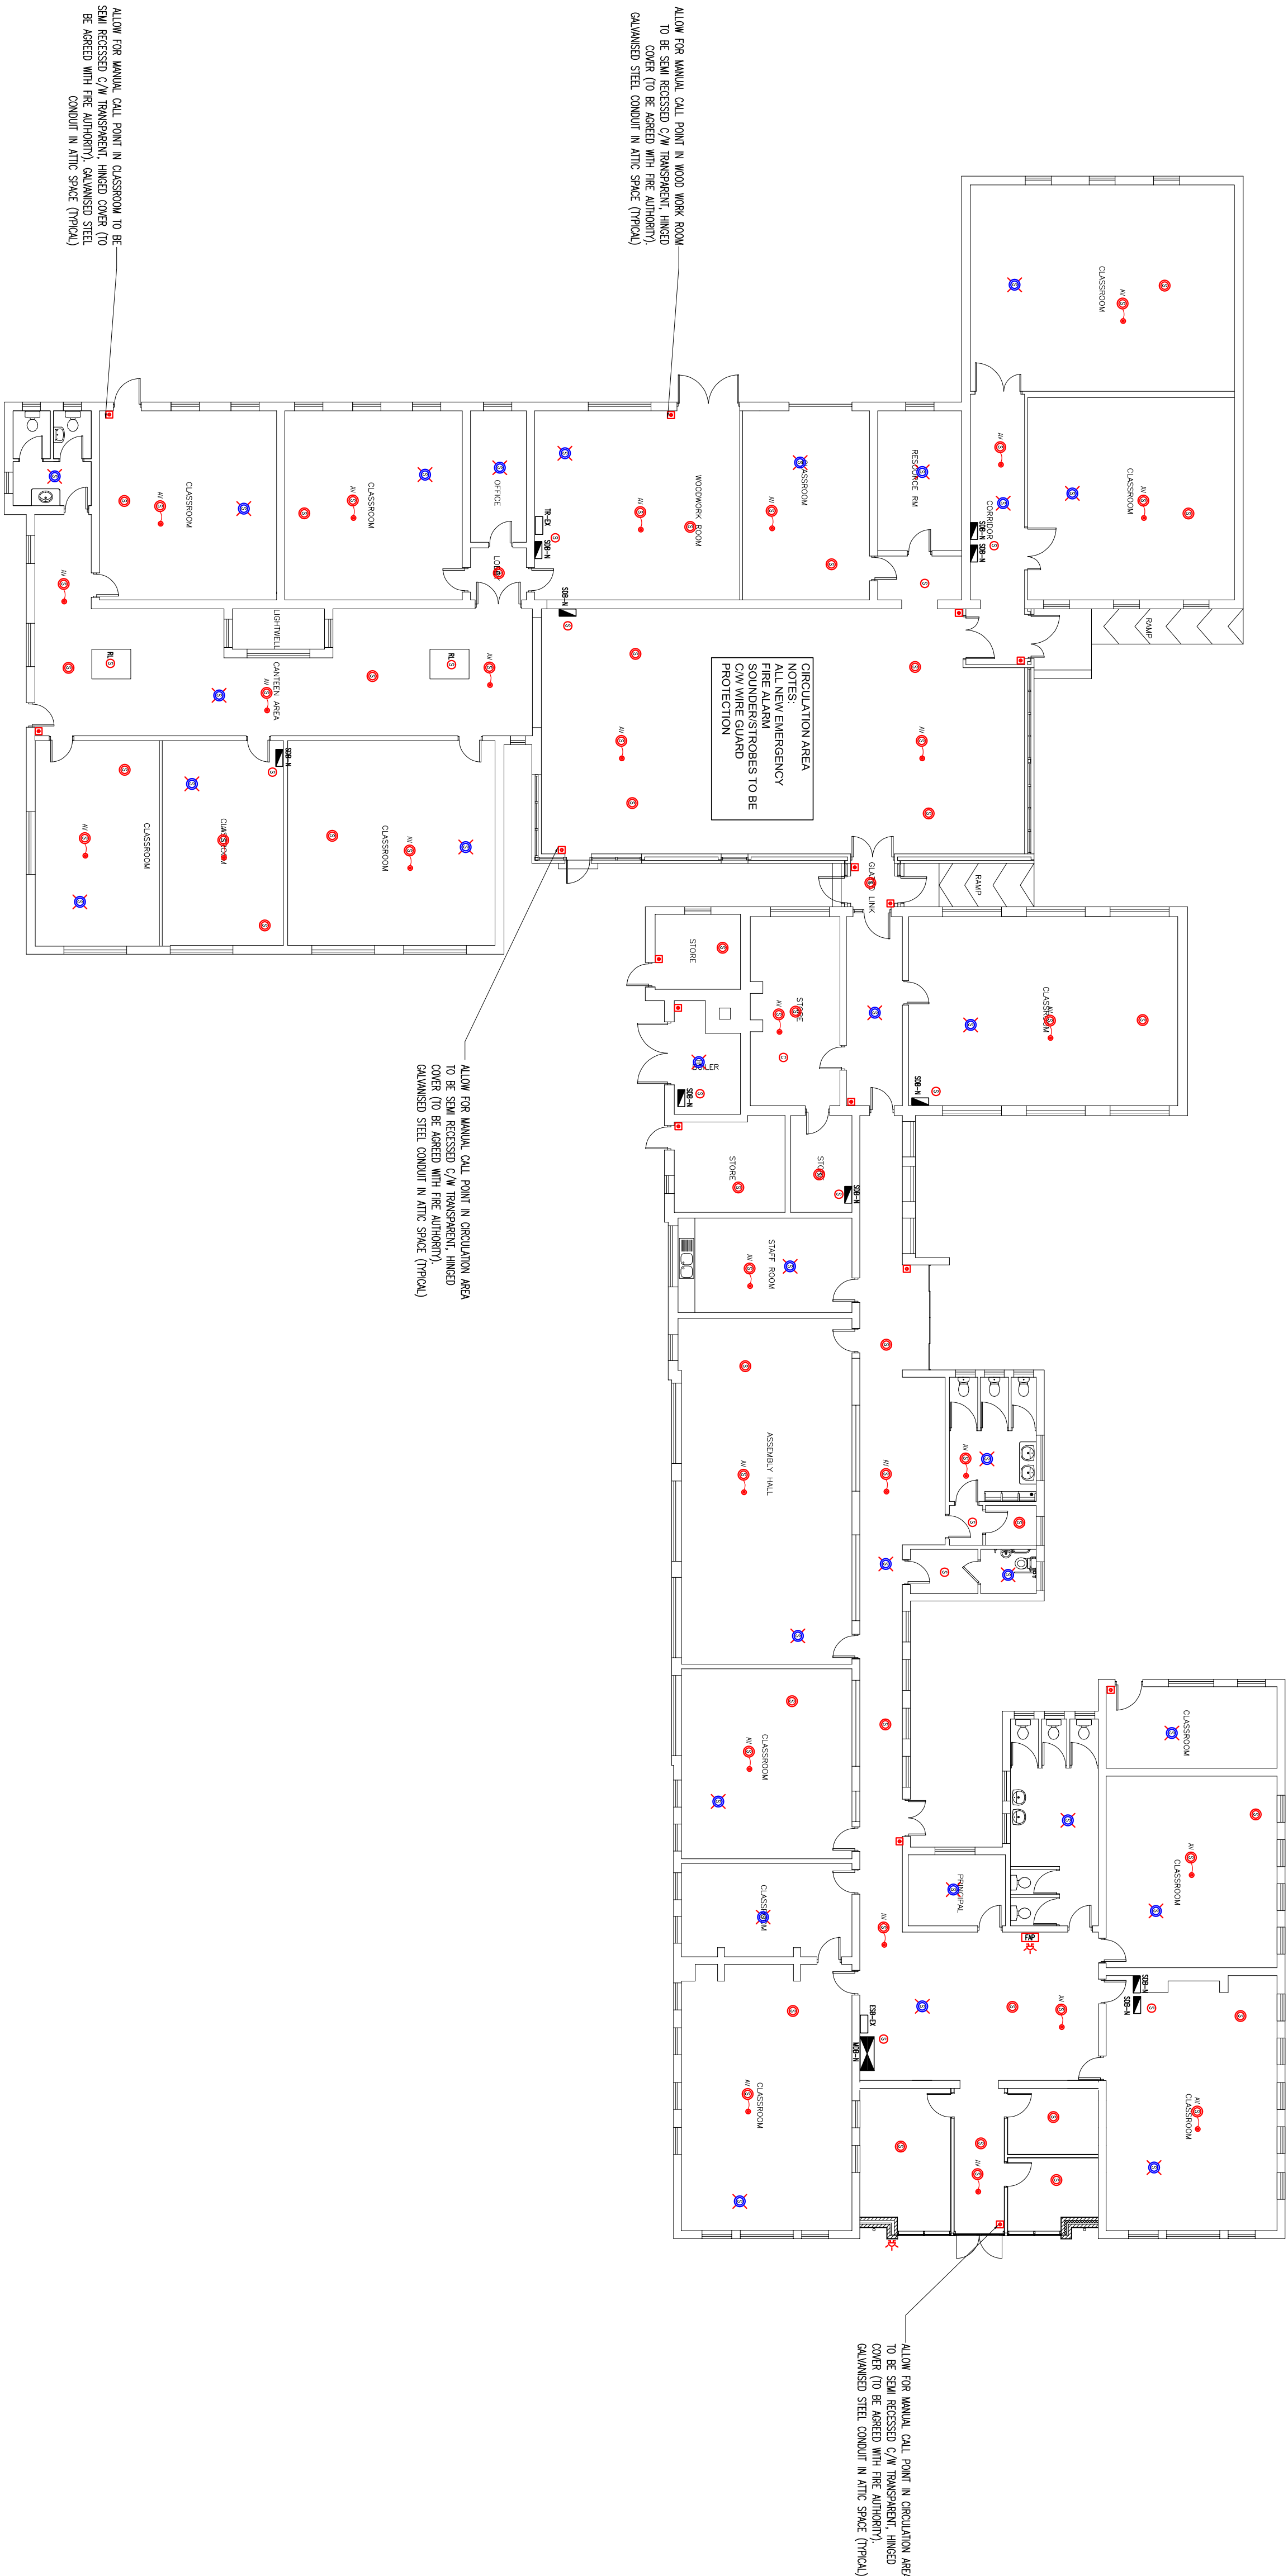

GENERAL NOTES

- 1) Do not scale services equipment from this drawing
- 2) All dimensions should be checked on site
- 3) Any drawings or other documents should be brought to the attention of Geaney Engineering Consultants at the address shown below.
- 4) Drawing to be read in conjunction with all other drawings and documentation.

NOTES:

- 1. THIS DRAWING SHALL BE READ IN CONJUNCTION WITH ALL MECHANICAL, ELECTRICAL, ARCHITECTURAL AND STRUCTURAL DRAWINGS & SPECIFICATIONS.
- 2. THE ELECTRICAL CONTRACTOR SHALL CO-ORDINATE ALL SERVICES FITLY WITH ALL TRADES AND SERVICES SHOWN ON THIS DRAWING.
- 3. DO NOT SCALE FROM DRAWING. ALL DIMENSIONS SHALL BE TAKEN ON SITE.
- 4. THE ELECTRICAL CONTRACTOR SHALL BE RESPONSIBLE FOR PROVIDING ALL NECESSARY INFORMATION TO ALLOW PROPER CO-ORDINATION OF ALL SERVICES.
- 5. EXTRA COSTS INCURRED DUE TO THE CO-ORDINATION EXERCISE NOT BEING COMPLETED WILL NOT BE ACCEPTED BY THE ENGINEER.
- 6. PRIOR TO COMMENCING WORK, THE CONTRACTOR SHALL BE AGREED WITH THE EMPLOYERS REPRESENTATIVE FOR THE COMMUNICATION OF ALL SERVICES.
- 7. ALL SERVICES AS SHOWN ON THIS DRAWING SHALL BE INSTALLED IN THE FINAL TENDER PRICE.
- 8. SURFACE OF ALL EQUIPMENT SHALL BE APPROVED BY CLIENT, ARCHITECT AND BUILDING SURVEYOR.
- 9. ALL DIMENSIONS IN MILLIMETRES UNLESS STATED OTHERWISE.

FIRE ALARM & DETECTION LEGEND:

- EXISTING FIRE ALARM PANEL
- EXISTING SMOKE DETECTOR
- EXISTING SURFACE MOUNTED EMERGENCY LIGHT
- EXISTING RAINING MAN

Revision	Description	Date	Drawn	Checked
A	Tender Issue	22-Jan-2024	KM	JG

GEANEY ENGINEERING CONSULTANTS

STATION 22, CO. DUBLIN BUSINESS PARK,
CO. DUBLIN
WATERFORD,
IRELAND
TEL: 051-439271
FAX: 051-438188
EMAIL: info@geaneyengineering.ie

Project title:
**Life Safety and General Upgrade at
FET Templemore College
Tipperary**

Drawing title:

**Proposed Emergency Lighting
Floor Plan Layout**

Scale:
1:150 @A1

Architect:
NA

Project number:
0834

Drawing number:
Volume 3.3 - EL102

DEINSTALLATION NOTES:

THE ELECTRICAL CONTRACTOR SHALL ALLOW FOR DISCONNECTING & REMOVING OFF SITE ALL EXISTING EMERGENCY LIGHTING FITTINGS IN THE SCHOOL BUILDINGS TOGETHER WITH ALL OBSOLETE CABLING, CONTAINMENT, FIXINGS & SUPPORTS

THE EXISTING EMERGENCY LIGHTING INSTALLATION IS NOT INDICATED ON THIS DRAWING. IT SHALL BE THE ELECTRICAL CONTRACTORS RESPONSIBILITY TO CARRY OUT A SURVEY TO TRACE AND IDENTIFY ALL EXISTING EMERGENCY LIGHTING SERVICES WITHIN THE AREAS OF WORKS.

THE ELECTRICAL CONTRACTOR IS STRONGLY RECOMMENDED TO VISIT SITE PRIOR TO TENDER TO SURVEY THE AREAS OF WORKS AND FAMILIARISE THEMSELVES WITH THE SCOPE OF WORK INVOLVED WITH THE ABOVE AND ALL OTHER WORKS INDICATED ON THIS DRAWING AND THE ACCOMPANYING DRAWINGS TO ENSURE THAT ALL DUE ALLOWANCES AND NECESSARY COSTS ARE ACCOUNTED FOR IN THEIR TENDER SUBMISSION. ADDITIONAL COSTS INCURRED DUE TO THIS EXERCISE NOT BEING CARRIED OUT WILL NOT BE ACCEPTED.

WHEN THE EXISTING EMERGENCY LIGHTING SYSTEM IS DECOMMISSIONED AND REMOVED, INCLUDING CONTAINMENT SYSTEM, ALL EXISTING SURFACES AFFECTED SHALL BE MADE GOOD AND PAINTED TO MATCH EXISTING DECOR.

NOTE:

MINIMUM 1.3m CLEAR SPACE REQUIRED IN FRONT OF ALL NEW POWER DISTRIBUTION BOARDS.
MAXIMUM HEIGHT TO THE TOP OF ALL NEW POWER DISTRIBUTION BOARDS SHALL BE 2.15m AFFL.

