




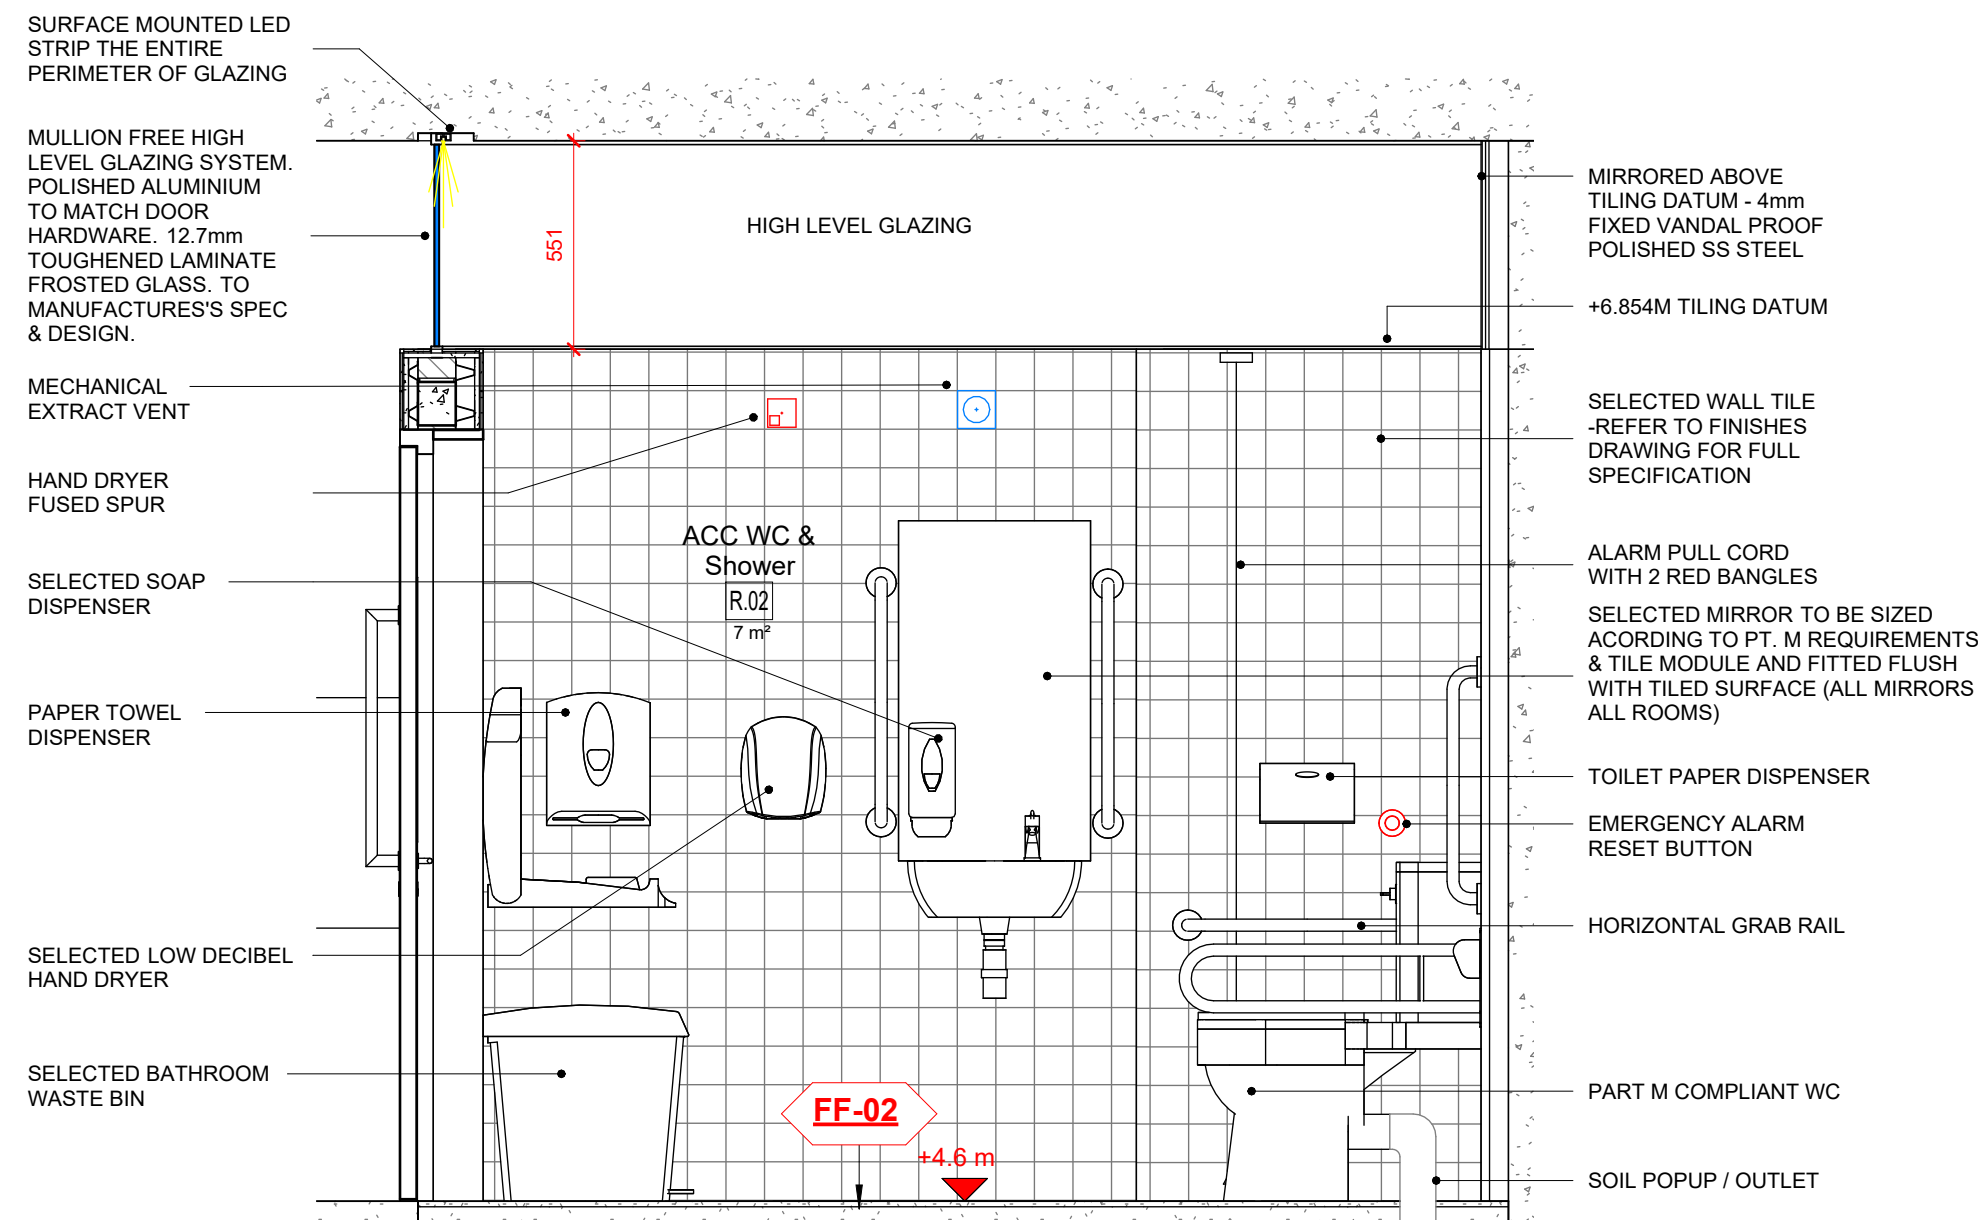


3 ELEVATION - A
Scale 1 : 20 @A1

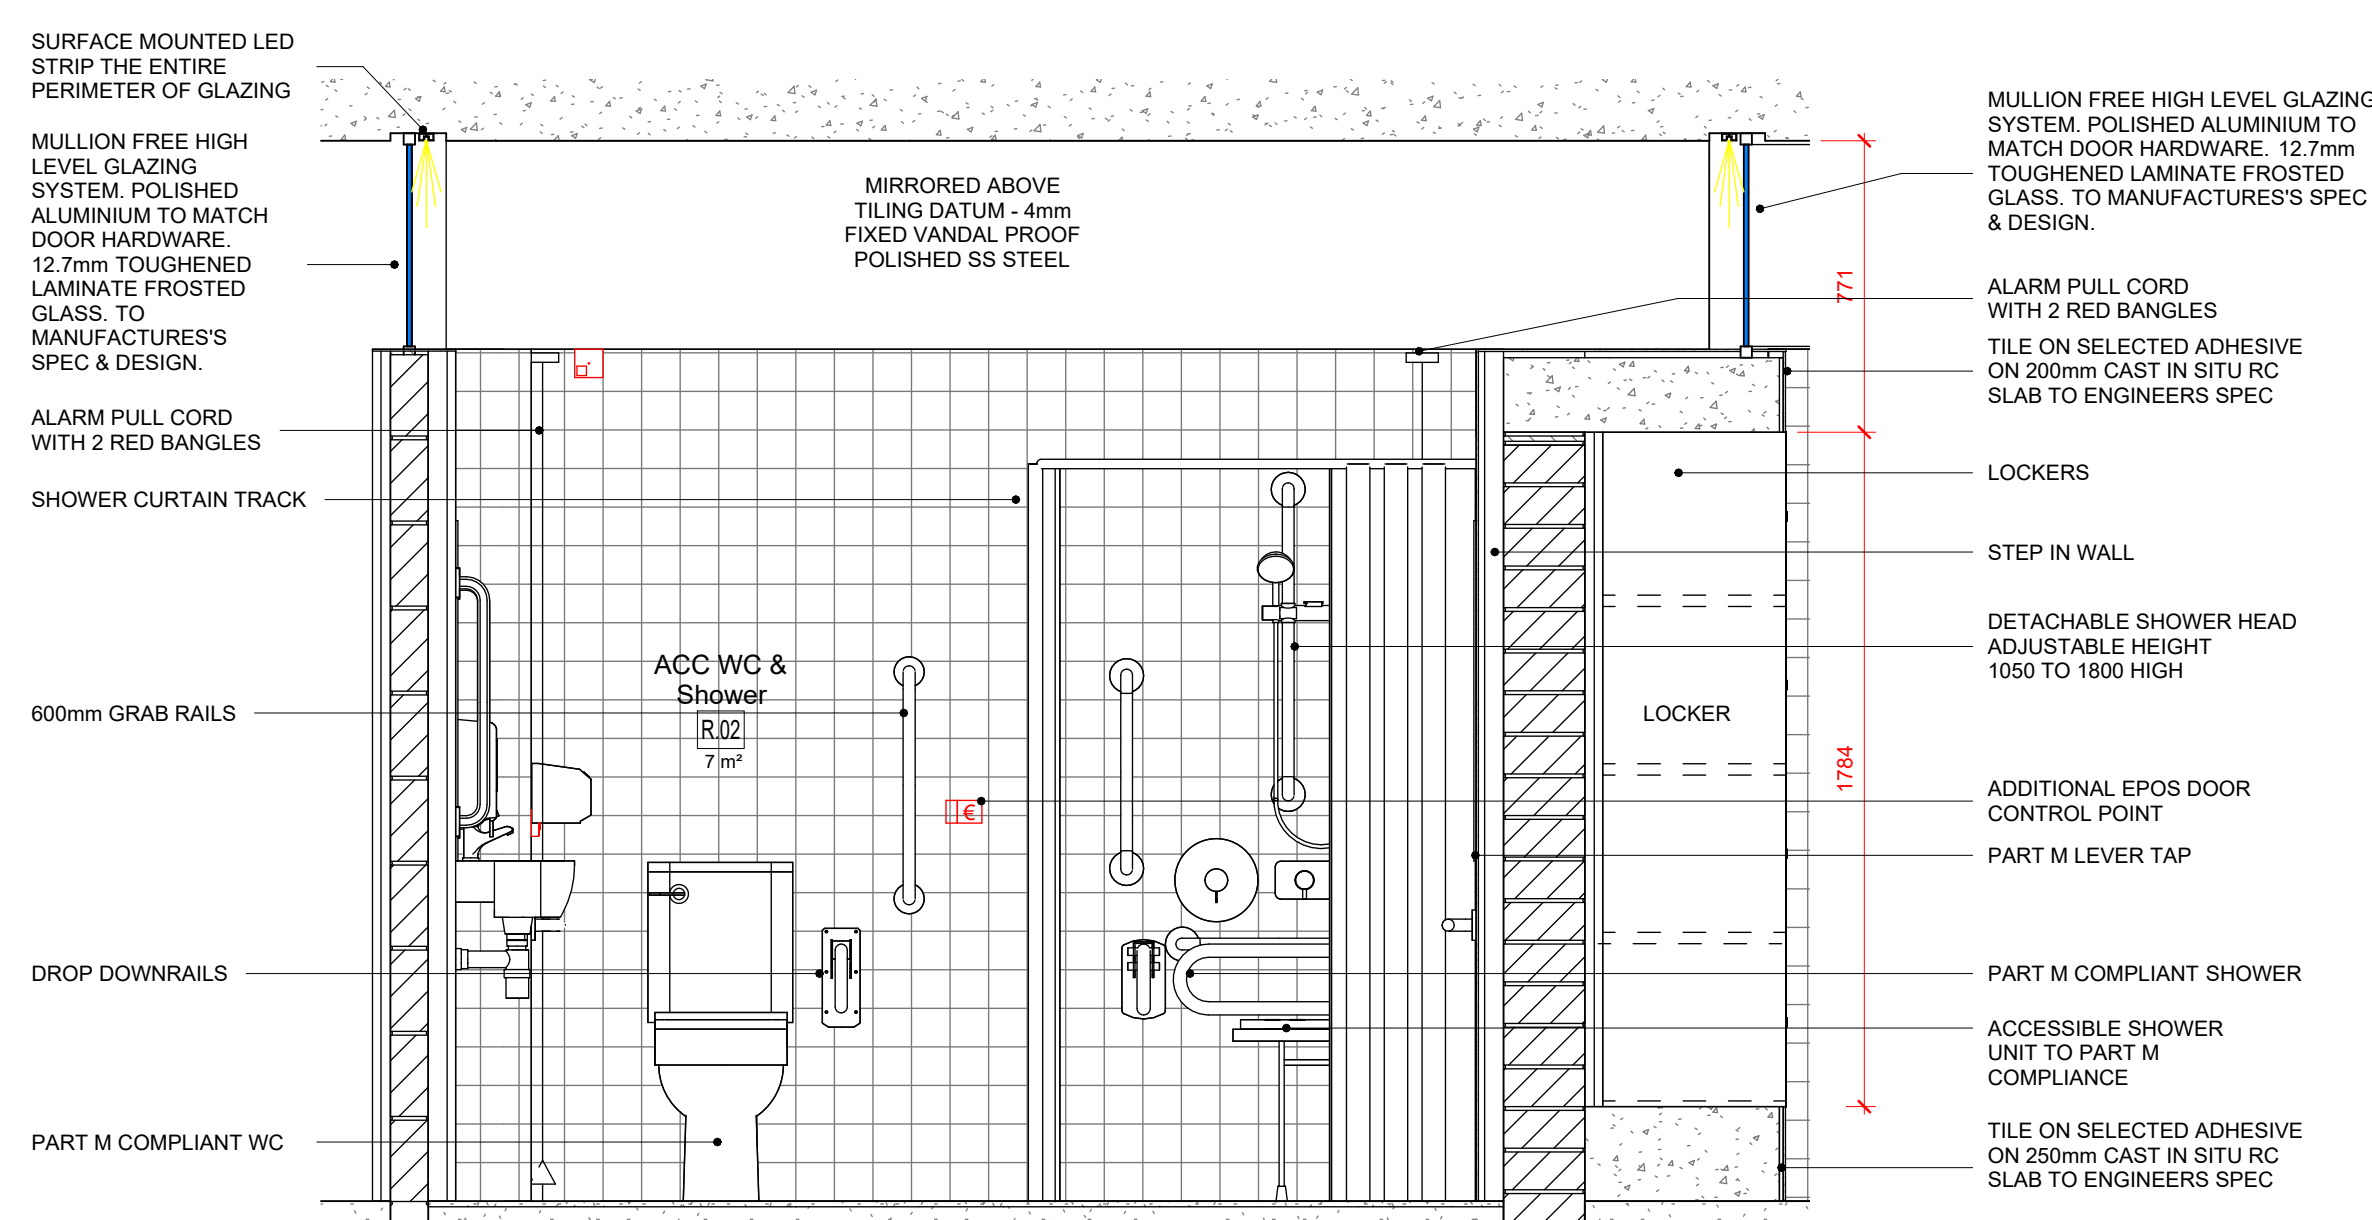


4 ELEVATION - B
Scale 1 : 20 @A1

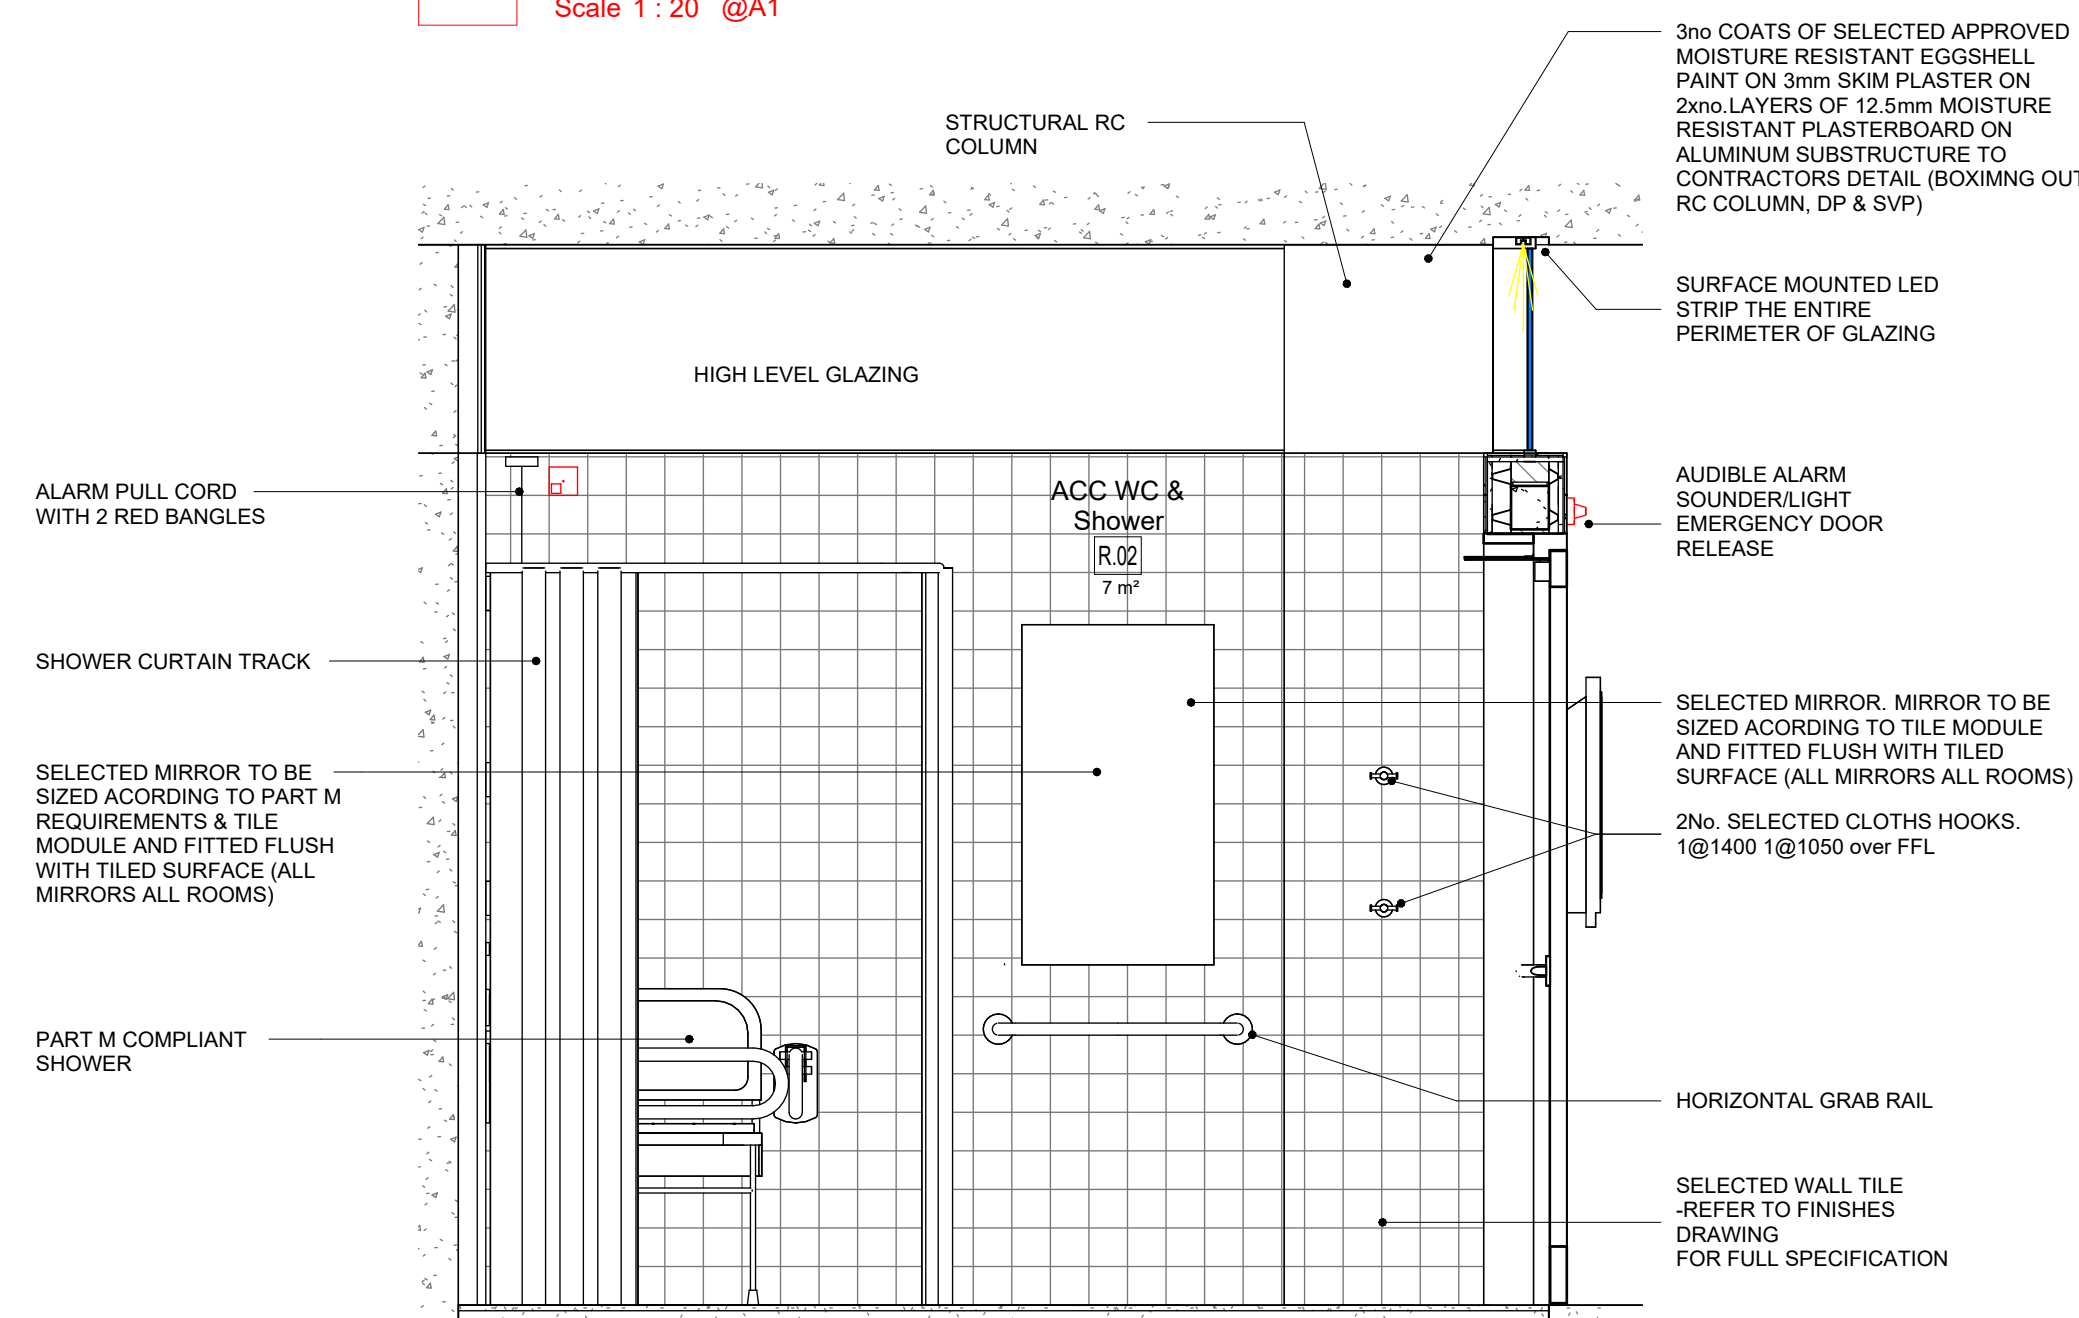


5 ELEVATION - C
Scale 1 : 20 @A1

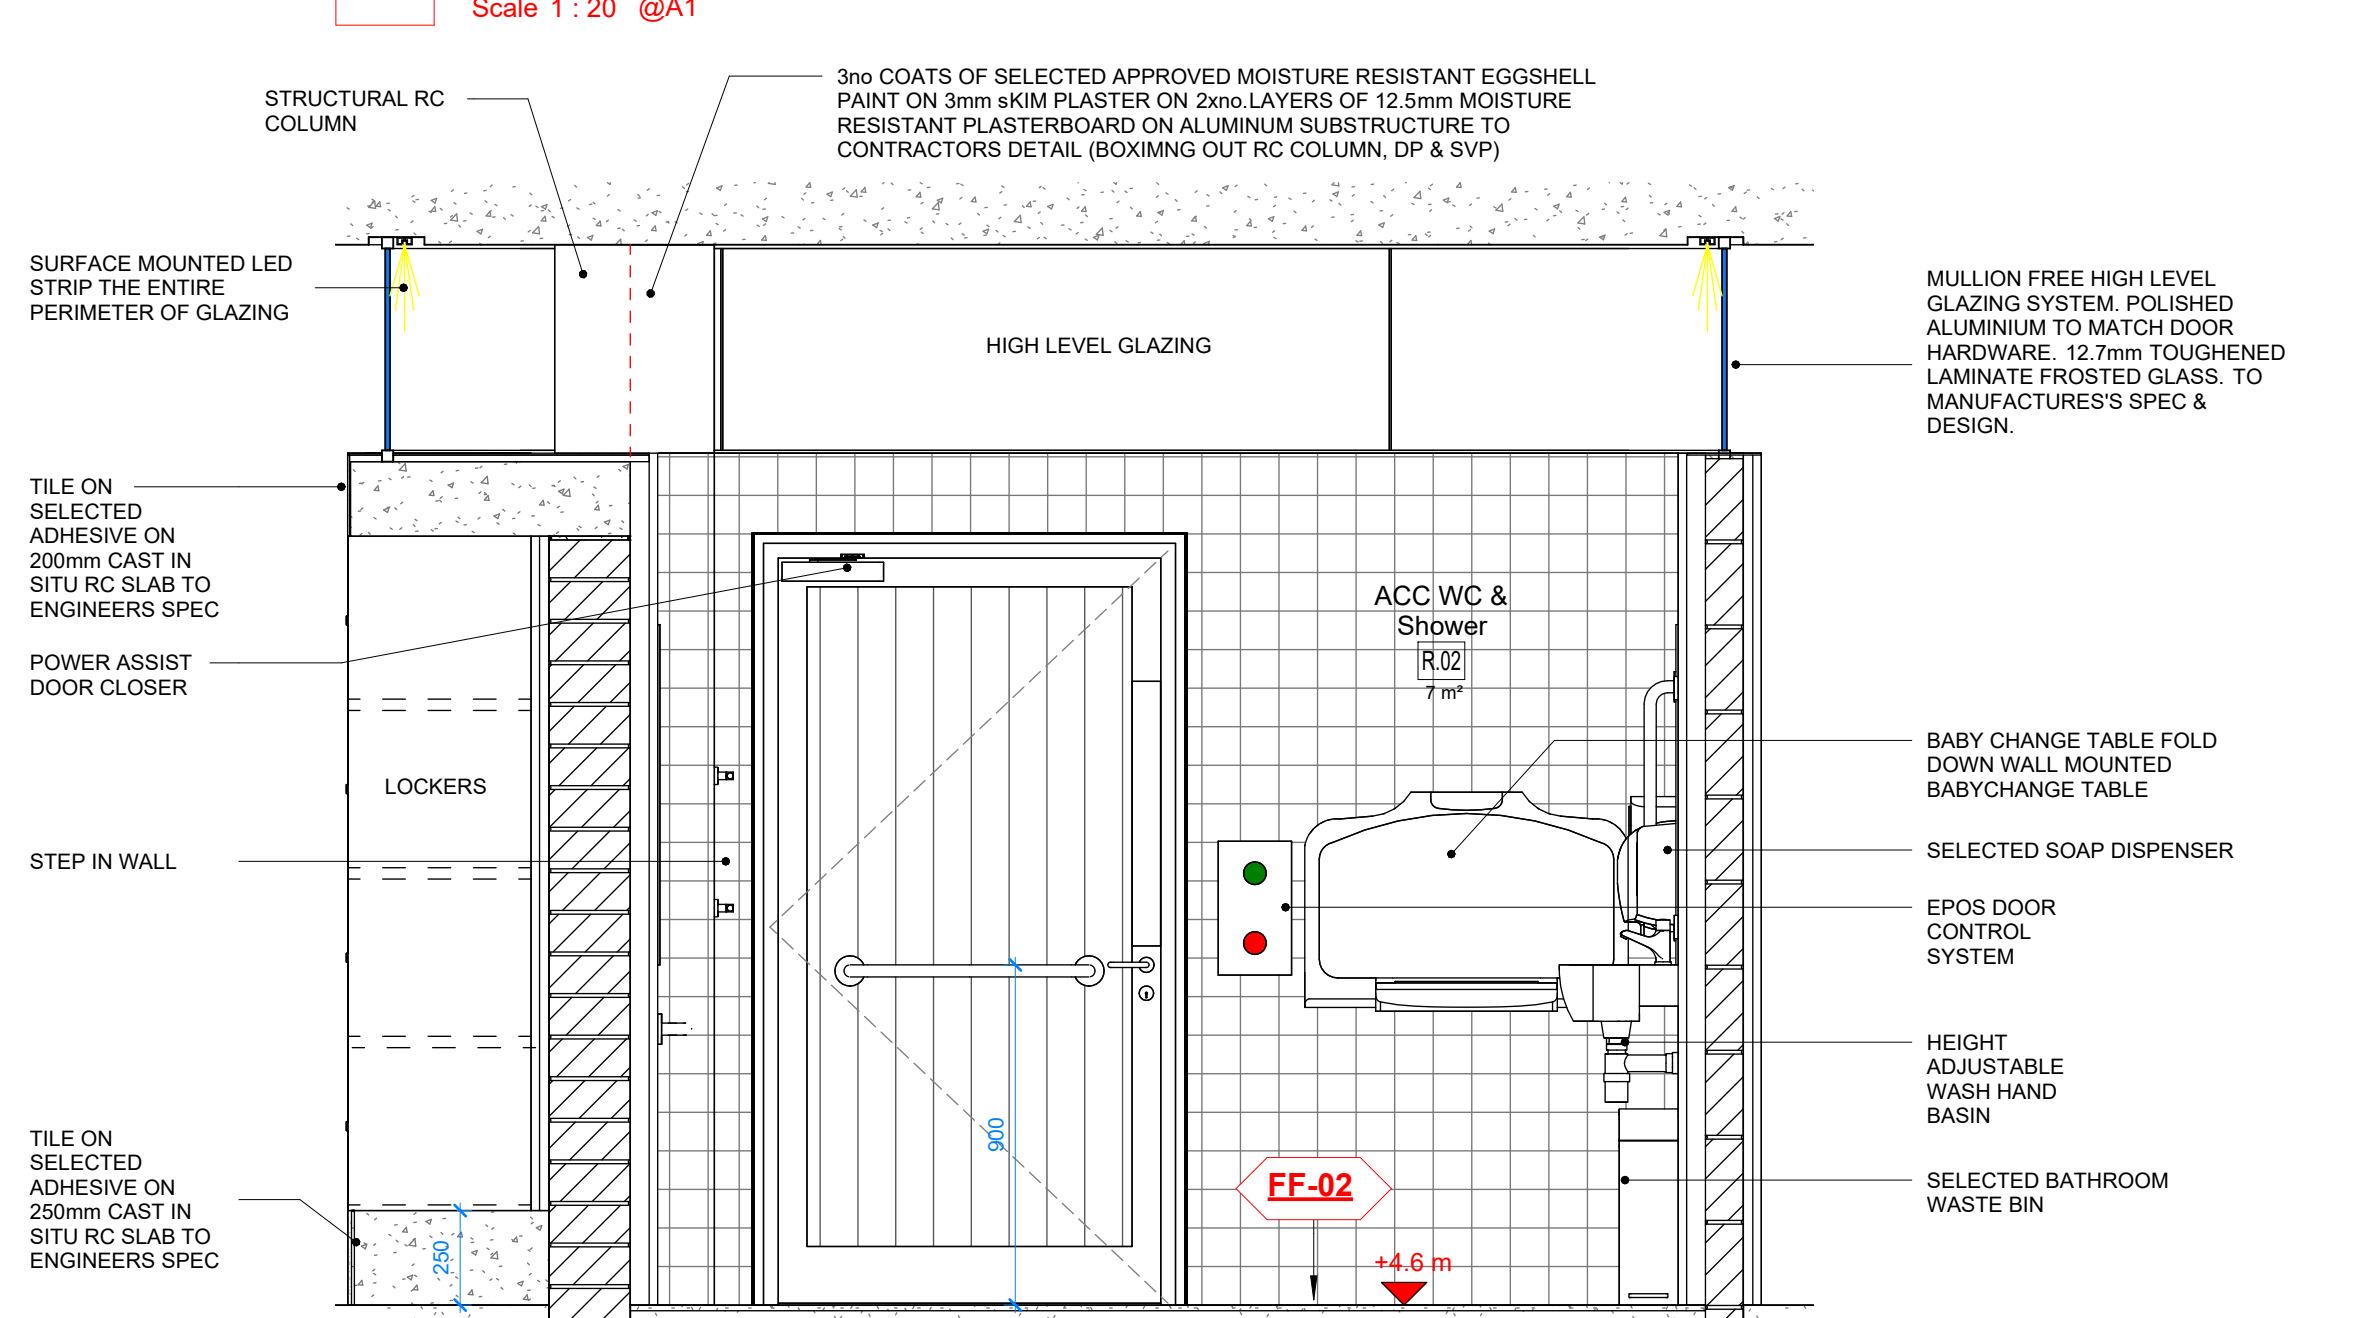

6 ELEVATION - D
Scale 1 : 20 @A1

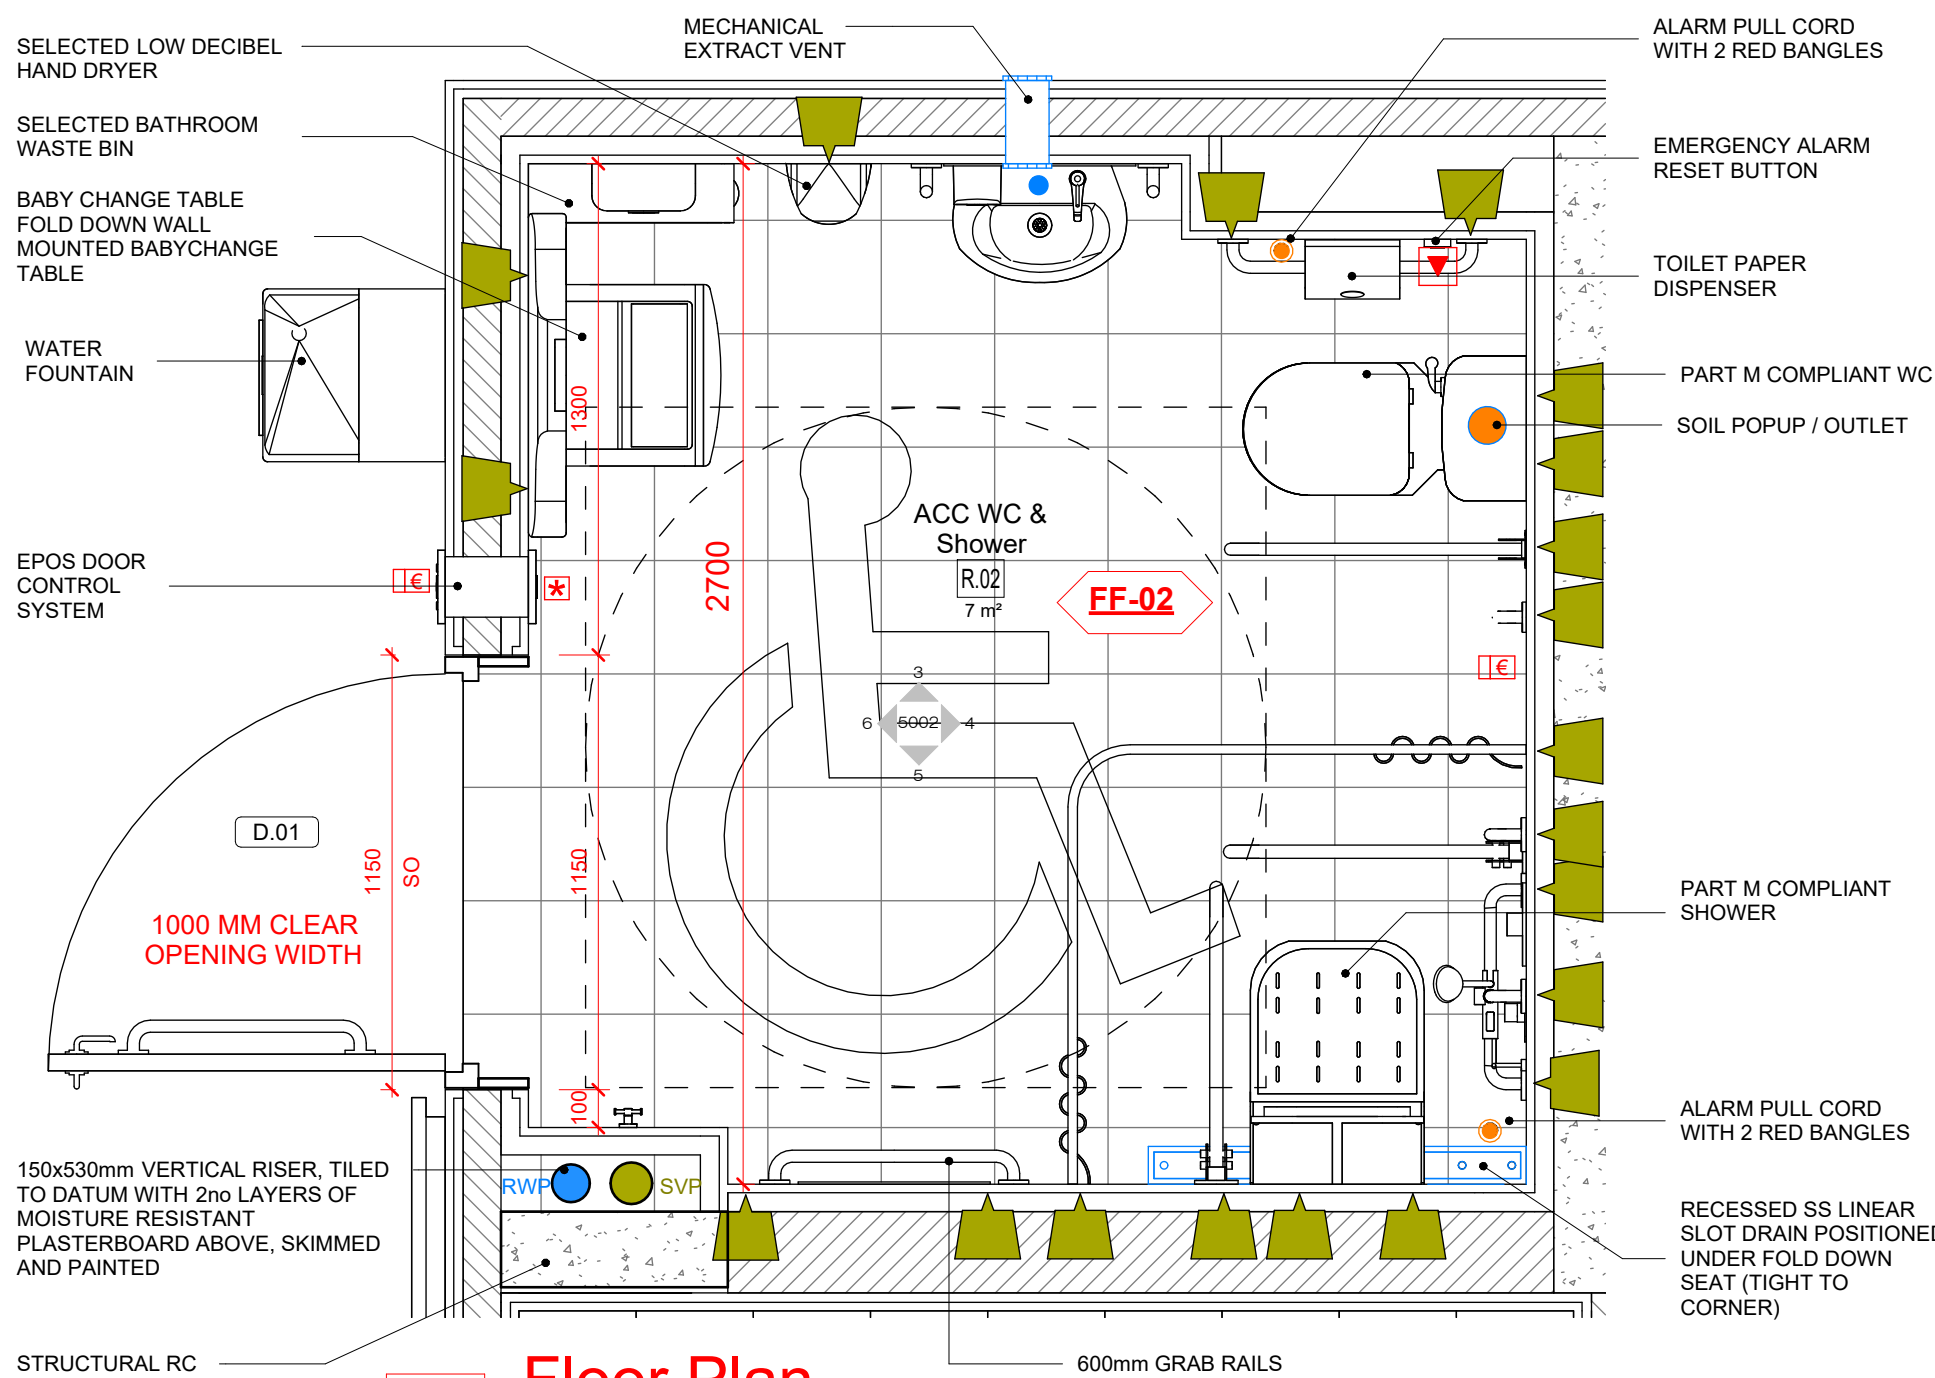

1 Floor Plan
Scale 1 : 20 @A1

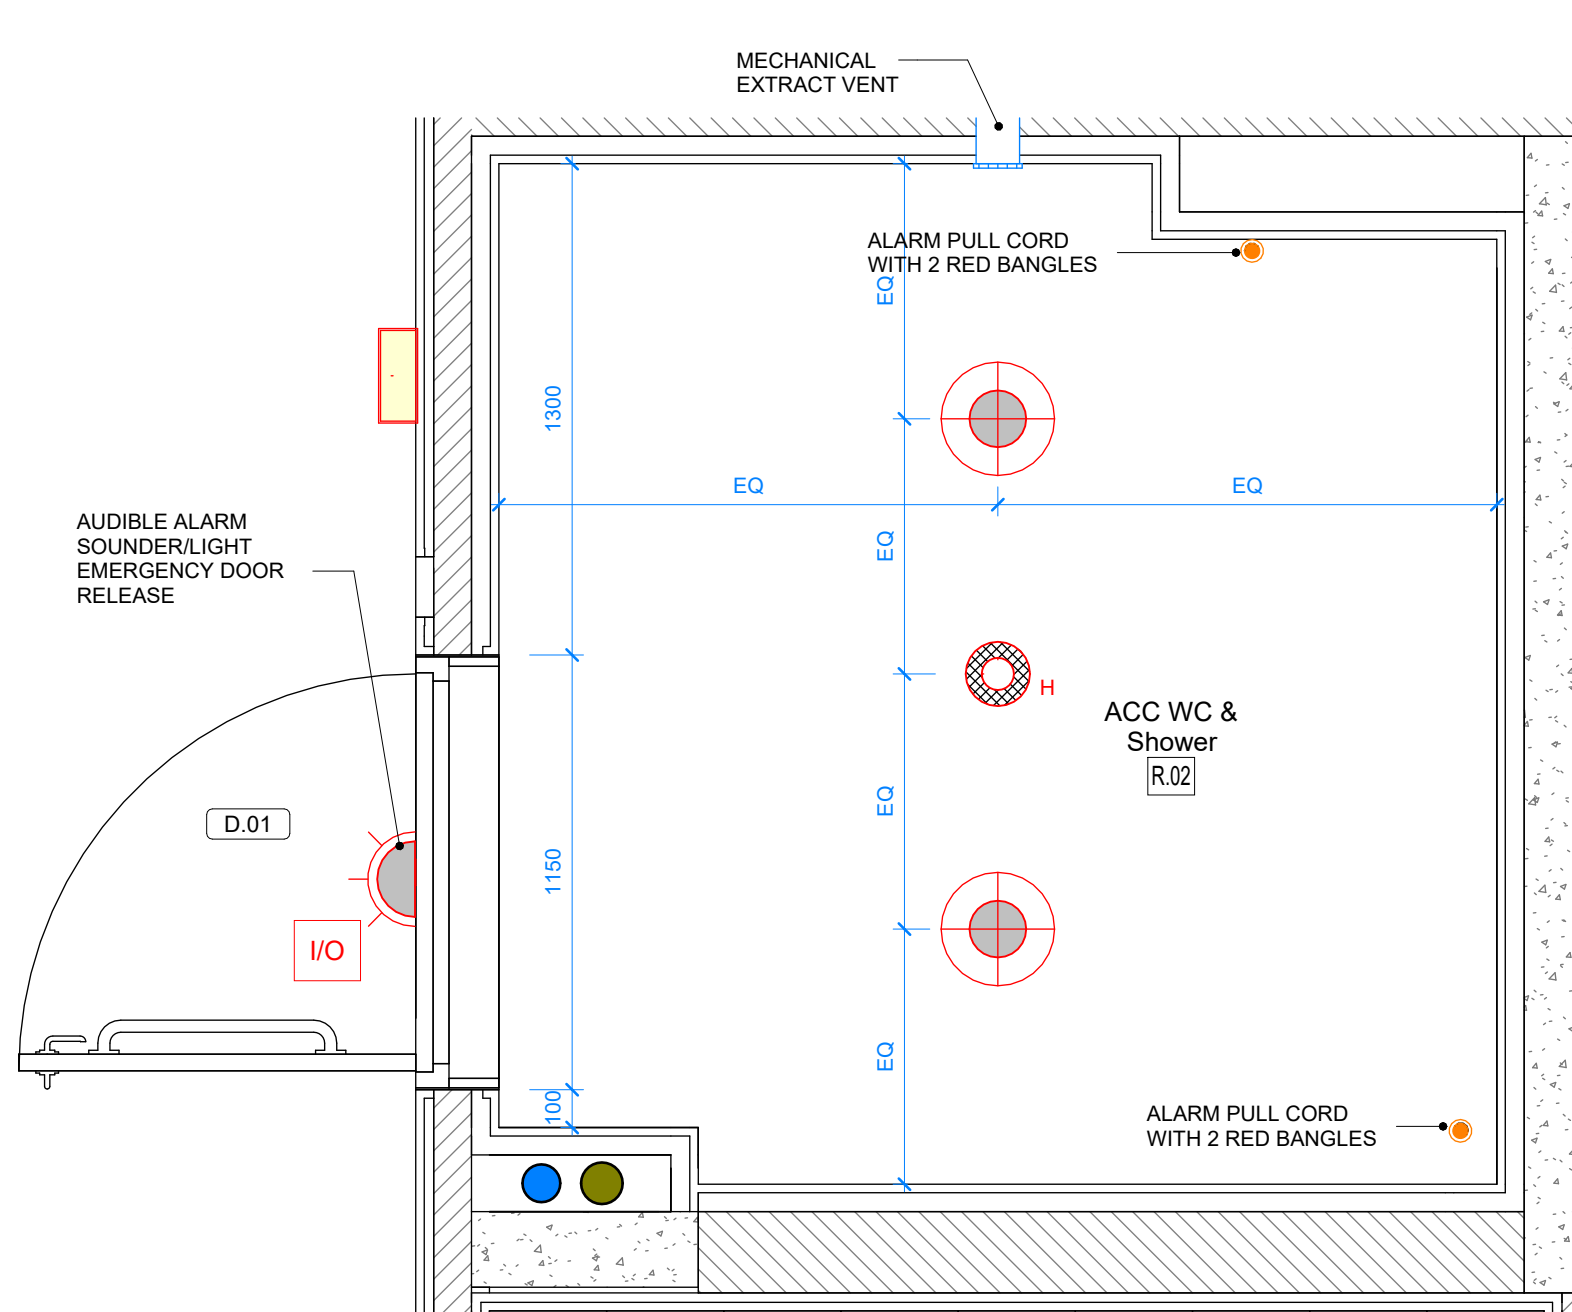

2 Reflected Ceiling Plan
Scale 1 : 20 @A1

NOTE
ALL SANITARY WARE SET-OUT IN STRICT ACCORDANCE WITH BUILDING REGULATIONS TDG PART M

NOTE:
TO BE CONSTRUCTED IN ACCORDANCE WITH DOC M SPECIFICALLY 1.4.10 CHANGING PLACES TOILET SHOWER RAILS NEED TO BE ADJUSTABLE FROM 1050 HIGH TO 1800 HIGH
A COMPLIANT LONGER RAIL MAY NEED TO BE SOURCED AND SWAPPED OUT
A CONTINUOUS CHARGING FULL ROOM COVER OVERHEAD TRACKED HOIST SYSTEM SHOULD BE PROVIDED THAT CONFORMS TO I.S. EN ISO 10535 'HOISTS FOR THE TRANSFER OF DISABLED PERSONS - REQUIREMENTS AND TEST METHODS'. SEE DOC M 1.4.10.K.

NOTE:
SELECTED 100X100X10mm **PORCELAIN TILE**, TILE FINISH ON 12.5mm TILE BACKER BOARD WITH SELECTED APPROVED ALUMINUM BOX TILE TRIM TO THE PERIMETER OF ALL TILED SURFACES. 2.4mm JOINT SIZE TO BE DETERMINED ON SITE TO ELIMINATE / MINIMIZE CUT TILES IN HORIZONTAL DIMENSION. SETTING OUT TO PROVIDE FOR **NO CUT TILES** IN VERTICAL DIMENSION. SELECTED APPROVED HIGH QUALITY COLORED EPOXY GROUT FOR WALL TILES TO EN 13888. DETAILED SUBMITTAL FOR ALL COMPONENT PARTS AND 1mX1m SAMPLE PANEL REQUIRED WITH SELECTED GROUT AND TRIM.

NOTE:
Dimensions not to be scaled from drawing.
For any discrepancies found consult with design office.
Copyright © - Cork County Council Architect's Dept.
This drawing to be read in conjunction with all the Specification Documents.

M&E LEGEND

M&E INDICATIVE ONLY TO BE FULLY COORDINATED WITH M&E CONSULTANT

All lighting to be energy efficient
LUX LEVEL 200-300 AT FLOOR LEVEL

- SURFACE MOUNTED CEILING LIGHT WITH EMERGENCY SPOTLIGHT IP65 3200K
- EPOS TERMINAL RECESSED INTO WALL SIZE & FACEPLATE TO BE AGREED
- INTERNAL DOOR LOCK INDICATOR SENSOR SIZE & FACEPLATE TO BE AGREED
- POWER ASSISTED DOOR CLOSER
- PROPOSED POSITION ACCESSIBLE ALARM PANEL & LIGHT
- AUDIBLE ALARM SOUNDER/LIGHT EMERGENCY DOOR RELEASE
- PROPOSED POSITION FUSED SOCKET
- EMERGENCY ALARM RESET BUTTON
- EM EMERGENCY LIGHT 3HR WALL MOUNTED
- EM EMERGENCY LIGHT 3HR SOFFIT MOUNTED
- EM EMERGENCY FLOOD LIGHT 3HR WALL MOUNTED
- S SURFACE MOUNTED SMOKE DETECTOR IP 67
- (DAC) ALARM PULL CORD
- I/O INPUT/OUTPUT DEVICE FIRE ALARM
- MECHANICAL EXTRACT VENT (ELEVATION)
- MECHANICAL EXTRACT VENT (PLAN)
- VENT THROUGH TO DUCT
- H HEAT DETECTOR IP 67
- SURFACE WALL MOUNTED UPLIGHTER ON COLUMNS TO LIGHT SOFFIT, IP 67 WITH EMERGENCY LIGHT AND MOTION DETECTION
- SURFACE WALL MOUNTED EXTERNAL LIGHT IP 67 WITH EMERGENCY LIGHT AND MOTION DETECTION
- SURFACE MOUNTED WALL LIGHT FITTING IP67 3200K
- EXIT FIRE EXIT SIGNAGE LIGHT IP 67

DRAINAGE LEGEND

- 1 NO. FLUSH MOUNTED RECESSED DRAIN
- 1 NO. FLOOR GULLY
- 1 NO. SLOT DRAIN
- 600 x 600 MANHOLE
- AJ ACCESS
- SOIL VENT PIPE (SVP)
- RAIN WATER DOWN PIPE (RWP)
- GROUNDS REQUIRED 171KG LOADING to drop down rails & shower seat & 131KG for grab rails

T.	TENDER ISSUE	13.07.2026
Rev	Description	Date
	Revision	

Project Stage: **TENDER**

Comhairle Contae Chorcaí

Roinn na nAilrí
Seachadadh Gaipillí
Halla an Chontae | Corcaigh | T12 R2NC | Éire
An tAilrí Contae | Marcus O'Coilín

Cork County Council

Architect Department
Capital Delivery Directorate
County Hall | Cork | T12 R2NC | Ireland
County Architect | Mark Collins
T +353-021 428 5430 | architects@corkcoco.ie | www.corkcoco.ie



Protect Title: **Claycastle Watersports Facility**
Youghal Co. Cork

Drawing Title:
ACCESSIBLE WC & SHOWER

Design Team:	Date: Jan 2023	Dwg No:
Cork County Council	Scale: 1:20	5002
Architects Department	Sheet: A1	
Capital Delivery	Stage ID: T	
File. No: CCWF-CCC- ZZ- 00-DR-A- 5002		
Job No: ATS1_S_2021_025		