



SMALL SHOWER

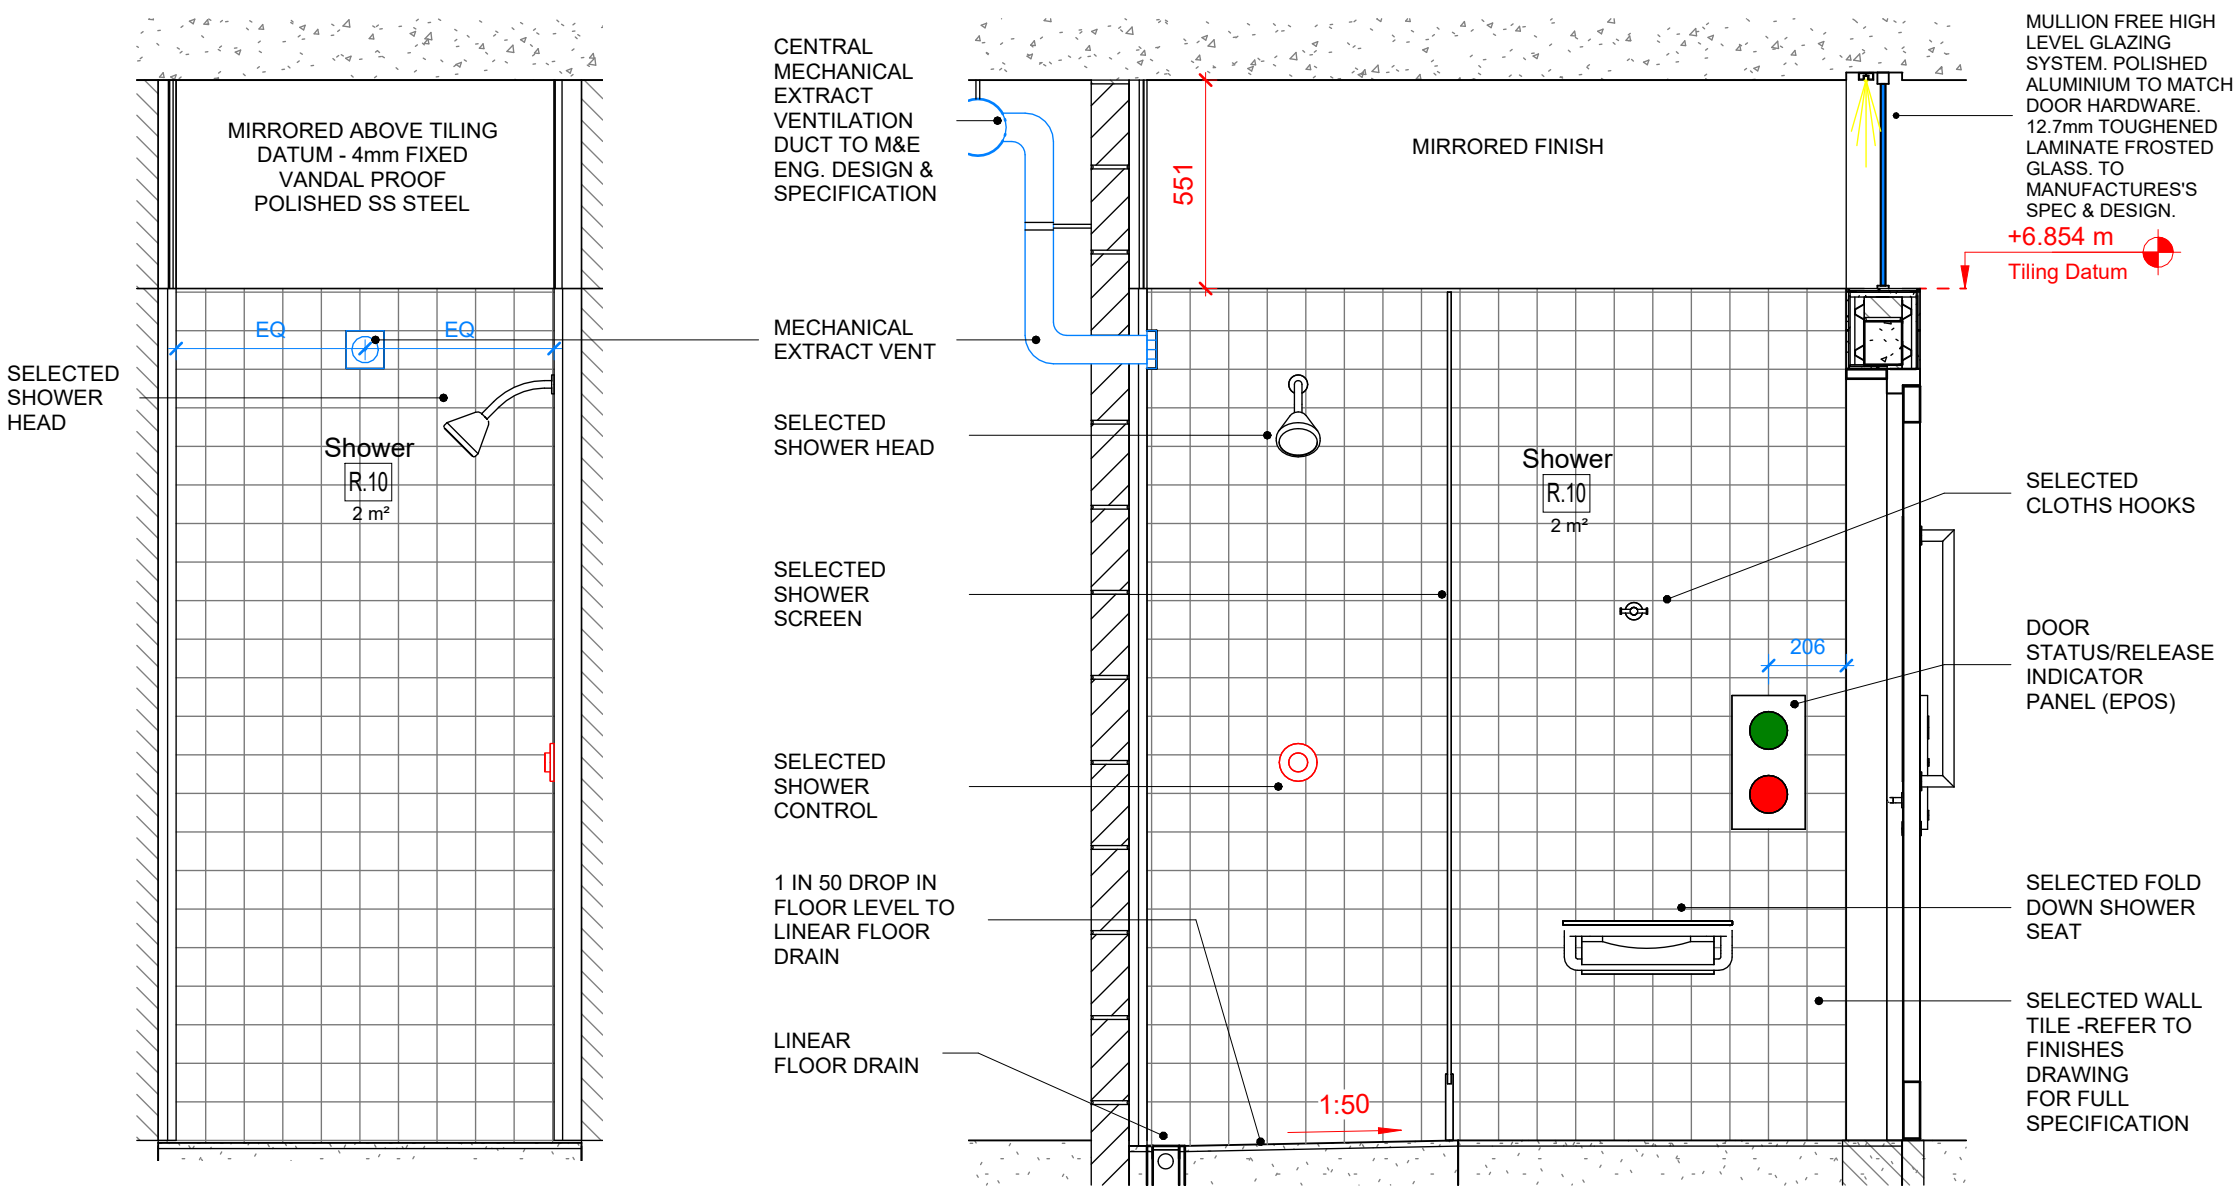


4 ELEVATION - A
Scale 1 : 20 @A1

5 ELEVATION - B
Scale 1 : 20 @A1

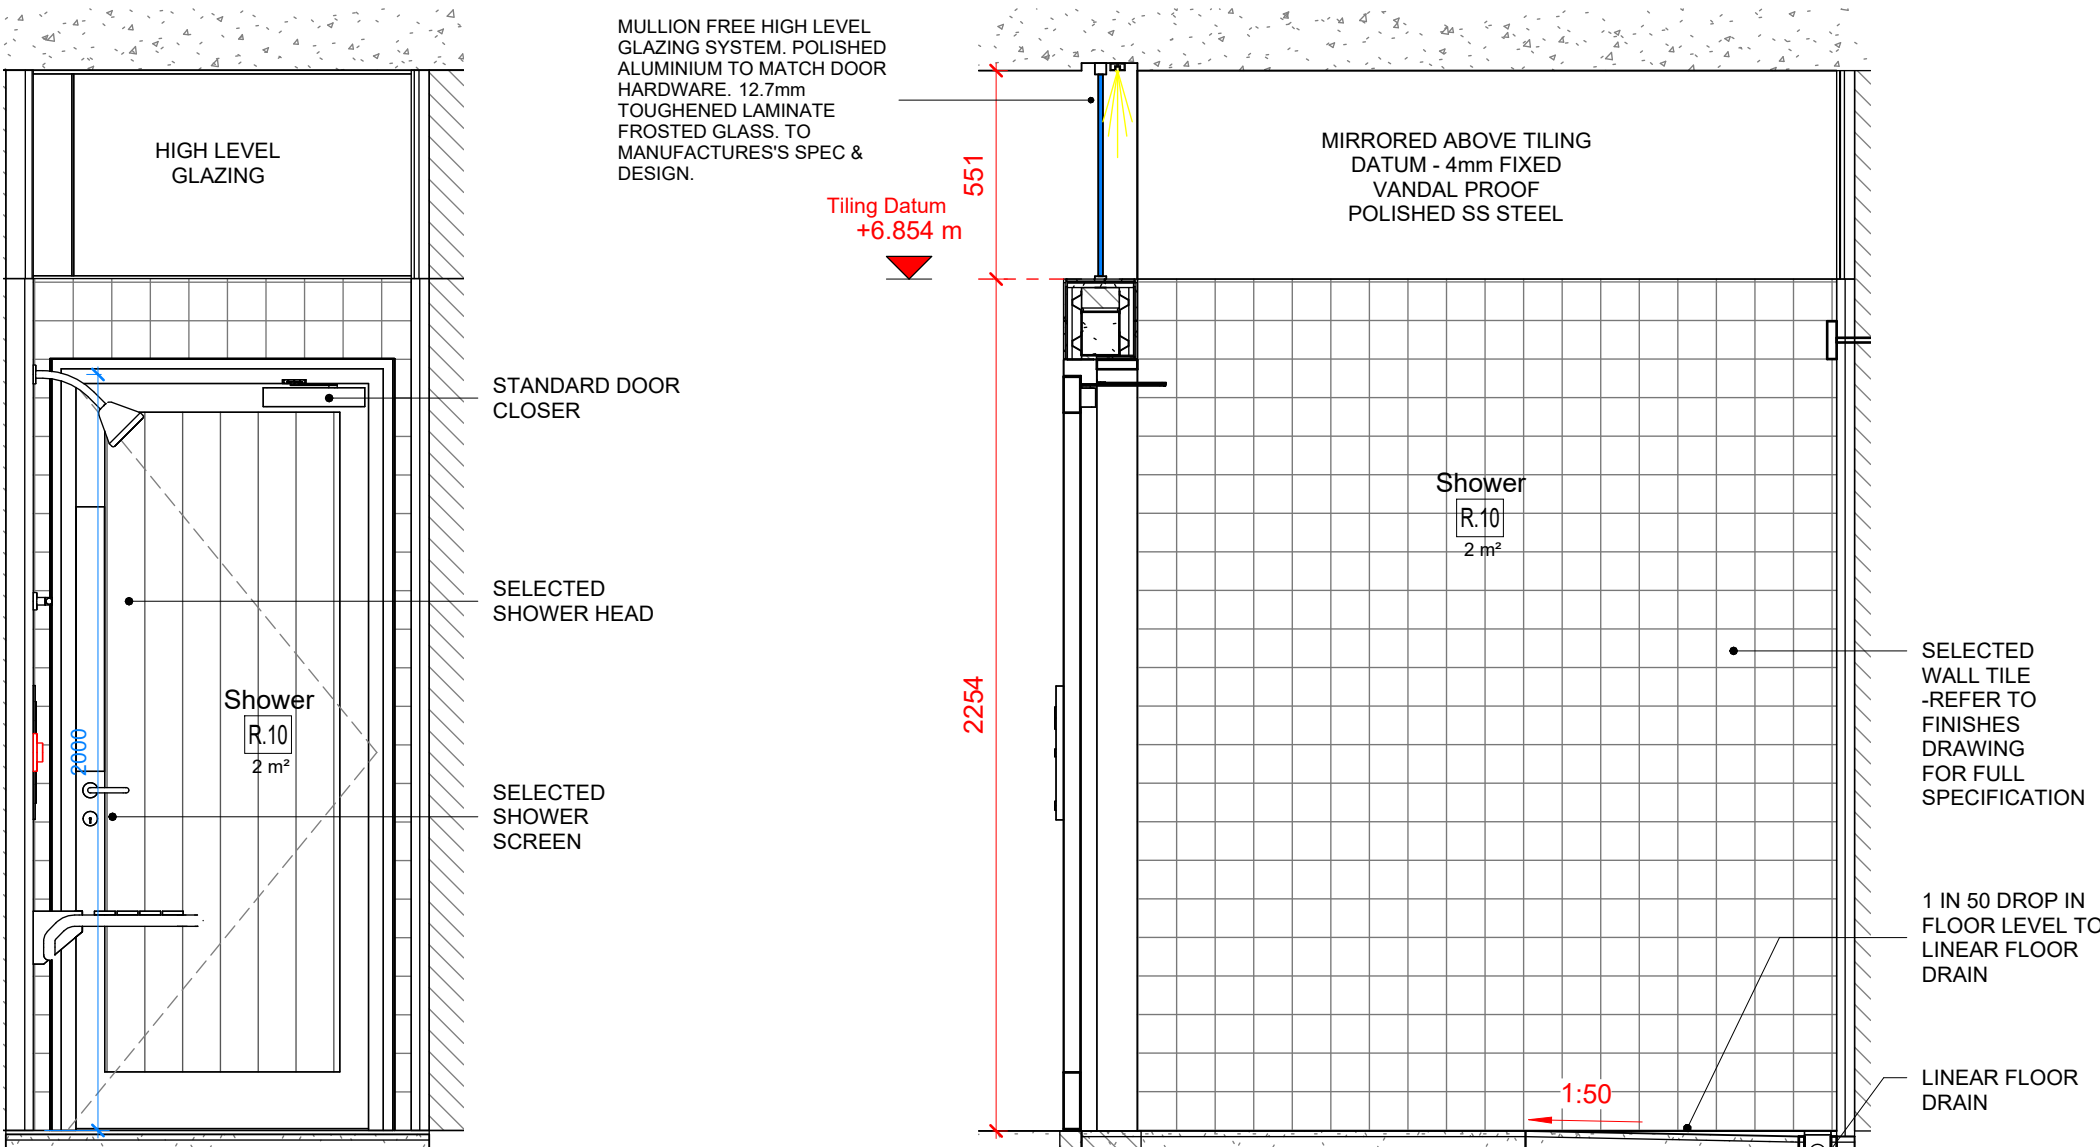

6 ELEVATION - C
Scale 1 : 20 @A1


7 ELEVATION - D
Scale 1 : 20 @A1

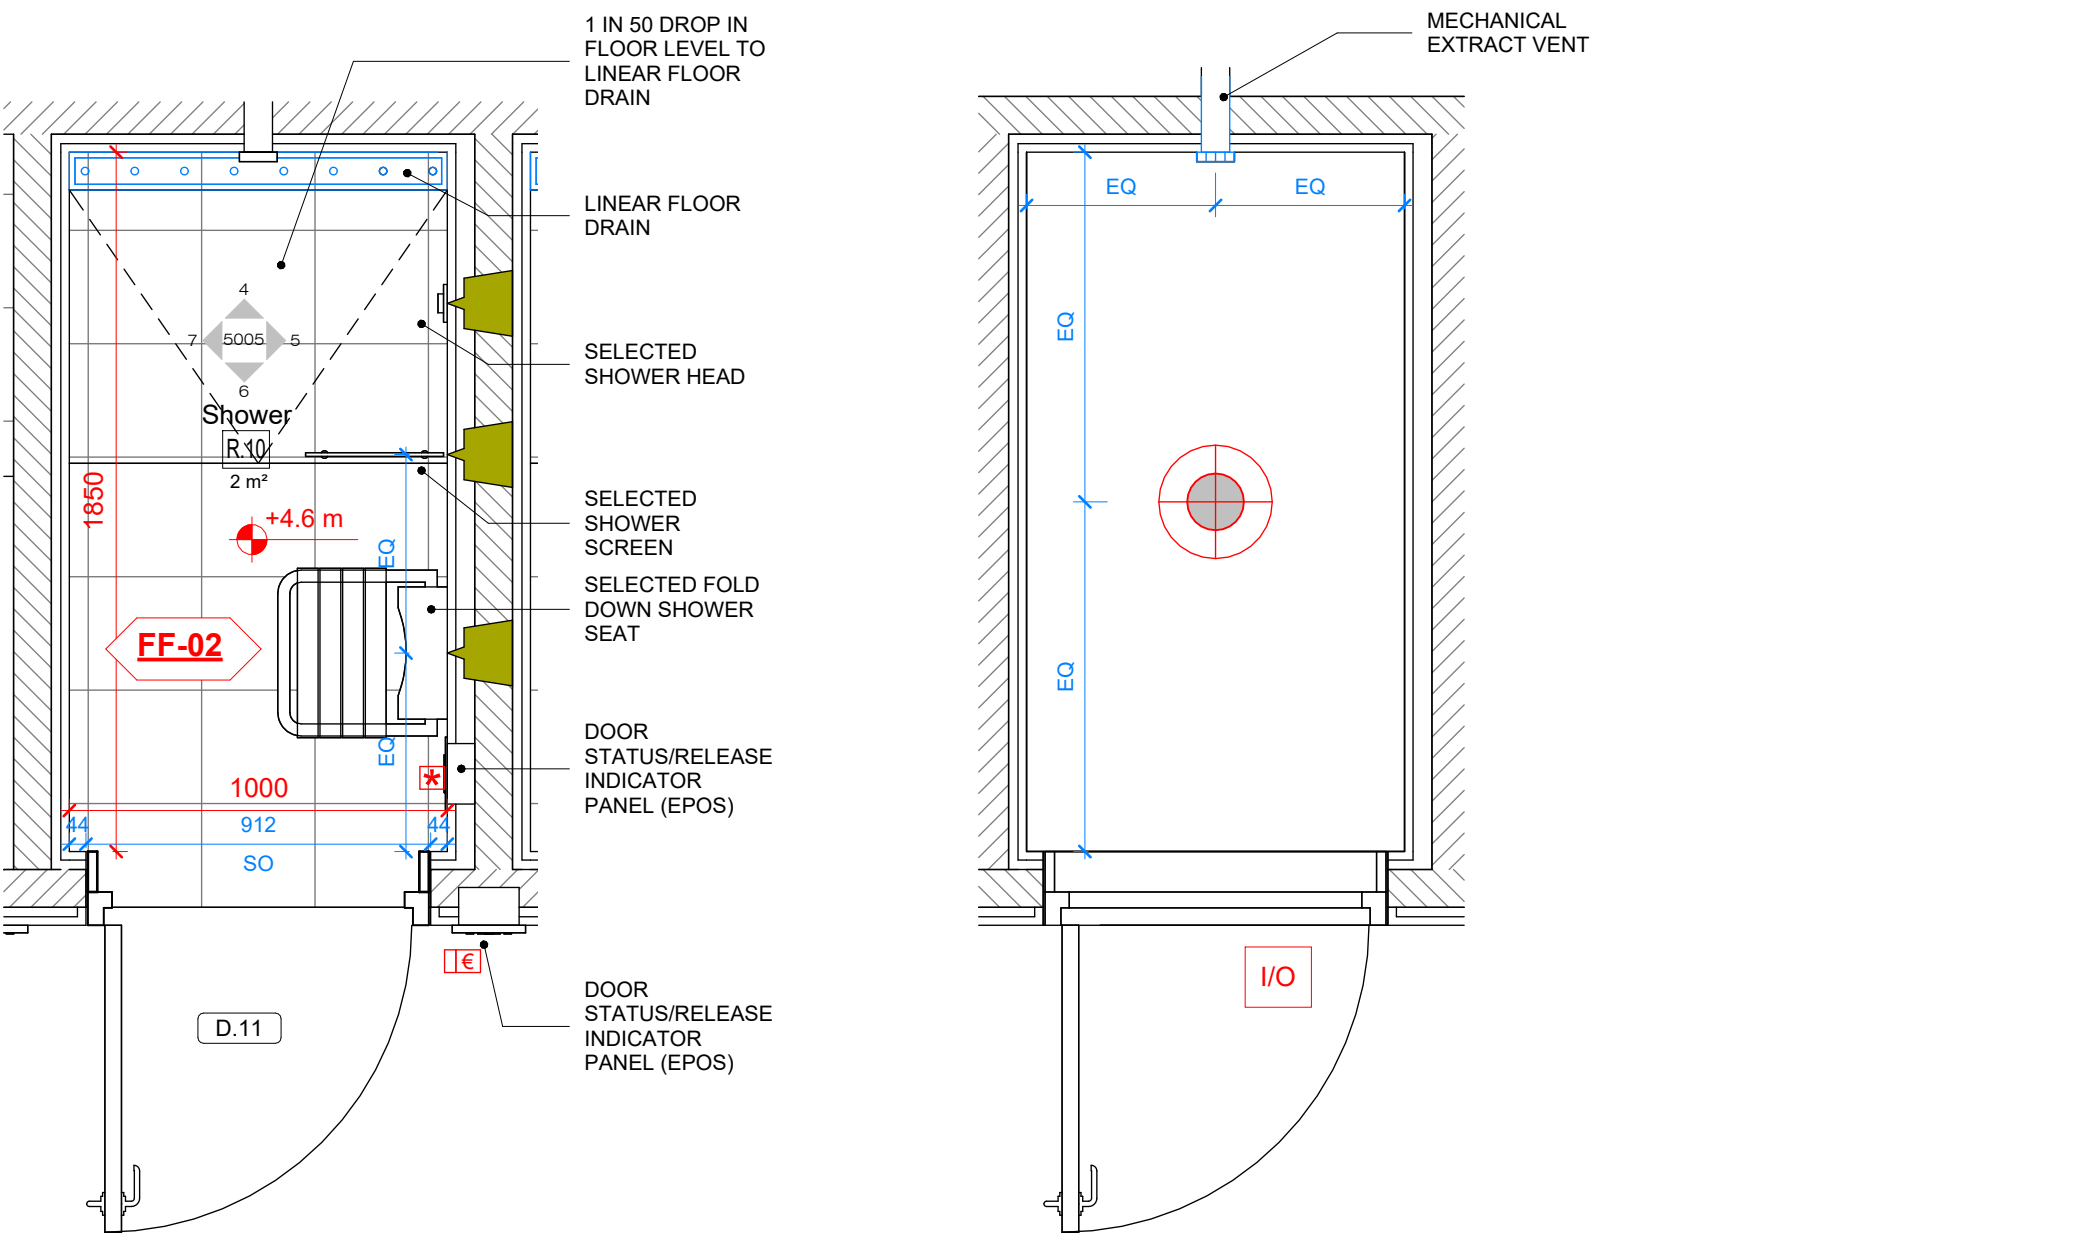

1 FLOOR PLAN
Scale 1 : 20 @A1


3 REFLECTED CEILING PLAN
Scale 1 : 20 @A1

LARGE SHOWER

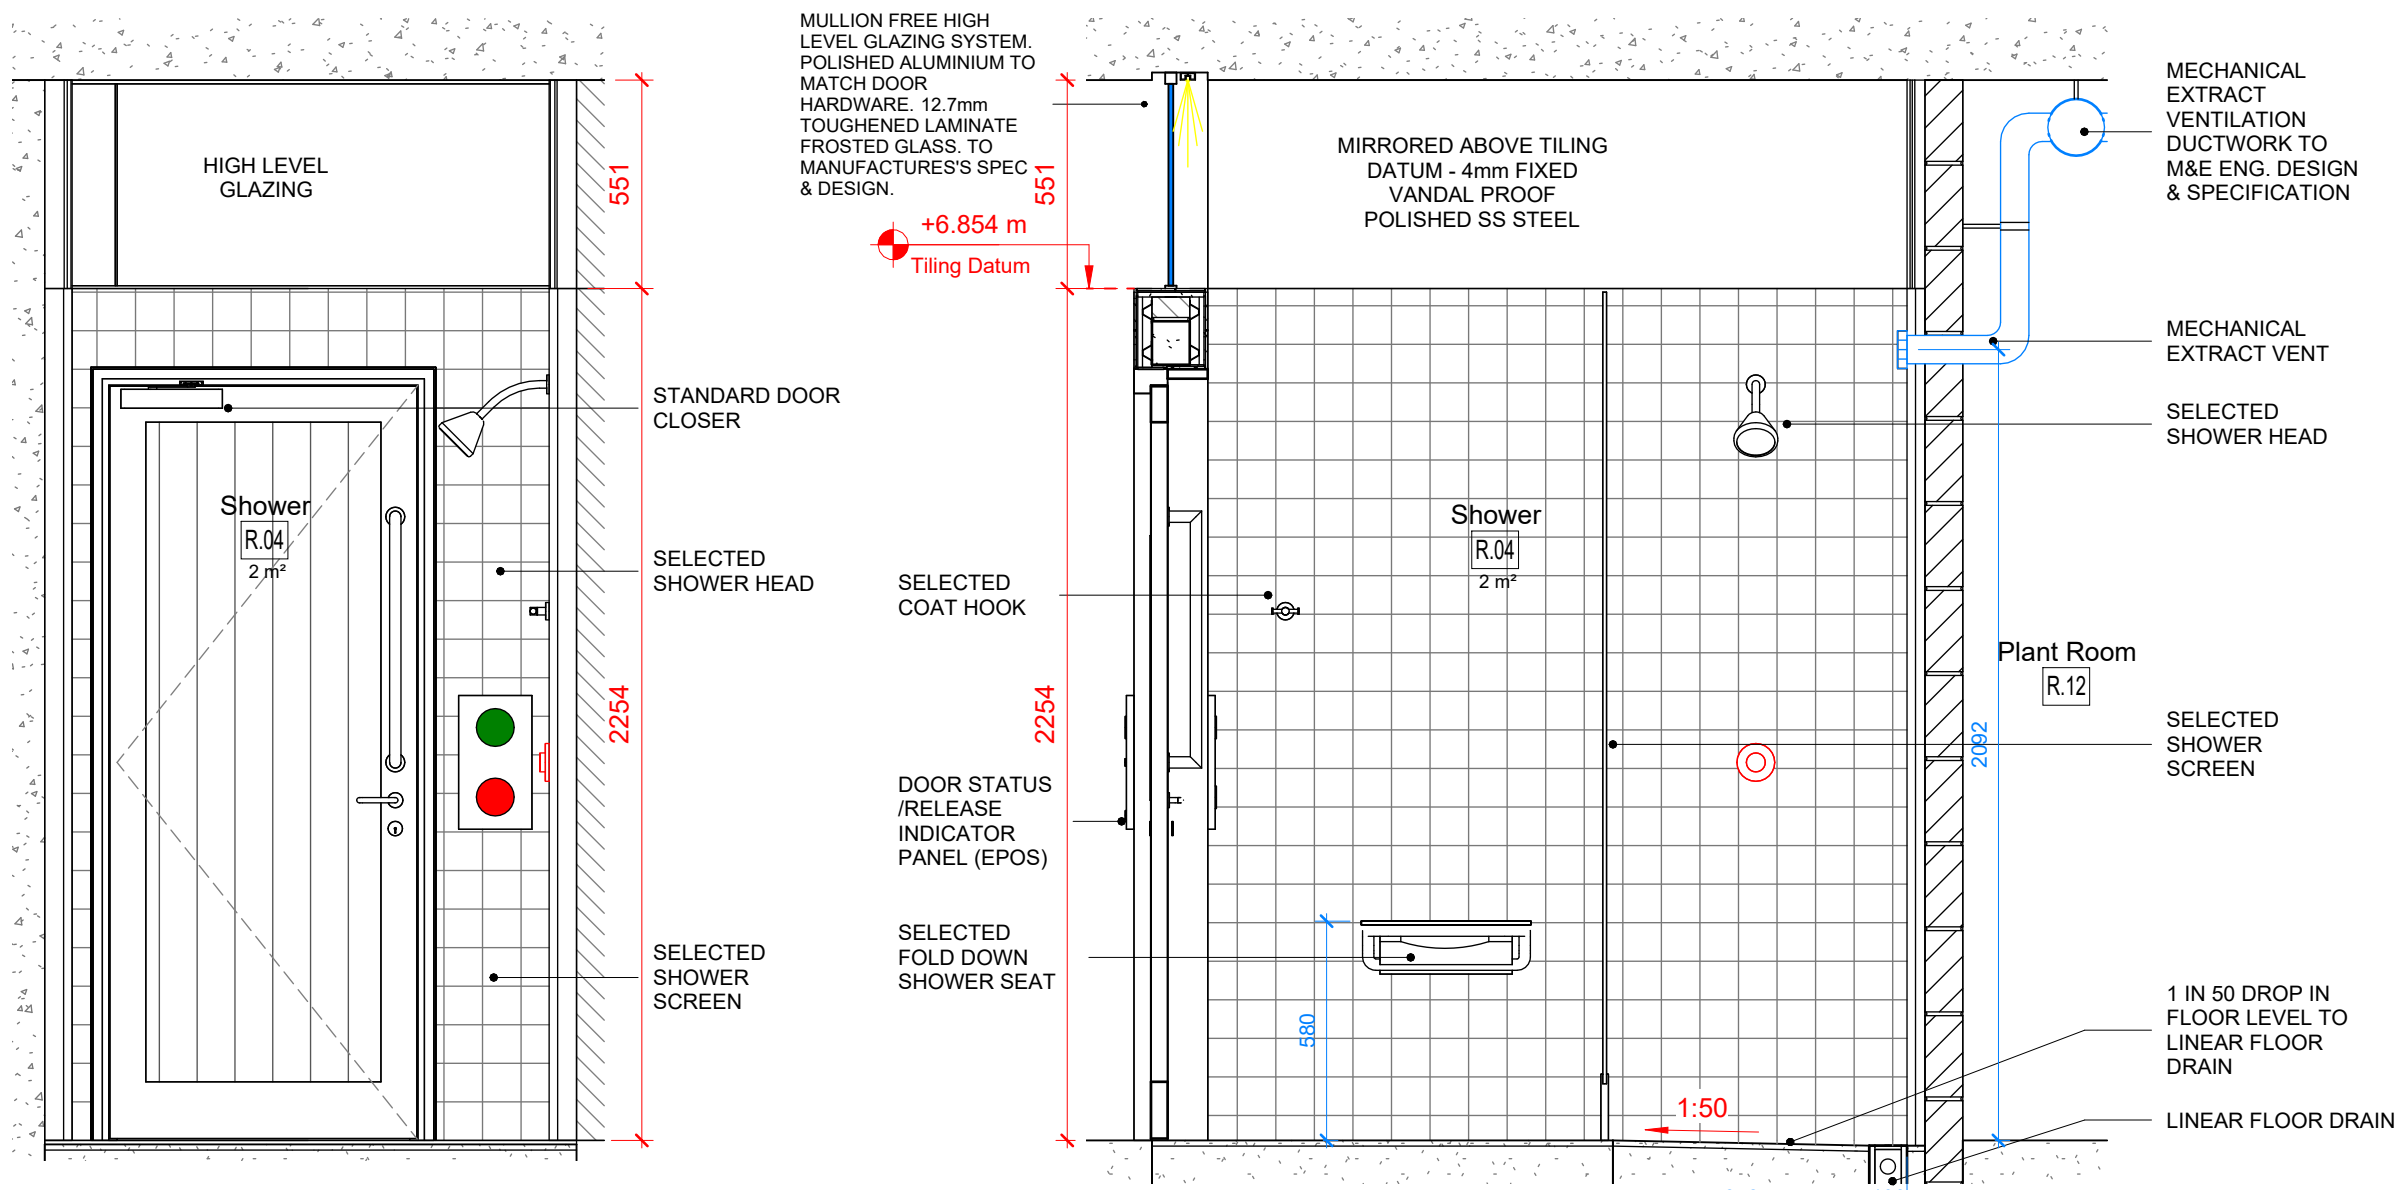


9 ELEVATION - A
Scale 1 : 20 @A1

10 ELEVATION - B
Scale 1 : 20 @A1

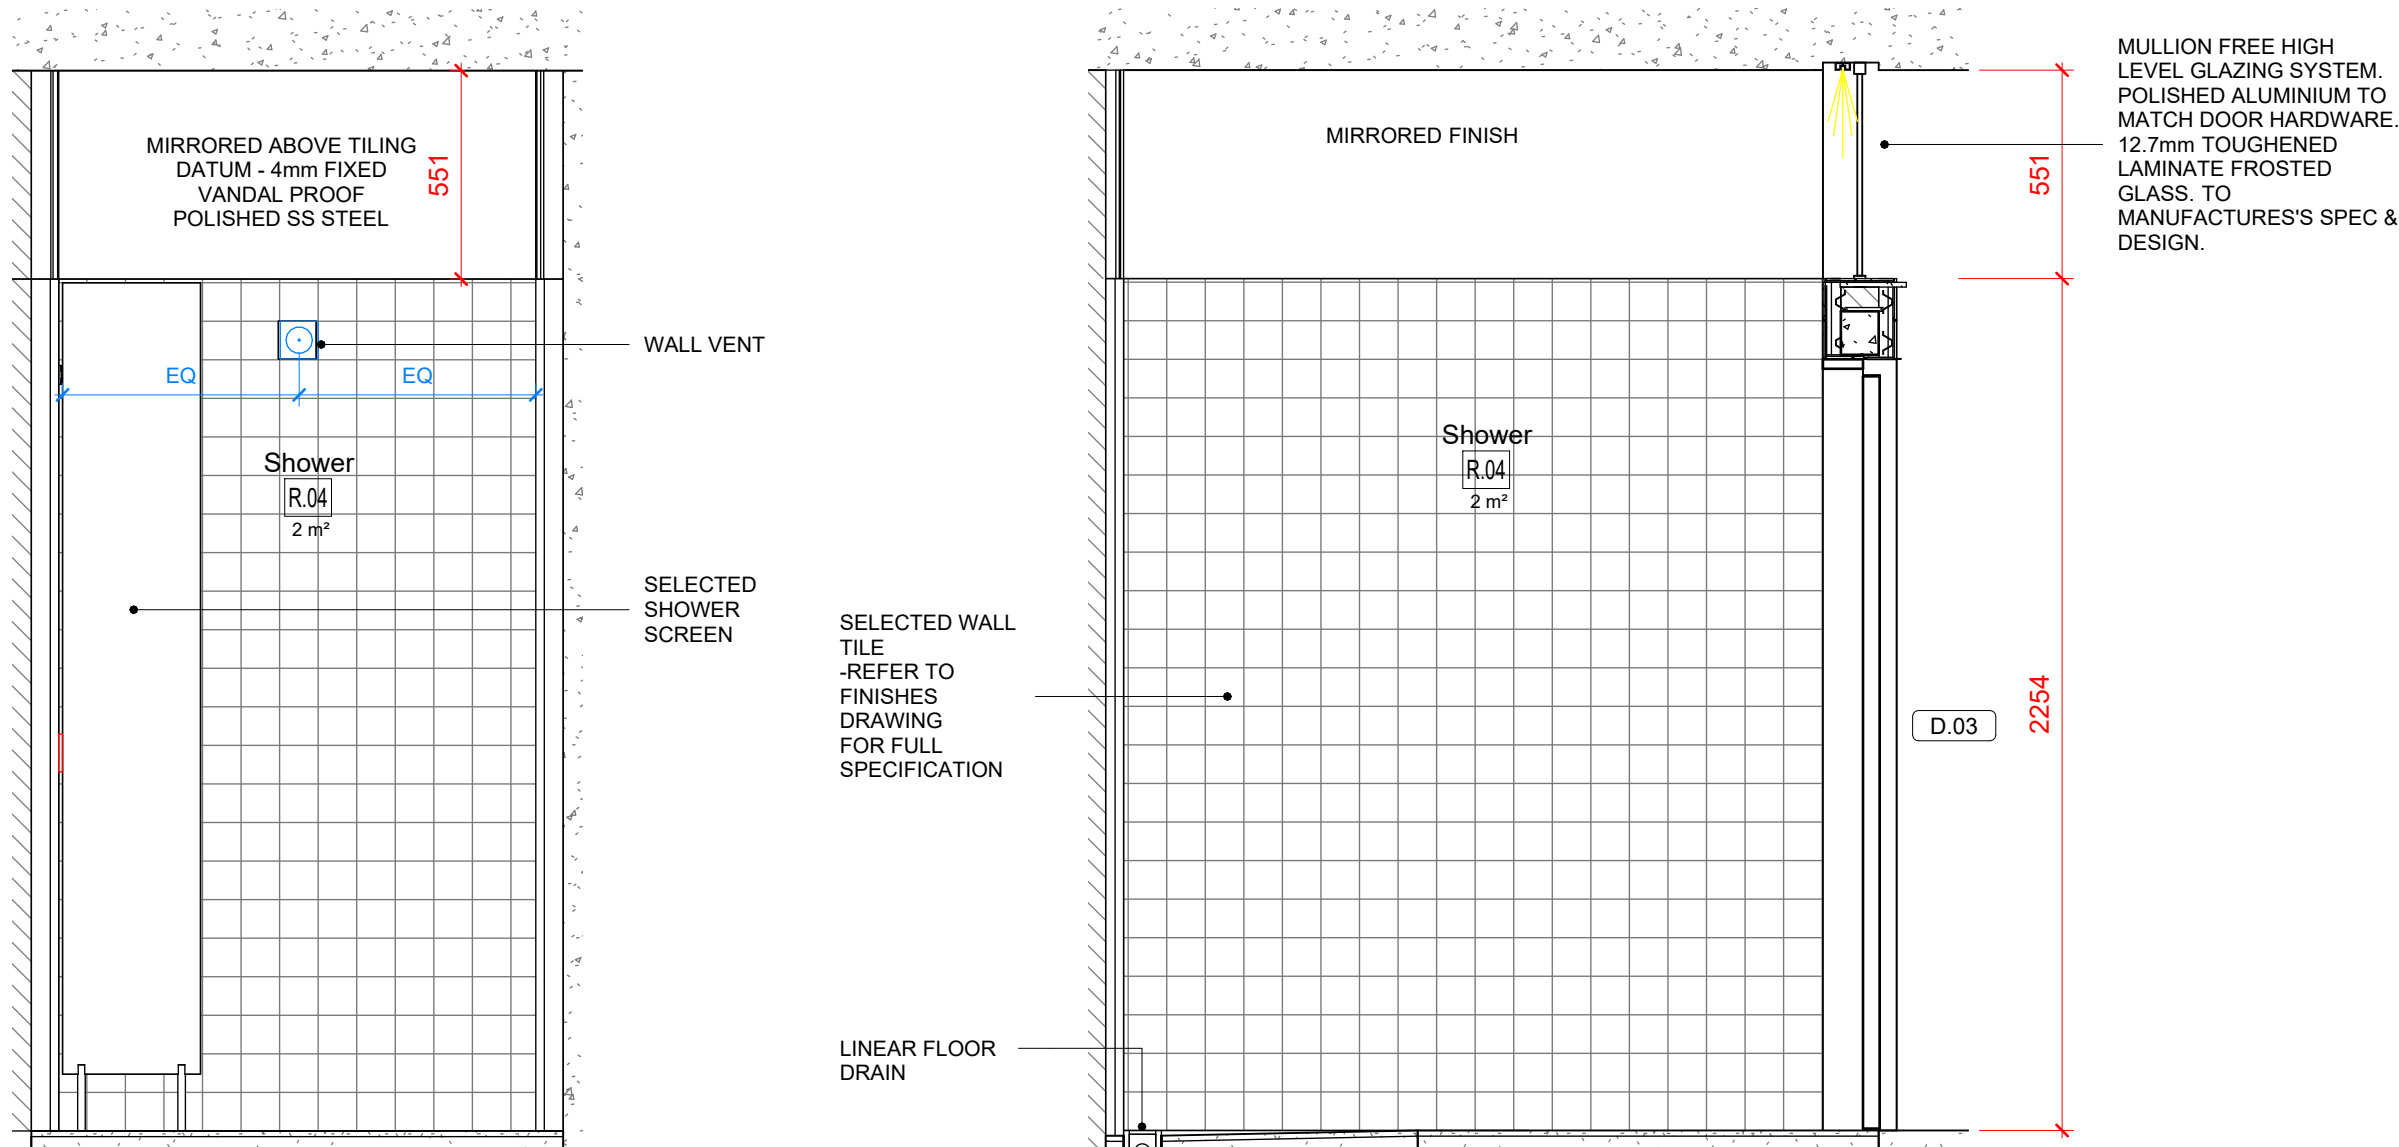

11 ELEVATION - C
Scale 1 : 20 @A1

12 ELEVATION - D
Scale 1 : 20 @A1

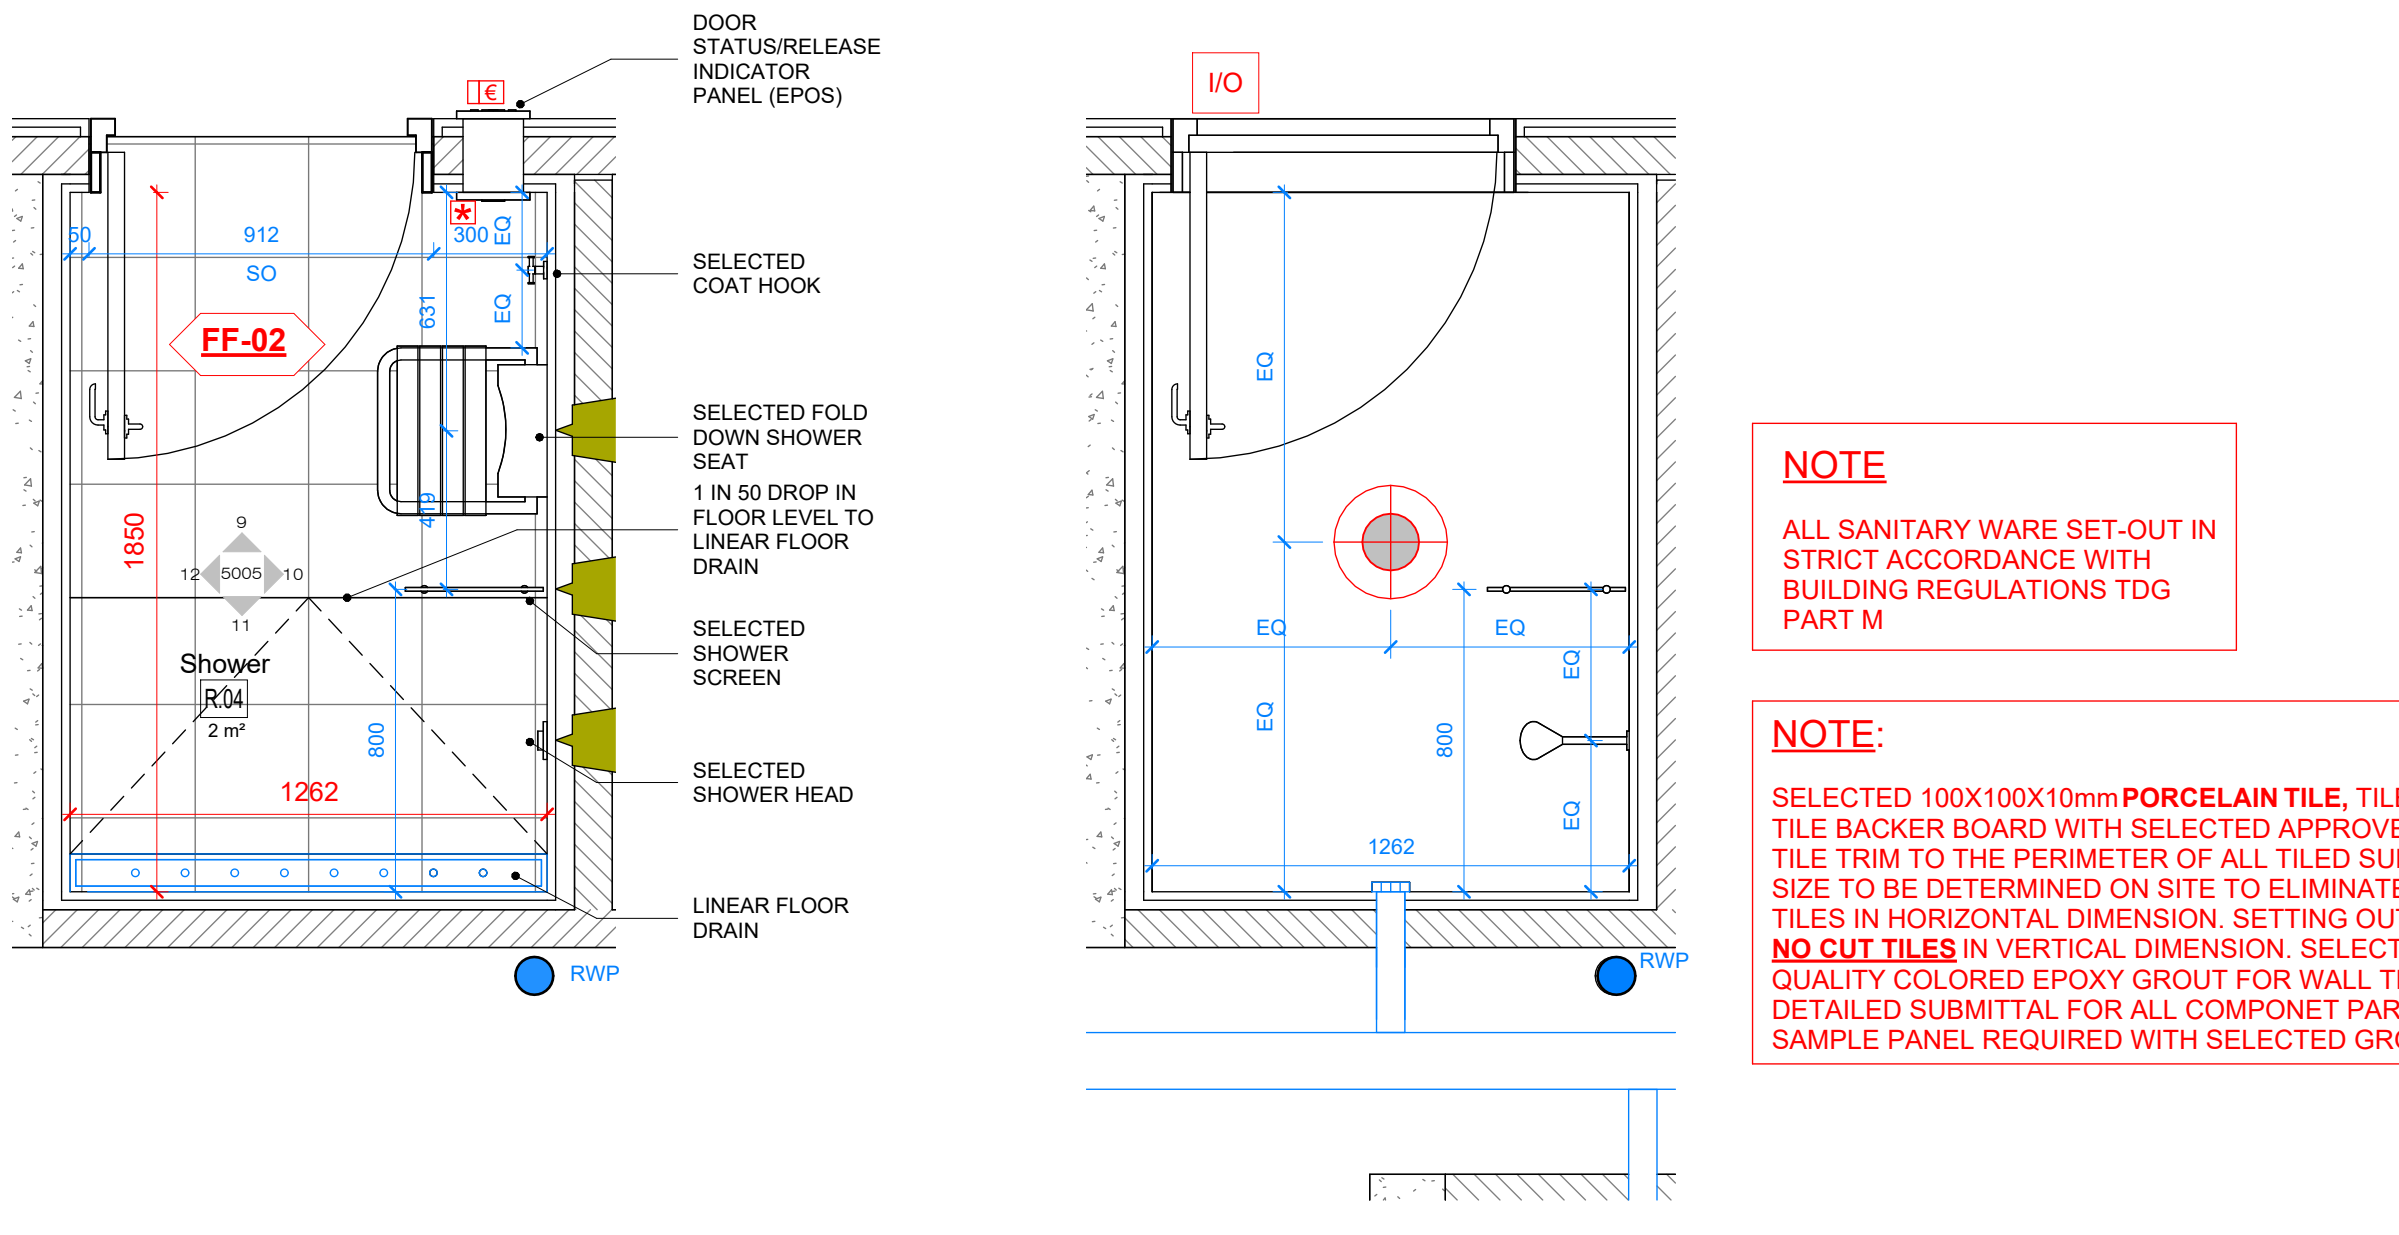

2 FLOOR PLAN
Scale 1 : 20 @A1

8 REFLECTED CEILING PLAN
Scale 1 : 20 @A1

NOTE:
Dimensions not to be scaled from drawing.
For any discrepancies found consult with design office.
Copyright © - Cork County Council Architect's Dept.
This drawing to be read in conjunction with all the
Specification Documents.

M&E LEGEND

M&E INDICATIVE ONLY TO BE FULLY
COORDINATED WITH M&E CONSULTANT

All lighting to be energy efficient
LUX LEVEL 200-300 AT FLOOR LEVEL

- SURFACE MOUNTED CEILING LIGHT WITH EMERGENCY SPOTLIGHT IP65 3200K
- EPOS TERMINAL RECESSED INTO WALL SIZE & FACEPLATE TO BE AGREED
- INTERNAL DOOR LOCK INDICATOR SENSOR SIZE & FACEPLATE TO BE AGREED
- POWER ASSISTED DOOR CLOSER
- PROPOSED POSITION ACCESSIBLE ALARM PANEL & LIGHT
- AUDIBLE ALARM SOUNDER/LIGHT EMERGENCY DOOR RELEASE
- PROPOSED POSITION FUSED SOCKET
- EMERGENCY ALARM RESET BUTTON
- EMERGENCY LIGHT 3HR WALL MOUNTED
- EMERGENCY LIGHT 3HR SOFFIT MOUNTED
- EMERGENCY FLOOD LIGHT 3HR WALL MOUNTED
- SURFACE MOUNTED SMOKE DETECTOR IP 67
- DISABLED (DAC) ALARM PULL CORD
- INPUT/OUTPUT DEVICE FIRE ALARM
- MECHANICAL EXTRACT VENT (ELEVATION)
- MECHANICAL EXTRACT VENT (PLAN)
- VENT THROUGH TO DUCT
- HEAT DETECTOR IP 67
- SURFACE WALL MOUNTED UPLIGHTER ON COLUMNS TO LIGHT SOFFIT, IP 67 WITH EMERGENCY LIGHT AND MOTION DETECTION
- SURFACE WALL MOUNTED EXTERNAL LIGHT IP 67 WITH EMERGENCY LIGHT AND MOTION DETECTION
- SURFACE MOUNTED WALL LIGHT FITTING IP67 3200K
- FIRE EXIT SIGNAGE LIGHT IP 67

DRAINAGE LEGEND

- 1 NO. FLUSH MOUNTED RECESSED DRAIN
- 1 NO. FLOOR GULLY
- 1 NO. SLOT DRAIN
- 600 x 600 MANHOLE
- AJ ACCESS
- SOIL VENT PIPE (SVP)
- RAIN WATER DOWN PIPE (RWP)
- GROUNDS REQUIRED 171KG LOADING to drop down rails & shower seat & 131KG for grab rails

T.	TENDER ISSUE	13.07.2026
Rev	Description	Date
Revision		

Project Stage: **TENDER**

Comhairle Contae Chorcaí

Roinn na nAilíirí
Seachadadh Gaipillí
Halla an Chontae | Corcaigh | T12 R2NC | Éire
An tAire Contae | Marcus O'Coileáin

Cork County Council

Architect Department
Capital Delivery Directorate
County Hall | Cork | T12 R2NC | Ireland
County Architect | Mark Collins
T +353-021 428 5430 | architects@corkcoco.ie | www.corkcoco.ie



Protect Title: **Claycastle Watersports Facility**
Youghal Co. Cork

Drawing Title:
SHOWER ROOMS

Design Team:	Date: Jan 2023	Dwg No:
Cork County Council	Scale: 1:20	5005
Architects Department	Sheet: A1	
Capital Delivery	Stage ID: T	
File. No: CCWF-CCC- ZZ- 00-DR-A- 5005		
Job No: ATS1_S_2021_025		