



ELECTRICAL ROOM

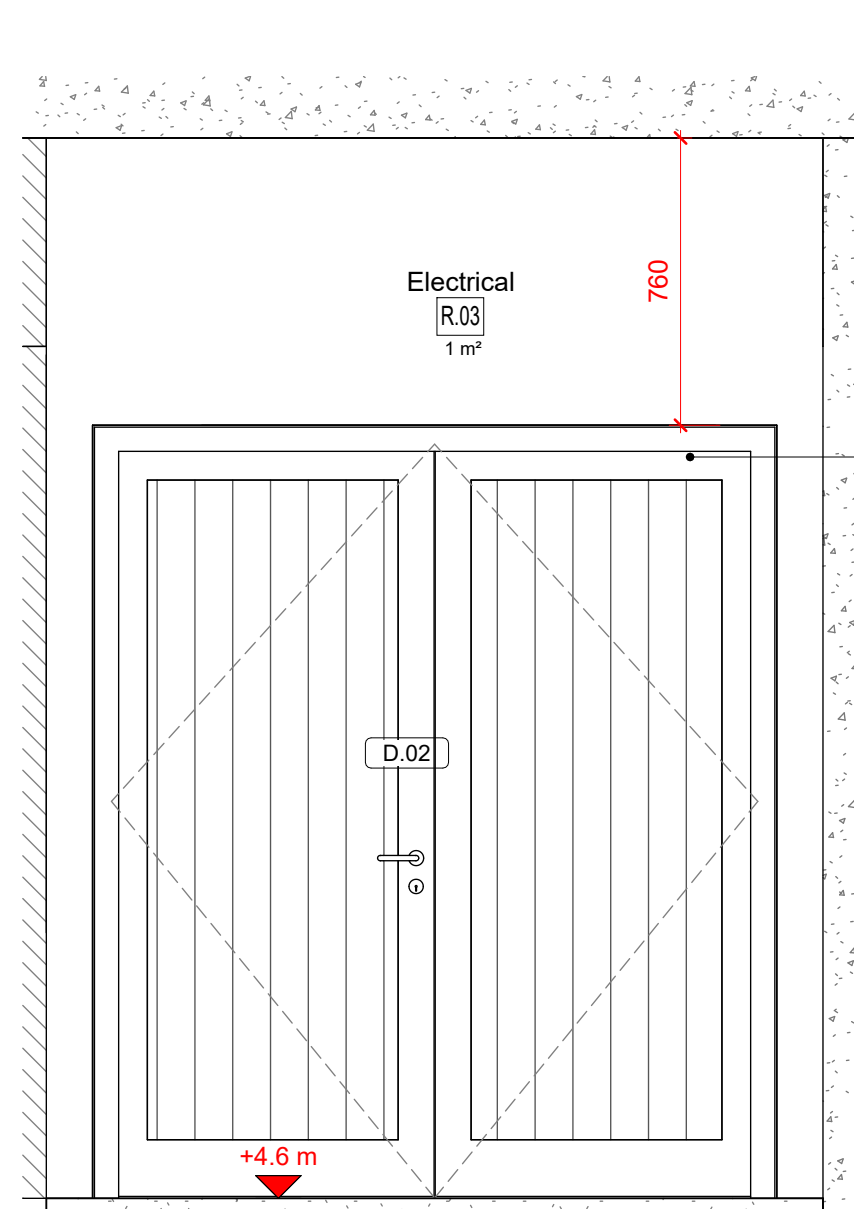


4 ELEVATION - A

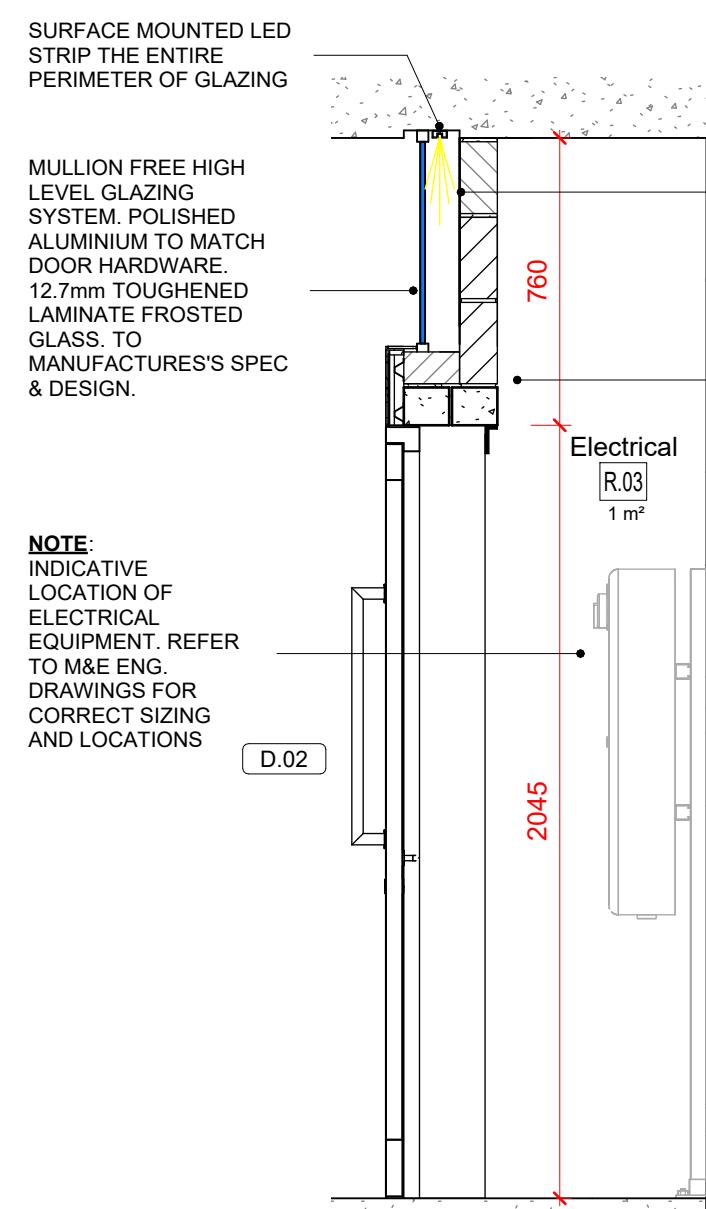


5 ELEVATION - B


NOTE ON ROOF PENETRATIONS IN FIRE RATED COMPARTMENTS (PLANT ROOM, ELECTRICAL ROOM): ALL PENETRATIONS IN THROUGH THE ROOF LESS THAN 1.5m FROM A COMPARTMENT WALL MUST HAVE FIRE STOPPING

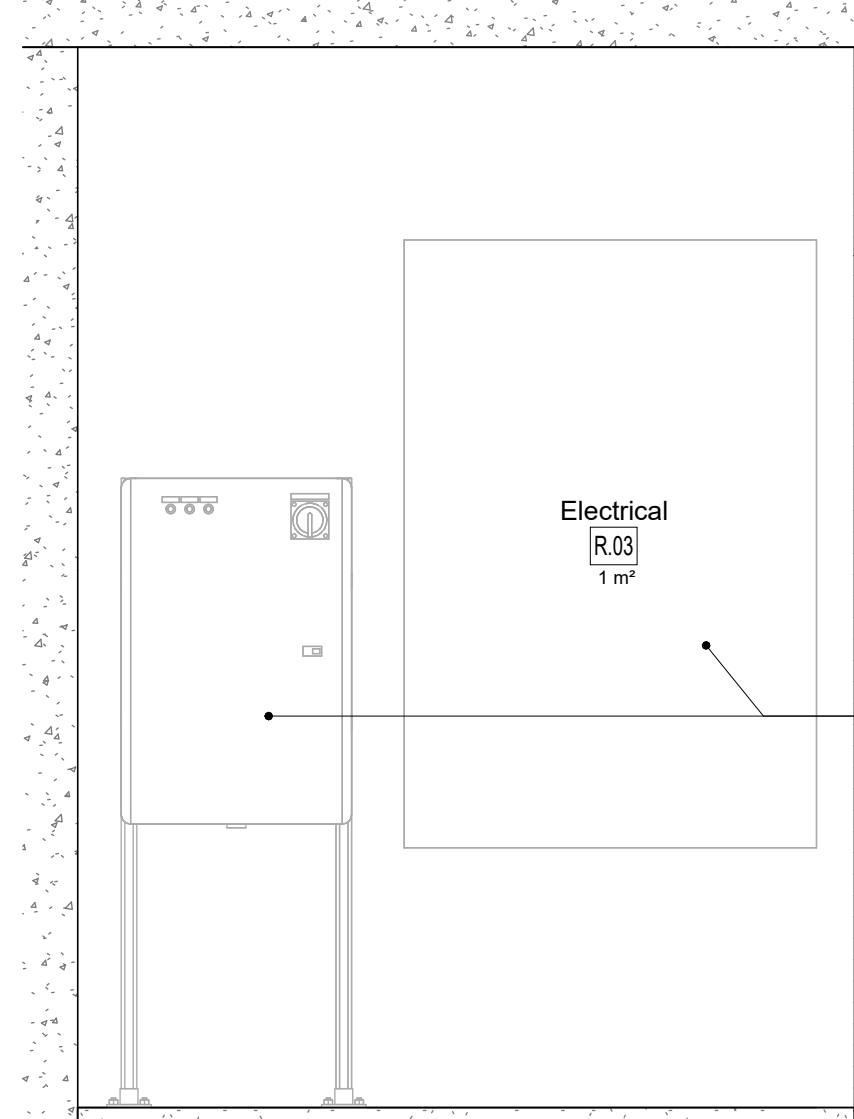

6 ELEVATION - C

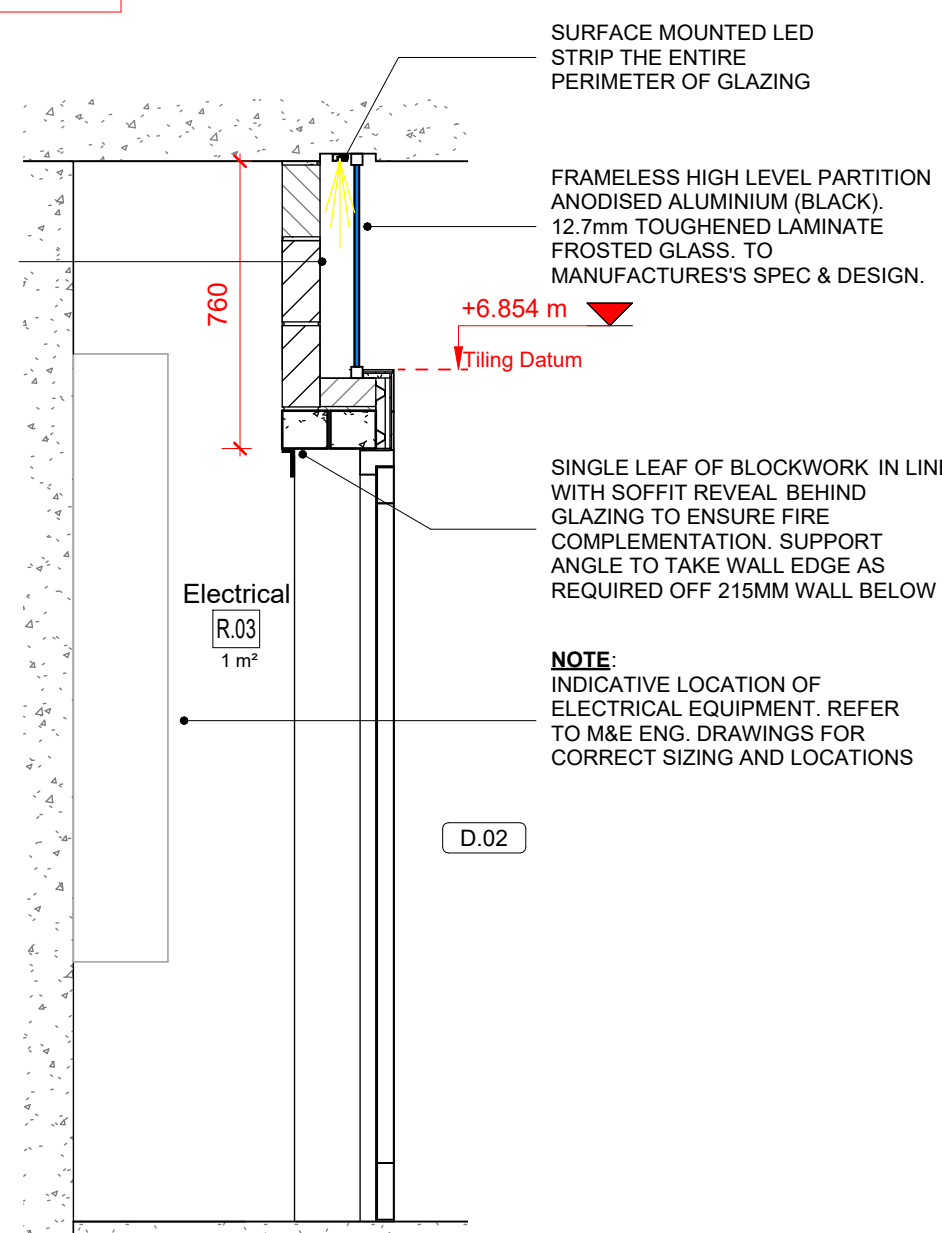


7 ELEVATION - D

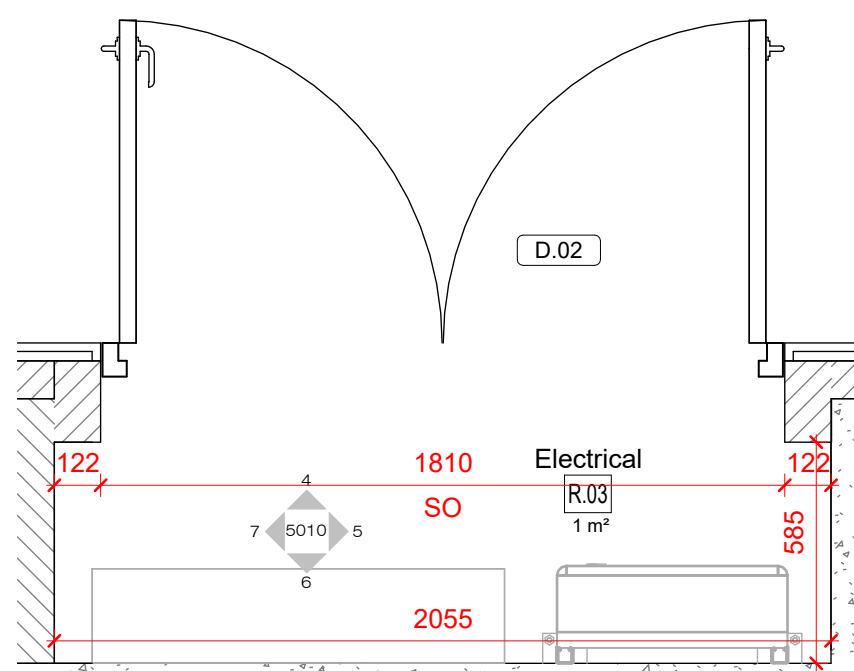


1 FLOOR PLAN

Scale 1 : 20 @A1

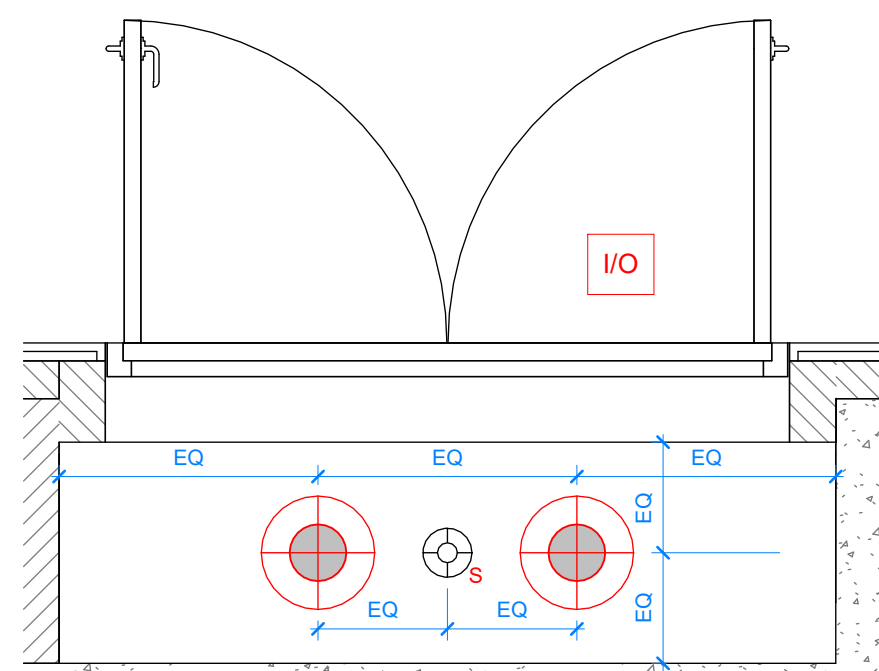


3 REFLECTED CEILING PLAN


CLEANER'S ROOM

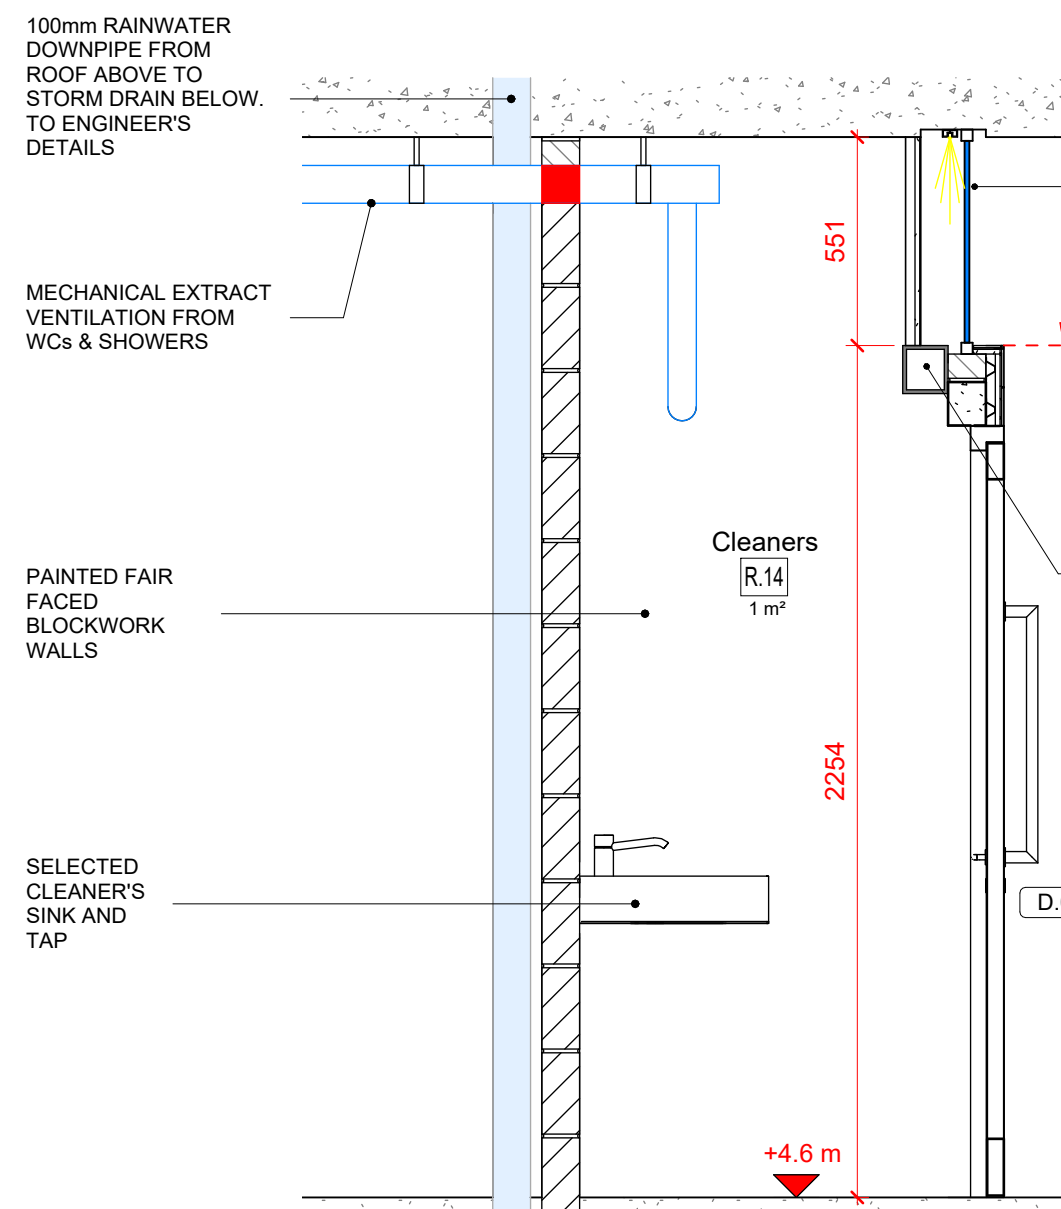


9 ELEVATION - A

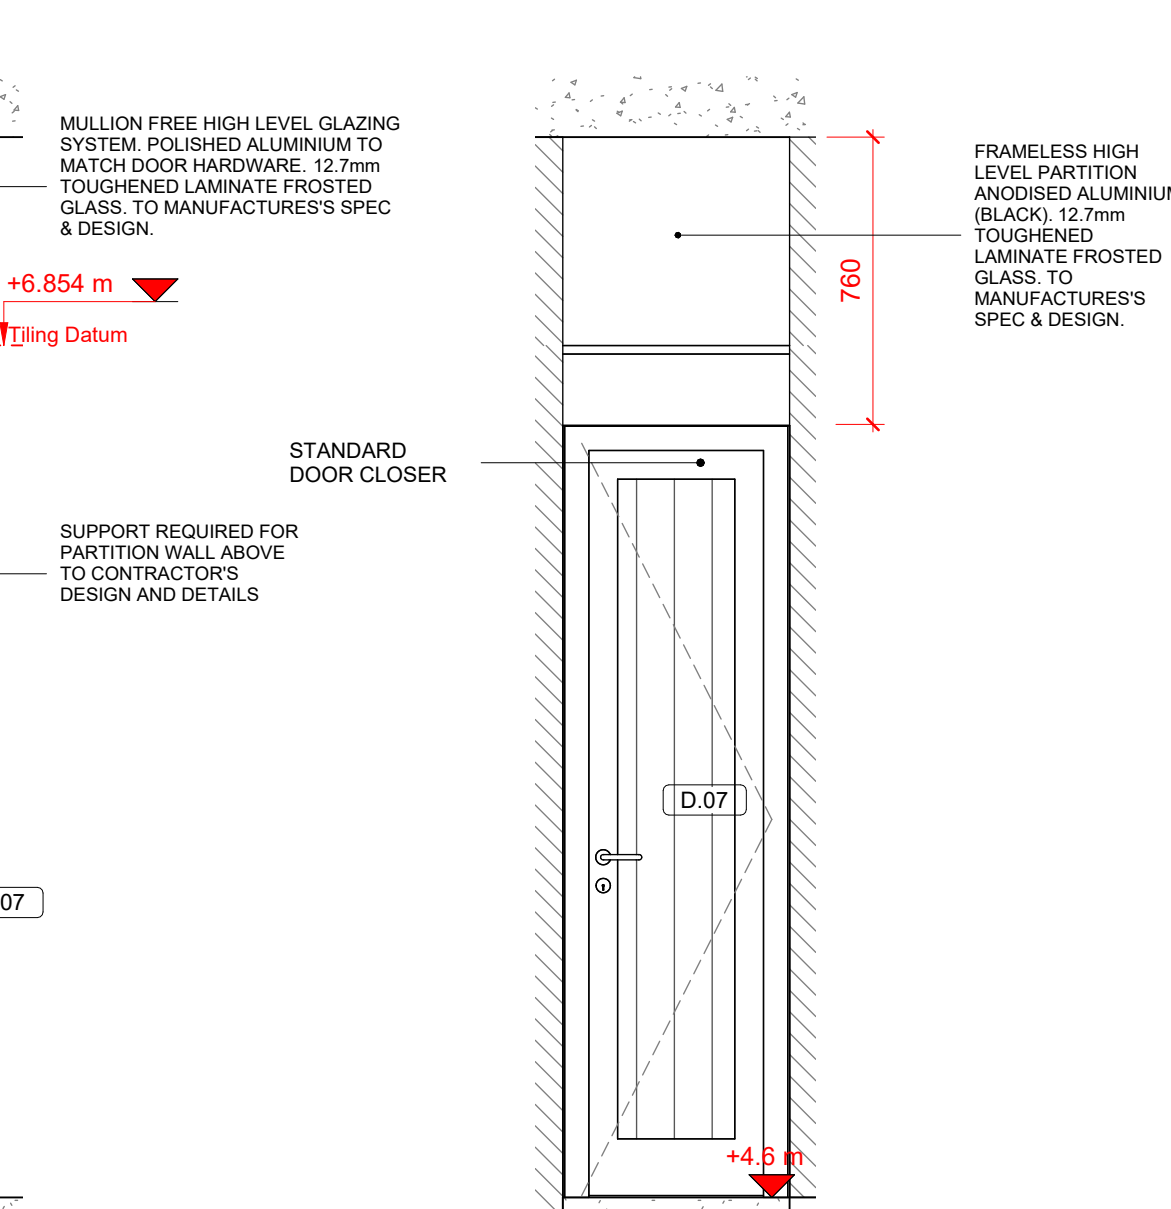


10 ELEVATION - B

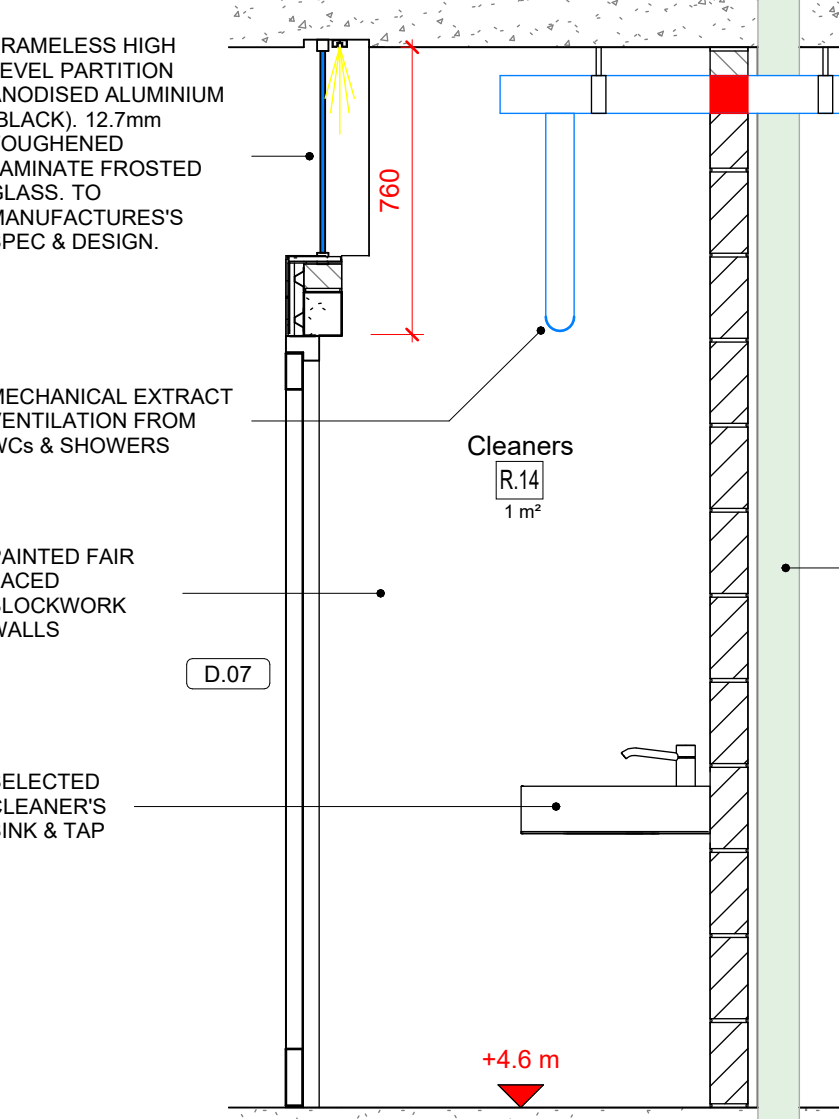


11 ELEVATION - C

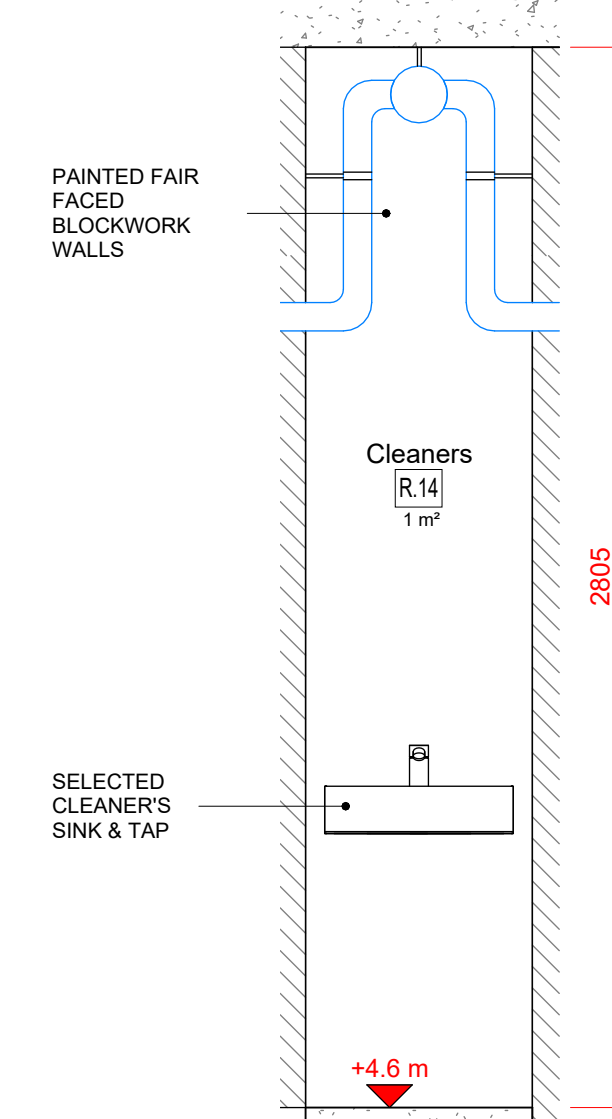

12 ELEVATION - D

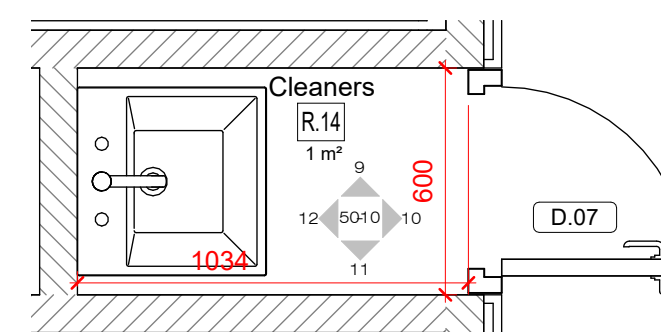

2 FLOOR PLAN

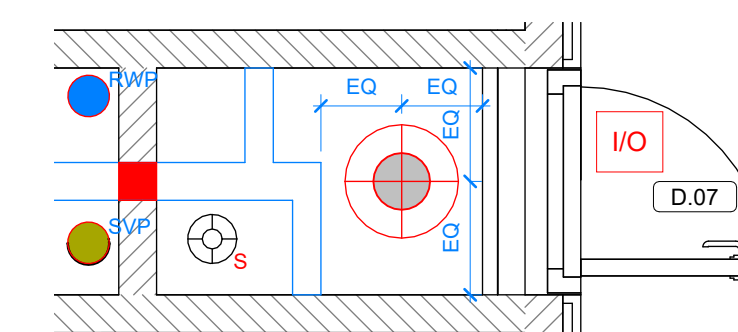

8 REFLECTED CEILING PLAN

NOTE:
Dimensions not to be scaled from drawing.
For any discrepancies found consult with design office.
Copyright © - Cork County Council Architect's Dept.
This drawing to be read in conjunction with all the
Specification Documents.

M&E LEGEND

M&E INDICATIVE ONLY TO BE FULLY
COORDINATED WITH M&E CONSULTANT

All lighting to be energy efficient
LUX LEVEL 200-300 AT FLOOR LEVEL

- | | |
|---|--|
|  | SURFACE MOUNTED CEILING LIGHT WITH EMERGENCY SPOTLIGHT IP65 3200K |
|  | EPOS TERMINAL RECESSED INTO WALL SIZE & FACEPLATE TO BE AGREED |
|  | INTERNAL DOOR LOCK INDICATOR SENSOR SIZE & FACEPLATE TO BE AGREED |
|  | POWER ASSISTED DOOR CLOSER |
|  | PROPOSED POSITION ACCESSIBLE ALARM PANEL & LIGHT |
|  | AUDIBLE ALARM SOUNDER/LIGHT EMERGENCY DOOR RELEASE |
|  | PROPOSED POSITION FUSED SOCKET |
|  | EMERGENCY ALARM RESET BUTTON |
|  | EM EMERGENCY LIGHT 3HR WALL MOUNTED |
|  | EM EMERGENCY LIGHT 3HR SOFFIT MOUNTED |
|  | EM EMERGENCY FLOOD LIGHT 3HR WALL MOUNTED |
|  | SURFACE MOUNTED SMOKE DETECTOR IP 67 |
|  | DISABLED (DAC) ALARM PULL CORD |
|  | INPUT/OUTPUT DEVICE FIRE ALARM |
|  | MECHANICAL EXTRACT VENT (ELEVATION) |
|  | MECHANICAL EXTRACT VENT (PLAN) |
|  | VENT THROUGH TO DUCT |
|  | HEAT DETECTOR IP 67 |
|  | SURFACE WALL MOUNTED UPLIGHTER ON COLUMNS TO LIGHT SOFFIT. IP 67 WITH EMERGENCY LIGHT AND MOTION DETECTION |
|  | SURFACE WALL MOUNTED EXTERNAL LIGHT IP 67 WITH EMERGENCY LIGHT AND MOTION DETECTION |
|  | SURFACE MOUNTED WALL LIGHT FITTING IP67 3200K |
|  | FIRE EXIT SIGNAGE LIGHT IP 67 |

DRAINAGE LEGEND

-  1 NO. FLUSH MOUNTED RECESSED DRAIN
-  1 NO. FLOOR GULLY
-  1 NO. SLOT DRAIN
-  600 x 600 MANHOLE
-  AJ ACCESS
-  SOIL VENT PIPE (SVP)
-  RAIN WATER DOWN PIPE (RWP)
-  GROUPS REQUIRED 171KG LOADING to drop down rails & shower seat & 131KG for grab rails

T.	TENDER ISSUE	13.07.2026
Rev	Description	Date
Revision		

Project Stage: **TENDER**

Comhairle Contae Chorcaí
Roinn na nAiltirí
Seachadadh Caipitil
Halla an Chontae | Corcaigh | T12 R2NC | Éire
An tAiltire Contae | Marcus O'Colleáin

Cork County Council
Architect Department
Capital Delivery Directorate
County Hall | Cork | T12 R2NC | Ireland
County Architect | Mark Collins
T +353-021 428 5430 | architects@corkcoco.ie | www.corkcoco.ie



Protect Title: **Claycastle Watersports Facility**
Youghal Co. Cork

Drawing Title:
ELECTRICAL & CLEANERS

Design Team: Cork County Council Architects Department Capital Delivery	Date: Jan 2023	Dwg No: 50
	Scale: 1:20	
	Sheet: A1	
	Stage ID: T	

File. No: **CCWF-CCC- ZZ- 00-DR-A- 5010**

Job No: **ATS1 S 2021 025**