

Notes

GENERAL NOTES:


1. DO NOT SCALE DRAWING. USE FIGURED DIMENSIONS ONLY.
2. THIS DRAWING IS TO BE READ IN CONJUNCTION WITH ALL OTHER RELEVANT ARCHITECTURAL, MECHANICAL/ELECTRICAL AND ENGINEERING DRAWINGS.
3. STRUCTURAL CONCRETE TO BE AS PER SPECIFICATION OR SIMILAR APPROVED. UNO.
4. ALL REINFORCEMENT TO BE INSPECTED BY ENGINEER PRIOR TO POURING CONCRETE.
5. FOR ALL SETTING OUT, REFER TO ARCHITECT'S DETAILS.
6. THE CONTRACTOR IS RESPONSIBLE FOR ALL TEMPORARY WORKS REQUIRED IN ORDER TO CONSTRUCT THE BUILDING, whilst MAINTAINING OVERALL STABILITY OF THE EXISTING BUILDING.
7. ALL FLOOR BUILD UPS, INSULATION, DPC AND RAJOON DETAILS SHOWN ON THESE DRAWINGS ARE FOR ILLUSTRATION PURPOSES ONLY.
8. USE PROPRIETARY GALVANISED JOIST HANGERS AT ALL TIMBER JOINTS. UNO.
9. THERMAL BLOCKS TO BE PROVIDED AT THE BASE OF ALL LOADEARING CONSTRUCTION DETAILS.
10. BOTTOM OF TRENCHES TO BE CLEANED AND SLOPED OFF BY ENGINEER PRIOR TO THE POURING OF ANY CONCRETE.
11. ALL WORKS CARRIED OUT MUST COMPLY WITH THE RELEVANT PARTS OF THE BUILDING REGULATIONS AND TECHNICAL GUIDANCE DOCUMENTS.
12. ENSURING THE WORKS ARE CARRIED OUT USING PROPER MATERIALS WHICH ARE FIT FOR USE FOR WHICH THEY ARE INTENDED AND FOR THE PURPOSES OF THE PROJECT.
13. ALL MATERIALS USED SHALL BE CE MARKED IN ACCORDANCE WITH THE EU CONSTRUCTION PRODUCT REGULATIONS (CPR) (No.305201/1). REFER TO ANNEX IV OF THE REGULATIONS FOR THE LIST OF APPLICABLE PRODUCTS.

LEGEND:




LEGEND

- 100mmØ FOUL SEWER
- 100mmØ STORM SEWER
- ARMSTRONG JUNCTION
- POP-UP
- BACK INLET GULLY TRAP
- GULLY TRAP
- LINEAR DRAIN
- INSPECTION CHAMBER

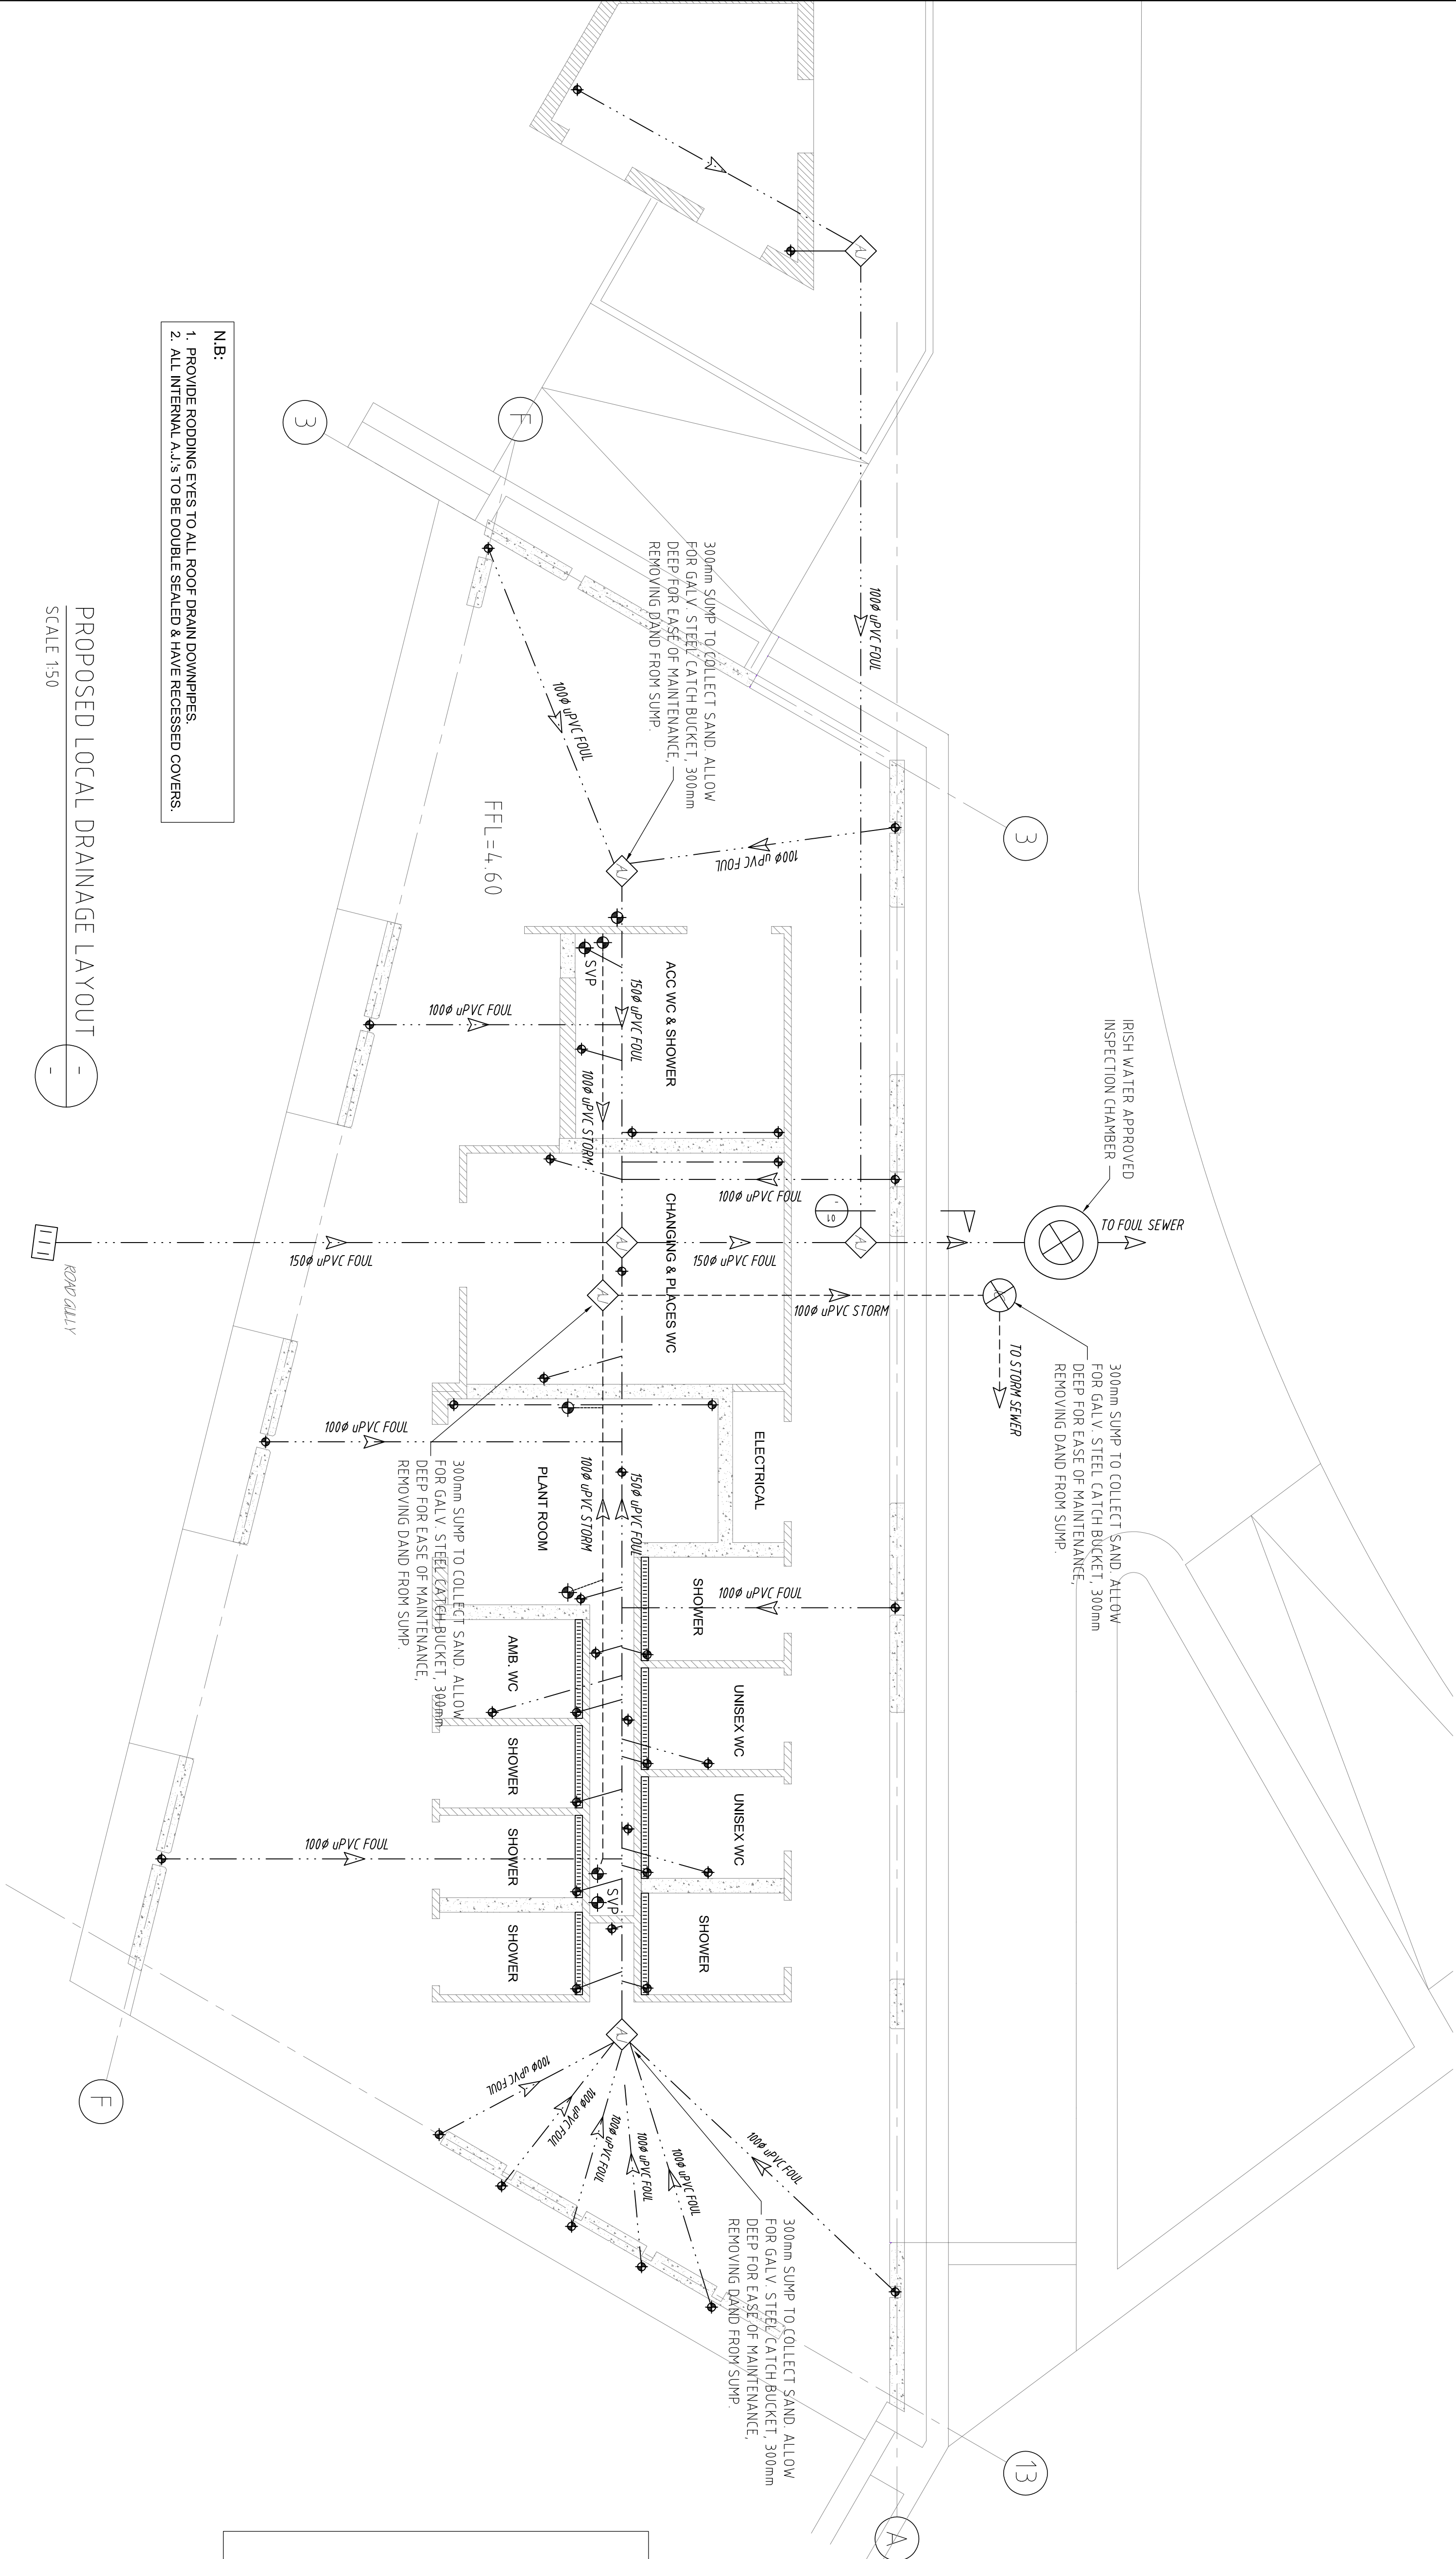

- NB:
1. PROVIDE RODDING EYES TO ALL ROOF DRAIN DOWNPIPES.
 2. ALL INTERNAL A.J.'s TO BE DOUBLE SEALED & HAVE RECESSED COVERS.

PROPOSED LOCAL DRAINAGE LAYOUT
SCALE 1:50

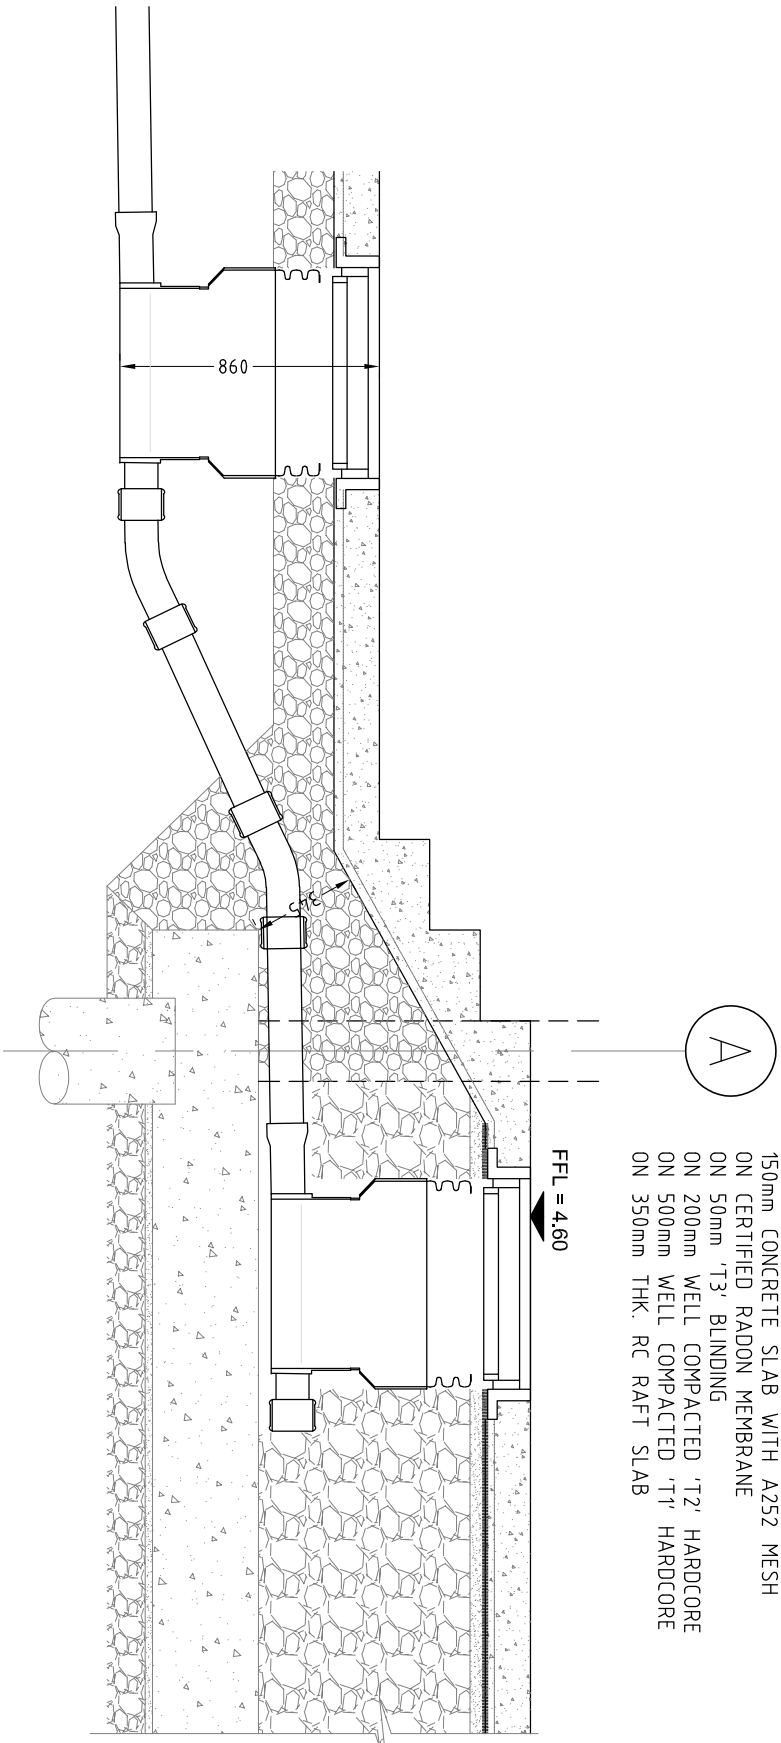

SECTION 01
SCALE 1:25

Rev	Date	Drawn	Description
1	16th Feb 26	GR	Issued for Tender
2	16th Feb 26	GR	Maintenance Sumps Added to S.N.O. A.J.s & 150mm Ø



CONSULTING ENGINEERS
CIVIL | STRUCTURAL | PROJECT MANAGEMENT

2 Clonkeen Business Park,
Blarney Road, Cork,
Ireland.

T: +353 (0)21 4399799
F: +353 (0)21 4399797
E: admin@rka.ie
W: www.rka.ie



Client:	
Cork County Council	
Project:	
Claycastle Watersports Facility, Youghal, Co. Cork.	

Drawing Title:			
Proposed Local Drainage Layout			
Designed: BA	Drawn: GR	Date: Feb. 26	
Eng. Chk: BA	Dwg. Chk: BA	Scale: AS SHOWN	
Project No: 572			
Drawing No: 03	Status: Tender	Rev: T2	