


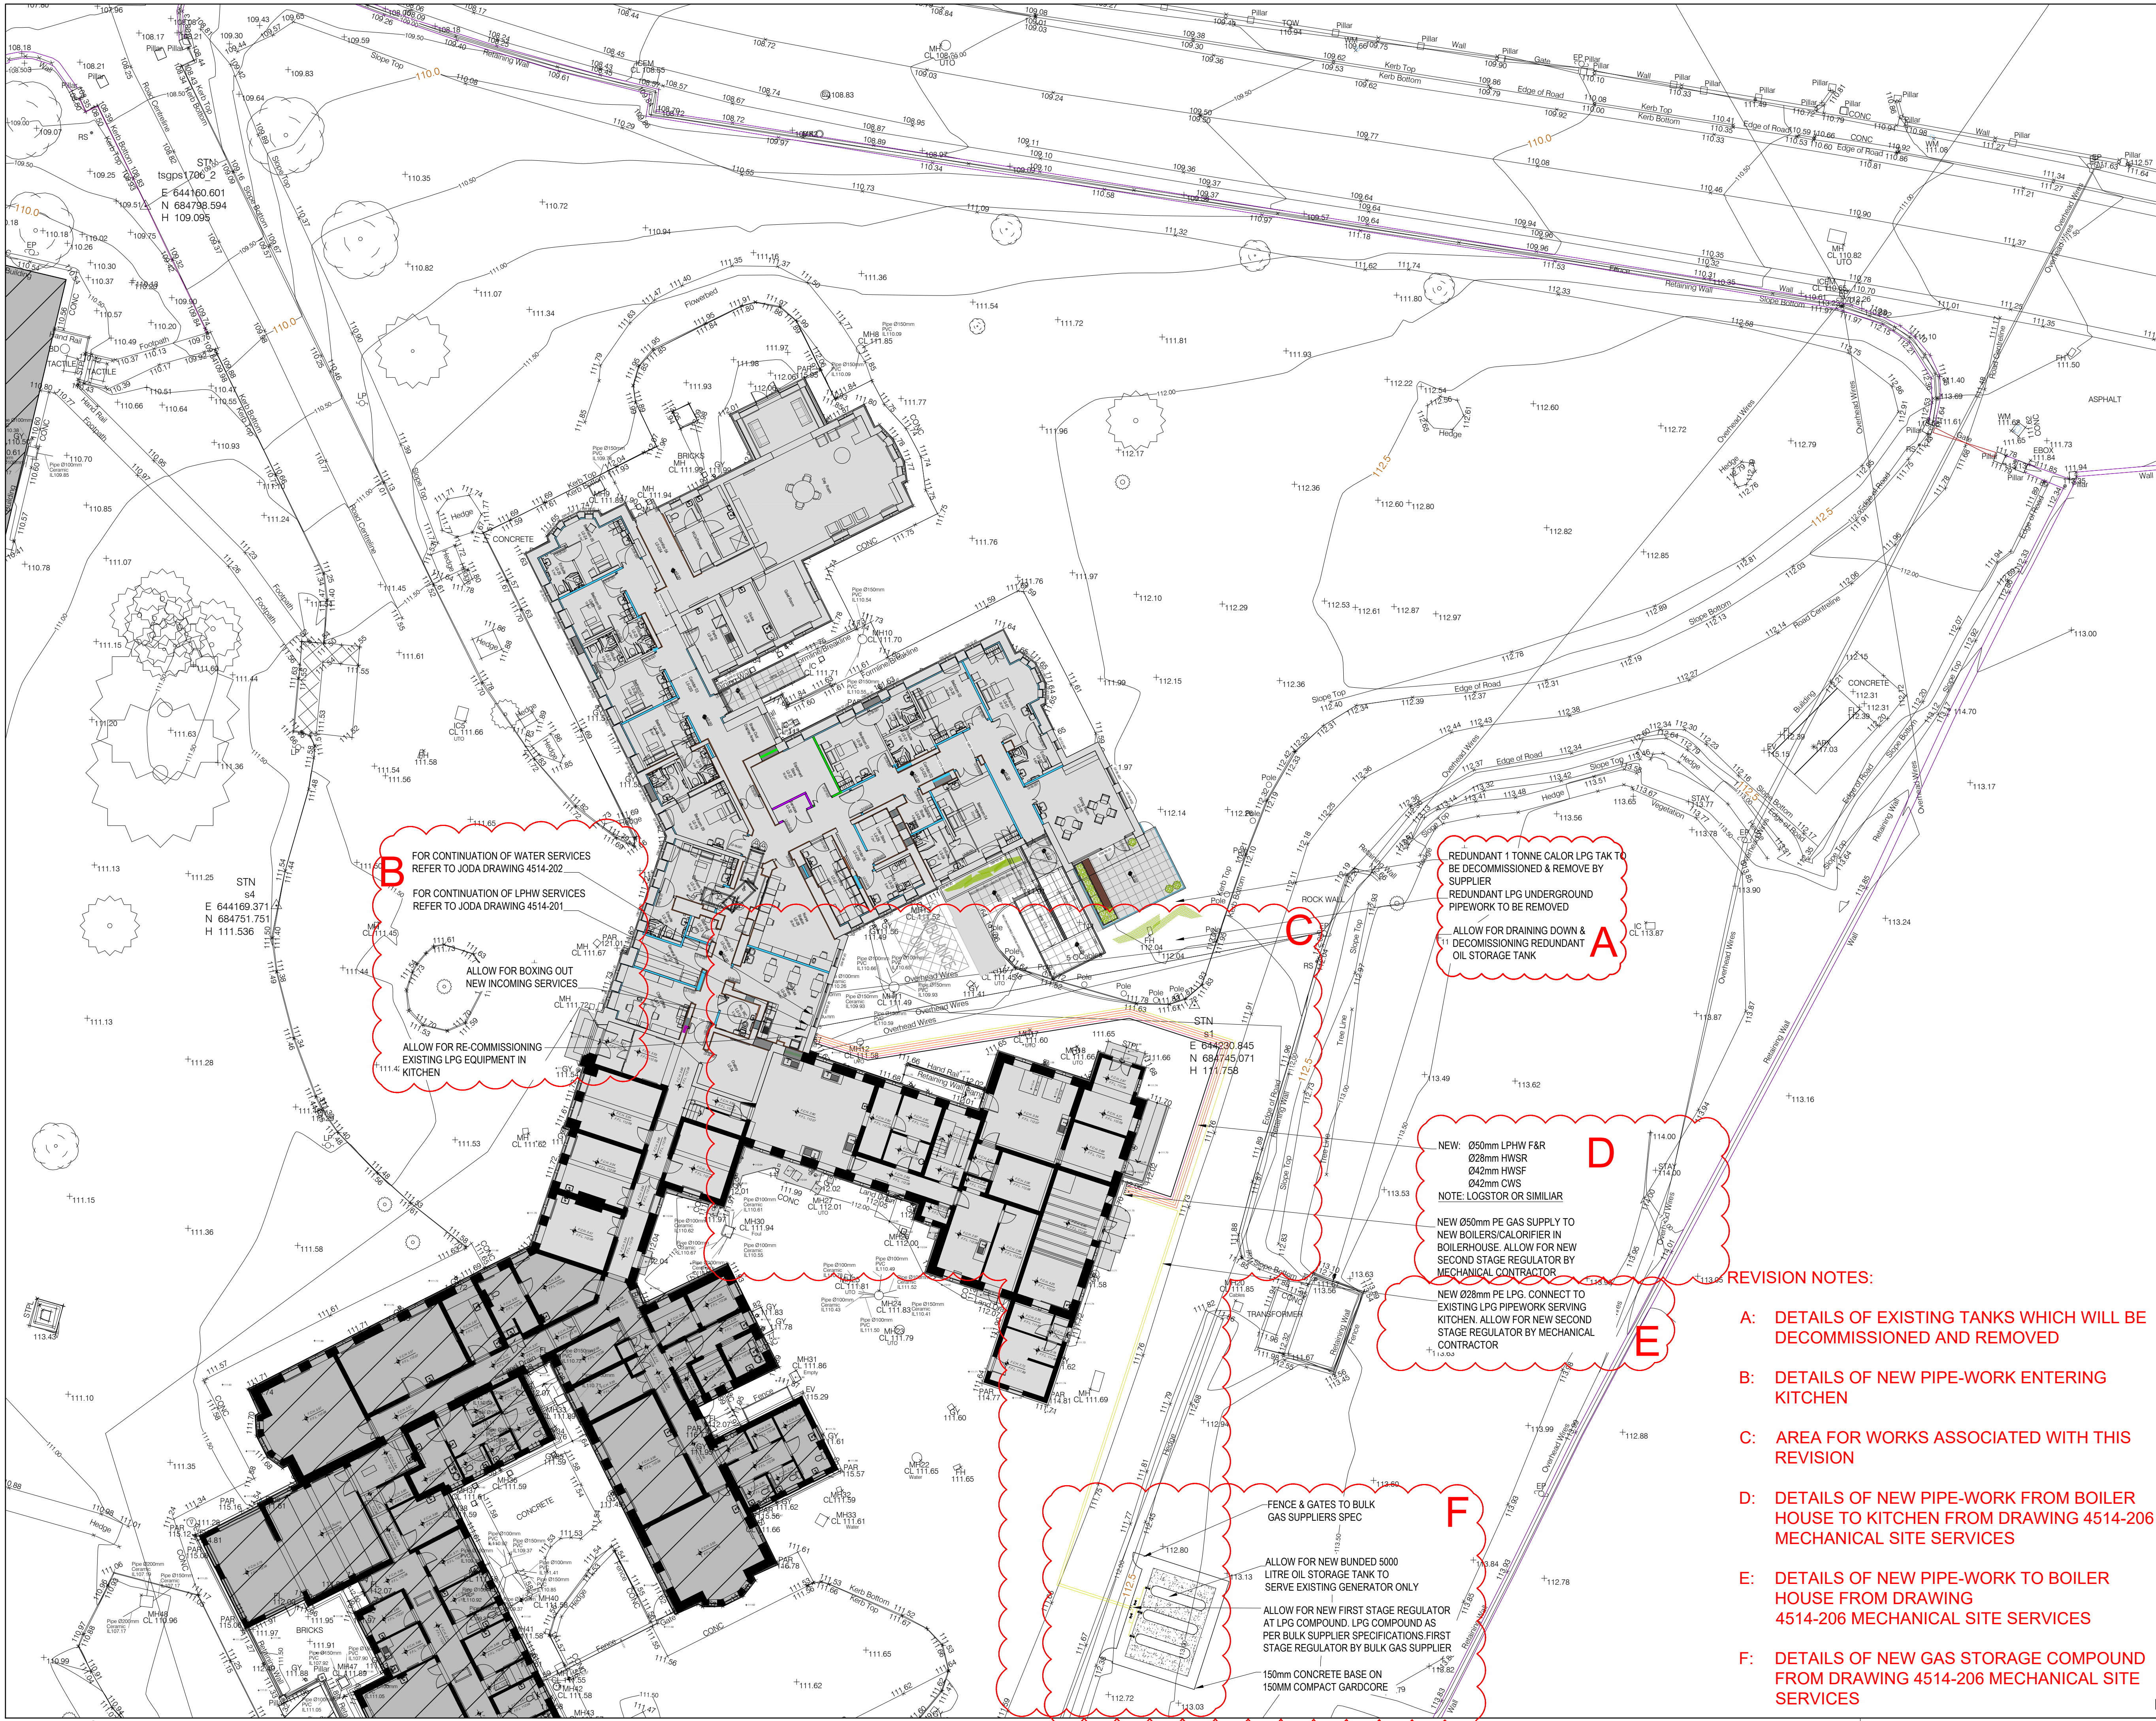

Note:
Contractors are responsible for the verification of all dimensions on site and the architect is to be informed in written format of any discrepancies prior to commencement of works.
Do not scale, use figured dimensions only.
Information shown here is of the Architectural intent, and shall be read in conjunction with all relevant drawings & specifications and all other consultant informations.
This drawing may contain Ordnance Survey Ireland map and Raster Data.

Model File References List -XRef Model Name, Version & Status:

- LANDSCAPING:**
See drawing 801 for details
- Paving to Clause Q25-120 with glazed balustrade to Clause L30-580
 - Raised Planter with bench to Clause Q25-292
 - 3 No Terracota Pots to Clause Q25-292A
 - Denotes Low level planting & lawn Refer to clauses in sections Q30/Q31 See drawing 801 for further information

- GENERAL NOTES:**
- FOR DETAILS OF NEW FOOTPATH & RAMP SEE CIVIL ENGINEER'S DRAWINGS. (UNDER REVIEW FOLLOWING FIRE STRATEGY LAYOUT RECEIVED 05/11/2020)
 - SEE DRAWING HSEDML+PAW_6609_801 LANDSCAPING DETAILS.
 - SEE MECHANICAL & CIVIL ENGINEER'S DRAWING FOR DETAILS OF NEW GAS TANK & BASE
 - SEE STRUCTURAL ENGINEER'S DRAWING FOR DETAILS OF RAMP CONSTRUCTION.
 - SEE CIVIL ENGINEER'S DRAWINGS. RESURFACE DRIVEWAY AND INSTALL NEW MANHOLES & DRAINAGE
 - REINSTATE AREA TAKEN AS BUILDER'S COMPOUND AT COMPLETION OF WORKS
 - SEE DRAWING HSEDML+P+W-6609-110 PROPOSED GROUND FLOOR PLAN

FOR CONSTRUCTION

Rev	Dm	Date	Description
-----	----	------	-------------

Key Plan

NEW: Ø50mm LPHW F&R Ø28mm HWSR Ø42mm HWSF Ø42mm CWS NOTE: LOGSTOR OR SIMILAR NEW Ø50mm PE GAS SUPPLY TO NEW BOILERS/CALORIFIER IN BOILERHOUSE. ALLOW FOR NEW SECOND STAGE REGULATOR BY MECHANICAL CONTRACTOR NEW Ø28mm PE LPG. CONNECT TO EXISTING LPG PIPEWORK SERVING KITCHEN. ALLOW FOR NEW SECOND STAGE REGULATOR BY MECHANICAL CONTRACTOR
--

REVISION NOTES:

A: DETAILS OF EXISTING TANKS WHICH WILL BE DECOMMISSIONED AND REMOVED

B: DETAILS OF NEW PIPE-WORK ENTERING KITCHEN

C: AREA FOR WORKS ASSOCIATED WITH THIS REVISION

D: DETAILS OF NEW PIPE-WORK FROM BOILER HOUSE TO KITCHEN FROM DRAWING 4514-206 MECHANICAL SITE SERVICES

E: DETAILS OF NEW PIPE-WORK TO BOILER HOUSE FROM DRAWING 4514-206 MECHANICAL SITE SERVICES

F: DETAILS OF NEW GAS STORAGE COMPOUND FROM DRAWING 4514-206 MECHANICAL SITE SERVICES

PASCALL +WATSON
11 Mallow Street Limerick Ireland
+353 (0)61 310 890 www.pascalls.ie

SITE PLAN - DETAIL PROPOSED

Project Name	COVID WORKS AT ABBEYLEIX CNU	Client Job No.	
Client	HSE DUBLIN MID LEINSTER	Drawing Originator	Pascall+Watson Architects
Purpose of Issue	CONSTRUCTION	Status	03
Drawn By	BQ	Checked By	JF
Approved By	AMN	Drawn Date	15/10/2020
Client	HSEDMLPAW	Project Ref.	6609
Originator		Level	-
Drawing No.	012	Revision	C0