


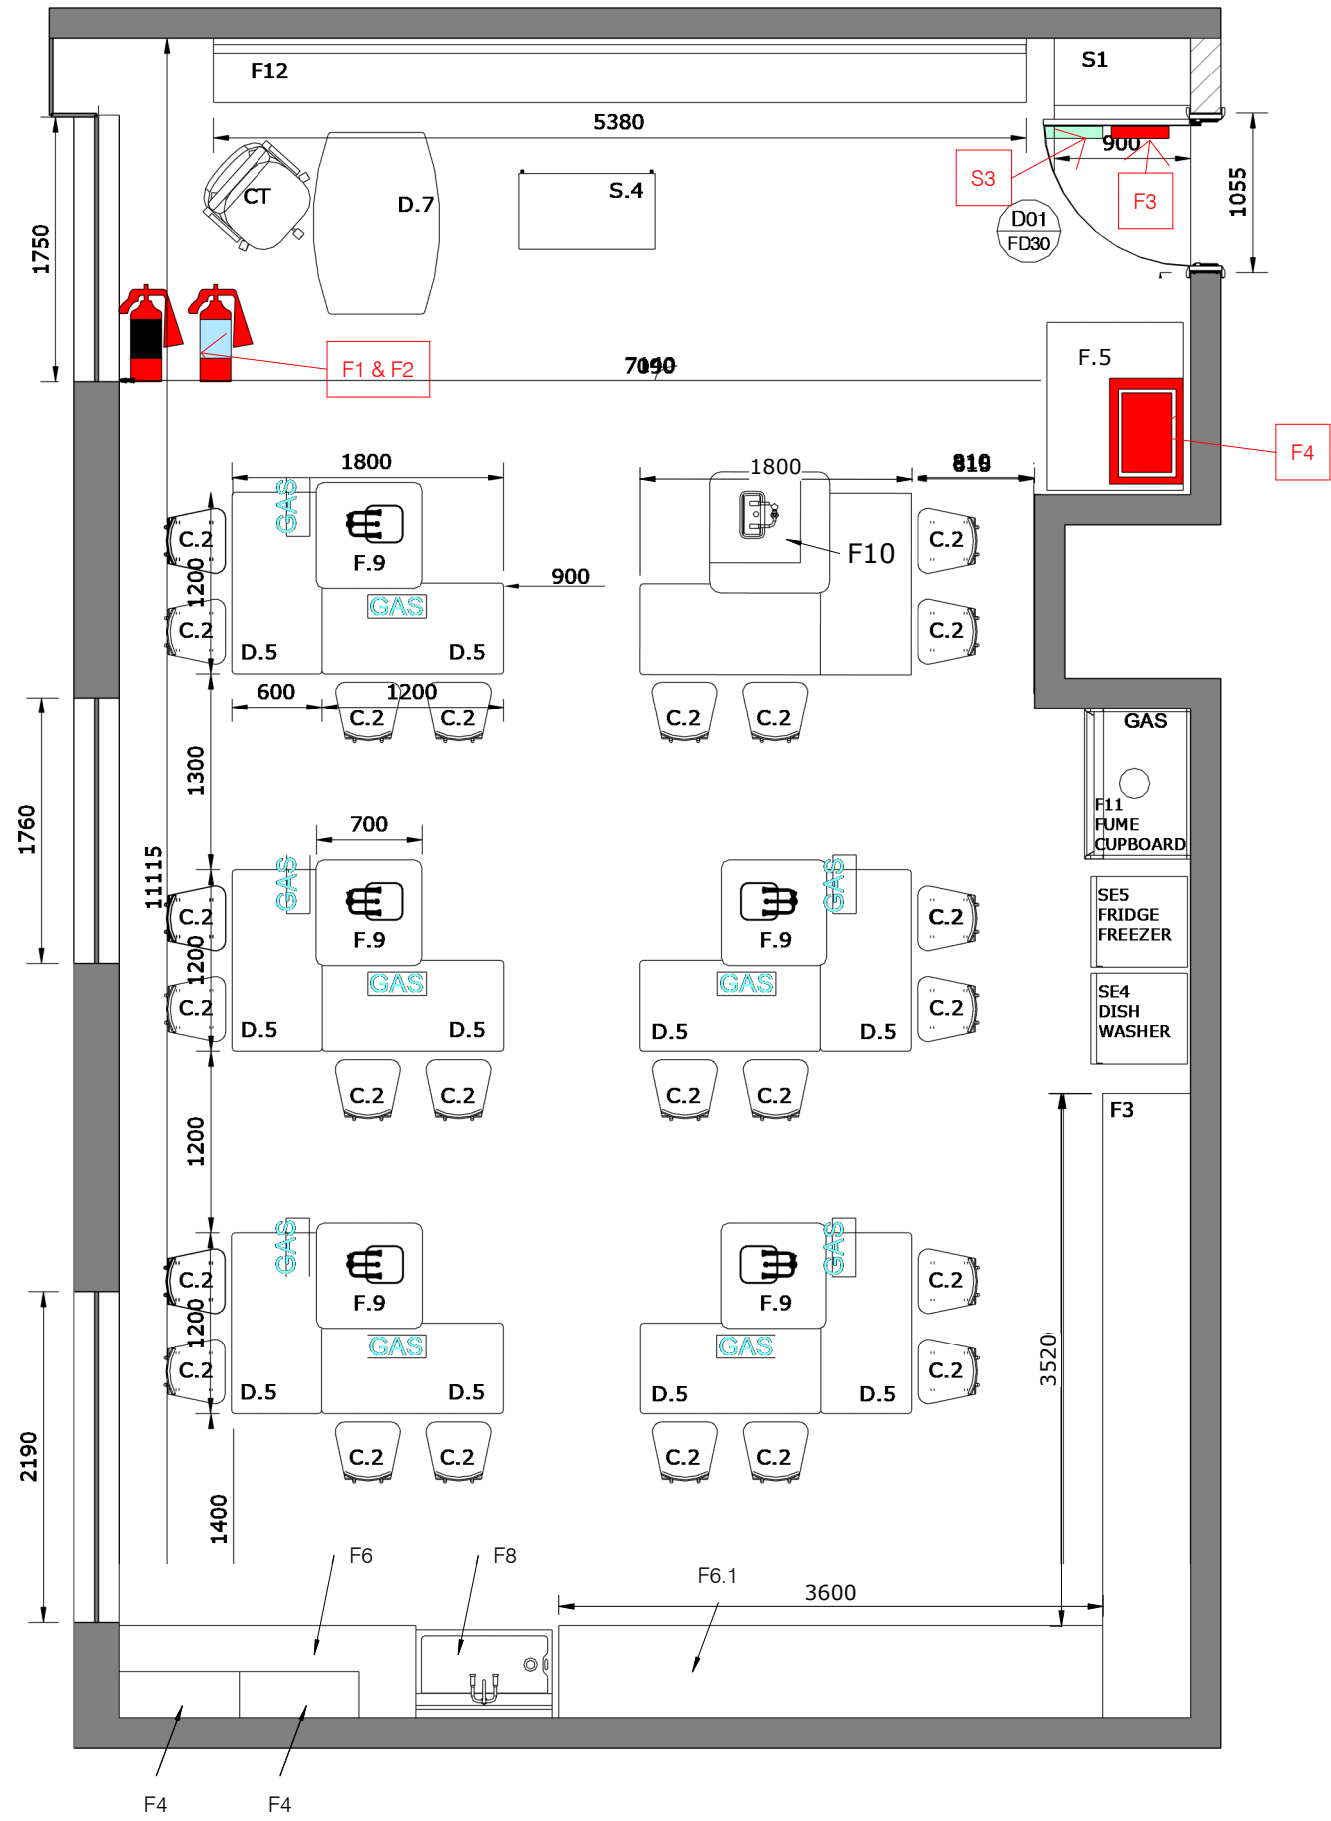

1 Proposed Signage Plan
1 : 50

PROPOSED SIGNAGE PLAN

NOTE : BUILDING LEGEND TO BE READ IN CONJUNCTION WITH ACCOMPANYING DRAWINGS AND SPECIFICATION DOCUMENTS.

F1 & F2
PROPOSED SIGNAGE TO ACCOMPANY THE PROPOSED CO2 AND POWDER FIRE EXTINGUISHERS TO HAVE 90 X 280mm SIGNAGE ABOVE THEM MATERIALS OF THE SIGNS ARE TO BE POLOPROPYLENE. SIGNS ARE TO BE FITTED 1300mm ABOVE THE FINIHSED FLOOR LEVEL.

F3
KCC GRADE 304 STAINLESS STEEL FIRE DOOR KEEP SHUT SIGN - WHITE TEXT

F4
FIRE BLANKET SIGNAGE. TO BE 1300MM ABOVE FLOOR LEVEL

S3
ROOM NAME AND ROOM NUMBER. STYLE OF SIGN TO BE CONFIRMED BY THE SCHOOL. PRIOR TO ORDERING

NOTE: THIS DRAWING IS FOR SIGANAGE ONLY, TO BE READ IN CONJUNCTION WITH ACCOMPANYING FLOOR PLAN DRAWINGS AND SPECIFICATION DOCUMENTS.

RIAI

Registered Architect

2024

Architect Accredited in Conservation

G3

PSDP Accreditation

P

A2

THIS DRAWING IS COPYRIGHT. USE DIMENSIONS ONLY - DO NOT SCALE. CONTRACTORS MUST VERIFY DIMENSIONS ON SITE PRIOR TO STARTING WORK.

MCLA

TENDER PURPOSES ONLY

Rev	Description:	Date:	Rev	Description:	Date:

MCLA

Unit 4B, Elm House,
Millennium Park,
Naas, Co. Kildare.
W91 K032
T: +353(0)45 854900
E : info@mclarchitecture.ie

Client : BOM CBS James Street
Project : Science Lab Works CBS James Street
Drawing Title : Proposed Signage Plan

Project No. : 26 15
Drawing No. : T105
Scale : 1 : 50
Date : June 2026
Drawn : David Farrell