
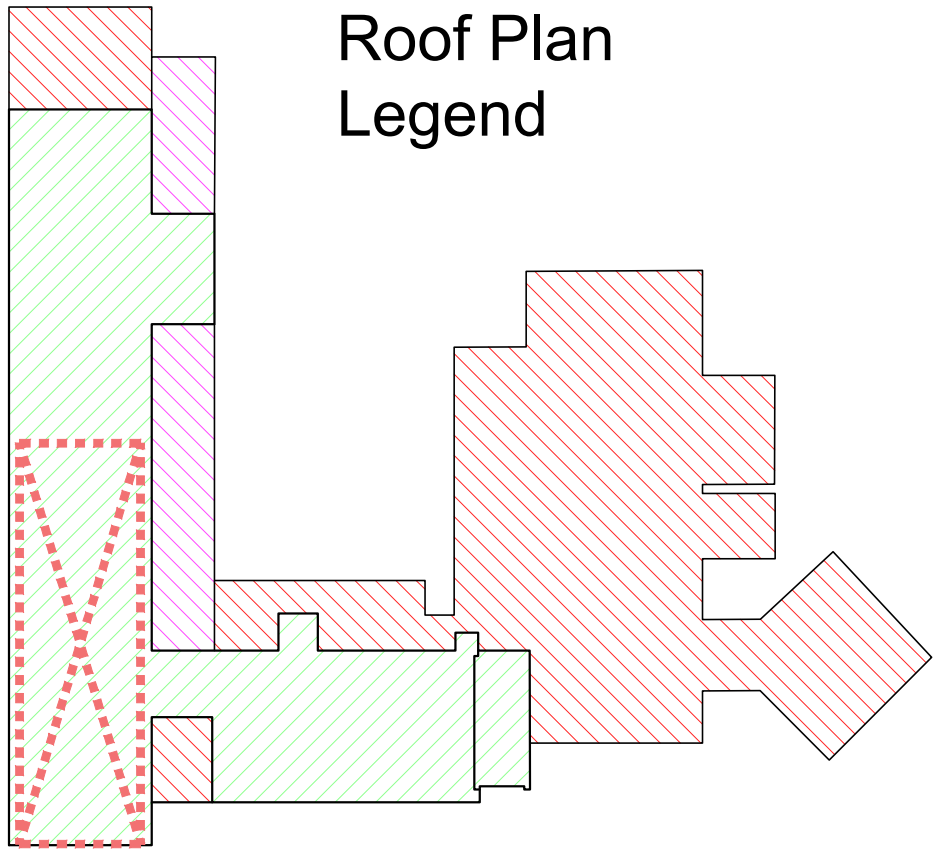


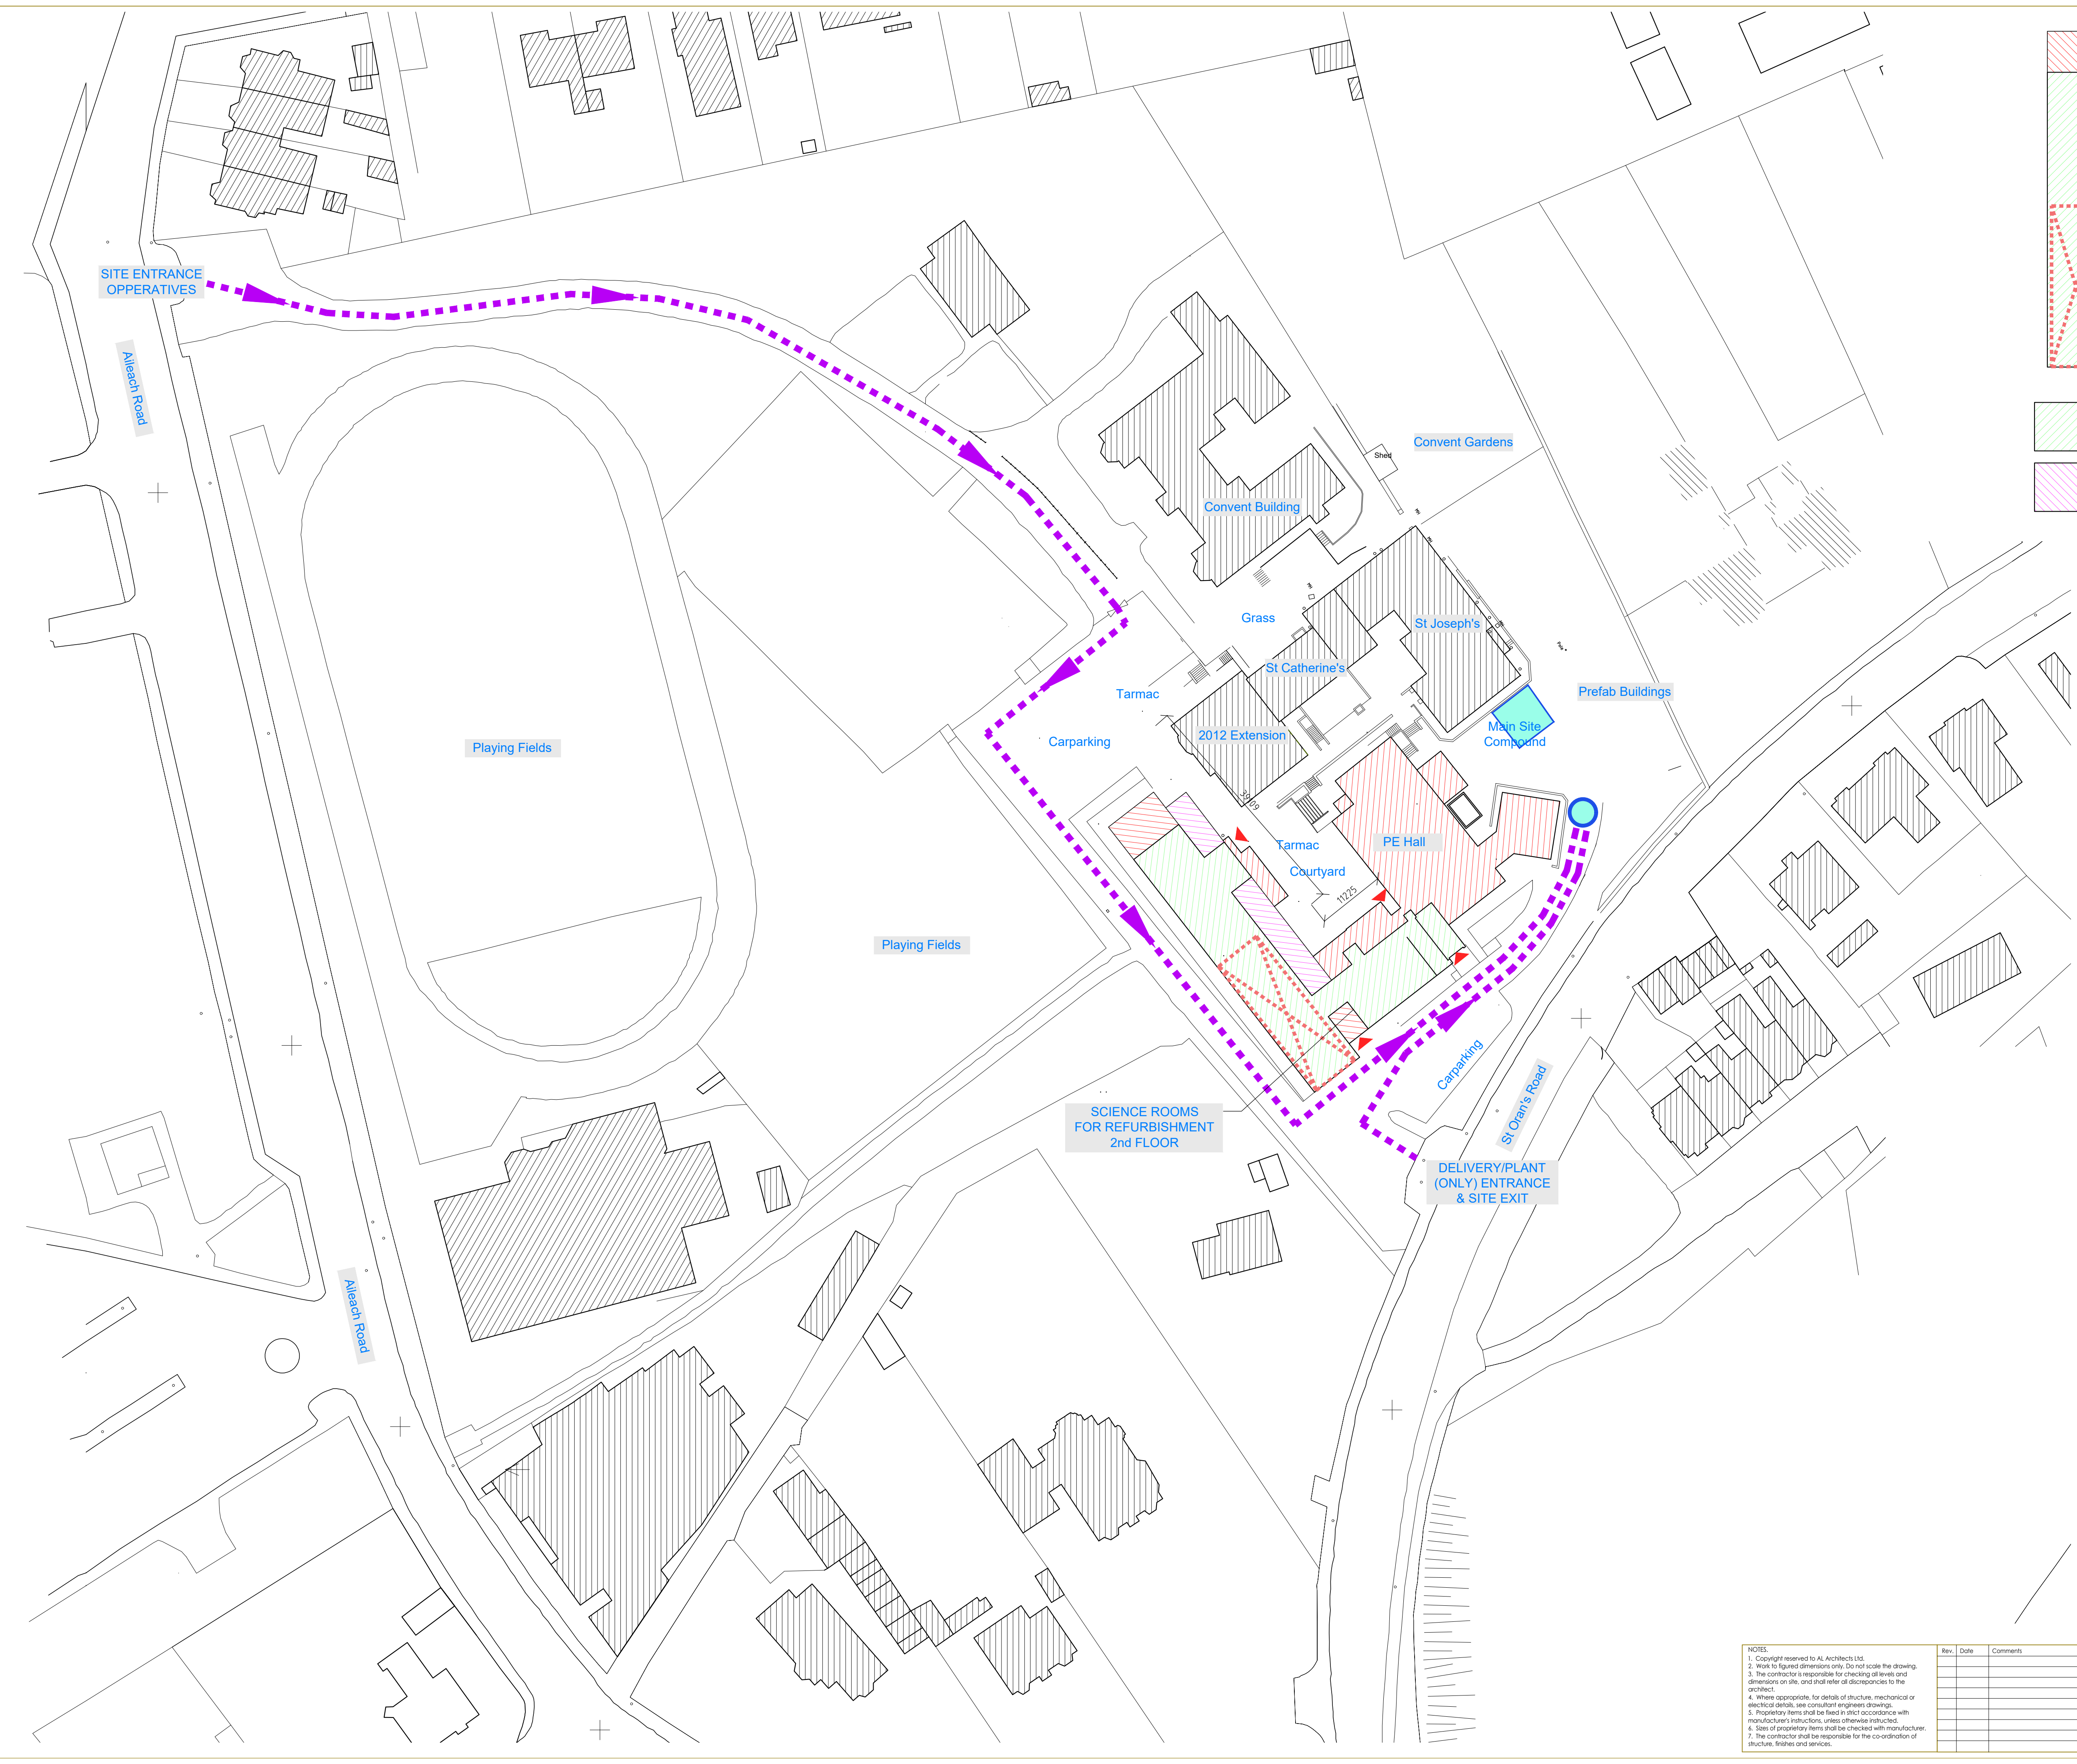

- 2nd Floor Level
Pitched Roof Works
- 1st Floor Level Flat
Roof Works
- Excluded Zones
- Other Buildings
- Science Rooms for
Refurbishment
on 2nd Floor

	SITE COMPOUND/OFFICE / CONTAINERS
	ACCESS FOR SITE TRAFFIC DURING CONSTRUCTION
	HOARDING / FENCING AROUND COMPOUND / YARD
	BUILDING ACCESS POINTS - TO BE AGREED
	LOADER/LIFTING ACCESS TO ROOFS
	GOOD DROP OFF LOCATIONS
	NEW UNDERGROUND GAS LINE

NOTES:
1. Copyright reserved to AL Architects Ltd.
2. Work to figured dimensions only. Do not scale the drawing.
3. The contractor is responsible for checking all levels and dimensions on site, and shall rectify all discrepancies to the architect.
4. Where appropriate, for details of structure, mechanical or electrical details, see consultant engineers drawings.
5. Proprietary items shall be fixed in strict accordance with manufacturer's instructions, unless otherwise instructed.
6. Sizes of proprietary items shall be checked with manufacturer.
7. The contractor shall be responsible for the coordination of structure, finishes and services.

Rev.	Date	Comments

AL
Architects

Chartered Architects | Surveyors | Project Managers.

Office 88, The Courtyard, Lower Main Street, Letterkenny,
Co. Donegal, Ireland, F92 GN13
Tel: +353 (0)749128222, Fax: +353 (0)749129903.
Email: info@alarchitects.com

Project

Refurbishment of Science Rooms at
Scoil Mhuire, Buncrana,
Co. Donegal

Drawing Title

Site Layout Plan

Date

2.07.2026

Drawn

DK

Scale

1:500

Print as

A1

Project No.

S074-01

Rev.

-

Drawing No.

S07401-ALA-XX-ZZ-DR-AR-10001