


NOTES:
1. Copyright reserved to AL Architects.
2. Work to figured dimensions only. Do not scale the drawing.
3. The contractor is responsible for checking all levels and dimensions on site, and shall refer all discrepancies to the architect.
4. Where appropriate, for details of structure, mechanical or electrical details, see consultant engineers drawings.
5. Proprietary items shall be fixed in strict accordance with manufacturer's instructions, unless otherwise instructed.
6. Sizes of proprietary items shall be checked with manufacturer.
7. The contractor shall be responsible for the co-ordination of structure, finishes and services.

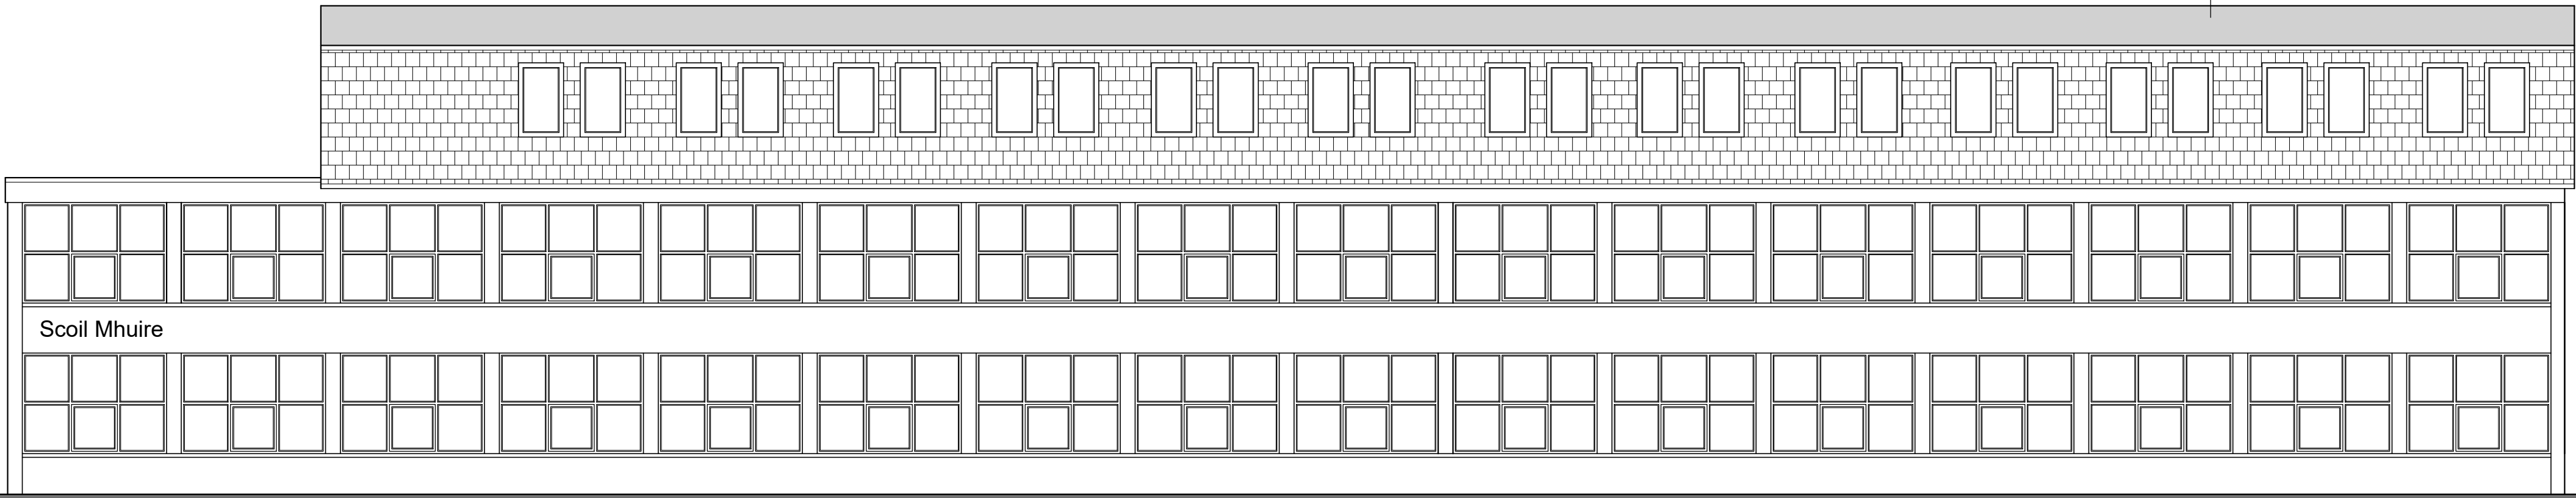


Existing Elevation 1

Science Classroom Location



Existing Elevation 2

Science Classroom Location

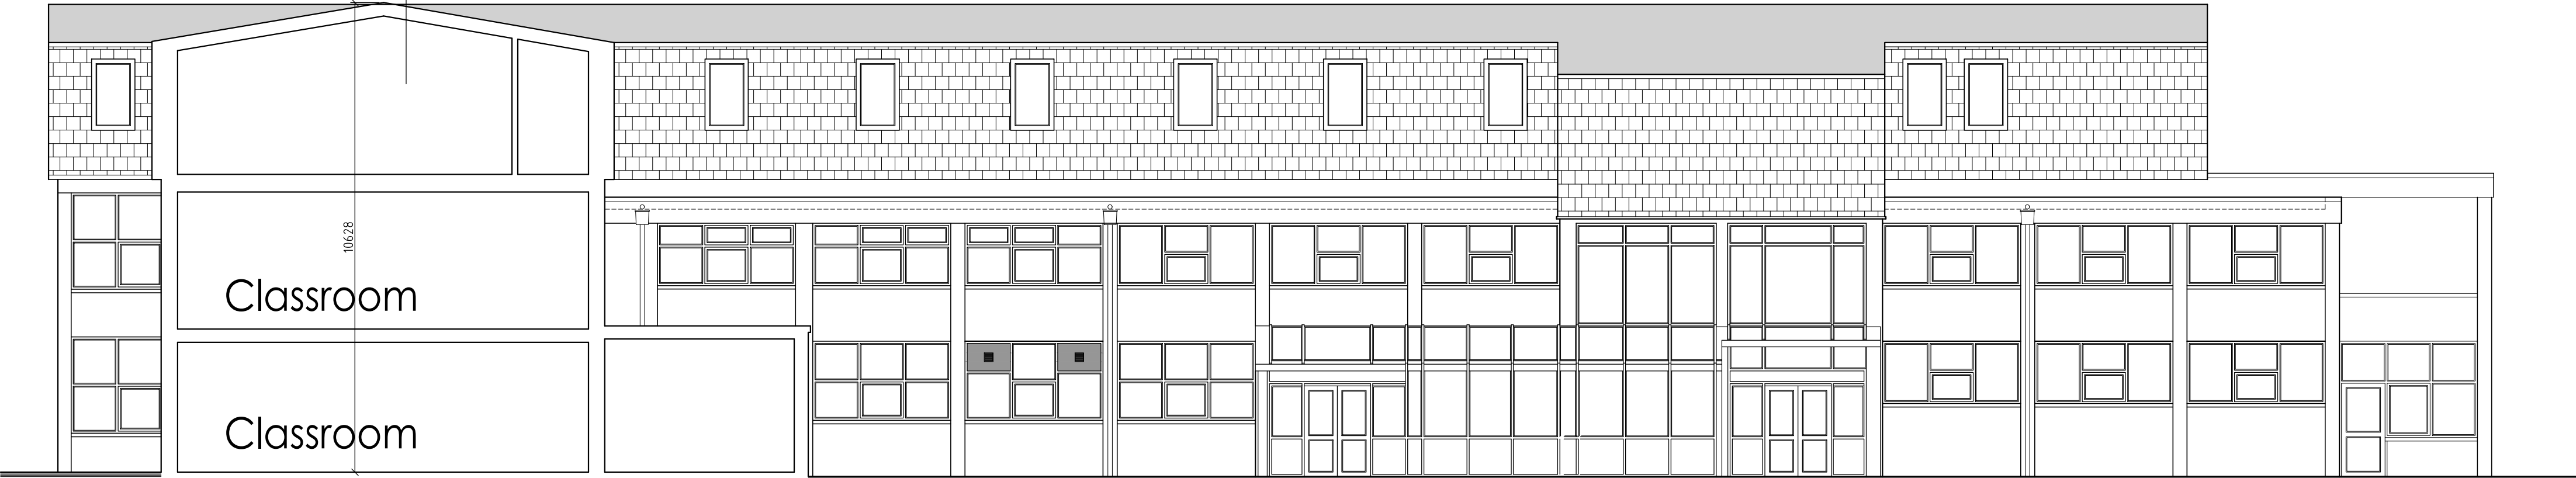

Existing Sectional Elevation A-A

Rev.	Date	Comments	Project
			Refurbishment of Science Rooms at Scoil Mhuire, Buncrana, Co. Donegal.
Drawing Title			Existing Elevations & Section A-A
Date		6.07.2026	Drawn DD
Scale		1:100	Print as A1
Project No.		S074-01	Rev. -
Drawing No.		S07401-ALA-XX-ZZ-DR-AR-10004	