



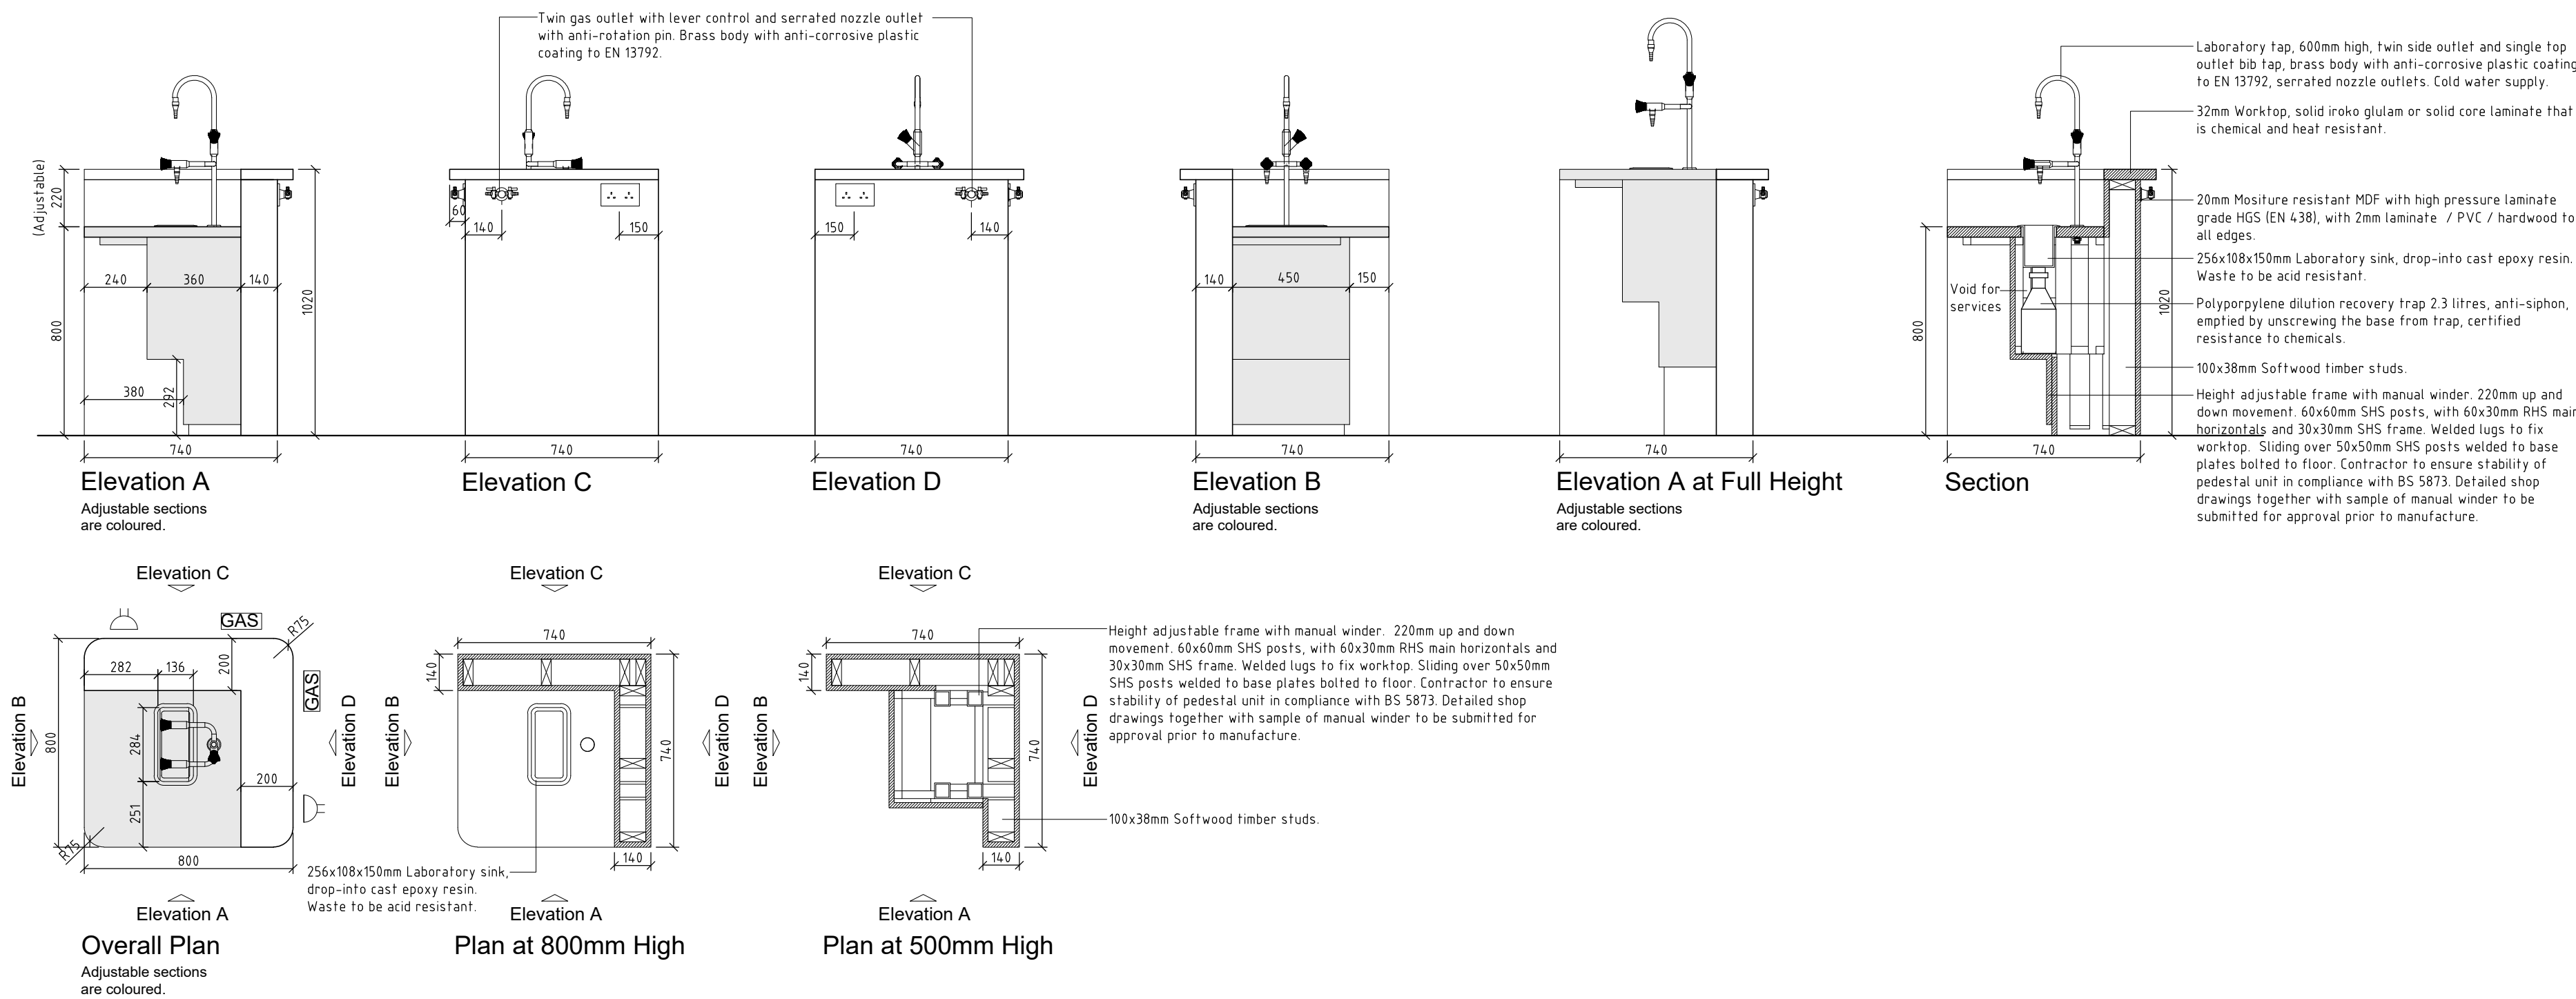

Student Pedestal (Accessible) F.12

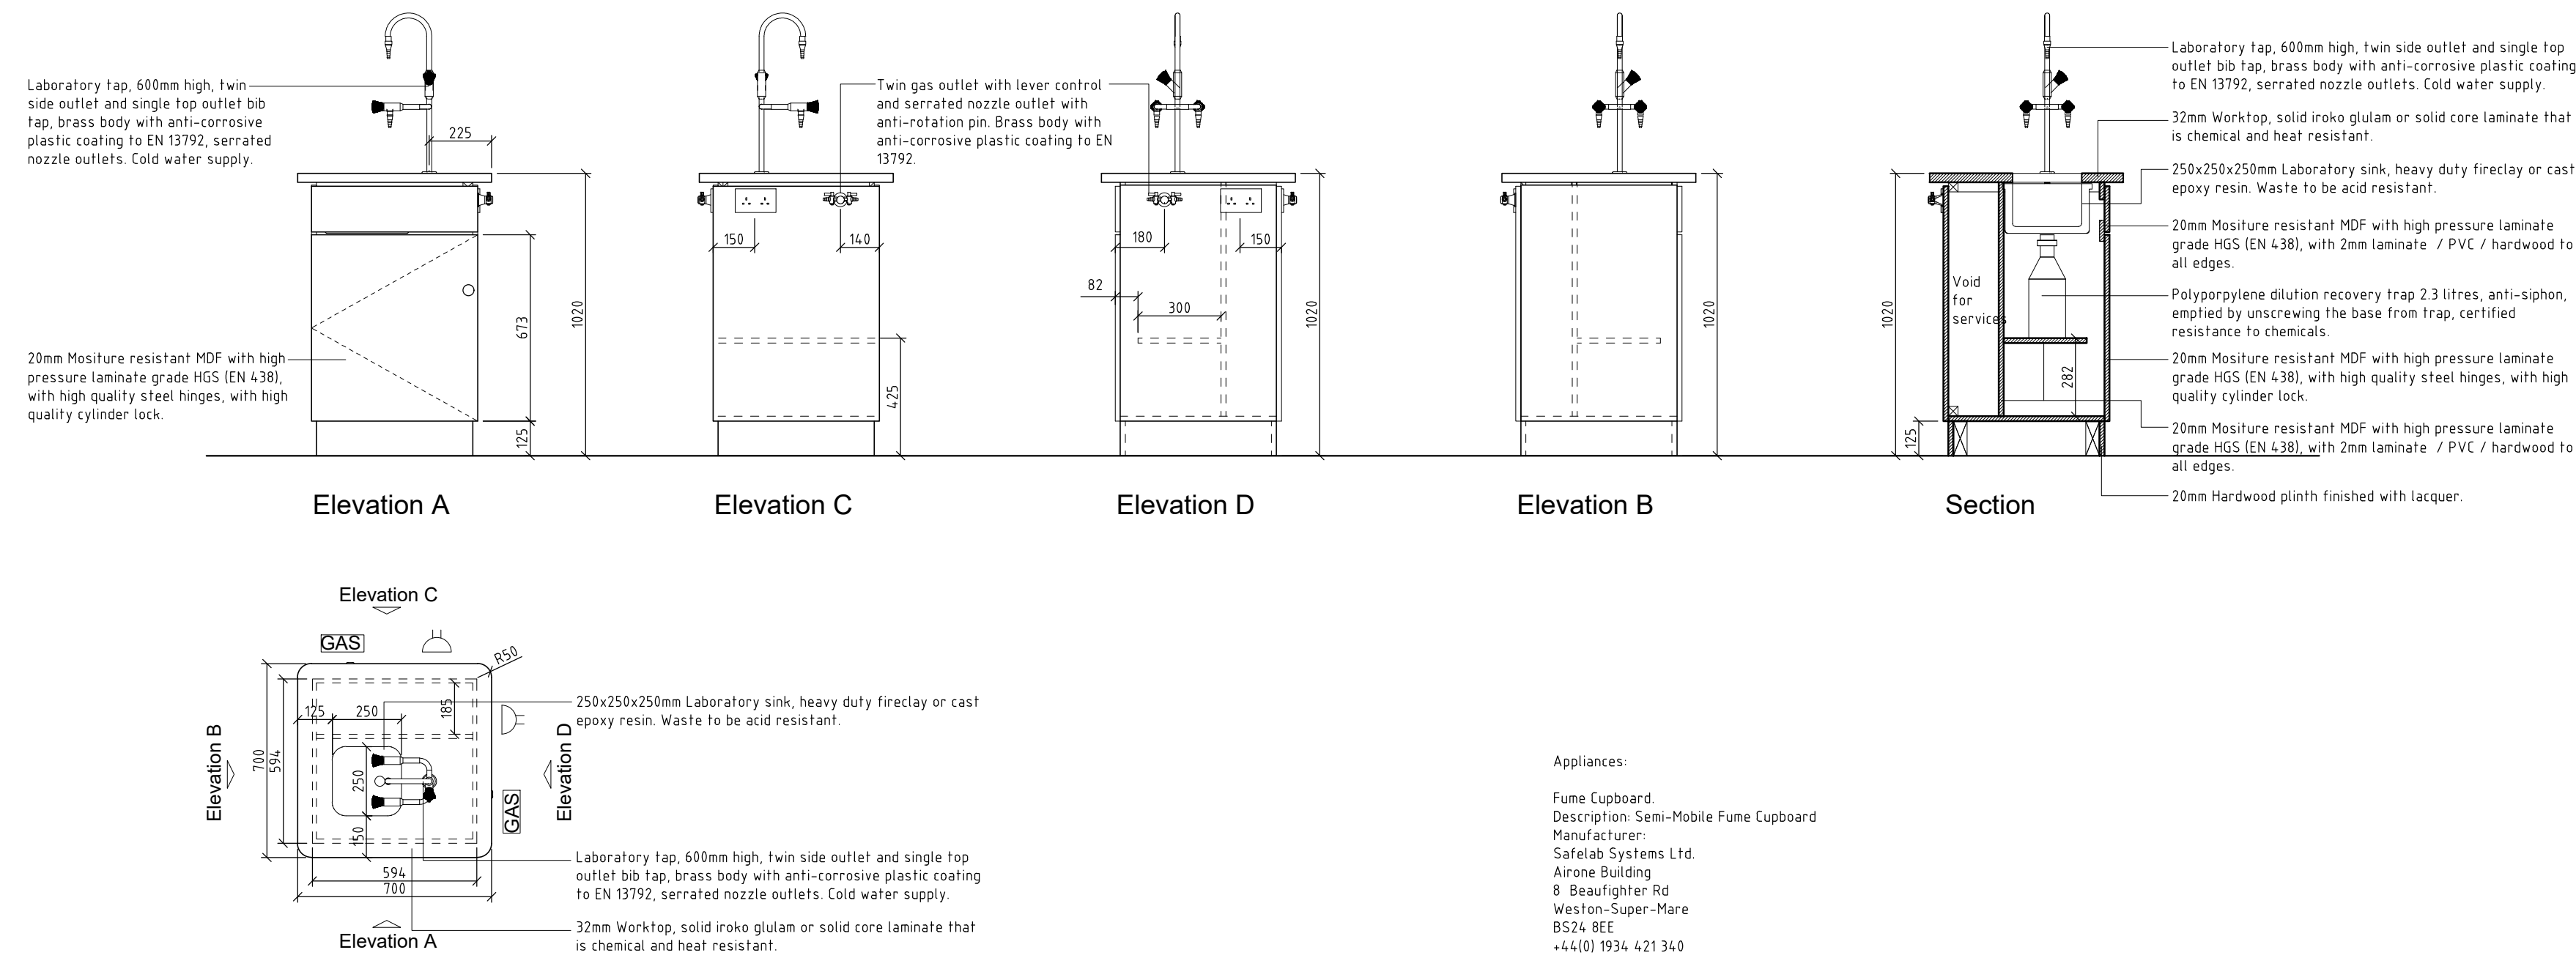

Overall Plan

Student Pedestal 1-5

Appliances:

Fume Cupboard.
Description: Semi-Mobile Fume Cupboard
Manufacturer:
Safelab Systems Ltd.
Airone Building,
8 Beaufighter Rd
Weston-Super-Mare
BS24 8EE
+44(0) 1934 421 340
enquiries@safelab.co.uk

Irish Distributor:
Lennox - Niamh Sheridan
01 460 7617

Product Reference: Airone 10000S Semi-Mobile Ducted Fume
Cpd
Dimensions: 1000 (w) x 700 (d) x 1850 (h) mm.
Material: Epoxy coated mild steel carcass, safety glass sides
and rear panel, clear back baffle and top panel,
counterweighted front sliding sash, polypropylene spillage
tray, profiled aluminum aerofoils, stainless steel cill,
restraining Stainless Steel Tether.
Finish/Colour: As manufacturers finish.

NOTES:

1. Copyright reserved to AL Architects.
2. Work to figured dimensions only. Do not scale the drawing.
3. The contractor is responsible for checking all levels and dimensions on site, and shall refer all discrepancies to the architect.
4. Where appropriate, for details of structure, mechanical or electrical details, see consultant engineers drawings.
5. Proprietary items shall be fixed in strict accordance with manufacturer's instructions, unless otherwise instructed.
6. Sizes of proprietary items shall be checked with manufacturer.
7. The contractor shall be responsible for the co-ordination of structure, finishes and services.

Rev. Date Comments

Rev.	Date	Comments
1	10-06-2026	10-06-2026
2	10-06-2026	10-06-2026
3	10-06-2026	10-06-2026
4	10-06-2026	10-06-2026
5	10-06-2026	10-06-2026
6	10-06-2026	10-06-2026
7	10-06-2026	10-06-2026

Tender Issue

AL Architects

Chartered Architects | Surveyors | Project Managers.

Office 88, The Courtyard, Lower Main Street, Letterkenny,
Co. Donegal, Ireland.
Tel: +353 (0)749128222. Fax: +353 (0)749129903.
Email: info@alarchitects.com

Project: Refurbishment of Science Rooms
of Scoil Mhuire, Buncrana, Co. Donegal.

Drawing title: Pedestal Details

Purpose of Issue: Tender Issue

Date: 10-06-2026

Drawn: DK

Scale: 1:20

Print as: A1

Project No.: S074-01

Rev.: -

Drawing No.: S07401-ALA-XX-ZZ-DR-AR-50001