



Space for Fridge
BOSCH Serie 2
KTR15NW3AG Under counter Fridge - White Provided by Contractor


Space for Dishwasher
BOSCH Serie 4 SMS46IW10G Full-size Dishwasher -White Provided by Contractor

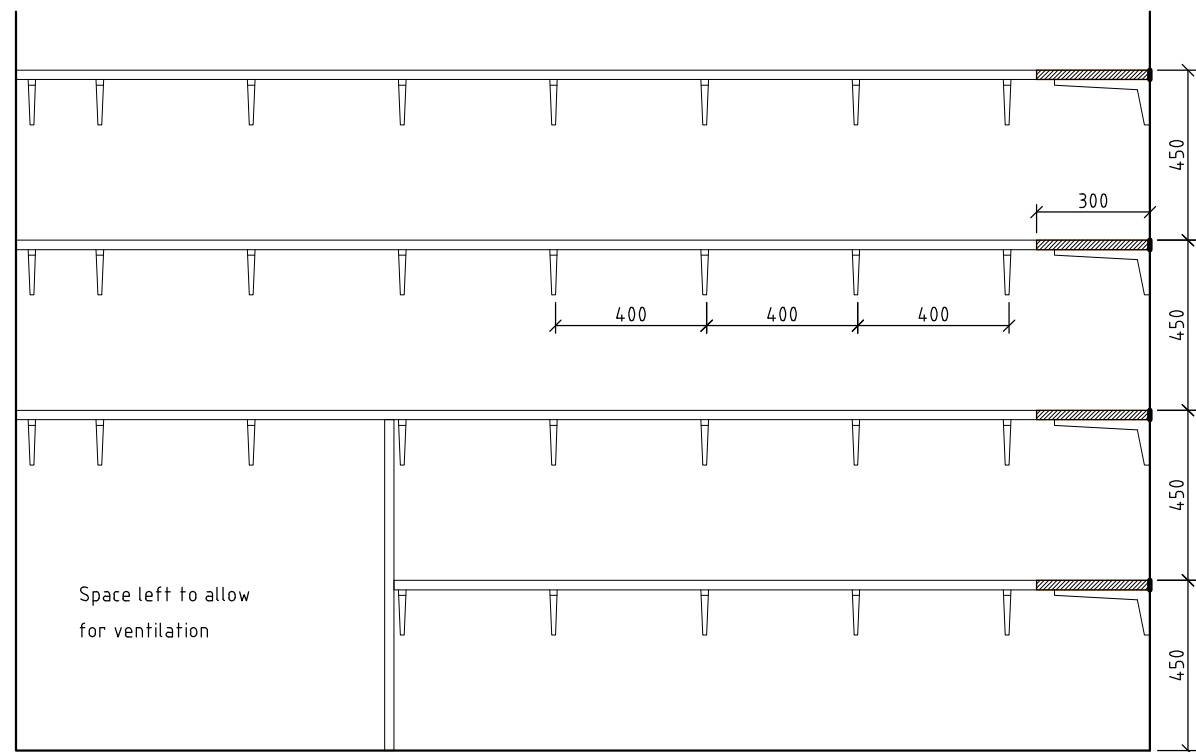


Elevation A

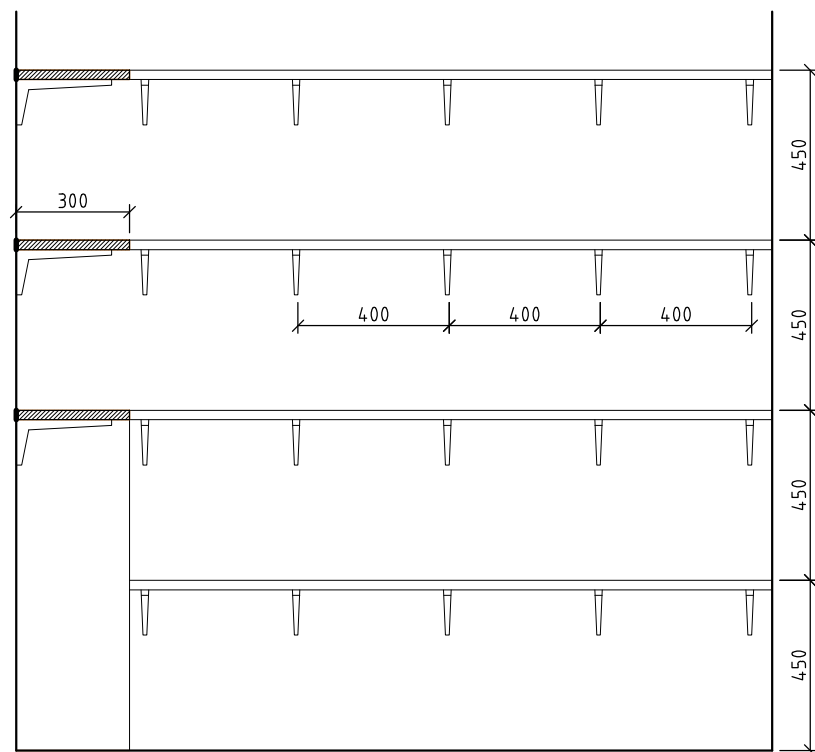

Elevation B

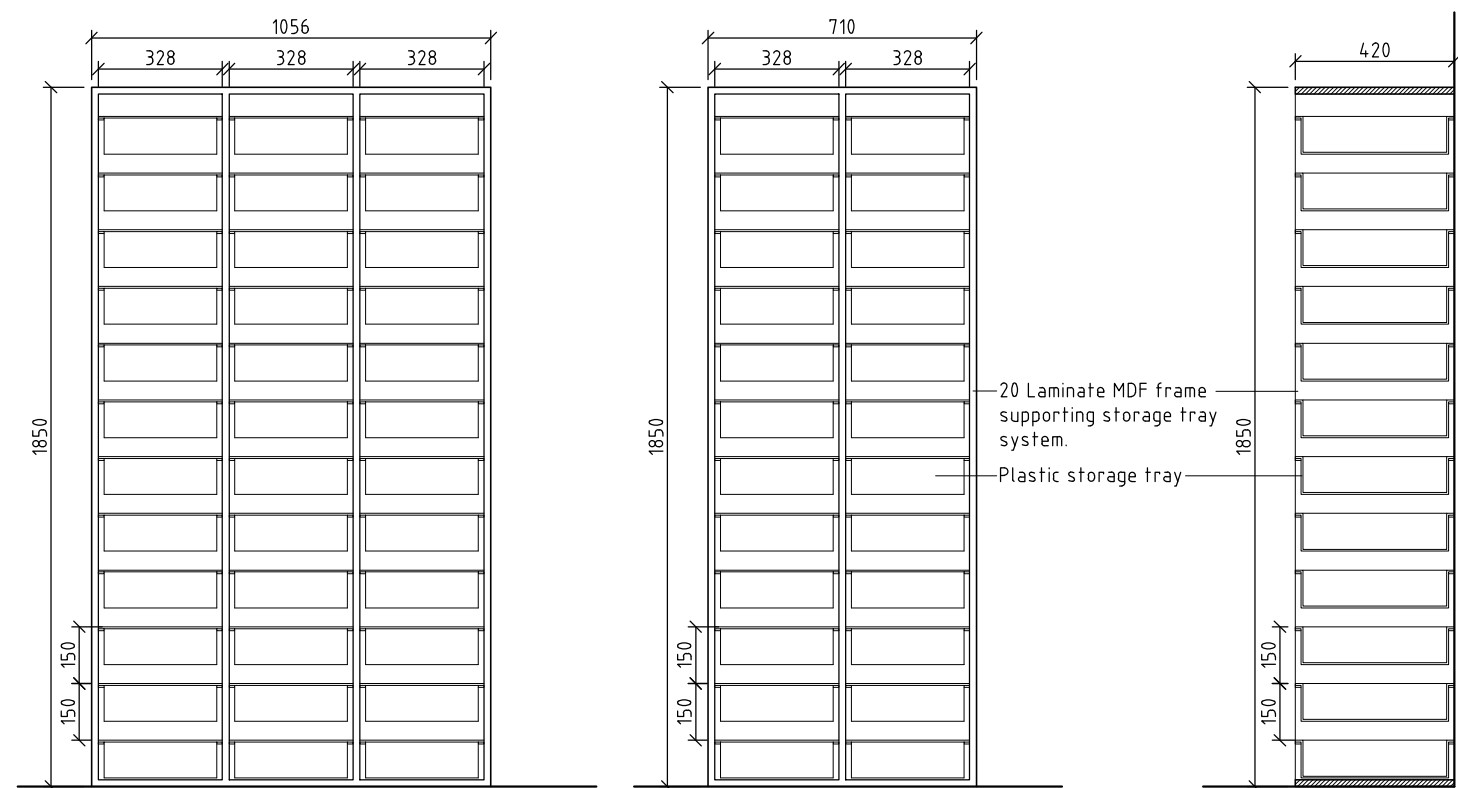


3 Bay Wide Tray Storage
2 Bay Wide Tray Storage
Section

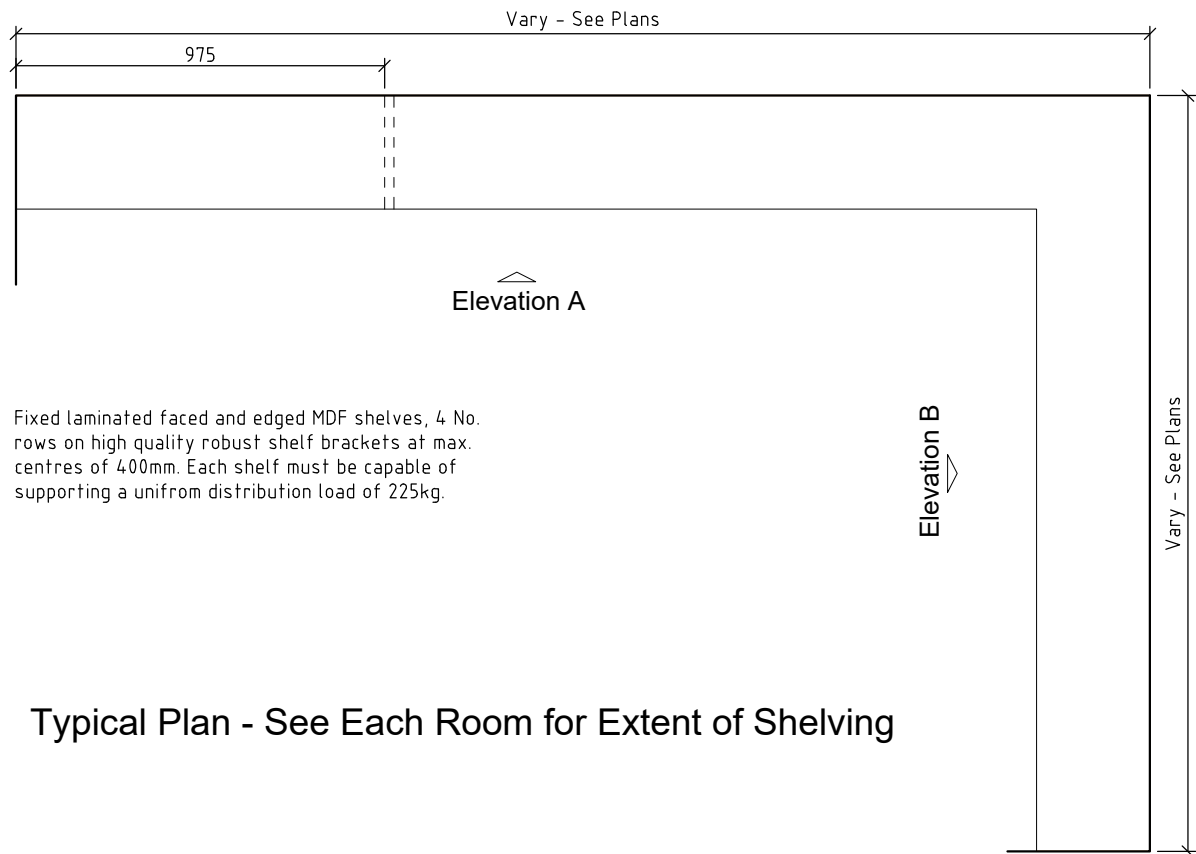


Typical Plan - See Each Room for Extent of Shelving

Typical Prep Room & Chemical Store Shelving

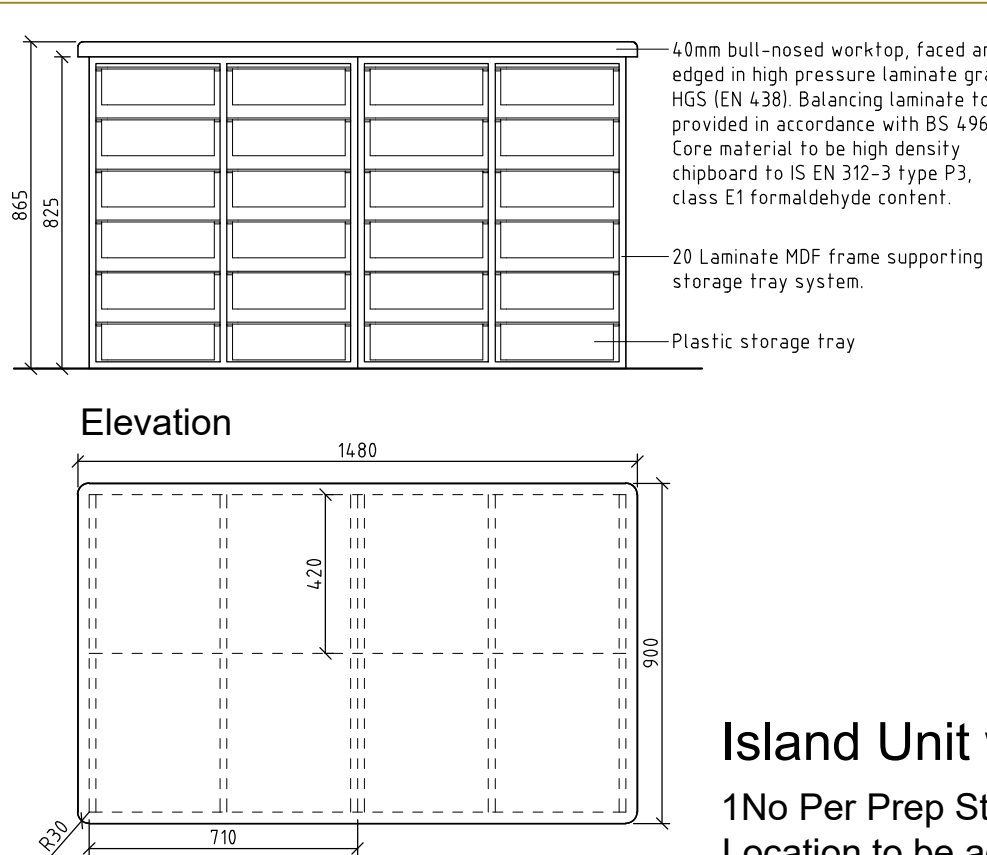

Island Unit with Tray Storage
1No Per Prep Store
Location to be agreed.

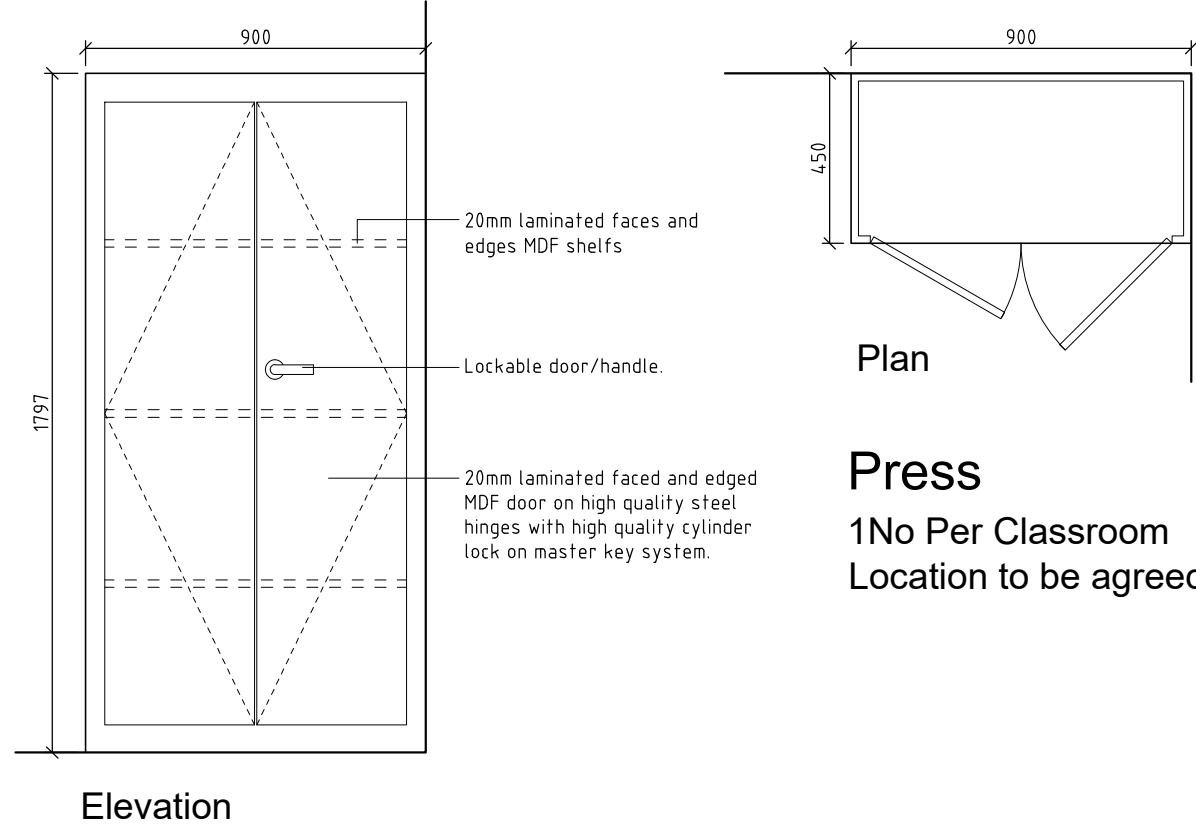

Press
1No Per Classroom
Location to be agreed.

NOTES.

1. Copyright reserved to AL Architects.
2. Work to figured dimensions only. Do not scale the drawing.
3. The contractor is responsible for checking all levels and dimensions on site, and shall refer all discrepancies to the architect.
4. Where appropriate, for details of structure, mechanical or electrical details, see consultant engineers drawings.
5. Proprietary items shall be fixed in strict accordance with manufacturer's instructions, unless otherwise instructed.
6. Sizes of proprietary items shall be checked with manufacturer.
7. The contractor shall be responsible for the co-ordination of structure, finishes and services.

Rev.	Date	Comments
-	-	-

Tender Issue



Chartered Architects | Surveyors | Project Managers.

Office 88, The Courtyard, Lower Main Street, Letterkenny, Co. Donegal, Ireland.
Tel: +353 (0)749128222. Fax: +353 (0)749129903.
Email: info@alarchitects.com

Project Refurbishment of Science Rooms at Scoil Mhuire, Buncrana, Co. Donegal.

Drawing Title Fixtures & Fittings 2

Purpose of Issue Tender Issue

Date 08-05-2026	Drawn DK
Scale 1:20	Print as A1
Project No. S074-01	Rev. -
Drawing No. S07401-ALA-XX-ZZ-DR-AR-50003	