



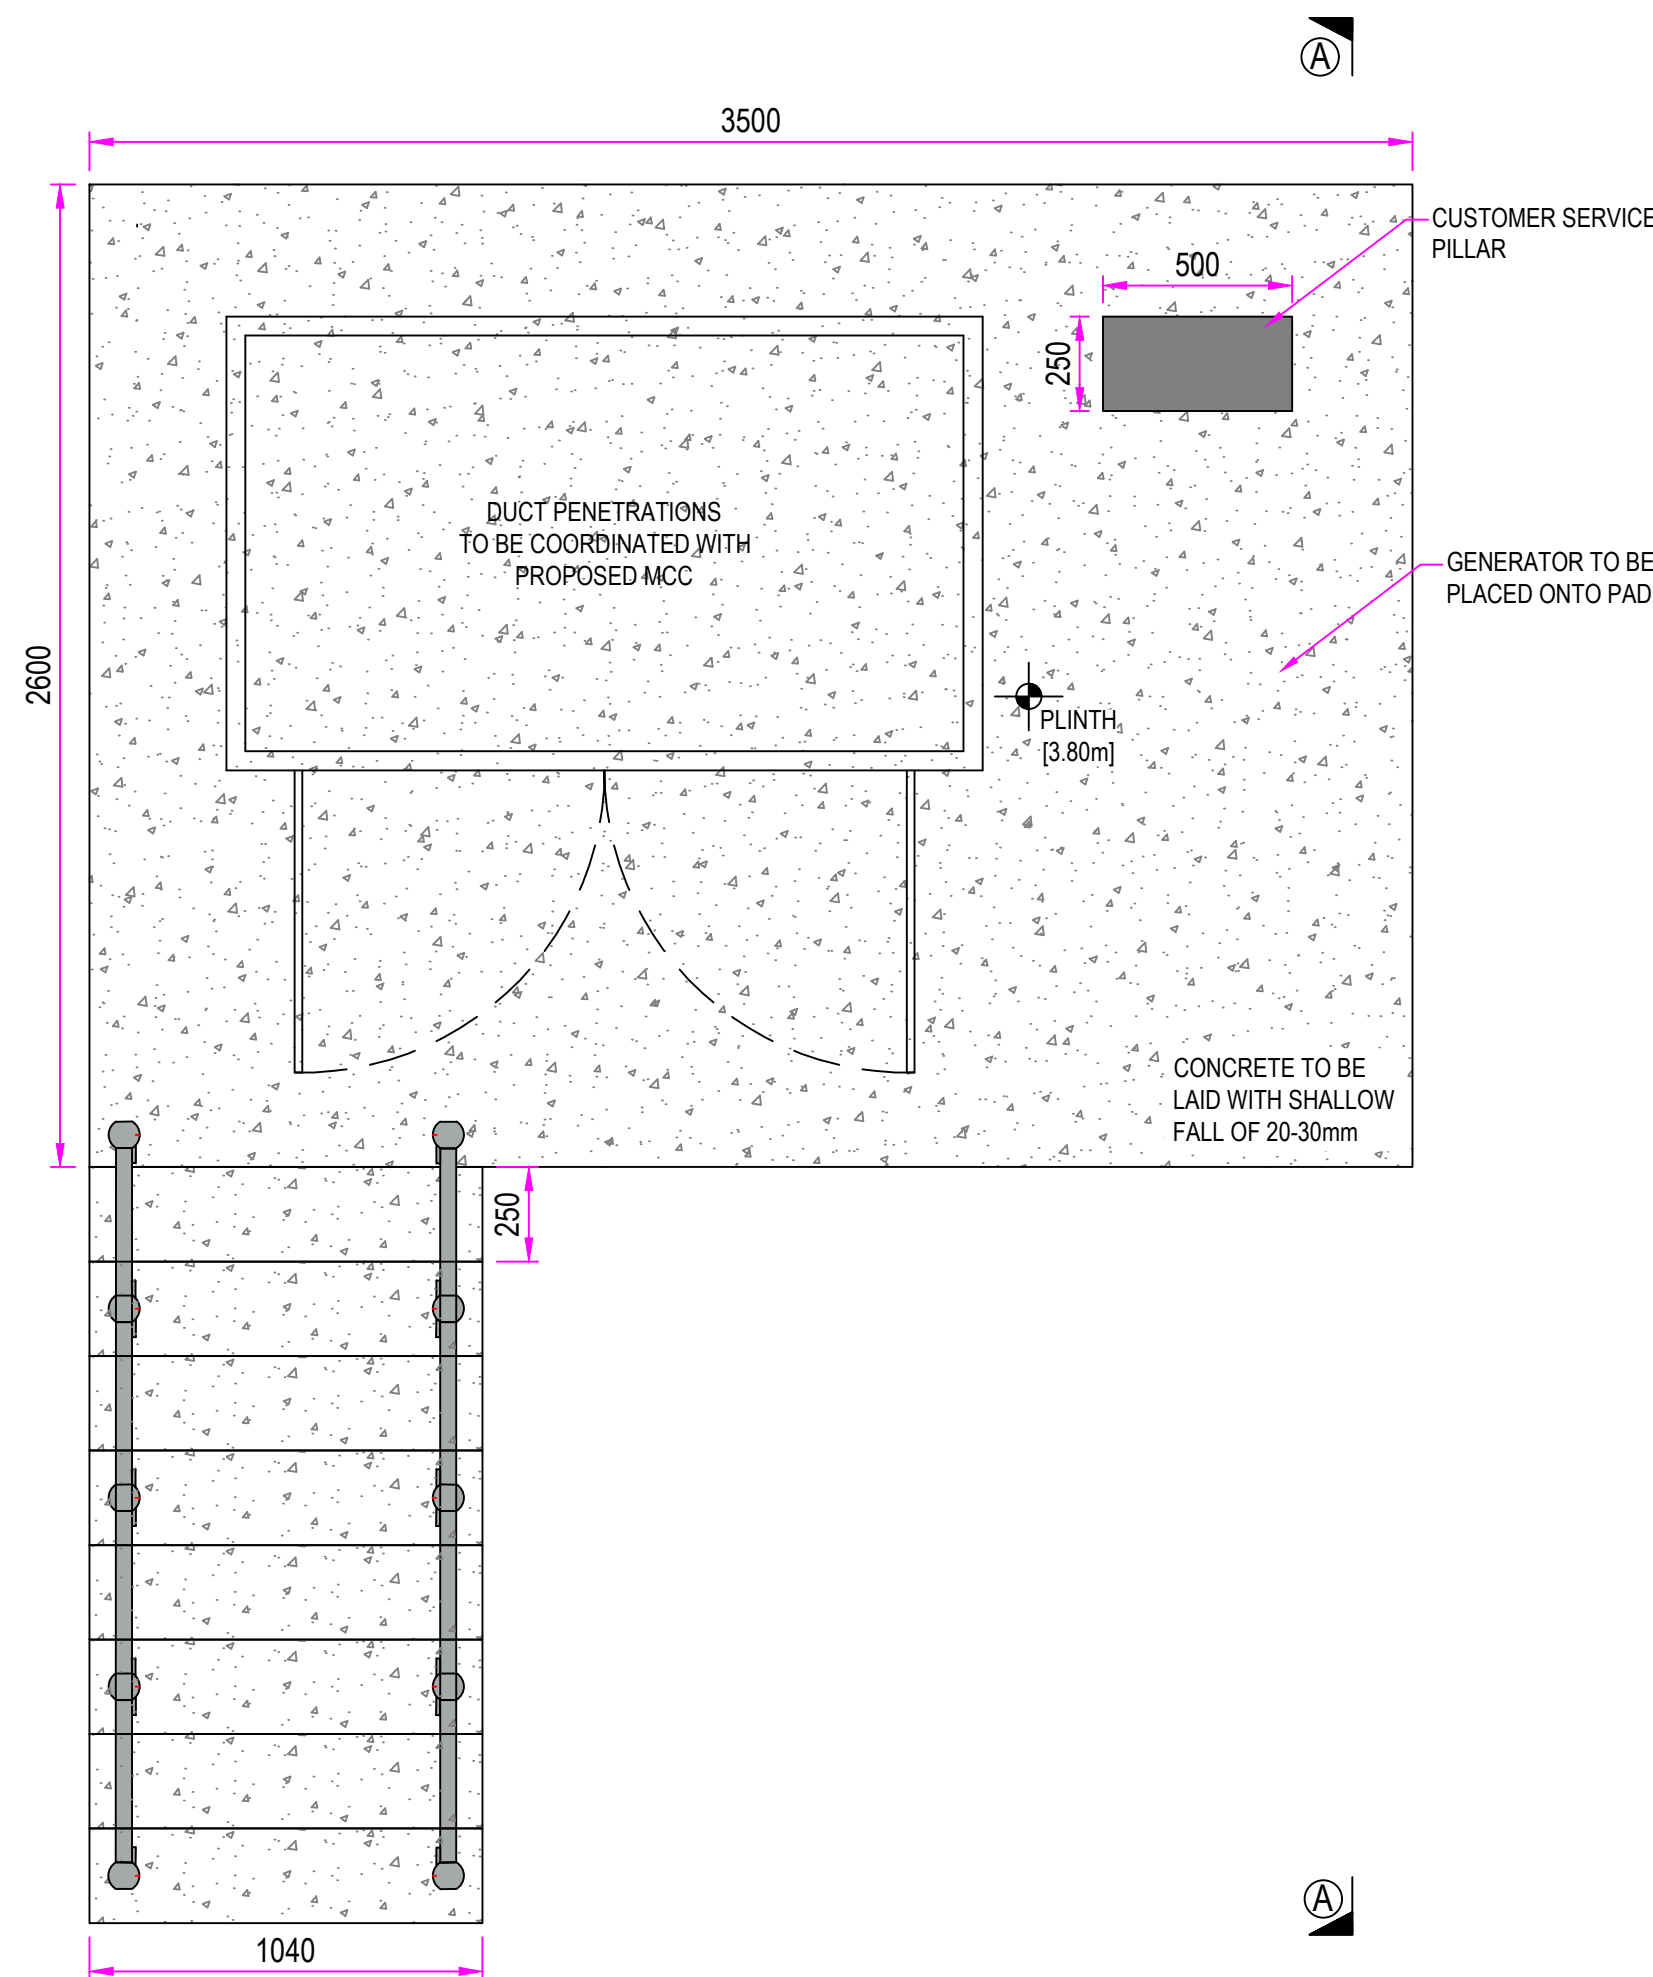


KIOSK BASE
PLAN VIEW
SCALE 1:20

PLINTH DIMENSIONS INDICATIVE
BASED ON KIOSK AND GENERATOR
AQUIRED

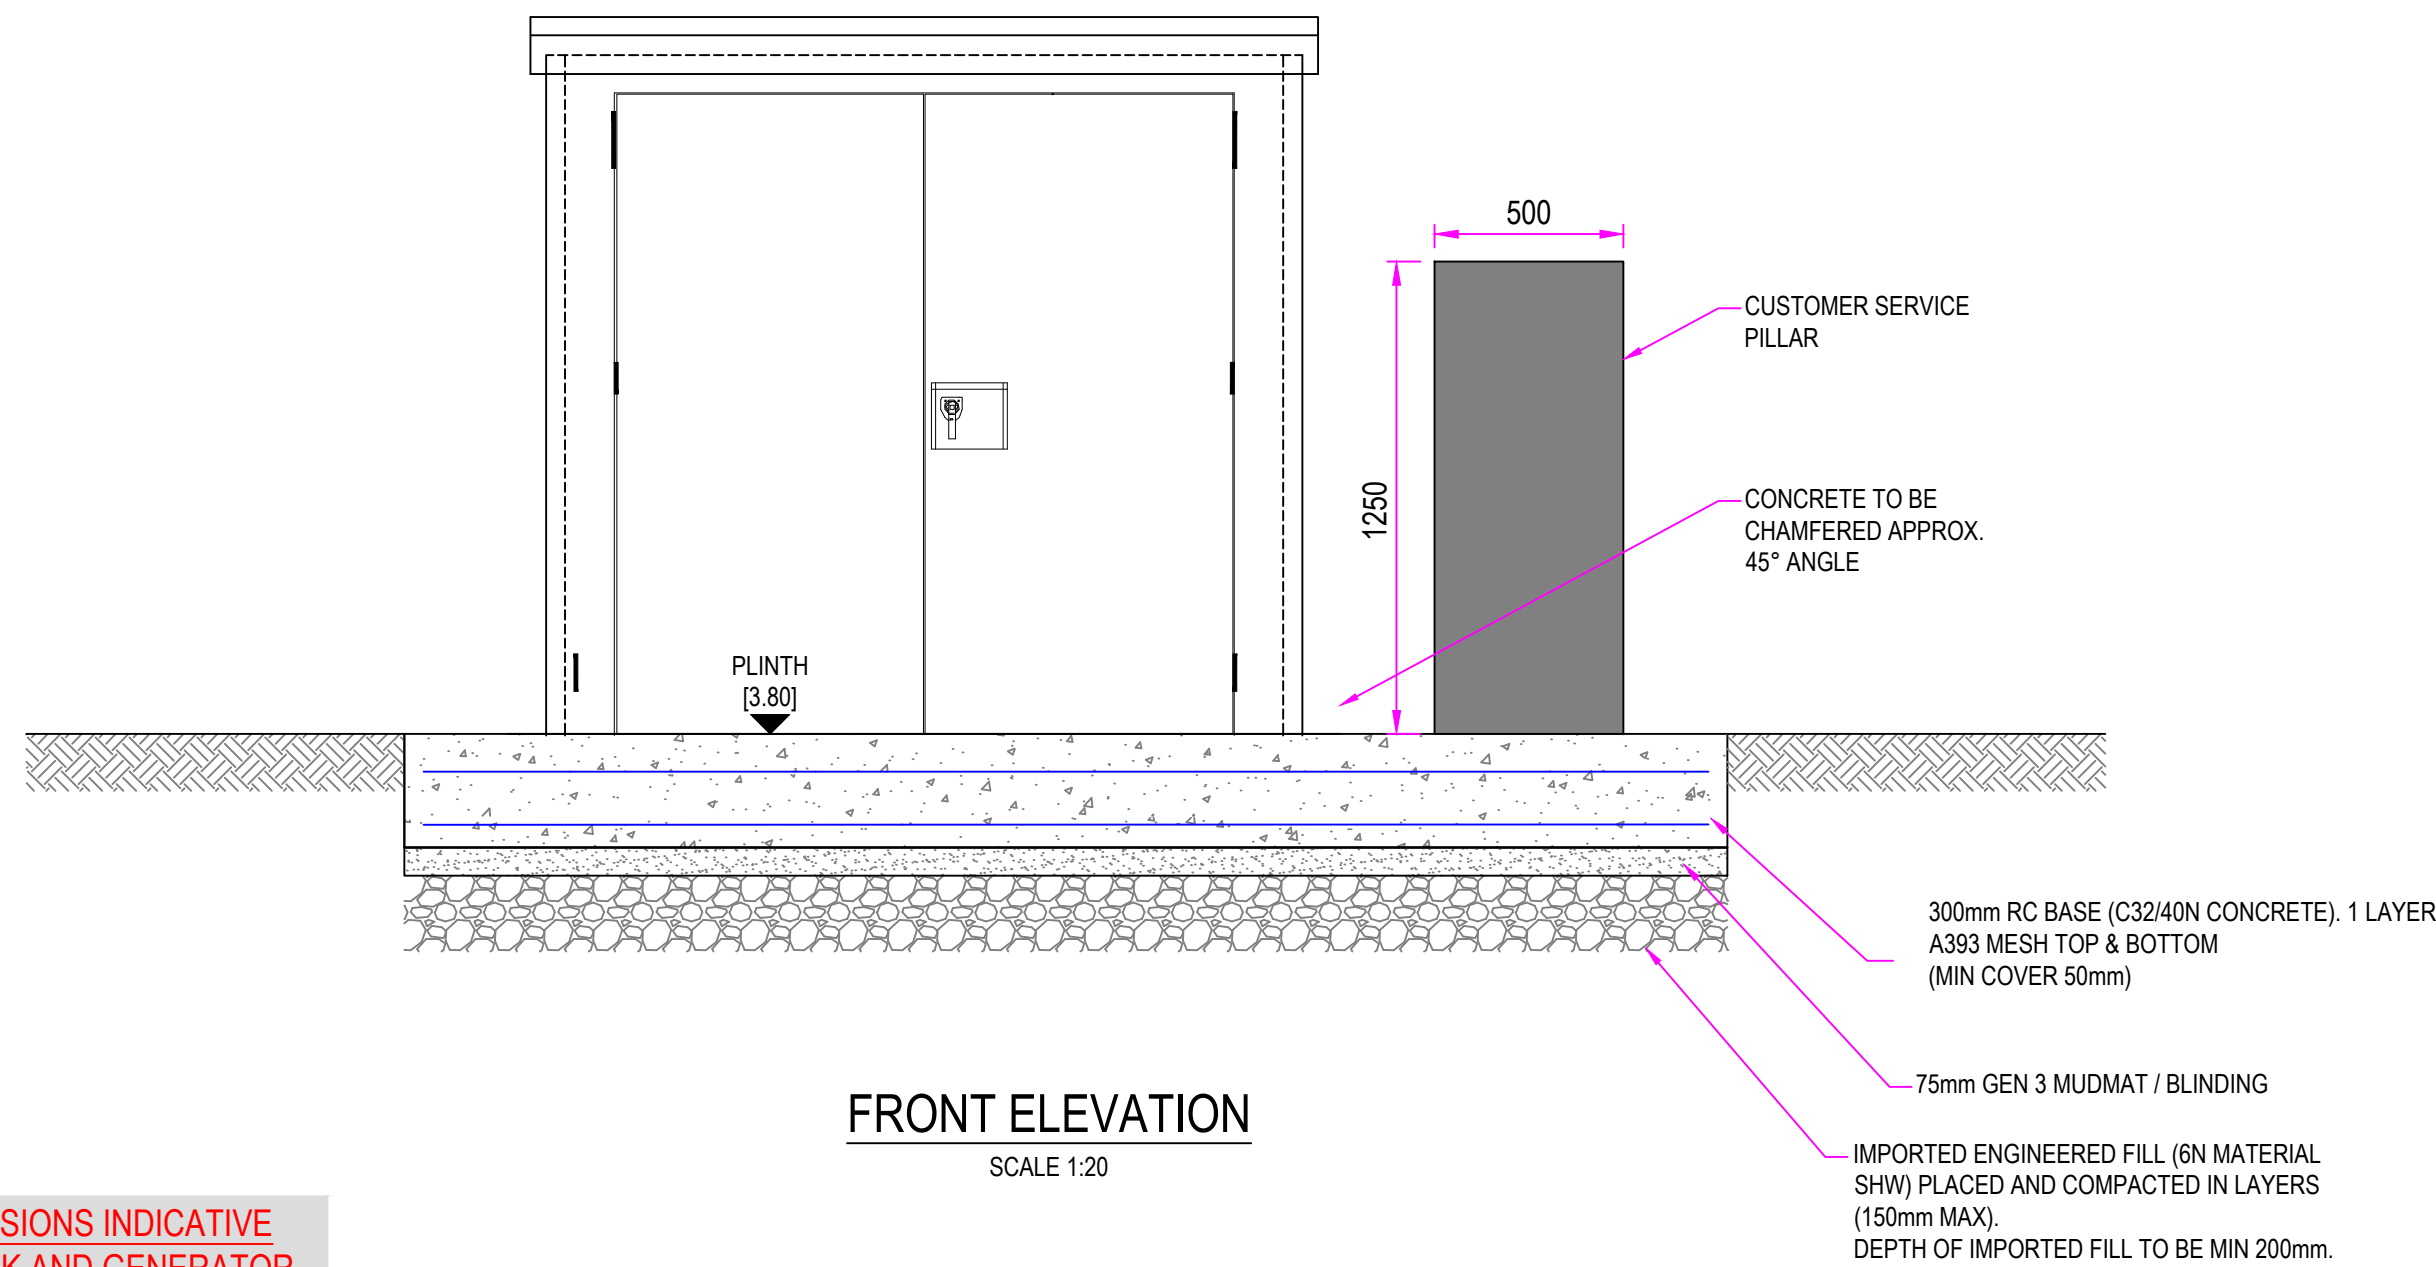

FRONT ELEVATION
SCALE 1:20

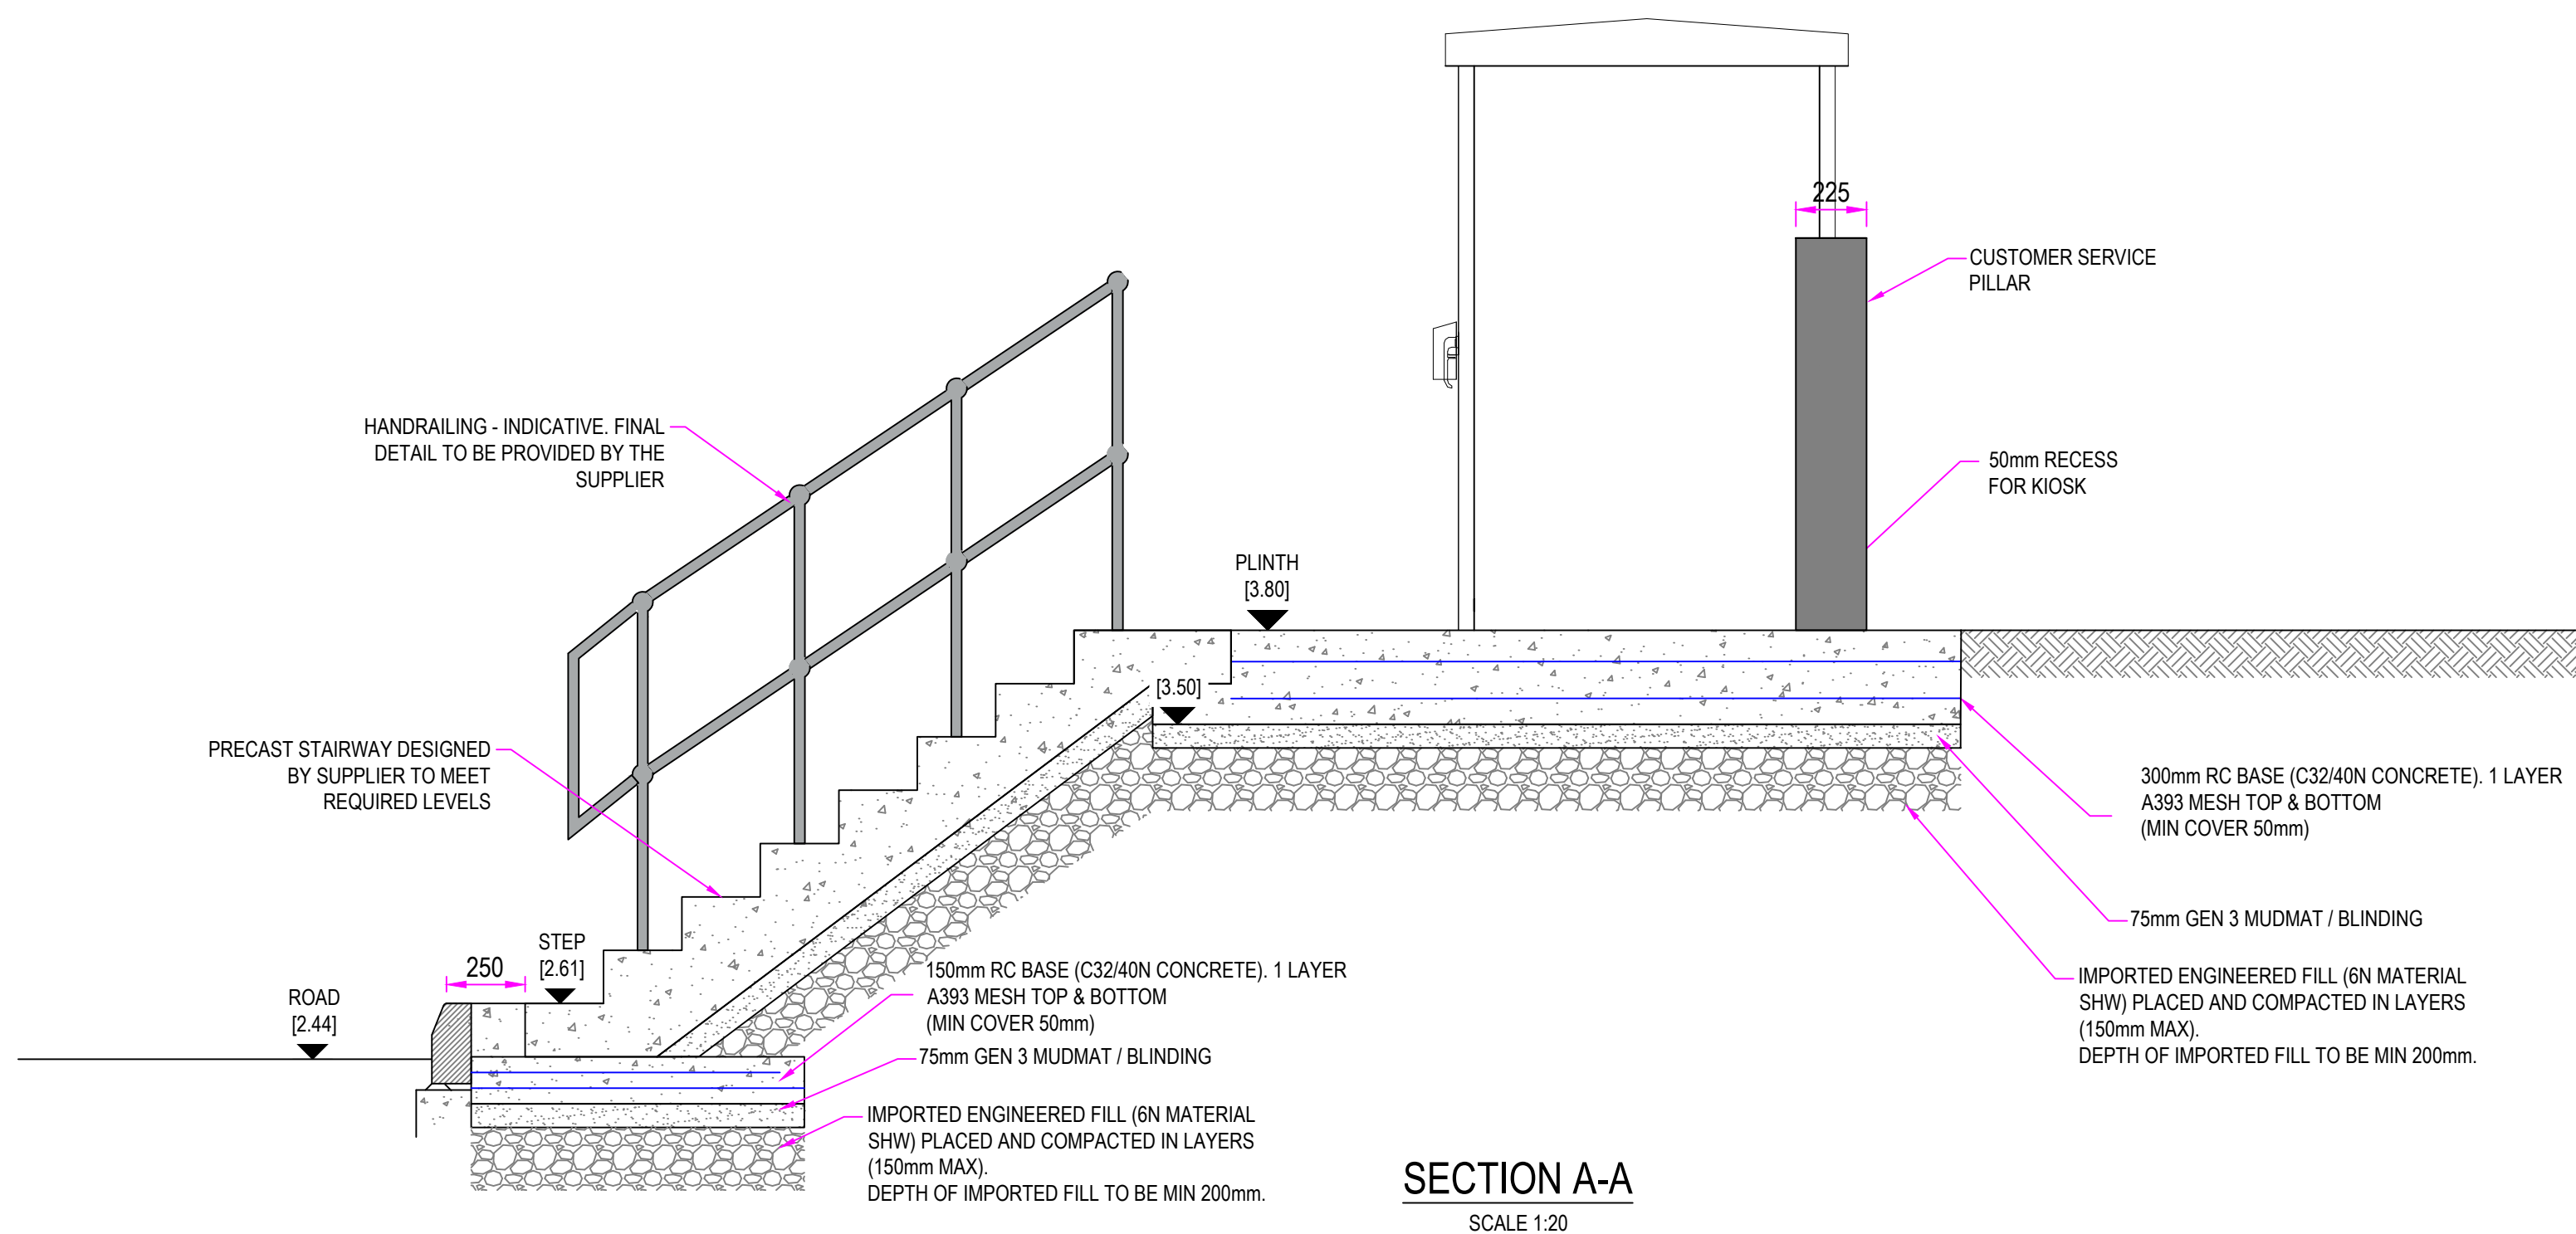

SECTION A-A
SCALE 1:20

NOTES

- Verifying Dimensions.
The contractor shall verify dimensions against such other drawings or site conditions as pertain to this part of the work.
- Existing Services.
Any information concerning the location of existing services indicated on this drawing is intended for general guidance only. It shall be the responsibility of the contractor to determine and verify the exact horizontal and vertical alignment of all cables, pipes, etc. (both underground and overhead) before work commences.
- Issue of Drawings.
Hard copies, dwf and pdf will form a controlled issue of the drawing. All other formats (dwg, dxf etc.) are deemed to be an uncontrolled issue and any work carried out based on these files is at the recipients own risk. RPS will not accept any responsibility for any errors arising from the use of these files, either by human error by the recipient, listing of un-dimensioned measurements, compatibility issues with the recipient's software, and any errors arising when these files are used to aid the recipients drawing production, or setting out on site.
- Datum.
All Levels to Ordnance Survey Datum, Belfast.
- Legend.

P04	Kiosk Plinth Resized	RM	01/06/2026
P03	Relocation of Kiosk	RM	10/03/2026
P03	Relocation of Kiosk	RM	10/03/2026
P02	Relocation of the Kiosk	RM	18/12/2025
rev	amendments	check	date

TETRA TECH

Elmwood House
74 Boucher Road
Belfast
BT12 6RZ

RPS
A TETRA TECH COMPANY

T +44 (0) 28 90 667914
F +44 (0) 28 90 668286
W www.rpsgroup.com/ireland
E ireland@rps-tetratech.com

Client

OPW
Oifig na
nOibrescha Publaí
Office of Public Works

Project
Morrington Storm Pumping Station

Title
The Dunes Storm Pumping Station GA
Kiosk and Generator Plan View
and General Arrangements

Project Number IBI0050	Sheet Size A1	Drawing Scale As Shown
---------------------------	------------------	---------------------------

Drawing Number
IBI0050-RPS-ZZ-XX-DR-C-1201

Drawn By CB	Status S3	Revision P04
----------------	--------------	-----------------

Checked By RM	Approved By RM	Date 05/11/2025
------------------	-------------------	--------------------