


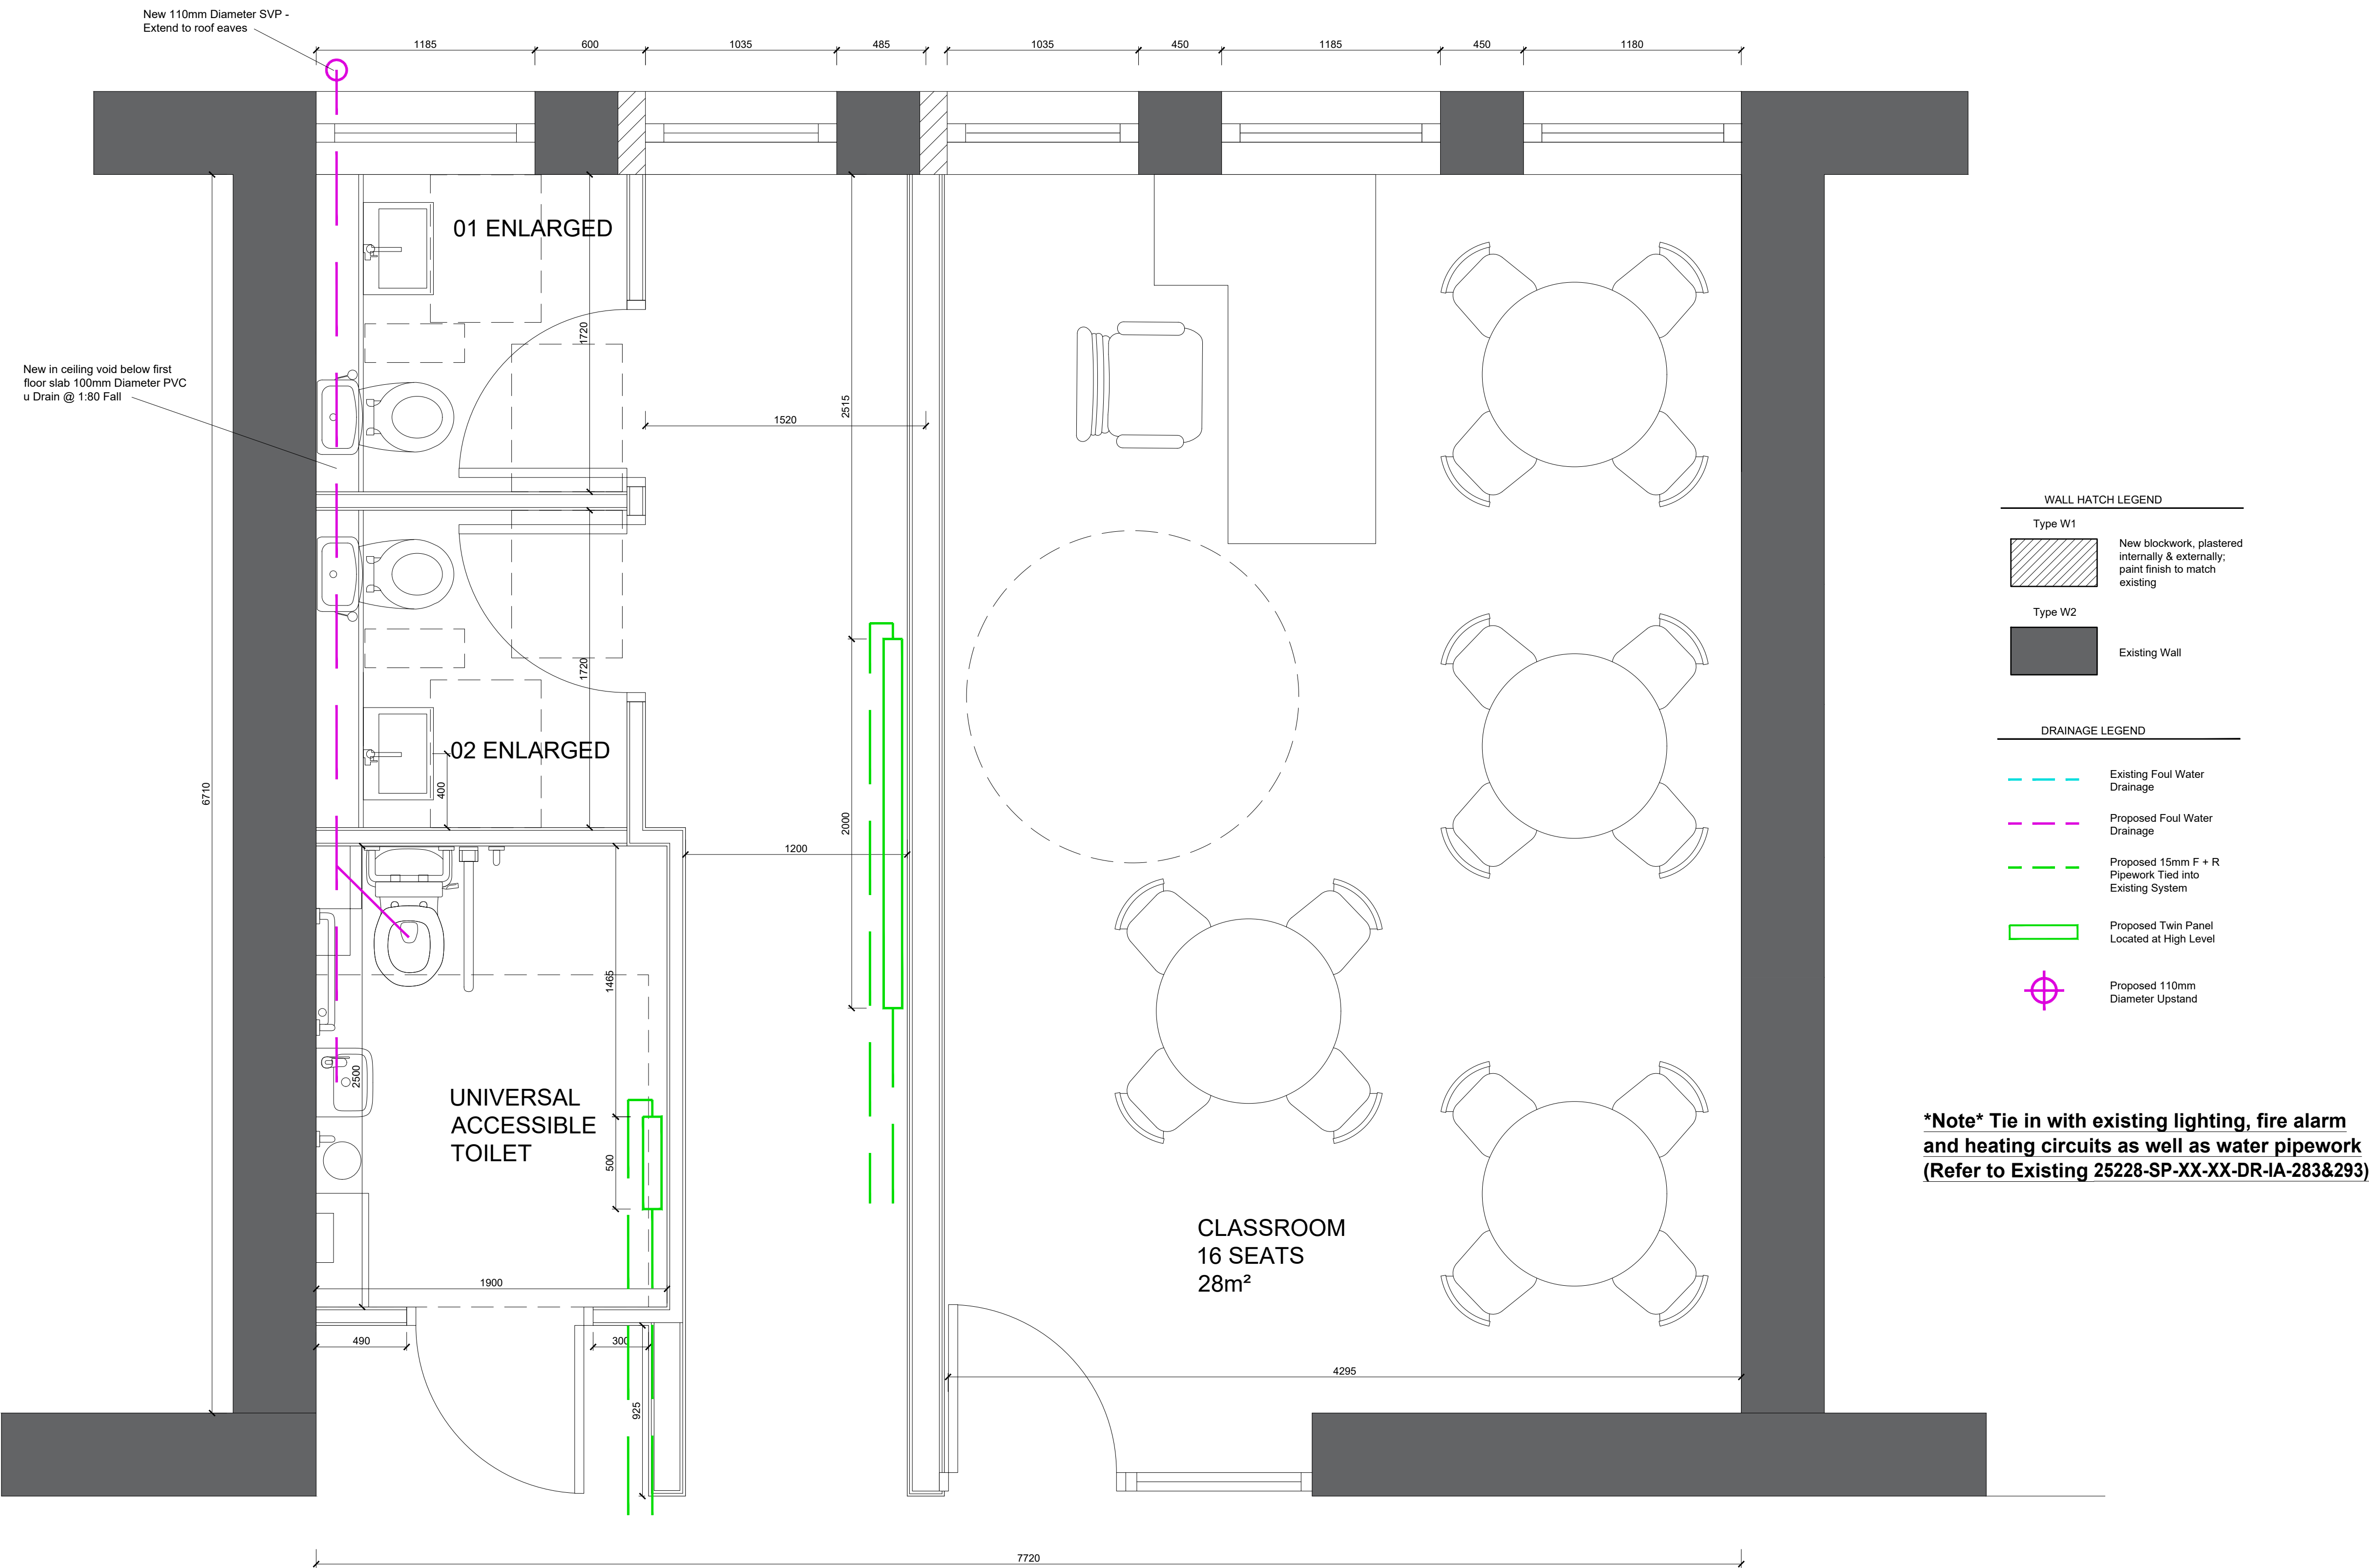

Proposed Clonmel Toilet First Floor Mechanical Plan
Scale at 1:20

Drawing Details

Drawing Title:
PROPOSED CLONMEL TOILET
FIRST FLOOR MECHANICAL PLAN

Ref: 25228-SP-XX-XX-DR-IA-253

Scale:
1:20@ A1

TIPPERARY FET COLLEGE CLONMEL,
THE MALL,
CLONMEL,
CO.TIPPERARY
E91 K2E2

Project Stage:
Stage 1

Client Details:
TIPPERARY ETB

All dimensions to be checked on site.

Do not scale dimensions from this drawing,
use figured dimensions only.

Refer to Engineer's drawings and specification
for all structural and services information.

Any discrepancies between the Architect's and
Engineer's drawings to be reported to the
Architect immediately.

The survey information shown on this drawing
is based on a survey prepared by a third party
and Spentide Ltd accept no responsibility for
the accuracy or completeness of the survey

Document Record			
P/S	Purpose / Description/	Date	Rev
1	Issued for Review	09.03.26	00
3	Issued for Tender	26.06.26	01