


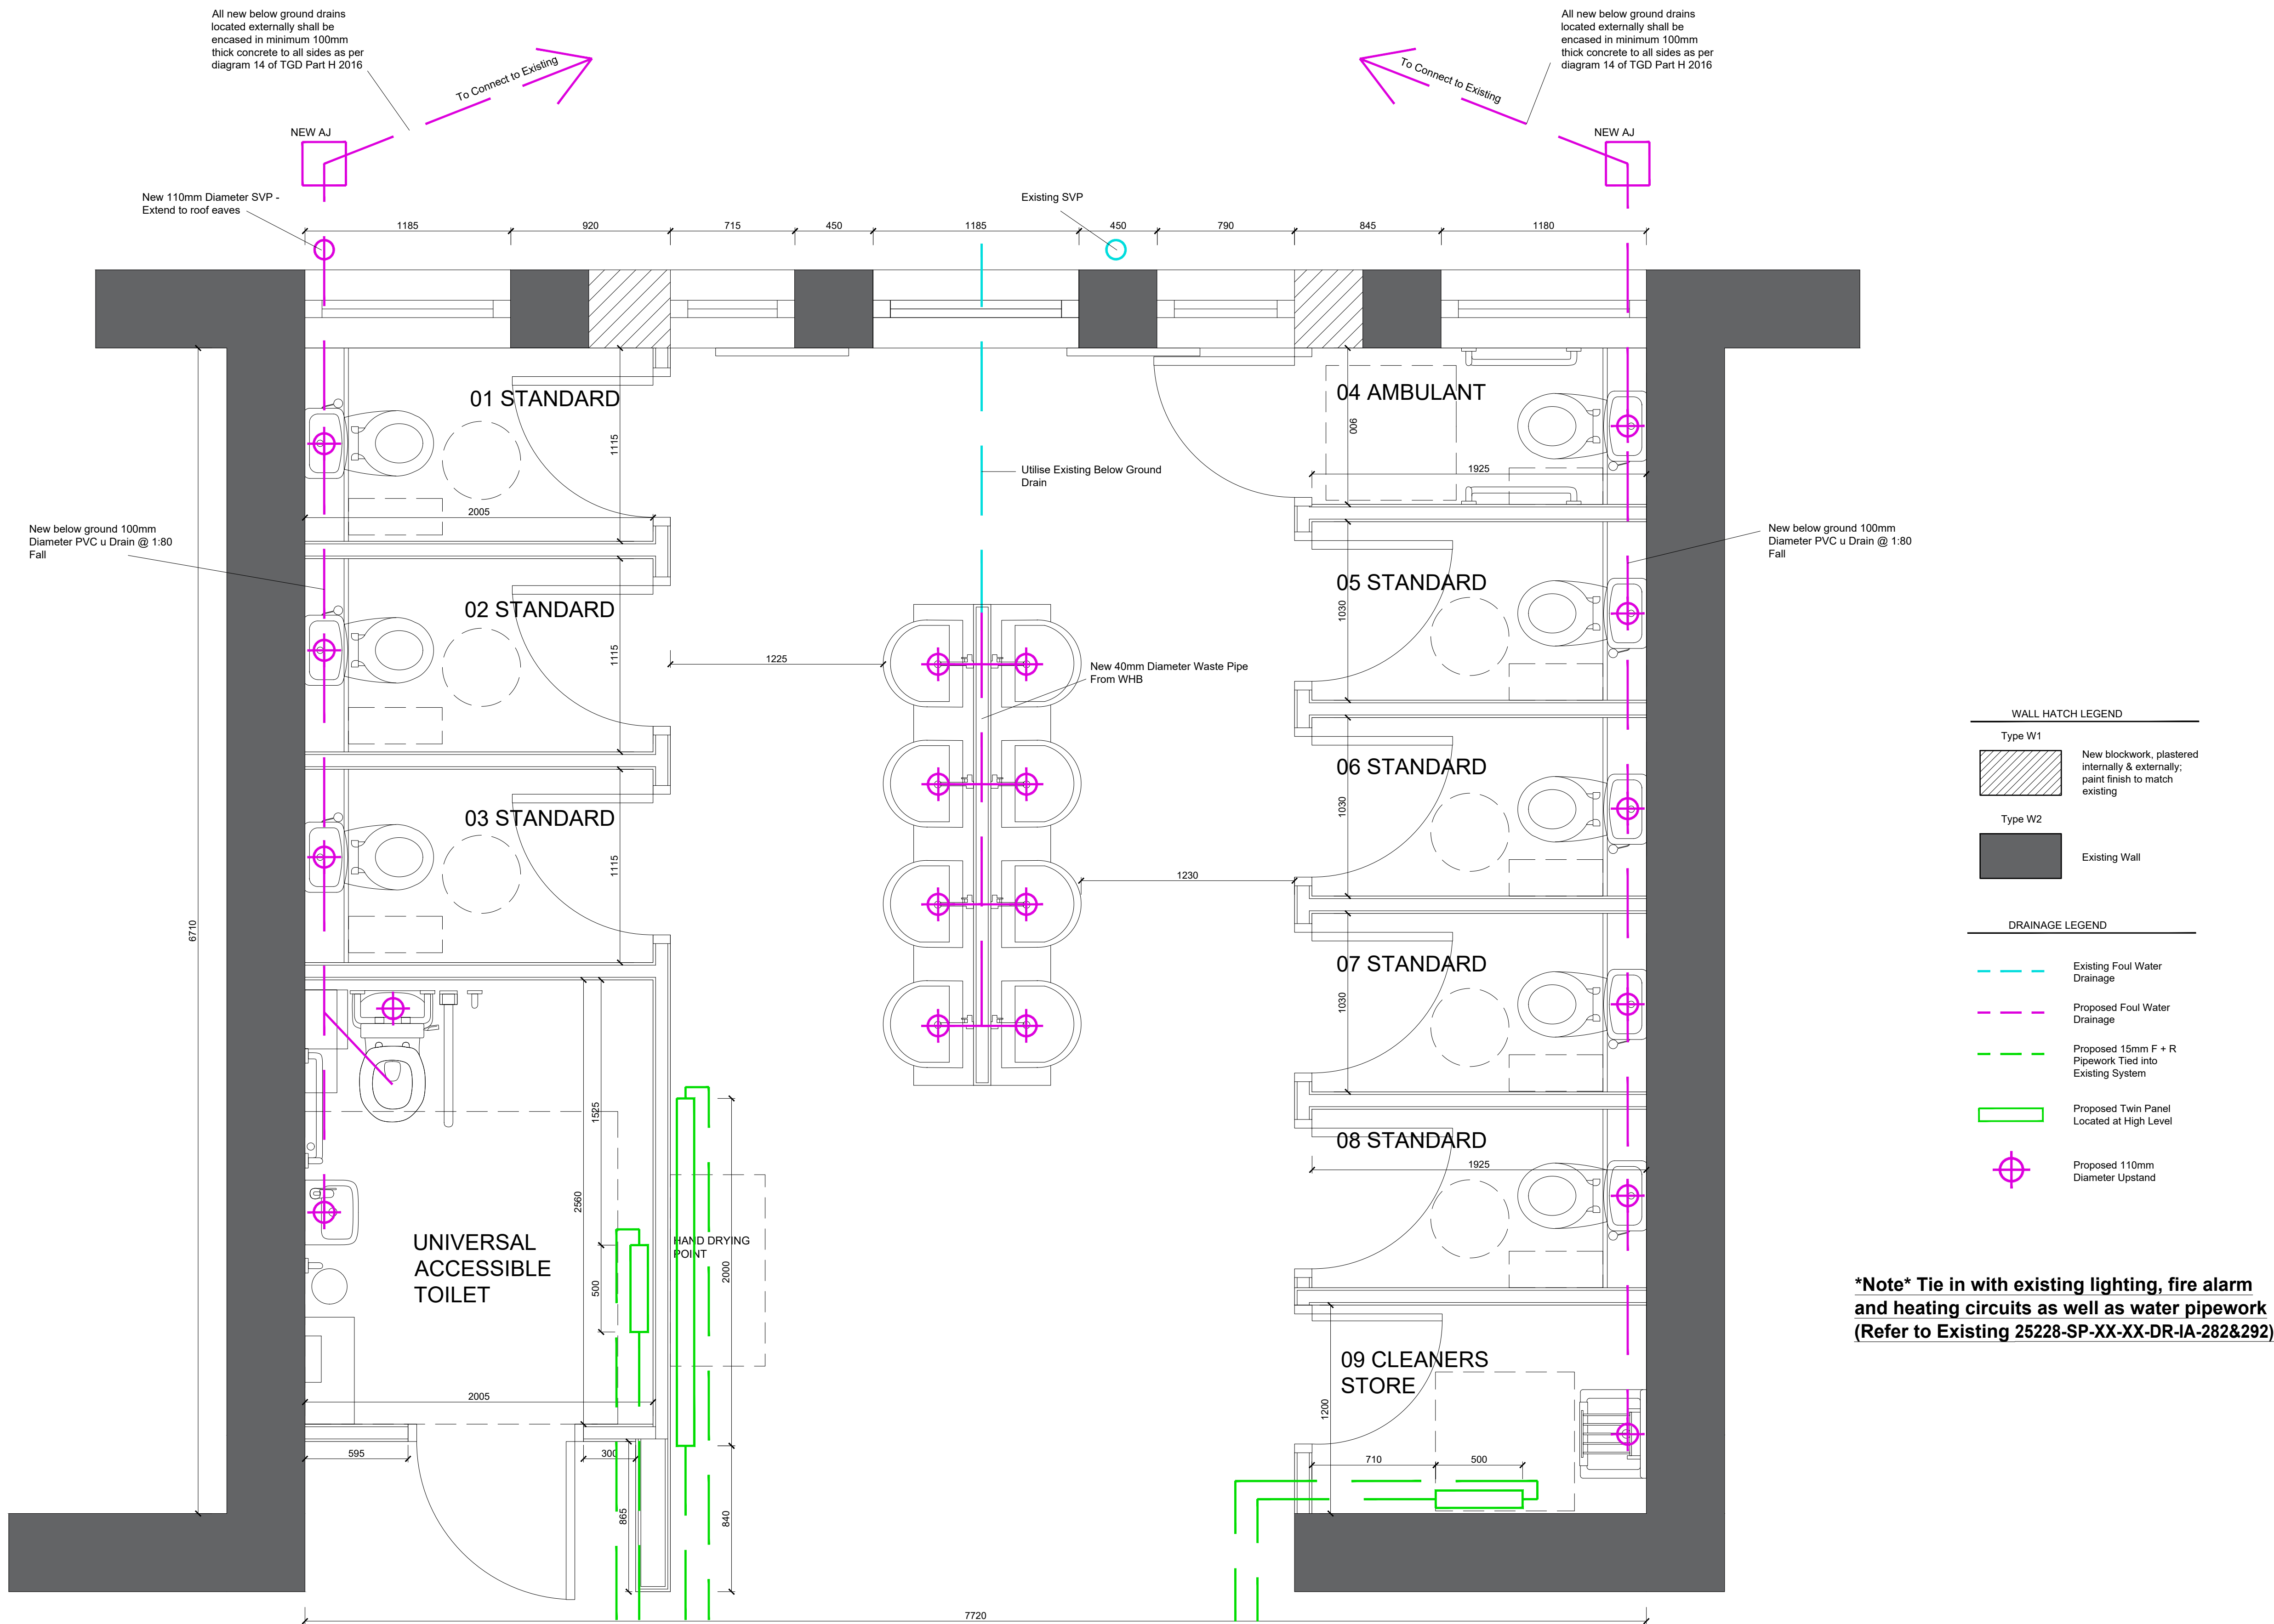

Proposed Clonmel Toilet Ground Floor Mechanical Plan
Scale at 1:20

Drawing Details

Drawing Title:

PROPOSED CLONMEL TOILET
GROUND FLOOR MECHANICAL PLAN

Ref: 25228-SP-XX-XX-DR-IA-252

Scale:

1:20@ A1

TIPPERARY FET COLLEGE CLONMEL,
THE MALL,
CLONMEL,
CO.TIPPERARY
E91 K2E2

Project Stage:
Stage 1

Client Details:
TIPPERARY ETB

All dimensions to be checked on site.

Do not scale dimensions from this drawing, use figured dimensions only.

Refer to Engineer's drawings and specification for all structural and services information.

Any discrepancies between the Architect's and Engineer's drawings to be reported to the Architect immediately.

The survey information shown on this drawing is based on a survey prepared by a third party and Spentide Ltd accept no responsibility for the accuracy or completeness of the survey

Document Record			
P/S	Purpose / Description/	Date	Rev
1	Issued for Review	09.03.26	00
3	Issued for Tender	26.06.26	01