


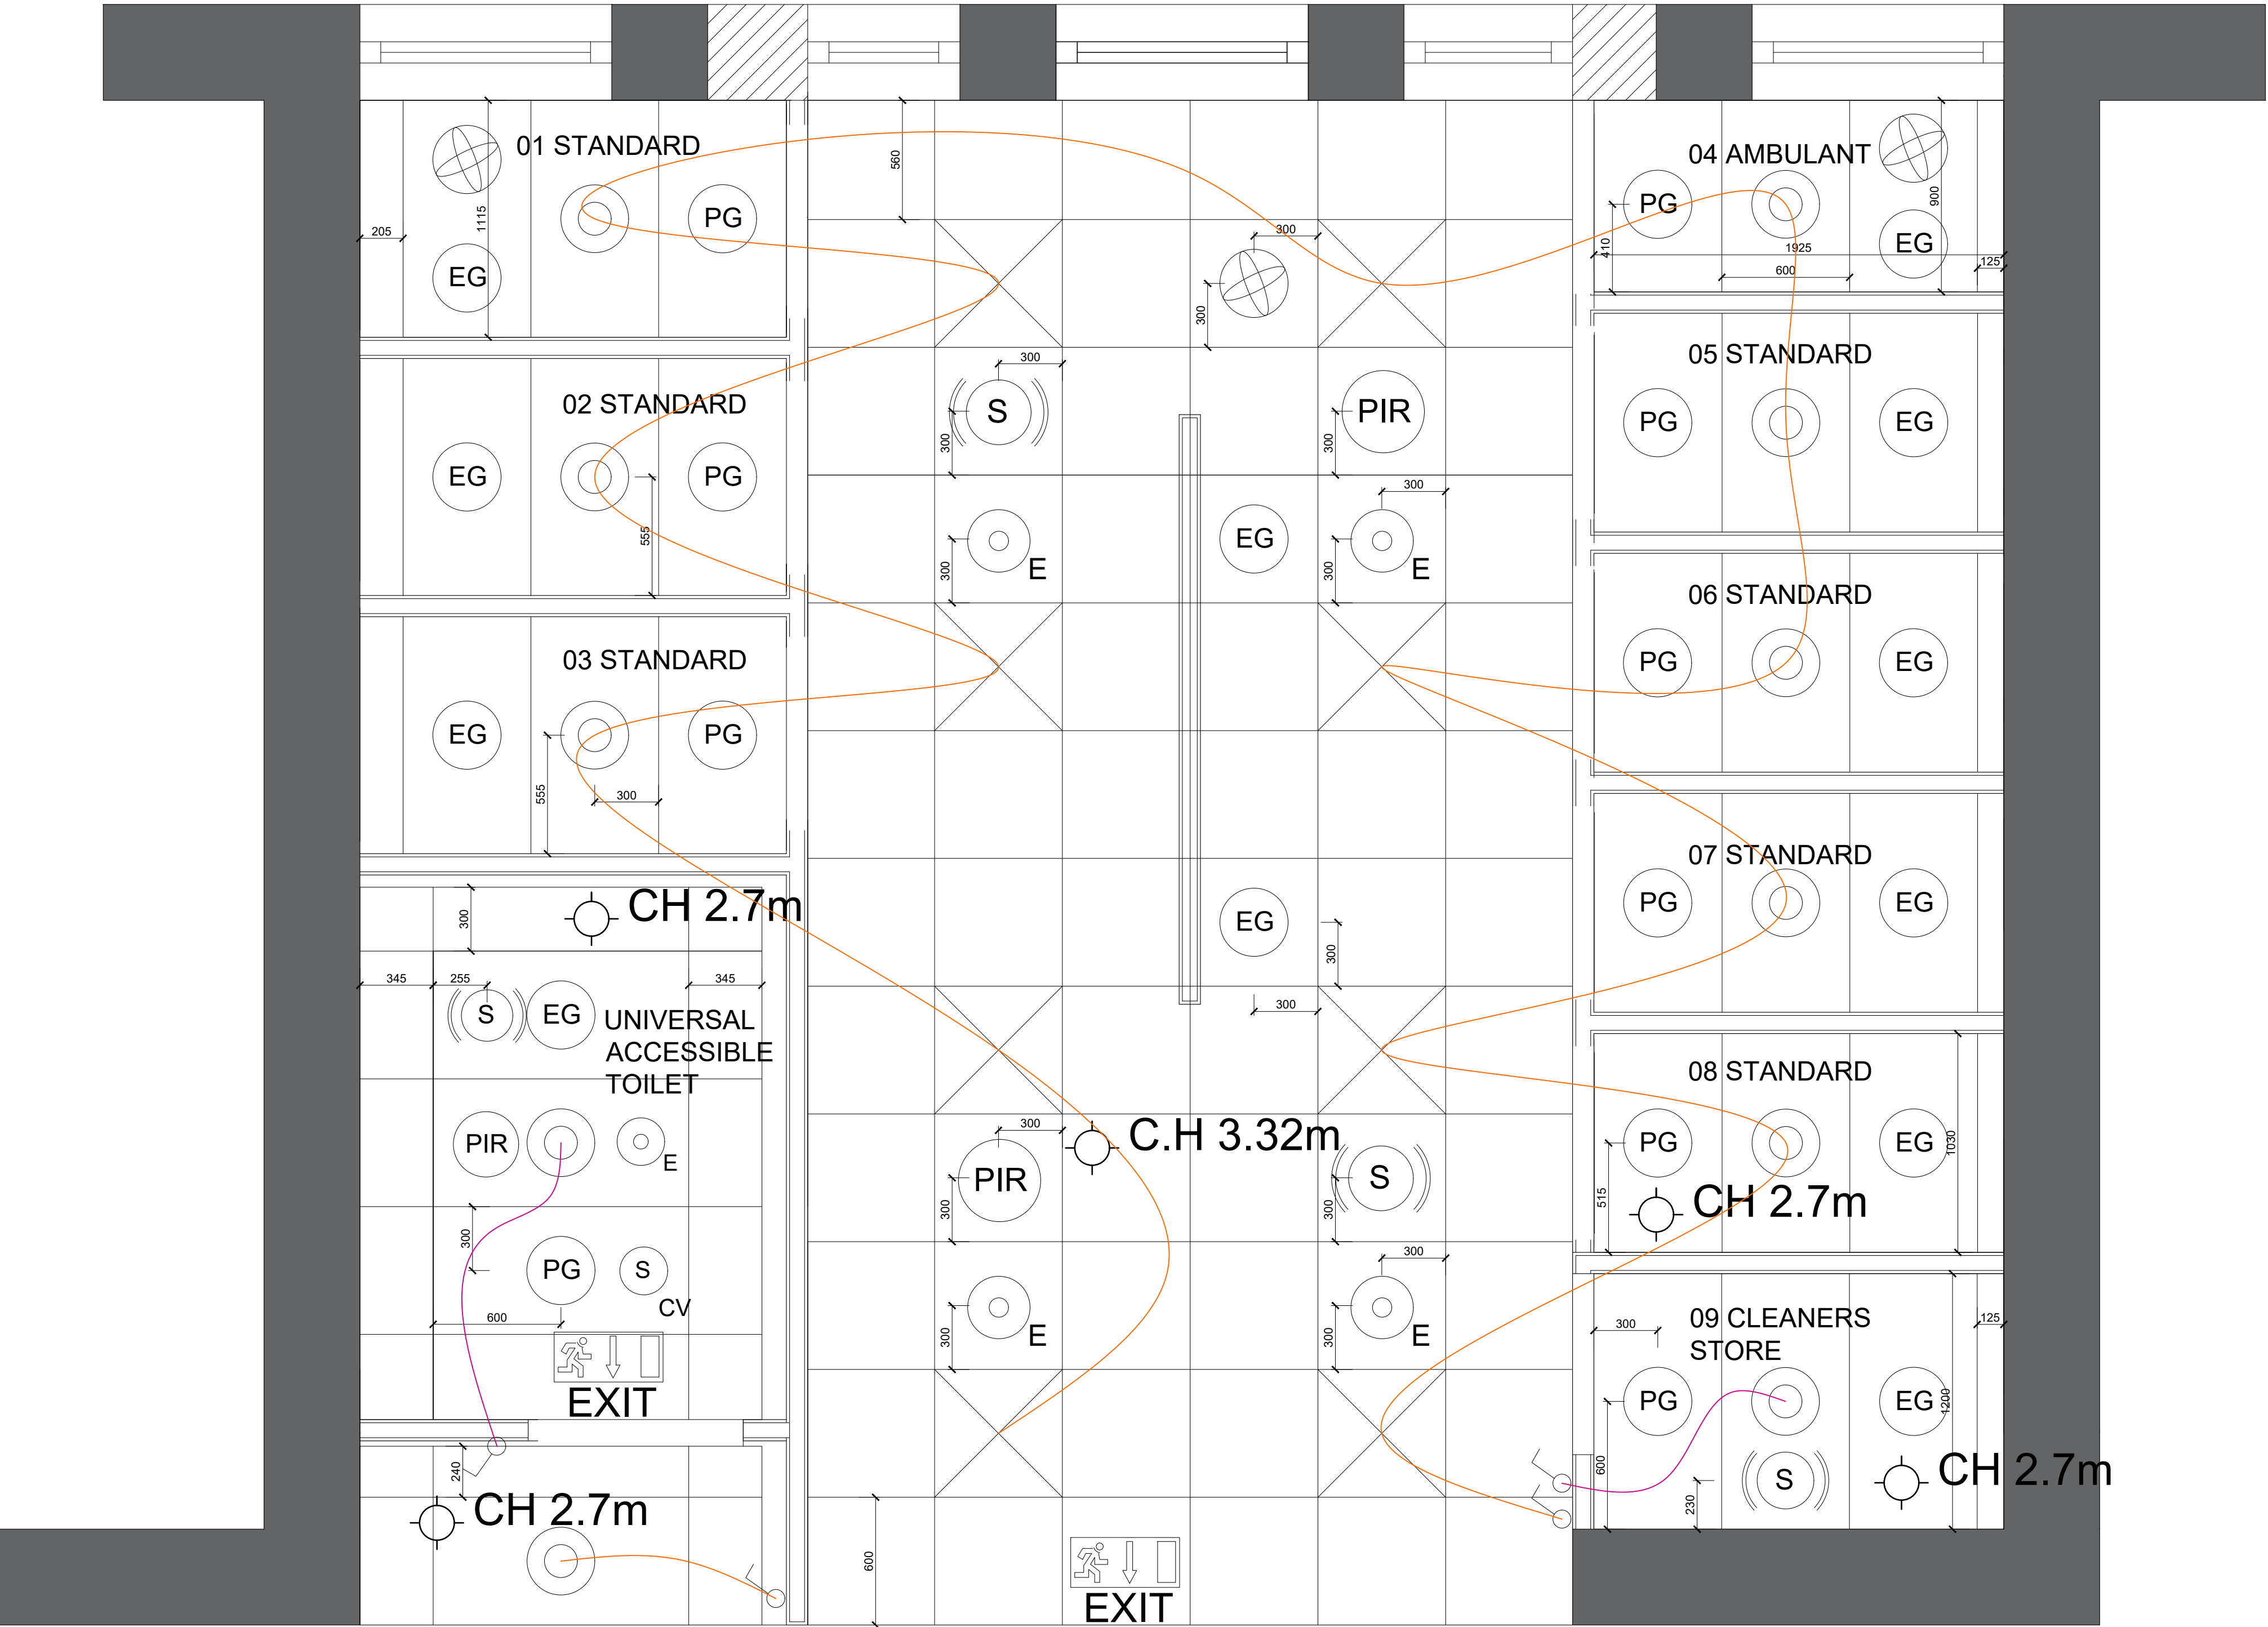

Proposed Clonmel Ground Floor Reflective Ceiling Plan
Scale at 1:20

CEILING FINISH LEGEND

Type C1

600 x 600mm Grid Ceiling Tiles

Type C2

600 x 1200mm Grid Ceiling Tiles

Type C3

Moisture Resistant Plasterboard

CEILING LIGHTING LEGEND

Type L1

LED LIGHT FITTING

Type L2

RECESSED LIGHT FITTING

*Note all STANDARD/AMBULANT/ENLARGED Rooms have the same C.H.2700mm

CEILING SERVICES LEGEND

Type CS1

FAN

Type CS2

EXTRACTOR GRILLE

Type CS3

PASSIVE GRILLE/SUPPLY

Type CS4

EMERGENCY LIGHTING (3HR DURATION NON-MAINTAINED)

Type CS5

PASSIVE INFRARED SENSOR

Type CS6

FIRE ALARM SMOKE DETECTOR W/ SOUNDER

Type CS7

FIRE ALARM SMOKE DETECTOR LOCATED IN CEILING VOID

Type CS8

EMERGENCY FIRE EXIT SIGN

Type CS9

GRILLE, 200X200

Type CS10

AIR DUCT FOR SUPPLY AIR

Type CS11

AIR DUCT FOR EXTRACT AIR

*Note indicative air ducting routes, subject to contractor design

ELECTRICAL LEGEND

Type E1

13AMP SPW OUTLET WALL MOUNTED

Type E2

CALL- RESET RUSH BUTTON WALL MOUNTED

Type E3

ALARM PULL CORD

Type E4

LIGHT SWITCH WALL MOUNTED

Type E5

13AMP, TWO GANG DOUBLE UNSWITCHED SOCKET

Type E6

THERMOSTAT CONTROLS

Drawing Details

Drawing Title:

PROPOSED CLONMEL TOILET
GROUND FLOOR REFLECTIVE CEILING PLAN

Ref:

25228-SP-XX-XX-DR-IA-232

Scale:

1:20@ A1

Project Stage:

Stage 1

Client Details:

TIPPERARY ETB

All dimensions to be checked on site.

Do not scale dimensions from this drawing, use figured dimensions only.

Refer to Engineer's drawings and specification for all structural and services information.

Any discrepancies between the Architect's and Engineer's drawings to be reported to the Architect immediately.

The survey information shown on this drawing is based on a survey prepared by a third party and Spentide Ltd accept no responsibility for the accuracy or completeness of the survey

Document Record

P/S	Purpose / Description/	Date	Rev
1	Issued for Information	25.02.26	00
1	Issued for Review	27.02.26	01
1	Issued for Review	08.04.26	02
3	Issued for Tender	26.06.26	03

80 Main Street, Midleton, Co. Cork,
P25 ET04 Ireland.

Email:

info@spentide.ie

Website:

www.spentide.ie

Tel:

+ 353 21 4633815
+ 353 87 9903810

© Drawing and content are copyright

***Note* Tie in with existing lighting, fire alarm and heating circuits as well as water pipework (Refer to Existing 25228-SP-XX-XX-DR-IA-282&292)**