


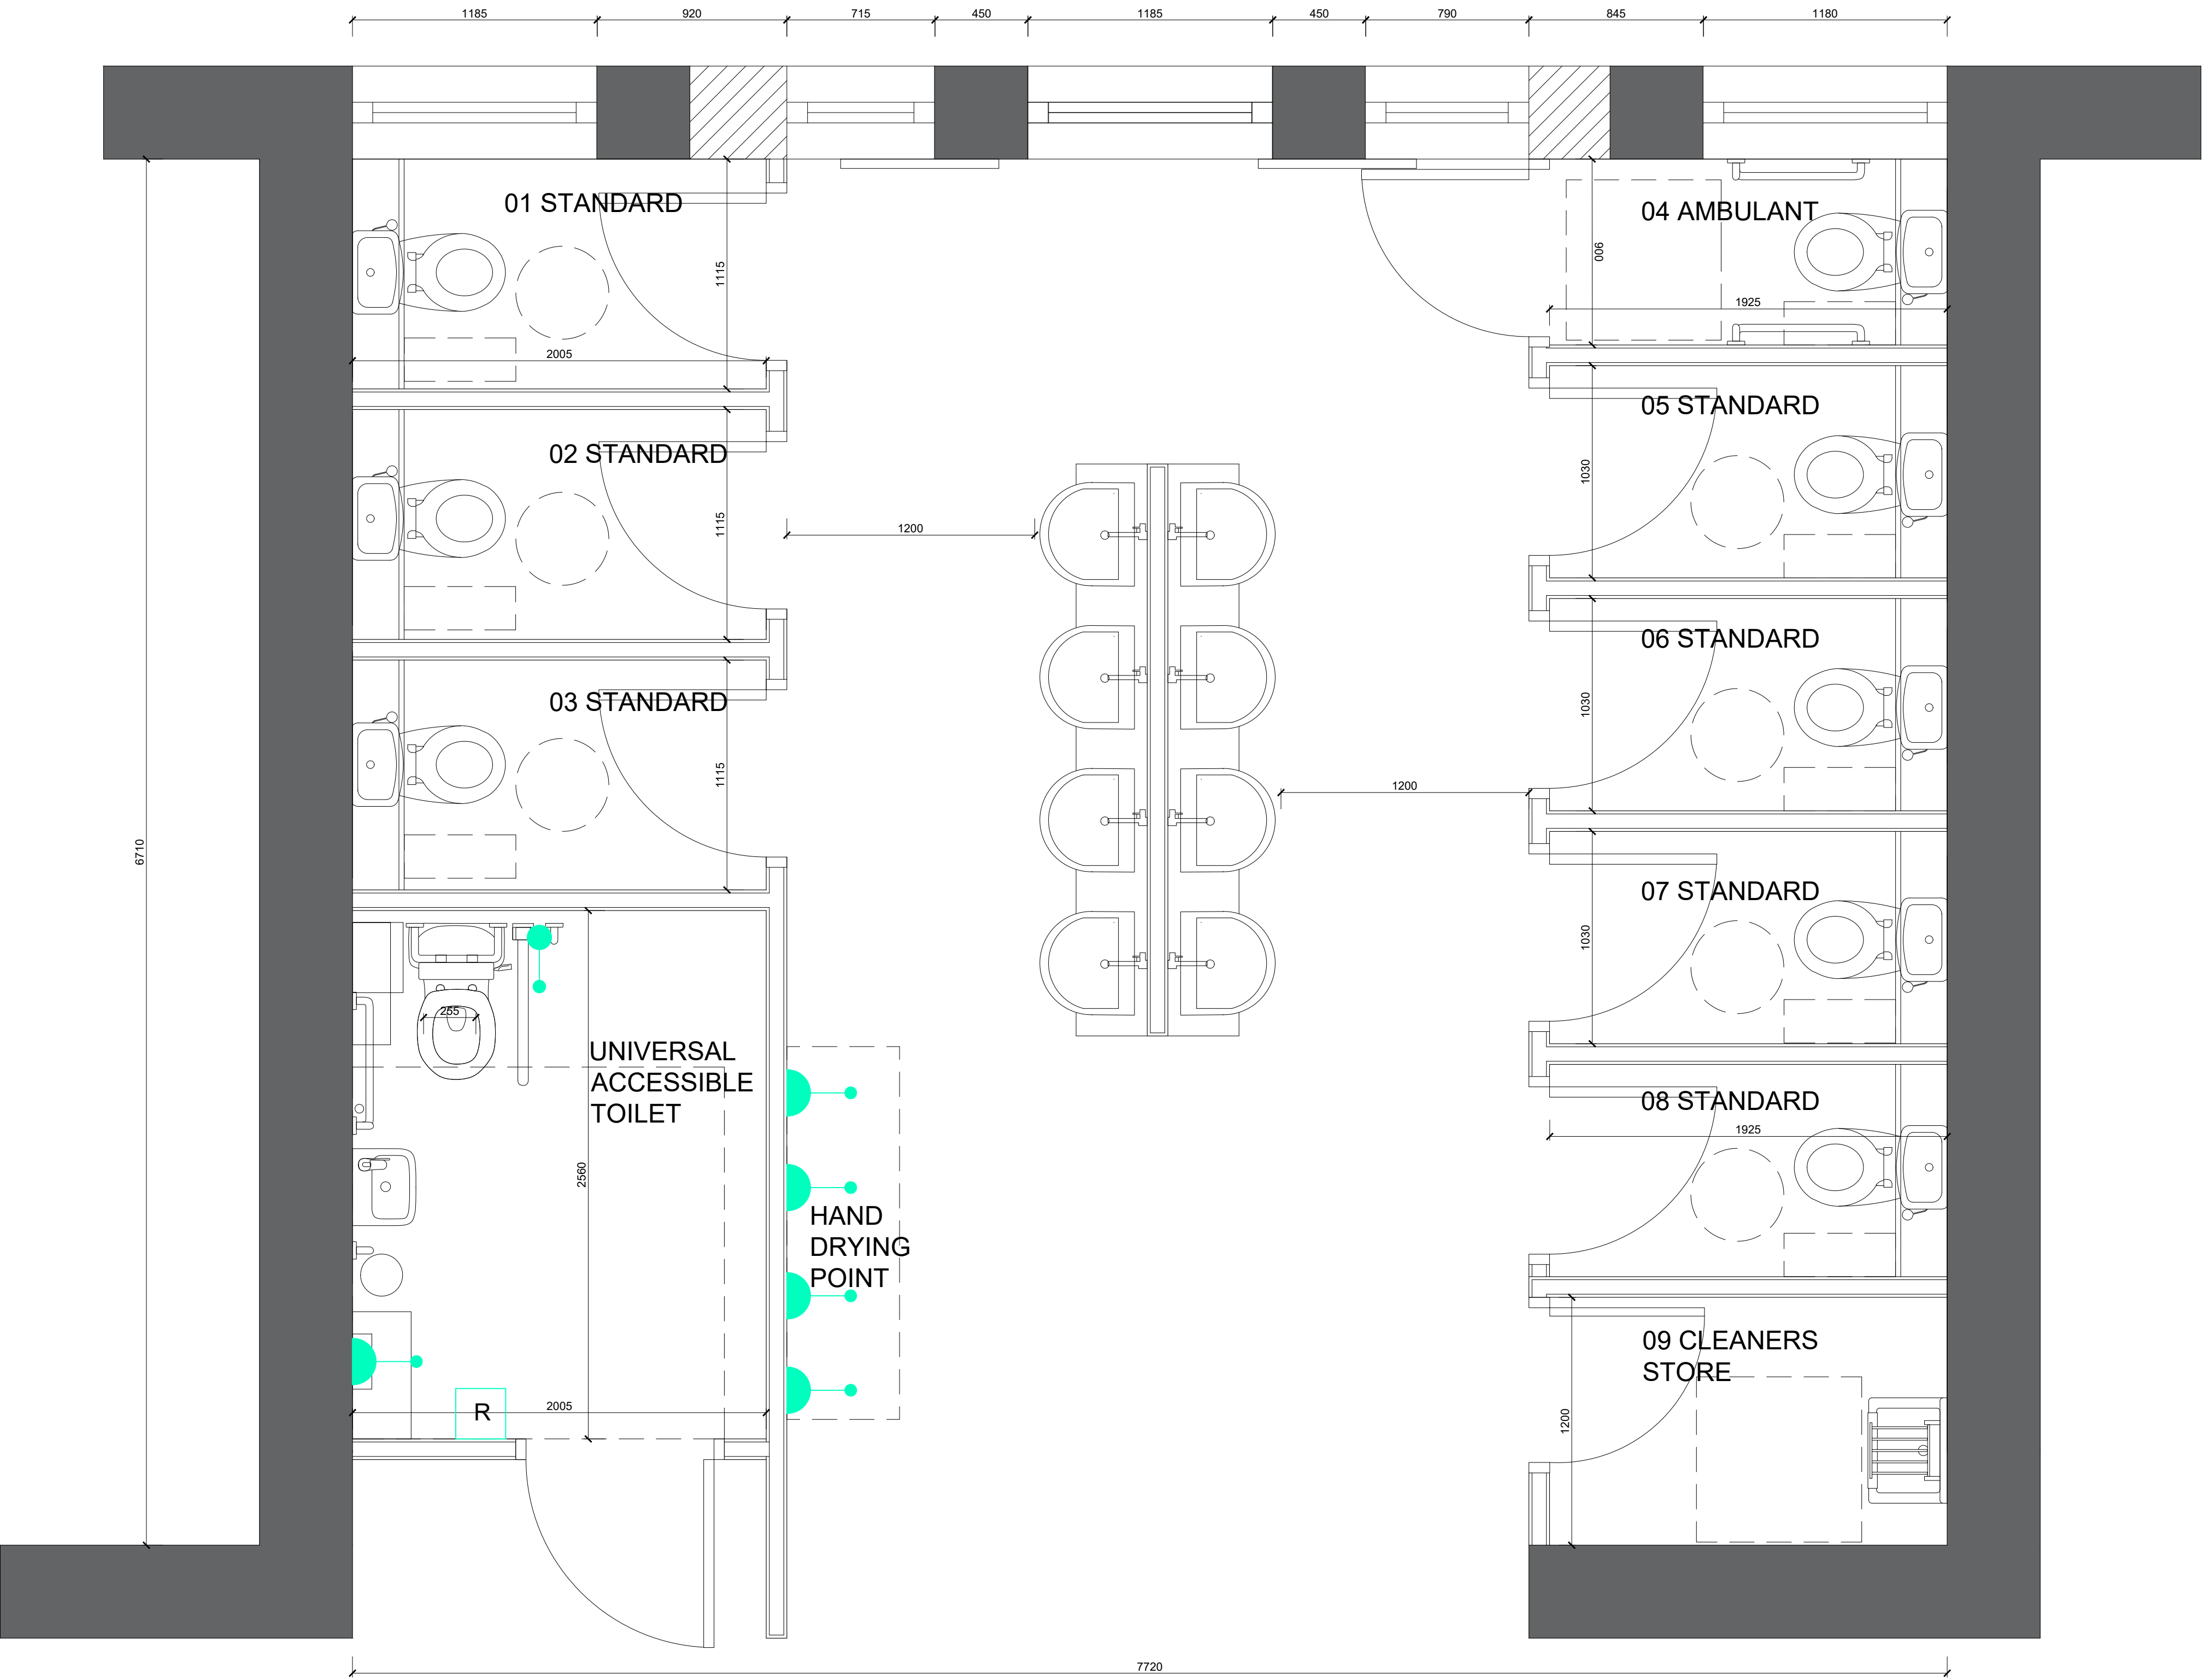

ELECTRICAL LEGEND	
Type E1	13AMP SPW OUTLET WALL MOUNTED
Type E2	
Type E3	CALL- RESET RUSH BUTTON WALL MOUNTED
Type E4	ALARM PULL CORD
Type E5	LIGHT SWITCH WALL MOUNTED
Type E6	13AMP. TWO GANG DOUBLE UNSWITCHED SOCKET
	T THERMOSTAT CONTROLS

Drawing Details

Drawing Title:

PROPOSED CLONMEL TOILET
GROUND ELECTRICAL FLOOR PLAN

Ref: 25228-SP-XX-XX-DR-IA-272

Scale:

1:20@ A1

TIPPERARY FET COLLEGE CLONMEL,
THE MALL,
CLONMEL,
CO.TIPPERARY
E91 K2E2

Project Stage:
Stage 1

Client Details:
TIPPERARY ETB

All dimensions to be checked on site.

Do not scale dimensions from this drawing,
use figured dimensions only.
Refer to Engineer's drawings and specification
for all structural and services information.

Any discrepancies between the Architect's and
Engineer's drawings to be reported to the
Architect immediately.

The survey information shown on this drawing
is based on a survey prepared by a third party
and Spentide Ltd accept no responsibility for
the accuracy or completeness of the survey

Document Record

P/S	Purpose / Description/	Date	Rev
1	Issued for Review	08.04.26	00
3	Issued for Tender	26.06.26	00

Proposed Clonmel Electrical Ground Floor Plan
Scale at 1:20



80 Main Street, Middleton, Co. Cork,
P25 ET04 Ireland.

Email: info@spentide.ie
Website: www.spentide.ie

Tel: + 353 21 4633815
+ 353 87 9903810

© Drawing and content are copyright