


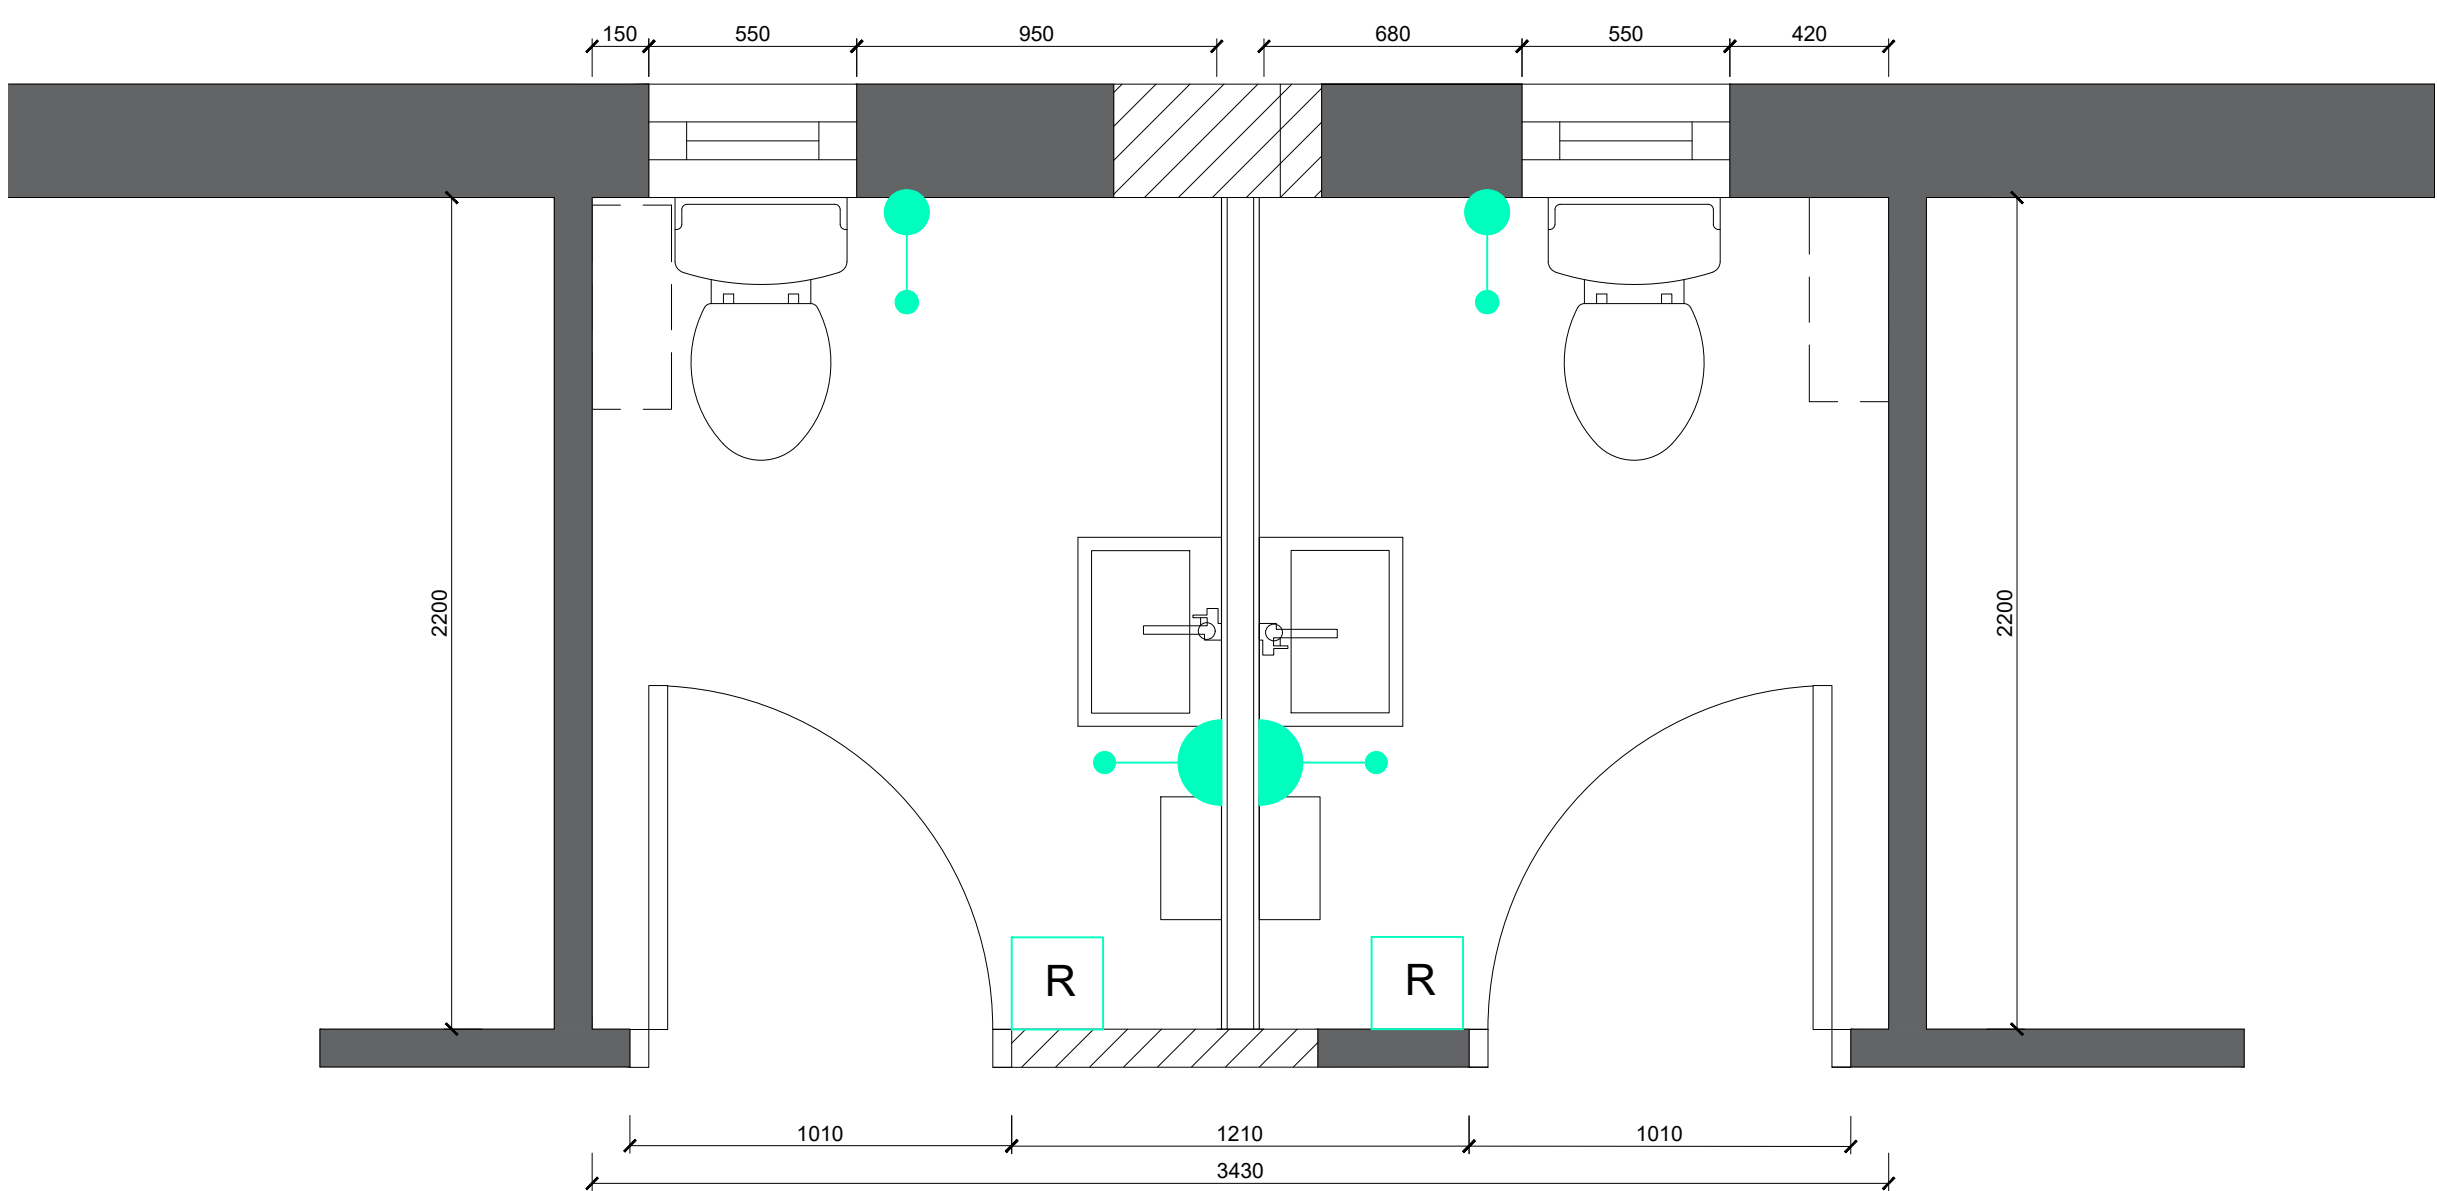

ELECTRICAL LEGEND

- Type E1
13AMP SPW OUTLET WALL MOUNTED
- Type E2
CALL- RESET RUSH BUTTON WALL MOUNTED
- Type E3
ALARM PULL CORD
- Type E4
LIGHT SWITCH WALL MOUNTED
- Type E5
13AMP. TWO GANG DOUBLE UNSWITCHED SOCKET
- Type E6
THERMOSTAT CONTROLS

Proposed Cappawhite Electrical Floor Plan
Scale at 1:20

Drawing Details

Drawing Title:

PROPOSED CAPPAWHITE TOILET
ELECTRICAL FLOOR PLAN

Ref: 25228-SP-XX-XX-DR-IA-270

Scale:

1:20@ A1

TIPPERARY FET COLLEGE CAPPAWHITE,
CAPPAWHITE,
CO.TIPPERARY
E34 A320

Project Stage:

Stage 1

Client Details:

TIPPERARY ETB

All dimensions to be checked on site.

Do not scale dimensions from this drawing,
use figured dimensions only.

Refer to Engineer's drawings and specification
for all structural and services information.

Any discrepancies between the Architect's and
Engineer's drawings to be reported to the
Architect immediately.

The survey information shown on this drawing
is based on a survey prepared by a third party
and Spentide Ltd accept no responsibility for
the accuracy or completeness of the survey

Document Record

P/S	Purpose / Description/	Date	Rev
1	Issued for Review	08.04.26	00
3	Issued for Tender	26.06.26	00



80 Main Street, Midleton, Co. Cork,
P25 ET04 Ireland.

Email: info@spentide.ie
Website: www.spentide.ie

Tel: + 353 21 4633815
+ 353 87 9903810

© Drawing and content are copyright