


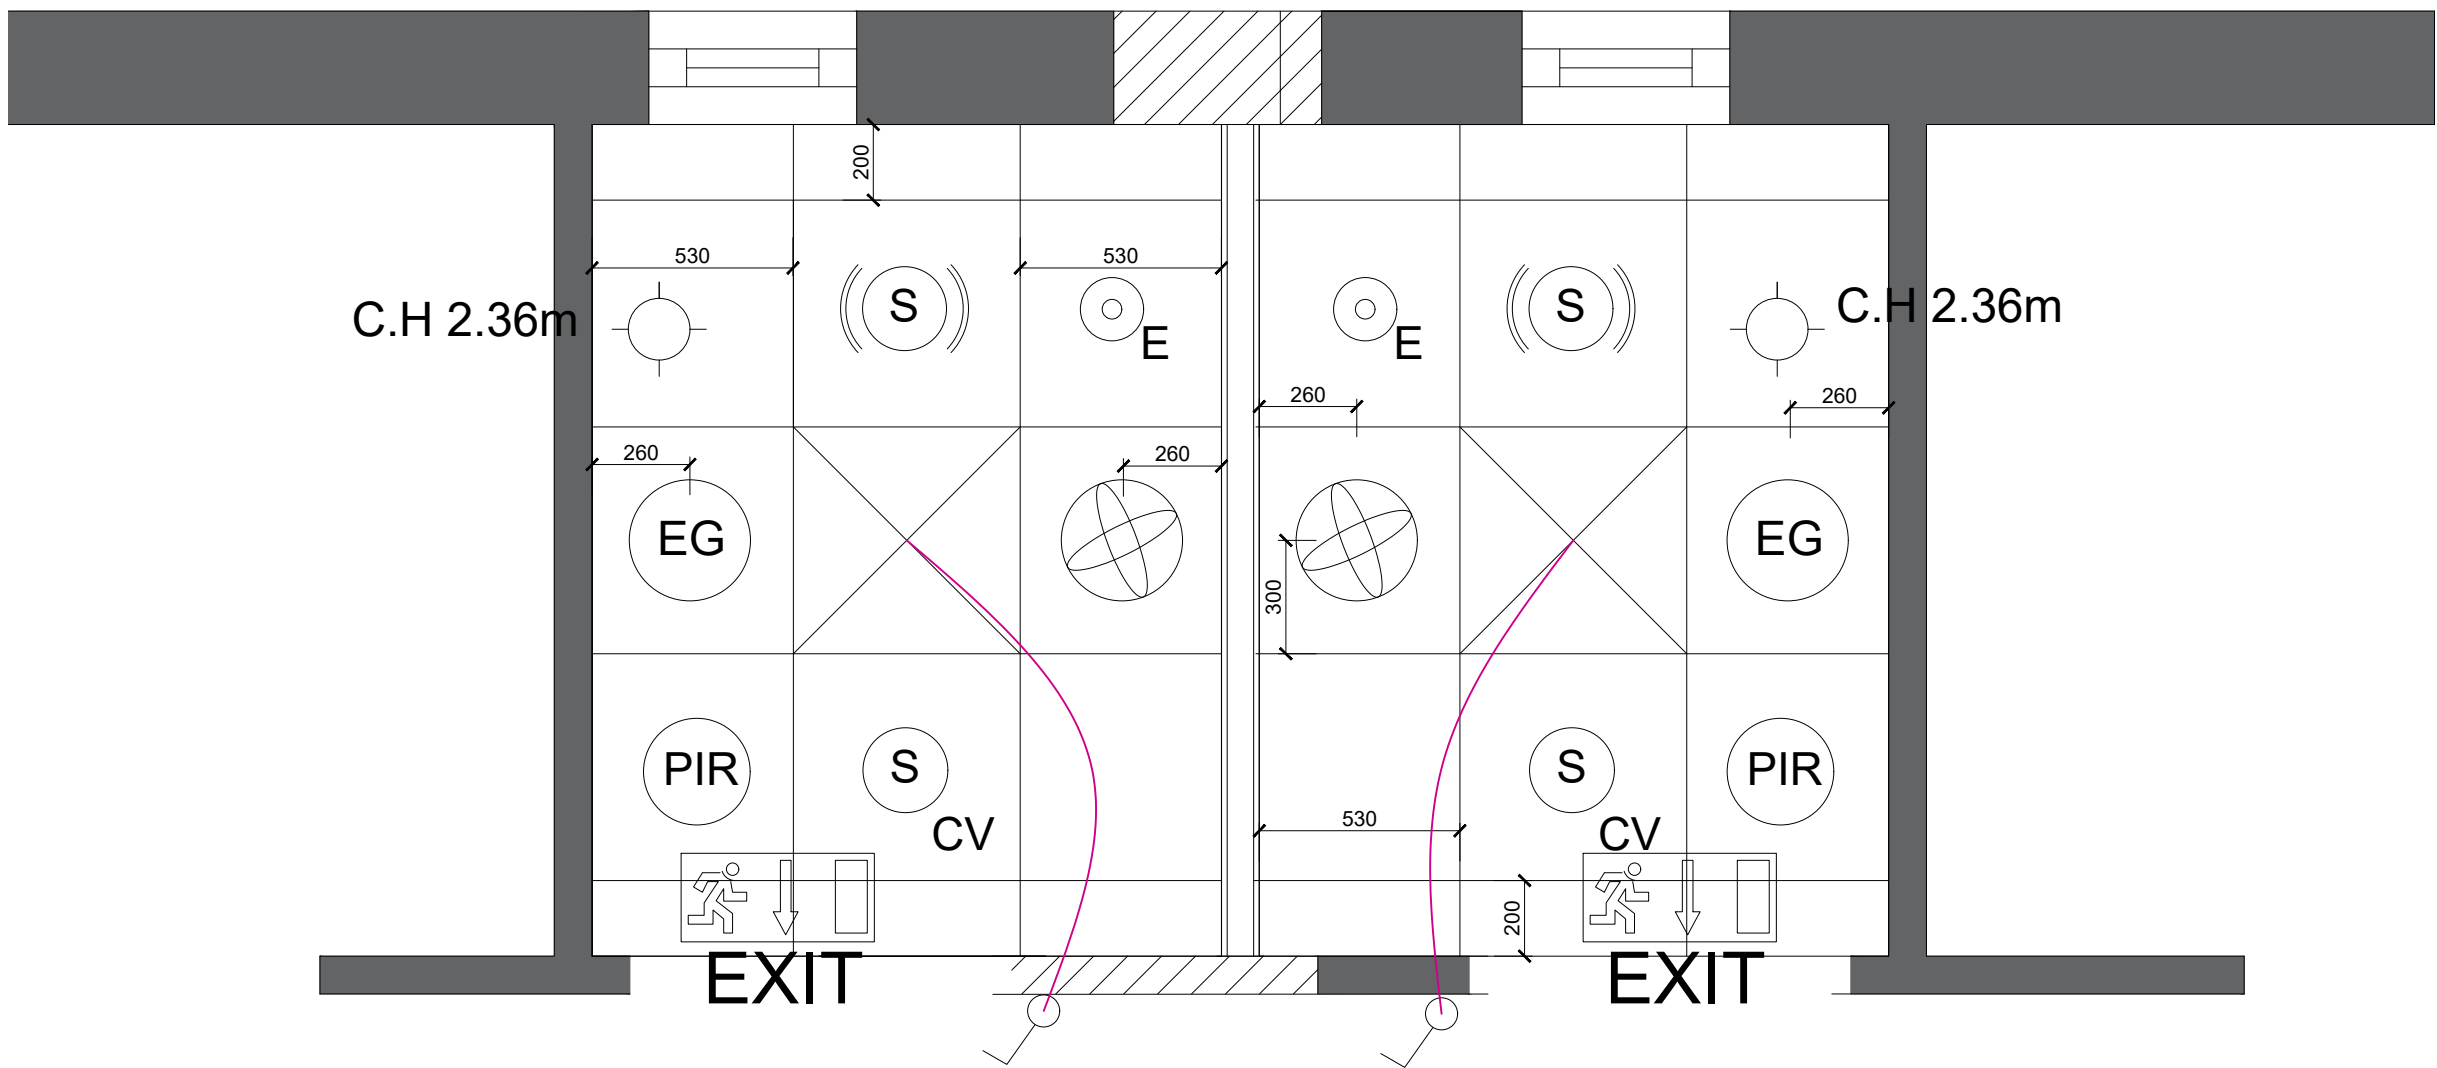

Proposed Cappawhite Reflective Ceiling Plan
Scale at 1:20

CEILING FINISH LEGEND	
Type C1	600 x 600mm Grid Ceiling Tiles
Type C2	600 x 1200mm Grid Ceiling Tiles
Type C3	Moisture Resistant Plasterboard

CEILING LIGHTING LEGEND	
Type L1	LED LIGHT FITTING
Type L2	RECESSED LIGHT FITTING

*Note all STANDARD/AMBULANT/ENLARGED Rooms have the same C.H.2700mm

CEILING SERVICES LEGEND	
Type CS1	FAN
Type CS2	EXTRACTOR GRILLE
Type CS3	PASSIVE GRILLE/SUPPLY
Type CS4	EMERGENCY LIGHTING (3HR DURATION NON-MAINTAINED)
Type CS5	PASSIVE INFRARED SENSOR
Type CS6	FIRE ALARM SMOKE DETECTOR W/ SOUNDER
Type CS7	FIRE ALARM SMOKE DETECTOR LOCATED IN CEILING VOID
Type CS8	EMERGENCY FIRE EXIT SIGN
Type CS9	GRILLE, 200X200
Type CS10	AIR DUCT FOR SUPPLY AIR
Type CS11	AIR DUCT FOR EXTRACT AIR

*Note indicative air ducting routes, subject to contractor design

ELECTRICAL LEGEND	
Type E1	13AMP SPW OUTLET WALL MOUNTED
Type E2	CALL - RESET RUSH BUTTON WALL MOUNTED
Type E3	ALARM PULL CORD
Type E4	LIGHT SWITCH WALL MOUNTED
Type E5	13AMP, TWO GANG DOUBLE UNSWITCHED SOCKET
Type E6	THERMOSTAT CONTROLS

***Note* Tie in with existing lighting, fire alarm and heating circuits as well as water pipework (Refer to Existing 25228-SP-XX-XX-DR-IA-280&290)**

Drawing Title:
PROPOSED CAPPAWHITE TOILET REFLECTIVE CEILING PLAN
Ref: 25228-SP-XX-XX-DR-IA-230
Scale:
1:20@ A1
TIPPERARY FET COLLEGE CAPPAWHITE, CAPPAWHITE, CO.TIPPERARY E34 A320
Project Stage:
Stage 1
Client Details:
TIPPERARY ETB

All dimensions to be checked on site.
Do not scale dimensions from this drawing, use figured dimensions only.
Refer to Engineer's drawings and specification for all structural and services information.
Any discrepancies between the Architect's and Engineer's drawings to be reported to the Architect immediately.
The survey information shown on this drawing is based on a survey prepared by a third party and Spentide Ltd accept no responsibility for the accuracy or completeness of the survey

Document Record			
P/S	Purpose / Description/	Date	Rev
1	Issued for Information	25.02.26	00
1	Issued for Tender	27.02.26	01
1	Issued for Review	08.04.26	02
3	Issued for Tender	26.06.26	03



Architecture | Project Management

80 Main Street, Midleton, Co. Cork, P25 ET04 Ireland.

Email: info@spentide.ie
Website: www.spentide.ie

Tel: + 353 21 4633815
+ 353 87 9903810

© Drawing and content are copyright