


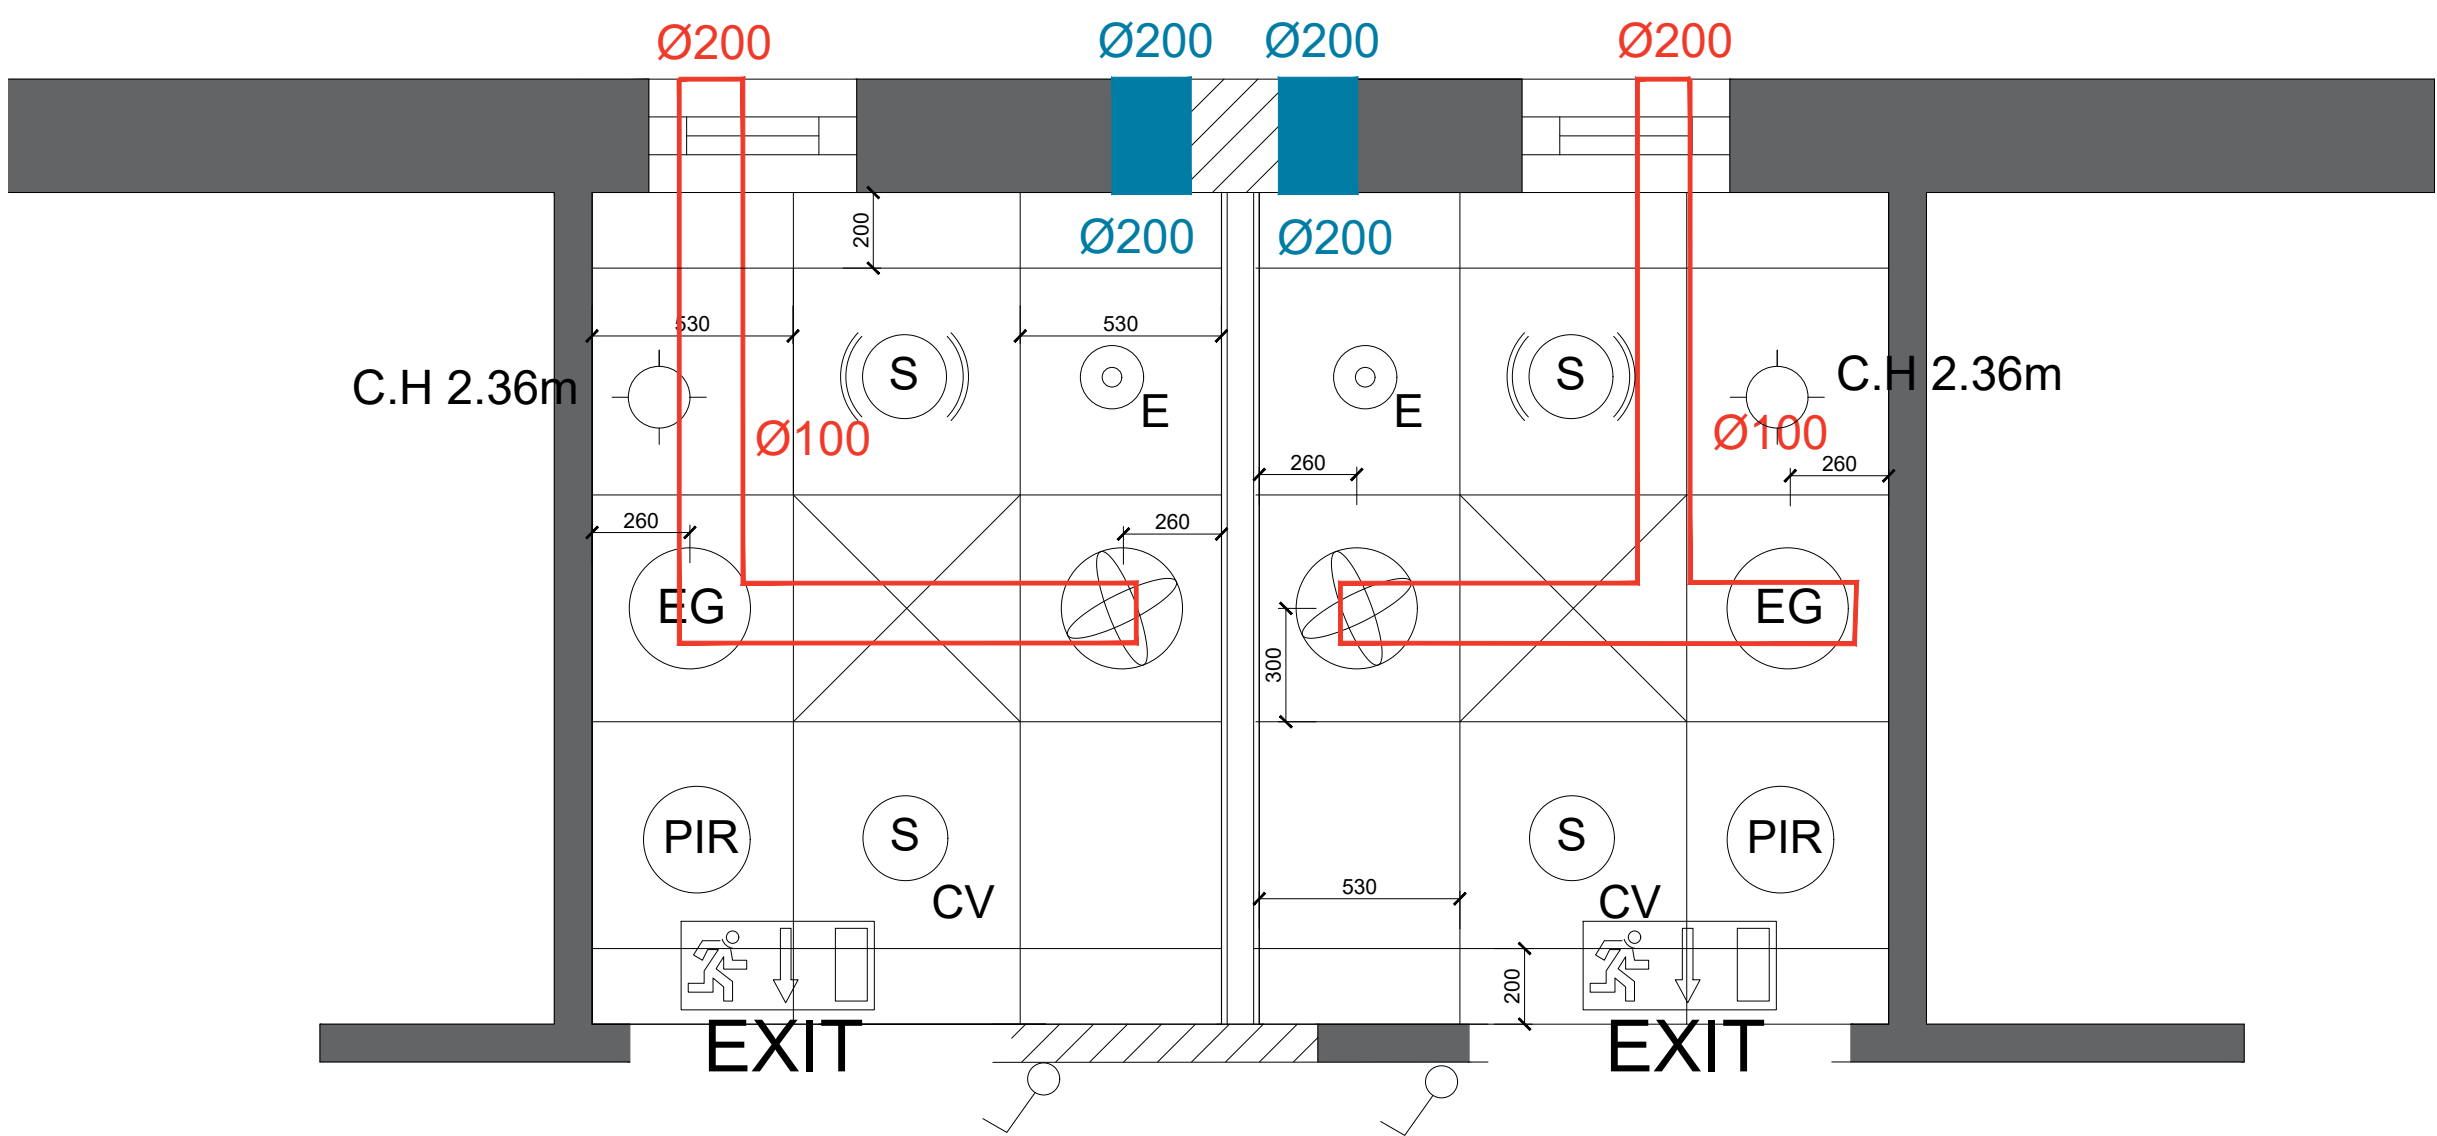

Proposed Cappawhite Mechanical Reflective Ceiling Plan
Scale at 1:20

CEILING FINISH LEGEND

- Type C1
600 x 600mm Grid Ceiling Tiles
- Type C2
600 x 1200mm Grid Ceiling Tiles
- Type C3
Moisture Resistant Plasterboard

CEILING LIGHTING LEGEND

- Type L1
LED LIGHT FITTING
- Type L2
RECESSED LIGHT FITTING
- *Note all STANDARD/AMBULANT/ENLARGED Rooms have the same C.H.2700mm

CEILING SERVICES LEGEND

- Type CS1
FAN
- Type CS2
EXTRACTOR GRILLE
- Type CS3
PASSIVE GRILLE/SUPPLY
- Type CS4
EMERGENCY LIGHTING (3HR DURATION NON-MAINTAINED)
- Type CS5
PASSIVE INFRARED SENSOR
- Type CS6
FIRE ALARM SMOKE DETECTOR W/ SOUNDER
- Type CS7
FIRE ALARM SMOKE DETECTOR LOCATED IN CEILING VOID
- Type CS8
EMERGENCY FIRE EXIT SIGN
- Type CS9
GRILLE, 200X200
- Type CS10
AIR DUCT FOR SUPPLY AIR
- Type CS11
AIR DUCT FOR EXTRACT AIR

*Note indicative air ducting routes, subject to contractor design

ELECTRICAL LEGEND

- Type E1
13AMP SPW OUTLET WALL MOUNTED
- Type E2
CALL- RESET RUSH BUTTON WALL MOUNTED
- Type E3
ALARM PULL CORD
- Type E4
LIGHT SWITCH WALL MOUNTED
- Type E5
13AMP- TWO GANG DOUBLE UNSWITCHED SOCKET
- Type E6
THERMOSTAT CONTROLS

***Note* Tie in with existing lighting, fire alarm and heating circuits as well as water pipework (Refer to Existing 25228-SP-XX-XX-DR-IA-280&290)**

Drawing Details

Drawing Title:
PROPOSED CAPPAWHITE TOILET
MECHANICAL REFLECTIVE CEILING PLAN
Ref: 25228-SP-XX-XX-DR-IA-280

Scale:
1:20@ A1

TIPPERARY FET COLLEGE CAPPAWHITE,
CAPPAWHITE,
CO.TIPPERARY
E34 A320

Project Stage:
Stage 1

Client Details:
TIPPERARY ETB

All dimensions to be checked on site.
Do not scale dimensions from this drawing, use figured dimensions only.
Refer to Engineer's drawings and specification for all structural and services information.
Any discrepancies between the Architect's and Engineer's drawings to be reported to the Architect immediately.
The survey information shown on this drawing is based on a survey prepared by a third party and Spentide Ltd accept no responsibility for the accuracy or completeness of the survey

Document Record

P/S	Purpose / Description/	Date	Rev
1	Issued for Review	08.04.26	00
3	Issued for Tender	26.06.26	01



80 Main Street, Midleton, Co. Cork,
P25 ET04 Ireland.

Email: info@spentide.ie
Website: www.spentide.ie

Tel: + 353 21 4633815
+ 353 87 9903810

© Drawing and content are copyright