
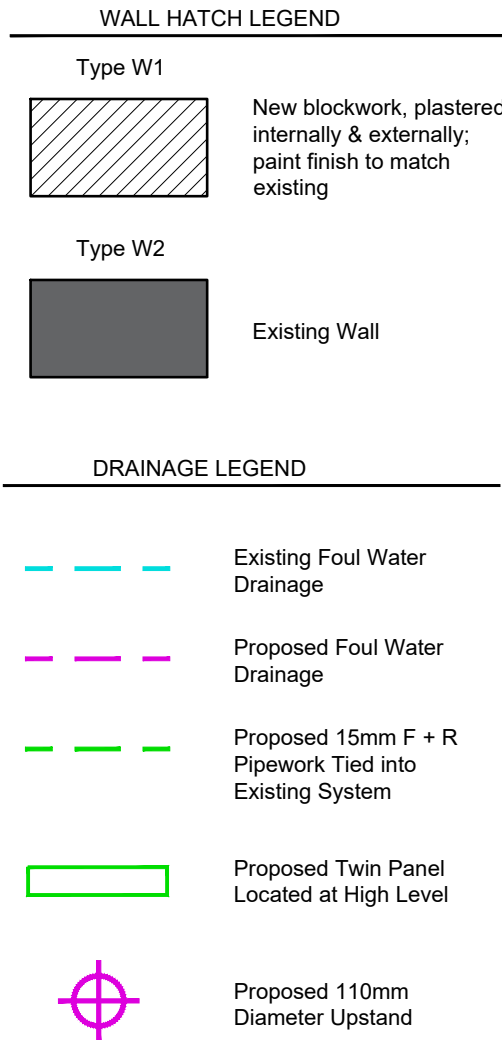


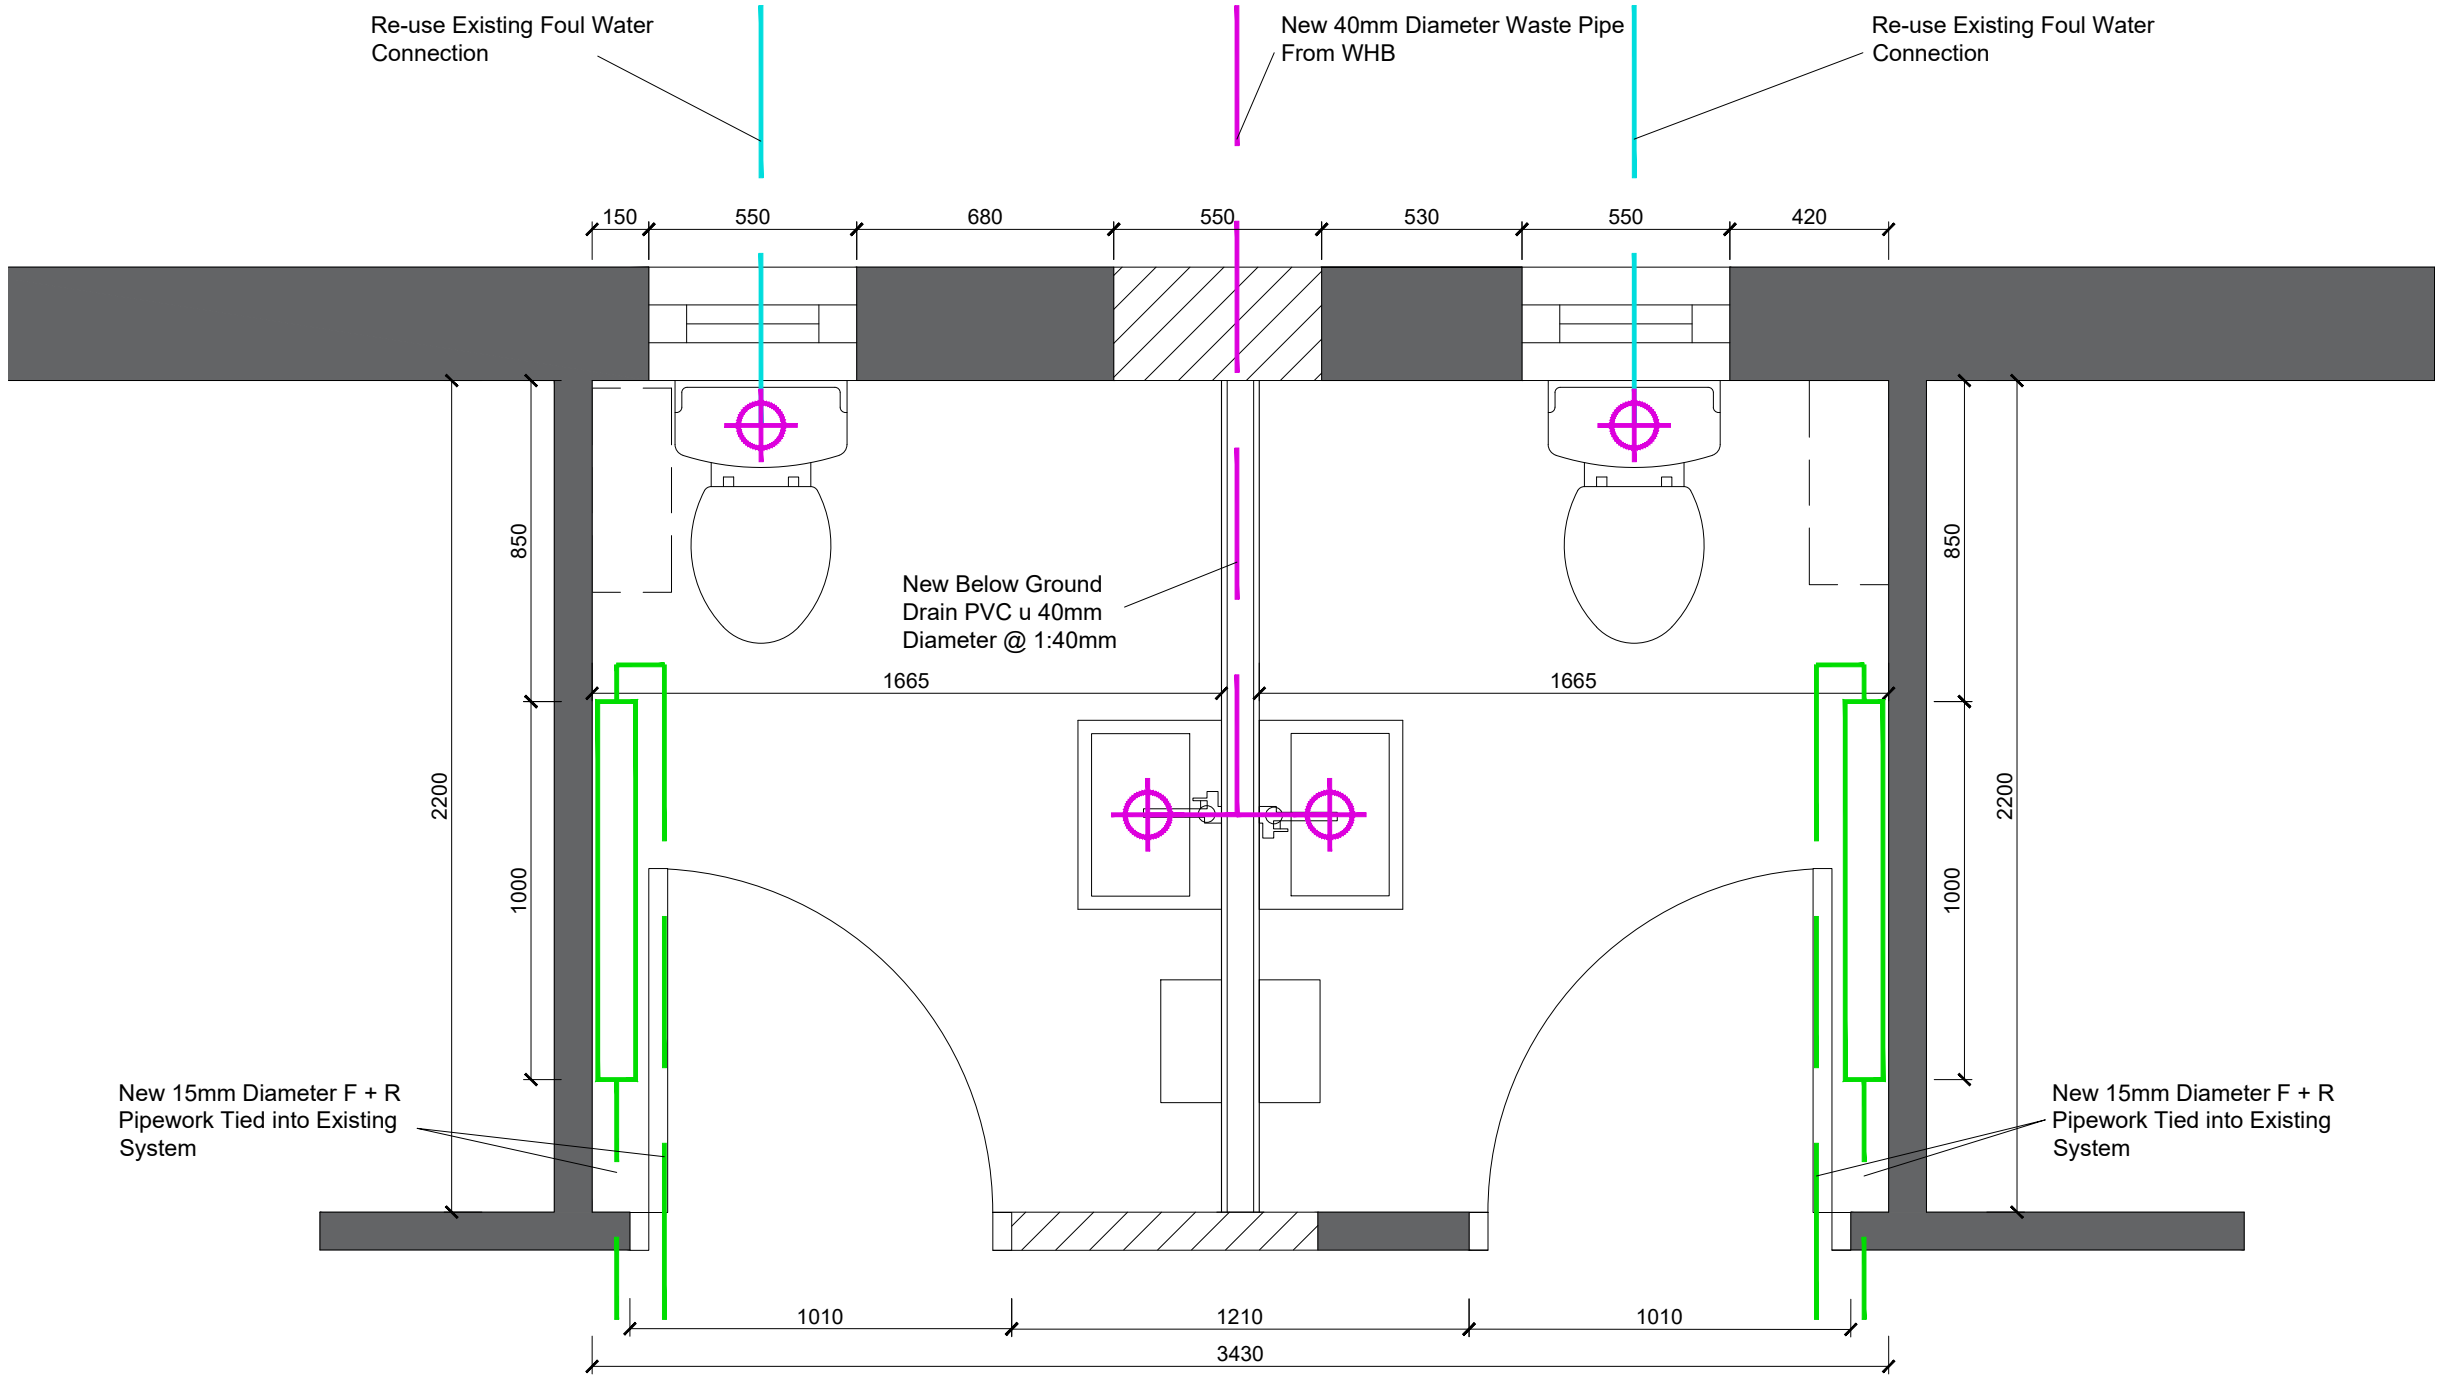

***Note* Tie in with existing lighting, fire alarm and heating circuits as well as water pipework (Refer to Existing 25228-SP-XX-XX-DR-IA-280&290)**

Proposed Cappawhite Toilet Mechanical Plan
Scale at 1:20

Drawing Details

Drawing Title:
PROPOSED CAPPAWHITE TOILET MECHANICAL PLAN

Ref: 25228-SP-XX-XX-DR-IA-250

Scale:
1:20@ A1

TIPPERARY FET COLLEGE CAPPAWHITE, CAPPAWHITE, CO.TIPPERARY E34 A320

Project Stage:
Stage 1

Client Details:
TIPPERARY ETB

All dimensions to be checked on site.

Do not scale dimensions from this drawing, use figured dimensions only.

Refer to Engineer's drawings and specification for all structural and services information.

Any discrepancies between the Architect's and Engineer's drawings to be reported to the Architect immediately.

The survey information shown on this drawing is based on a survey prepared by a third party and Spentide Ltd accept no responsibility for the accuracy or completeness of the survey

Document Record

P/S	Purpose / Description/	Date	Rev
1	Issued for Review	09.03.26	00
3	Issued for Tender	26.06.26	01