


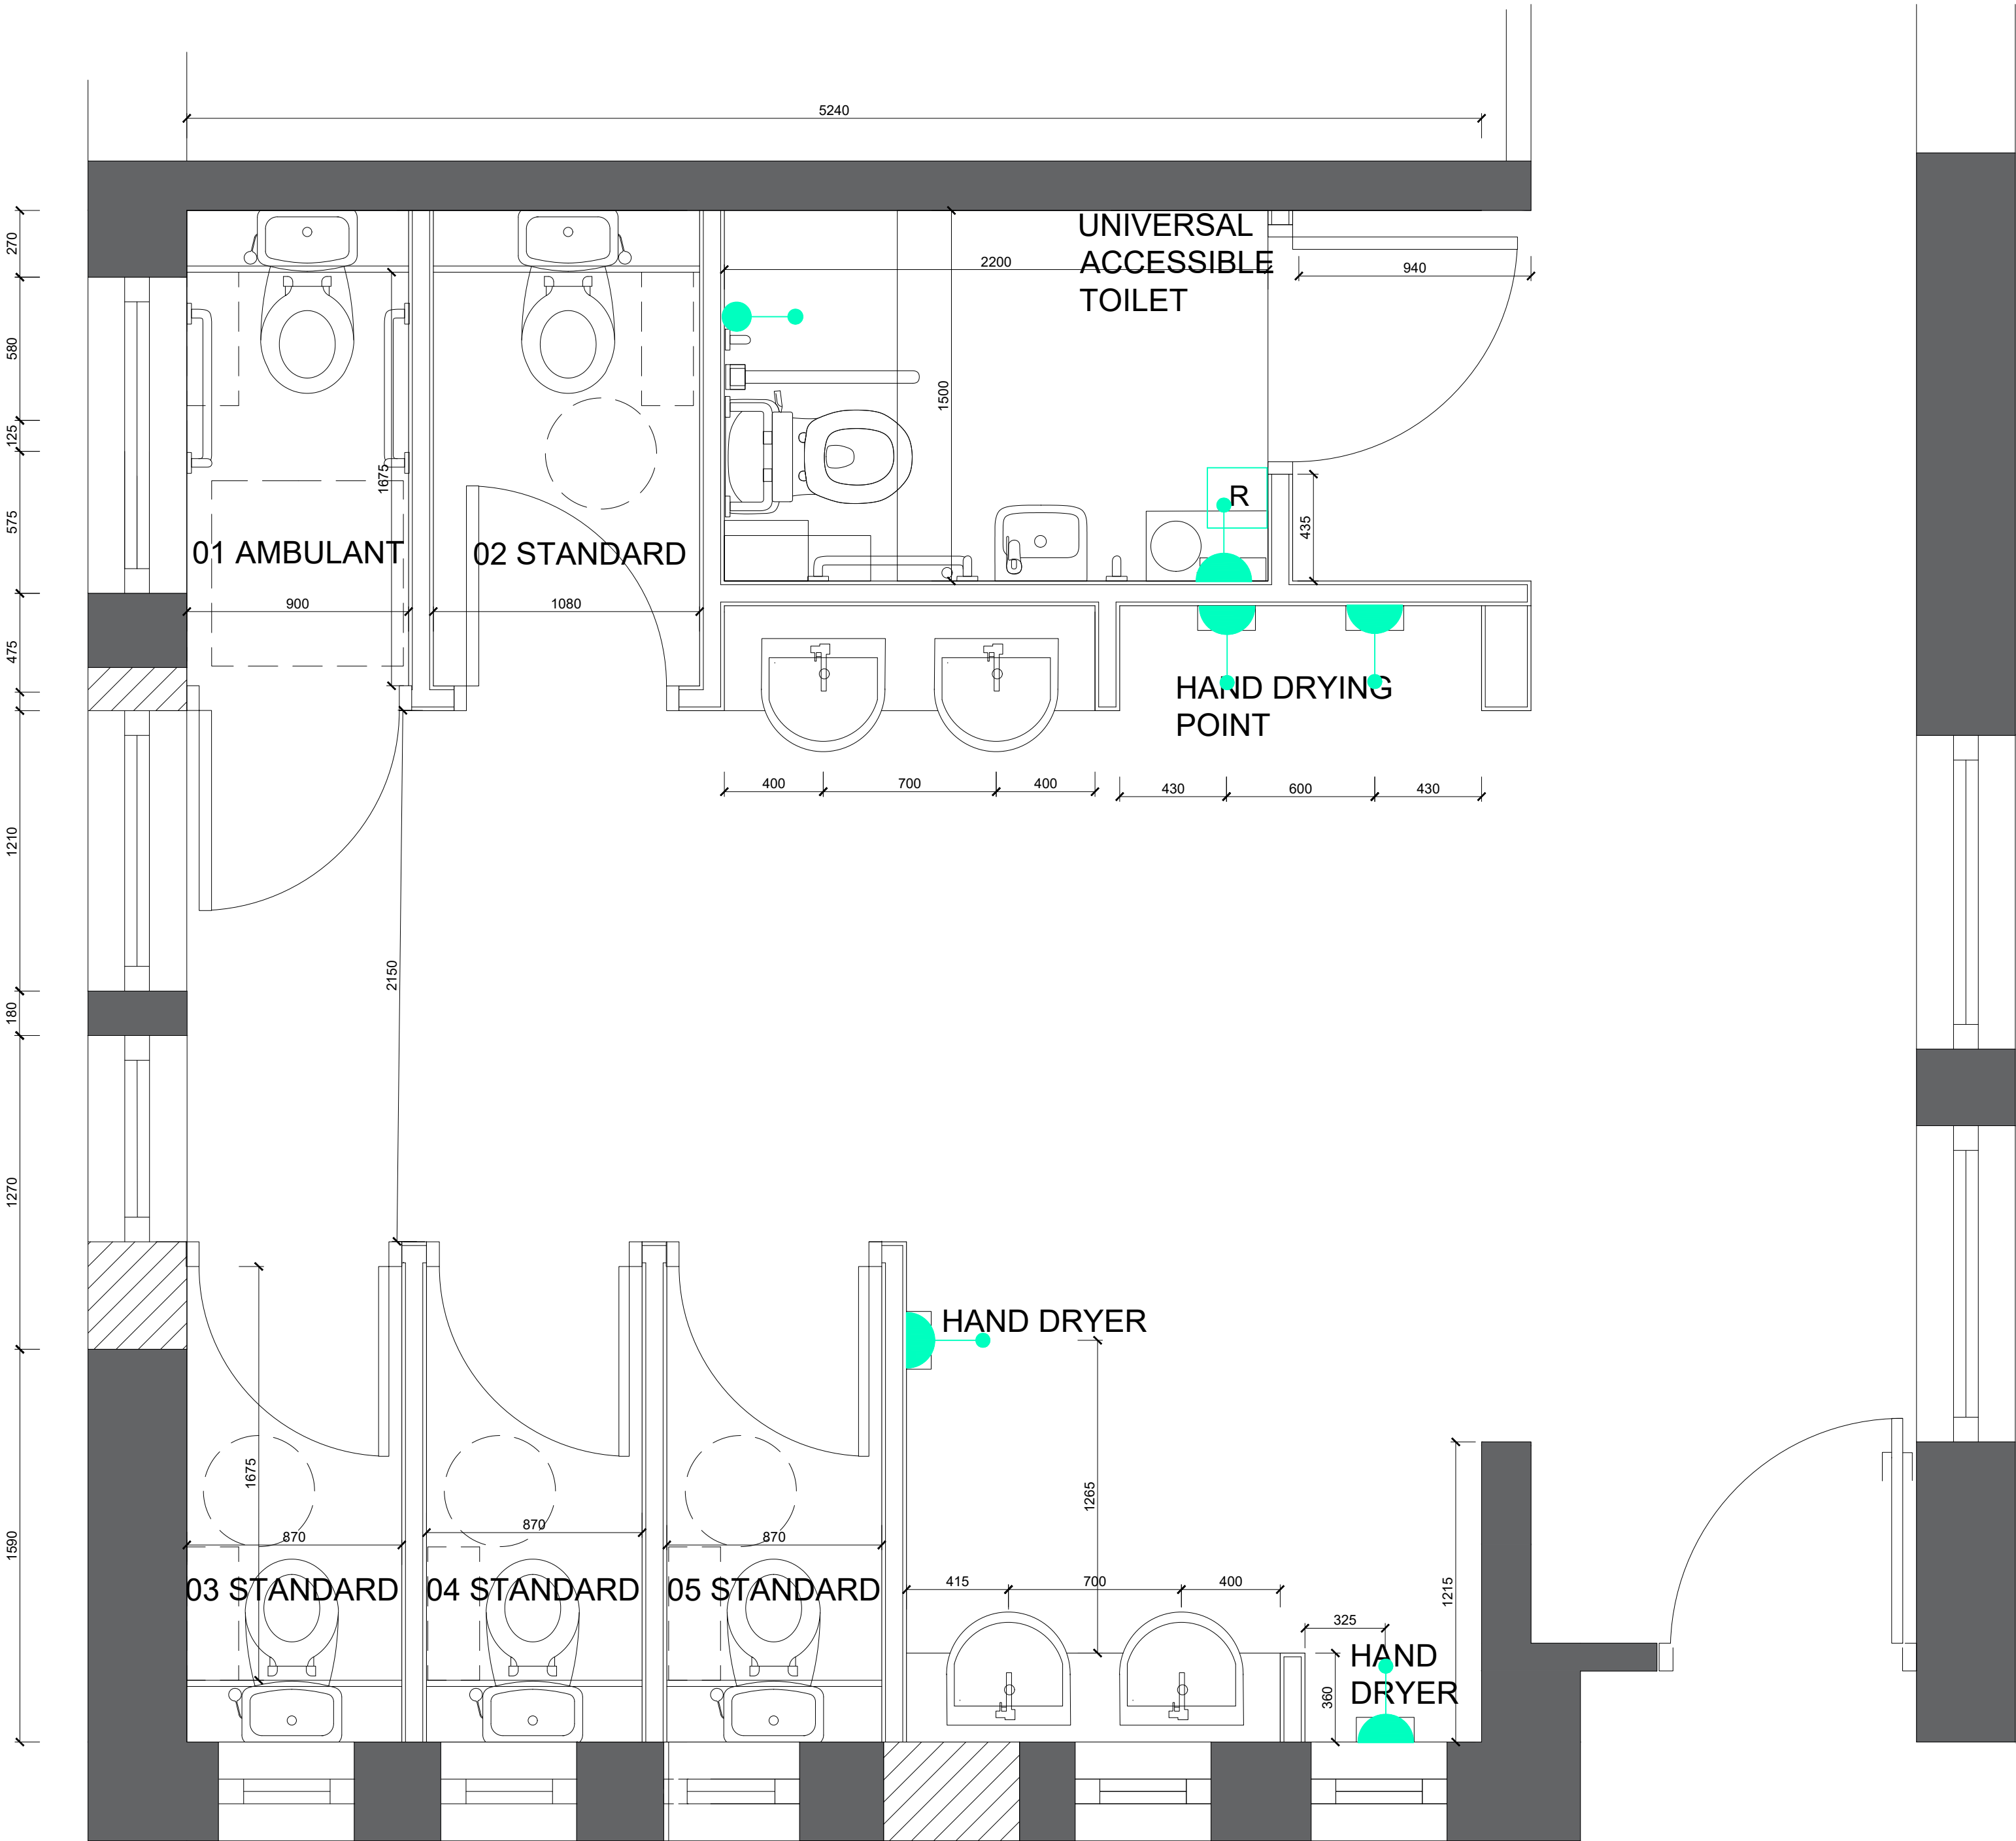

ELECTRICAL LEGEND	
Type E1	13AMP SPW OUTLET WALL MOUNTED
Type E2	CALL- RESET RUSH BUTTON WALL MOUNTED
Type E3	ALARM PULL CORD
Type E4	LIGHT SWITCH WALL MOUNTED
Type E5	13AMP, TWO GANG DOUBLE UNSWITCHED SOCKET
Type E6	THERMOSTAT CONTROLS

Drawing Details

Drawing Title:
PROPOSED ROSCREA TOILET ELECTRICAL FLOOR PLAN

Ref: 25228-SP-XX-XX-DR-IA-271

Scale:
1:20@ A1

TIPPERARY FET COLLEGE ROSCREA,
OLD DUBLIN ROAD,
ROSCREA,
CO.TIPPERARY
E53 P797

Project Stage:
Stage 1

Client Details:
TIPPERARY ETB

All dimensions to be checked on site.

Do not scale dimensions from this drawing, use figured dimensions only.

Refer to Engineer's drawings and specification for all structural and services information.

Any discrepancies between the Architect's and Engineer's drawings to be reported to the Architect immediately.

The survey information shown on this drawing is based on a survey prepared by a third party and Spentide Ltd accept no responsibility for the accuracy or completeness of the survey

Document Record			
P/S	Purpose / Description/	Date	Rev
1	Issued for Review	08.04.26	00
3	Issued for Tender	26.06.26	00

Proposed Roscrea Electrical Floor Plan
Scale at 1:20