


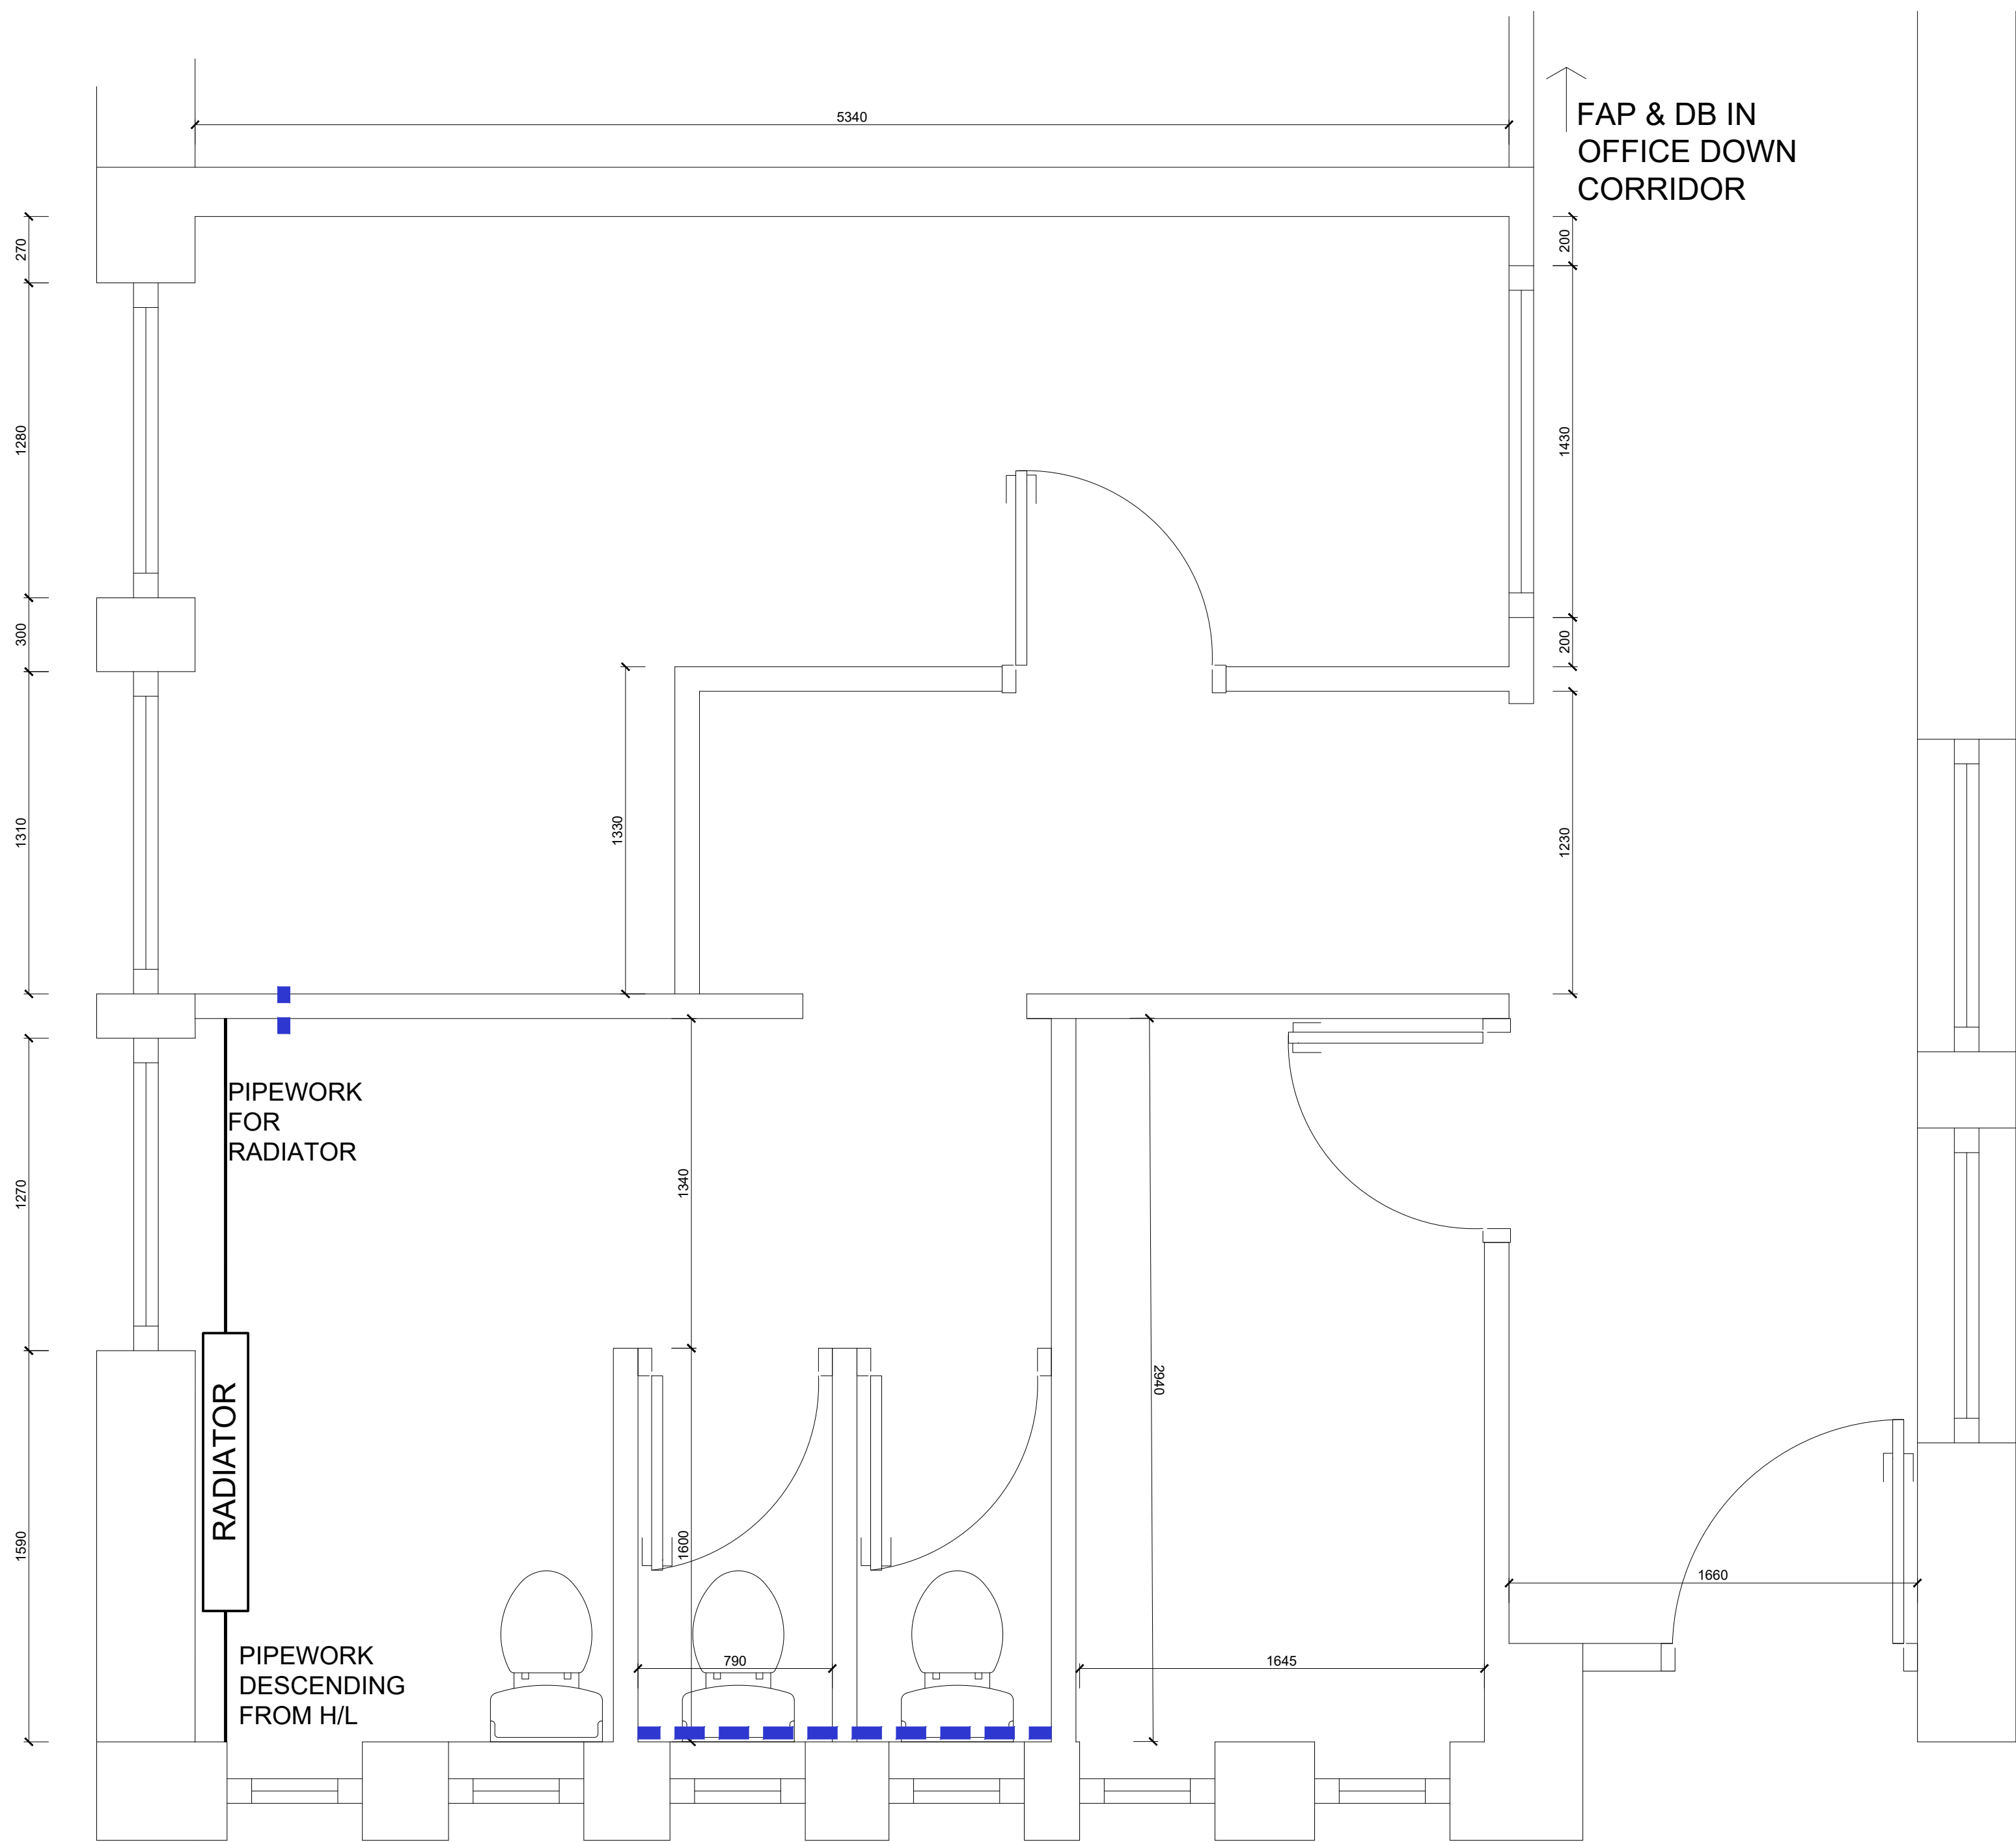

| DRAINAGE LEGEND |                     |
|-----------------|---------------------|
| ---             | Existing Cold Water |
| ---             | Existing Hot Water  |

Existing Roscrea Toilet Mechanical Floor Plan  
Scale at 1:20

Drawing Details

Drawing Title:  
EXISTING ROSCREA TOILET MECHANICAL FLOOR PLAN  
Ref: 25228-SP-XX-XX-DR-IA-291  
Scale:  
1:20@ A1  
TIPPERARY FET COLLEGE ROSCREA,  
OLD DUBLIN ROAD,  
ROSCREA,  
CO.TIPPERARY  
E53 P797  
Project Stage:  
Stage 1  
Client Details:  
TIPPERARY ETB

All dimensions to be checked on site.  
Do not scale dimensions from this drawing, use figured dimensions only.  
Refer to Engineer's drawings and specification for all structural and services information.  
Any discrepancies between the Architect's and Engineer's drawings to be reported to the Architect immediately.  
The survey information shown on this drawing is based on a survey prepared by a third party and Spentide Ltd accept no responsibility for the accuracy or completeness of the survey

| Document Record |                        |          |     |
|-----------------|------------------------|----------|-----|
| P/S             | Purpose / Description/ | Date     | Rev |
| 3               | Issued for Tender      | 26.06.26 | 00  |
|                 |                        |          |     |
|                 |                        |          |     |
|                 |                        |          |     |
|                 |                        |          |     |



Spentide

Architecture | Project Management

80 Main Street, Midleton, Co. Cork,  
P25 ET04 Ireland.  
Email: info@spentide.ie  
Website: www.spentide.ie  
Tel: + 353 21 4633815  
+ 353 87 9903810  
© Drawing and content are copyright