


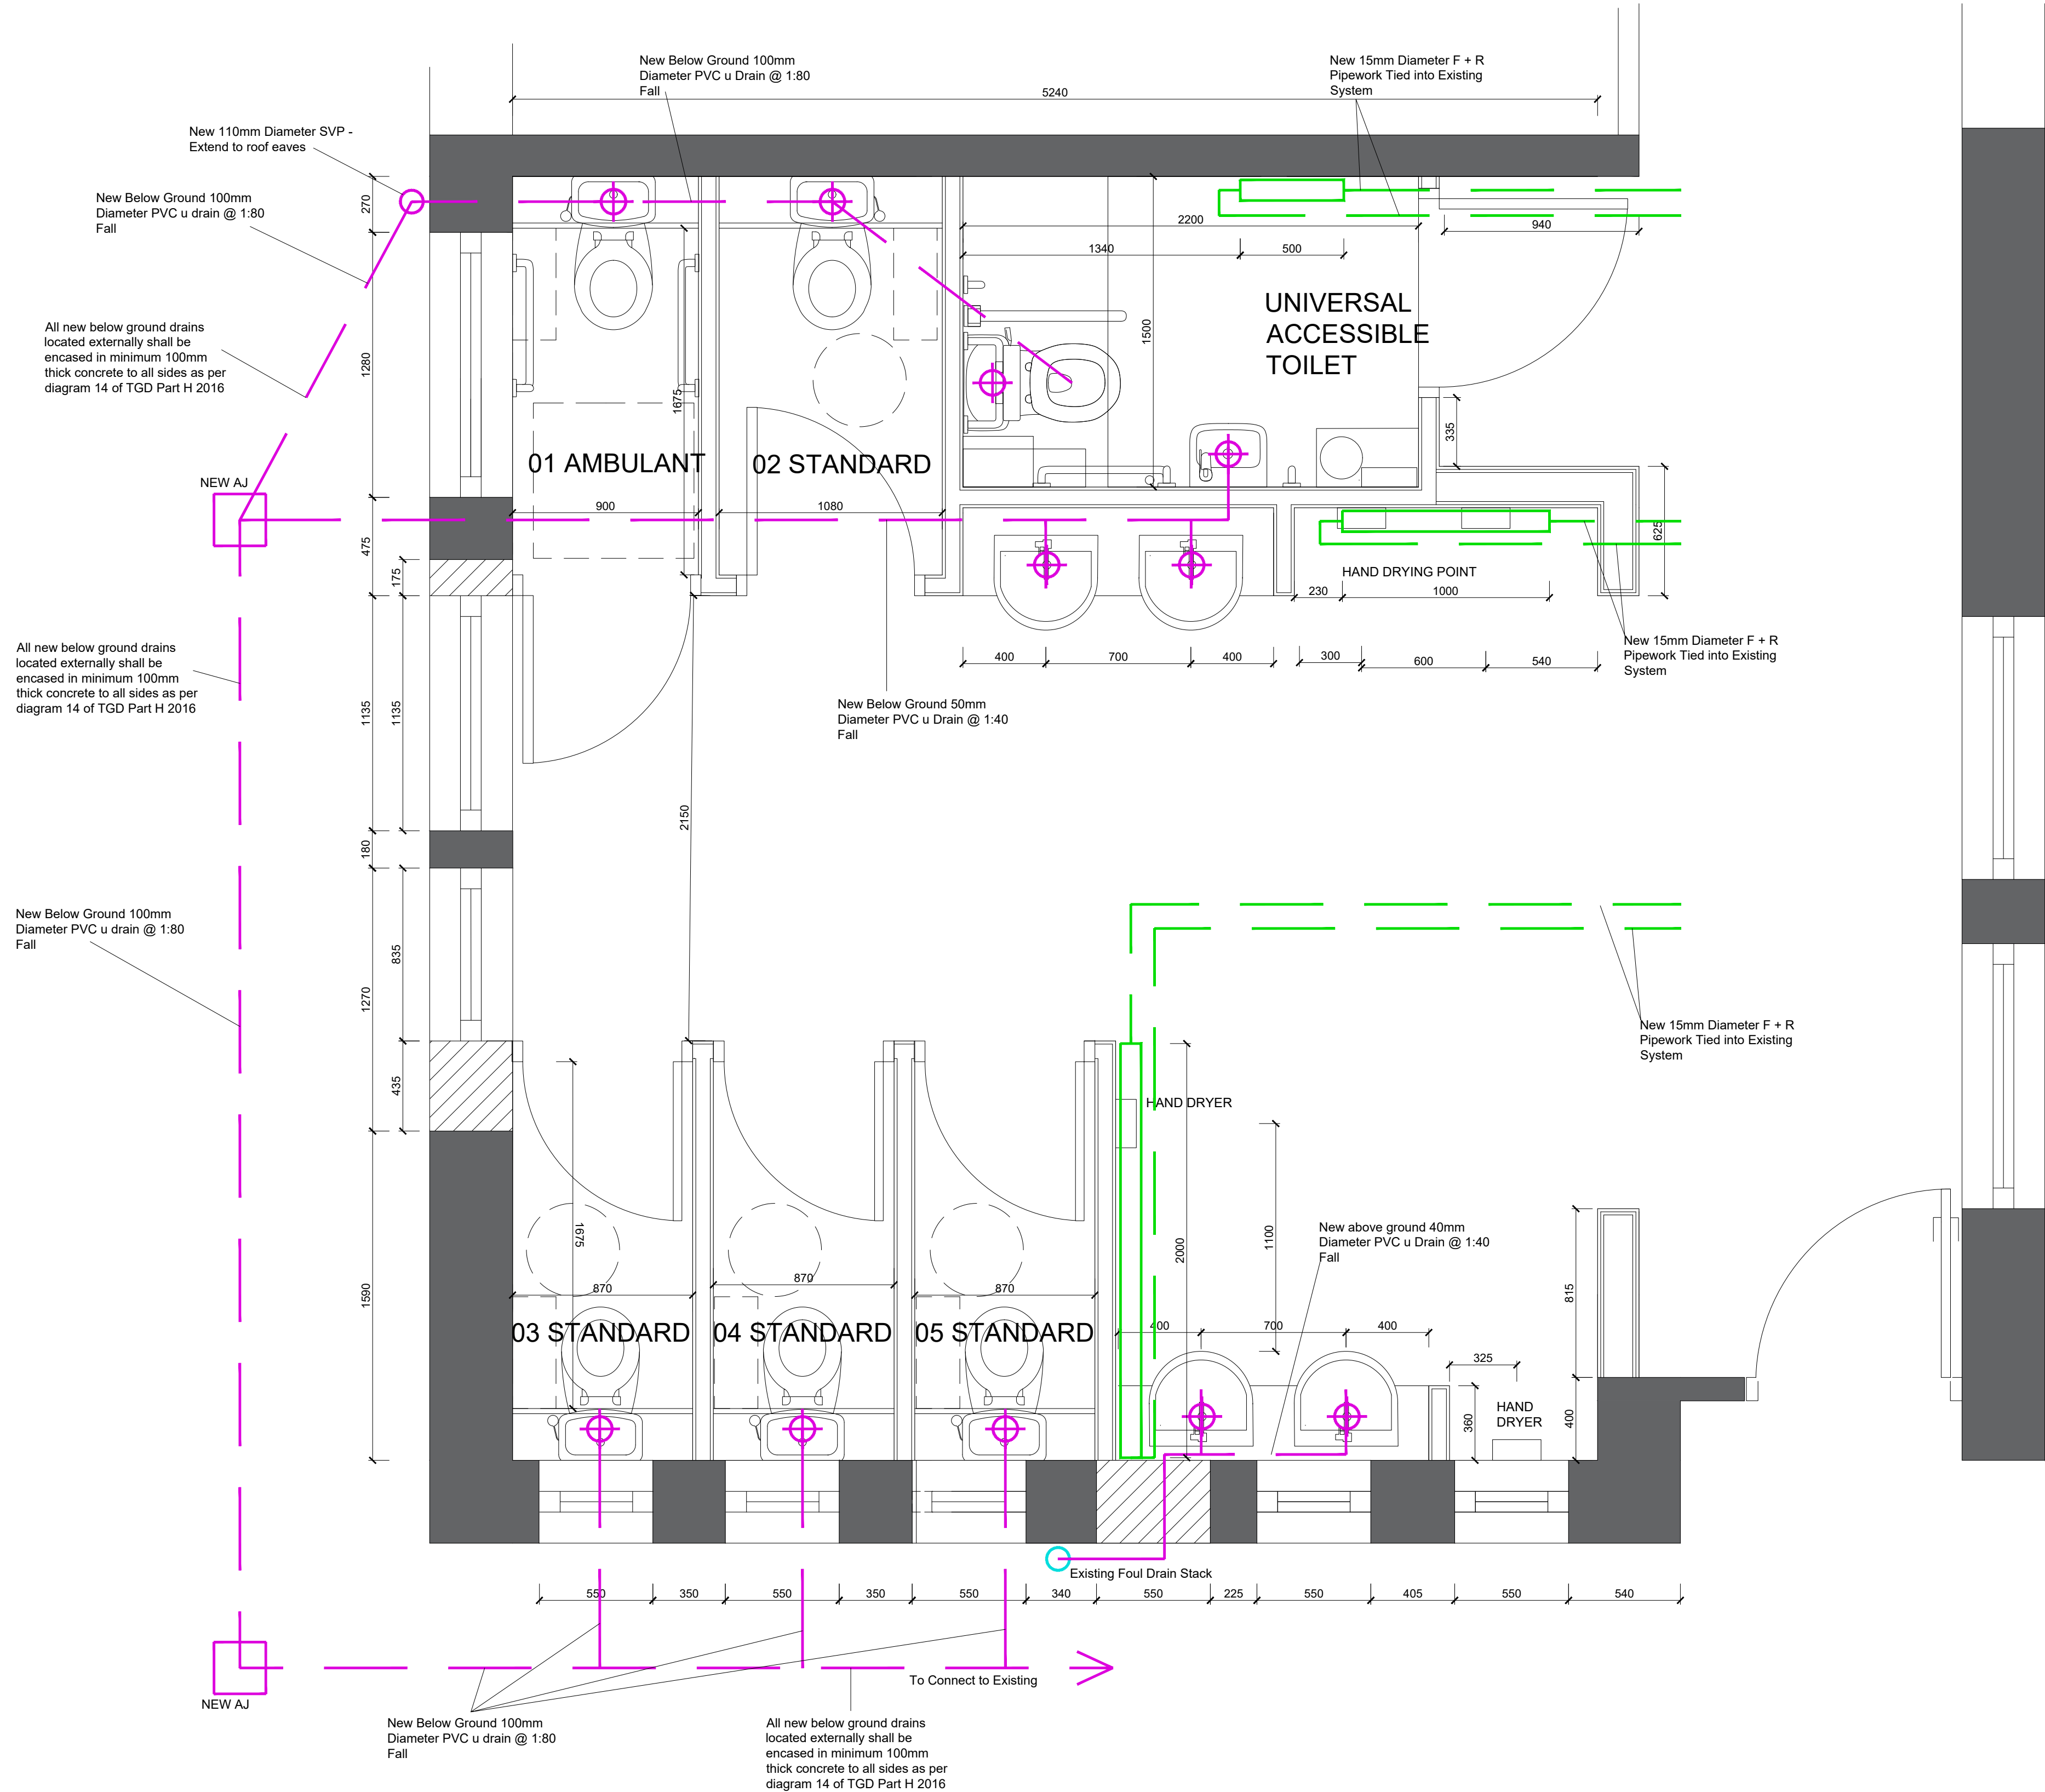

Proposed Roscrea Toilet Mechanical Plan
Scale at 1:20

Drawing Details

Drawing Title:
PROPOSED ROSCREA TOILET MECHANICAL PLAN

Ref: 25228-SP-XX-XX-DR-IA-251

Scale:
1:20@ A1

TIPPERARY FET COLLEGE ROSCREA,
OLD DUBLIN ROAD,
ROSCREA,
CO.TIPPERARY
E53 P797

Project Stage:
Stage 1

Client Details:
TIPPERARY ETB

All dimensions to be checked on site.

Do not scale dimensions from this drawing, use figured dimensions only.

Refer to Engineer's drawings and specification for all structural and services information.

Any discrepancies between the Architect's and Engineer's drawings to be reported to the Architect immediately.

The survey information shown on this drawing is based on a survey prepared by a third party and Spentide Ltd accept no responsibility for the accuracy or completeness of the survey

WALL HATCH LEGEND

Type W1
New blockwork, plastered internally & externally; paint finish to match existing

Type W2
Existing Wall

DRAINAGE LEGEND

Existing Foul Water Drainage

Proposed Foul Water Drainage

Proposed 15mm F + R Pipework Tied into Existing System

Proposed Twin Panel Located at High Level

Proposed 110mm Diameter Upstand

***Note* Tie in with existing lighting, fire alarm and heating circuits as well as water pipework (Refer to Existing 25228-SP-XX-XX-DR-IA-281&291)**

Document Record

P/S	Purpose / Description/	Date	Rev
1	Issued for Review	09.03.26	00
3	Issued for Tender	26.06.26	01