


	BATTLEMENT TO BE REMOVED AND FLASHING INSTALL BELOW RUNNING INTO GUTTER
	FLASHING RUNNING INTO GUTTER AT EVES LEVEL


GENERAL ENGINEERING NOTES

1. This drawing shall be read in conjunction with relevant Architectural, Civil and Mech/Elect drawings.
2. Figured dimensions only to be taken from this drawing.
3. All dimensions shall be checked on-site by the steelwork contractor and setting out dimensions shall be confirmed on site prior to fabrication of any steelwork. Any discrepancies shall be reported by the contractor to the Engineer or Architect without delay.

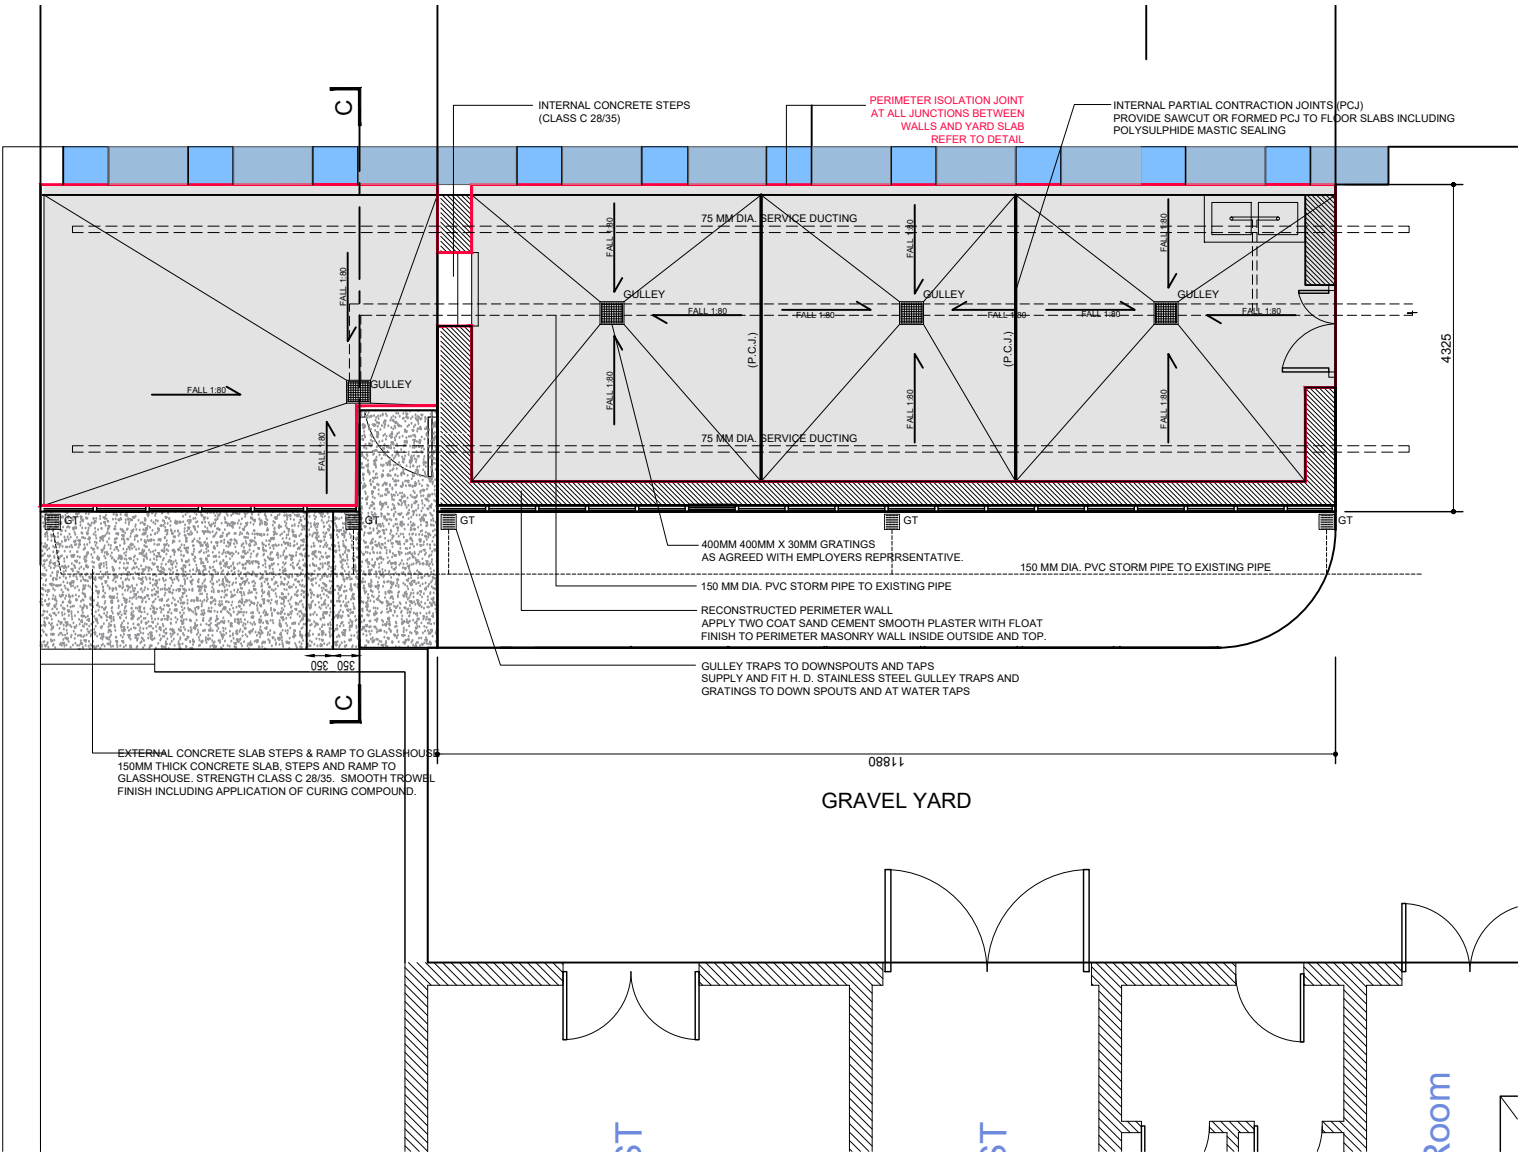


PROPOSED FLOOR PLAN & YARD

Scale 1/50

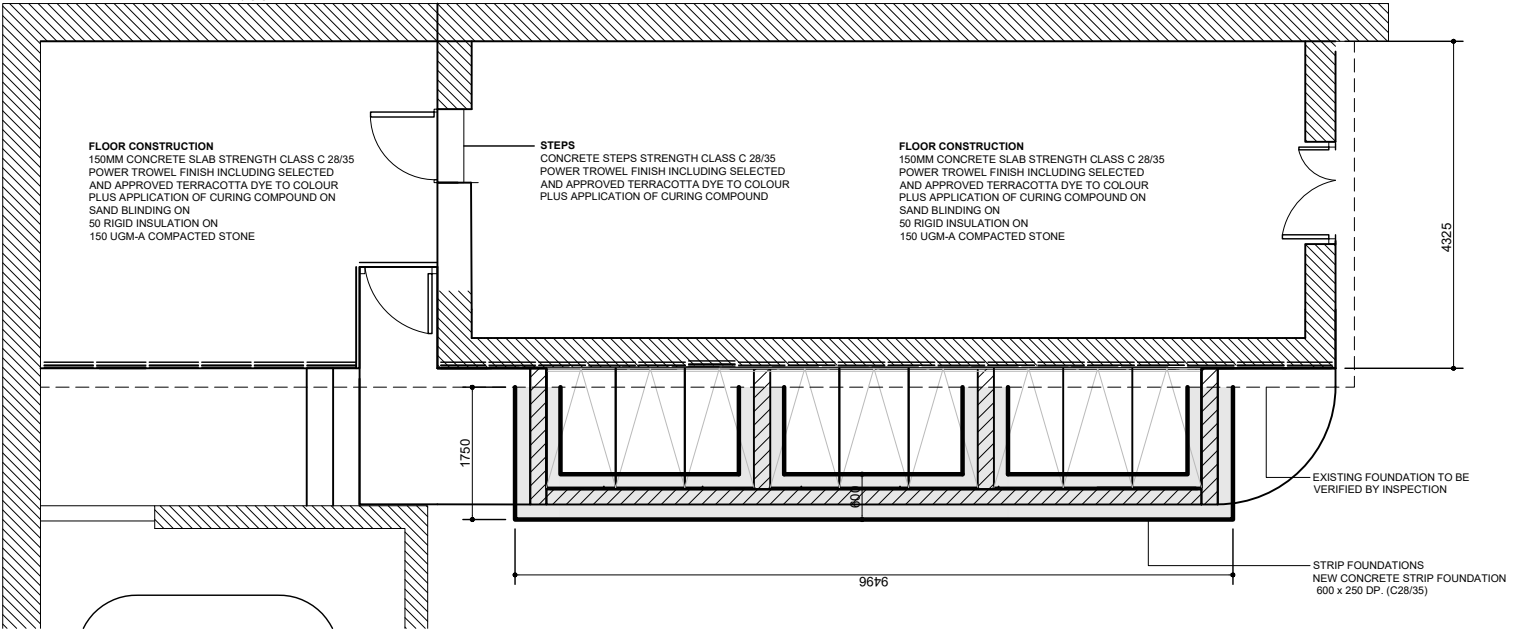

FOUNDATION PLAN

Scale 1/50

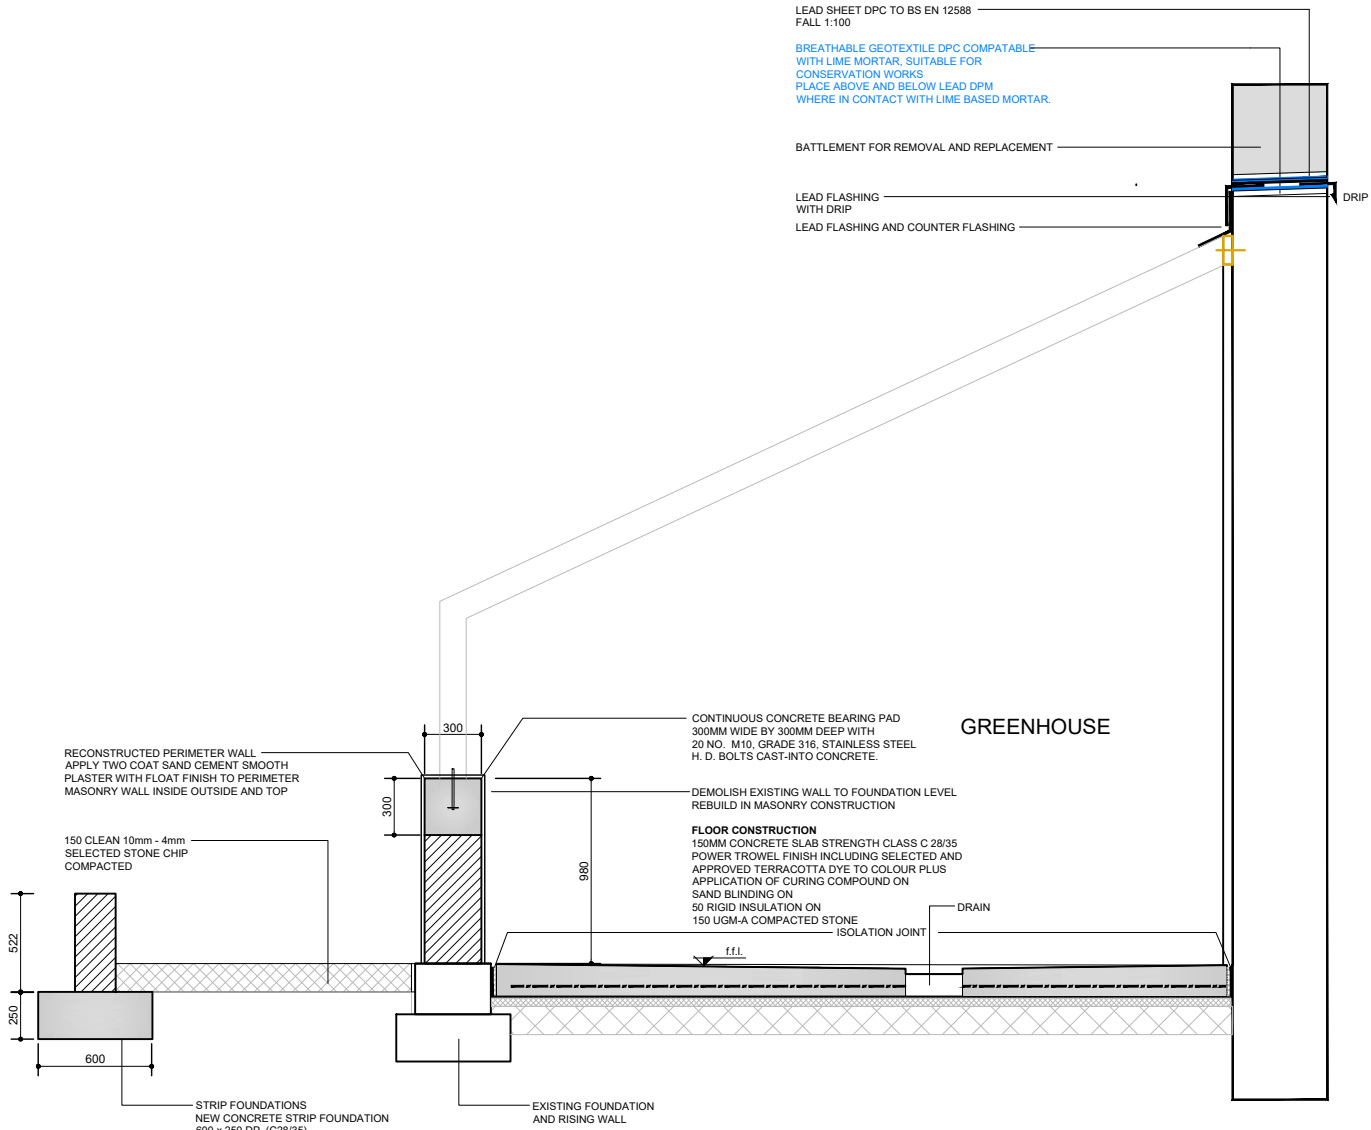

TYP. SECTION

Scale 1/20

Rev.	Amendment	Date	Dm.	Ckd.
-	-	-	P.G.	M.C.

Preliminary For Costing Only

Project:

Replacement of Existing Greenhouse at Glenveagh

Drawing:

Builders Plan

Dwg Num. EC 301	Scale 1/50	Date July 2026	Rev.
Job No. CC26-5065	Design M.C.	Drawn P.G.	Checked M.C.

Ordnance Survey Ireland Licence No. AR 0073408	REGISTERED FIRM
Ordnance Survey Ireland and Government of Ireland	

CARR CONSULTING ENGINEERS

Engineering Solutions

Unit 1, Northern Point, Business Park, Ballybolley, Co. Donegal
Tel (074)9131060 Fax (074)9130321 info@carrandco.ie