



FLOOR PLAN
SCALE -1:250 @ A1

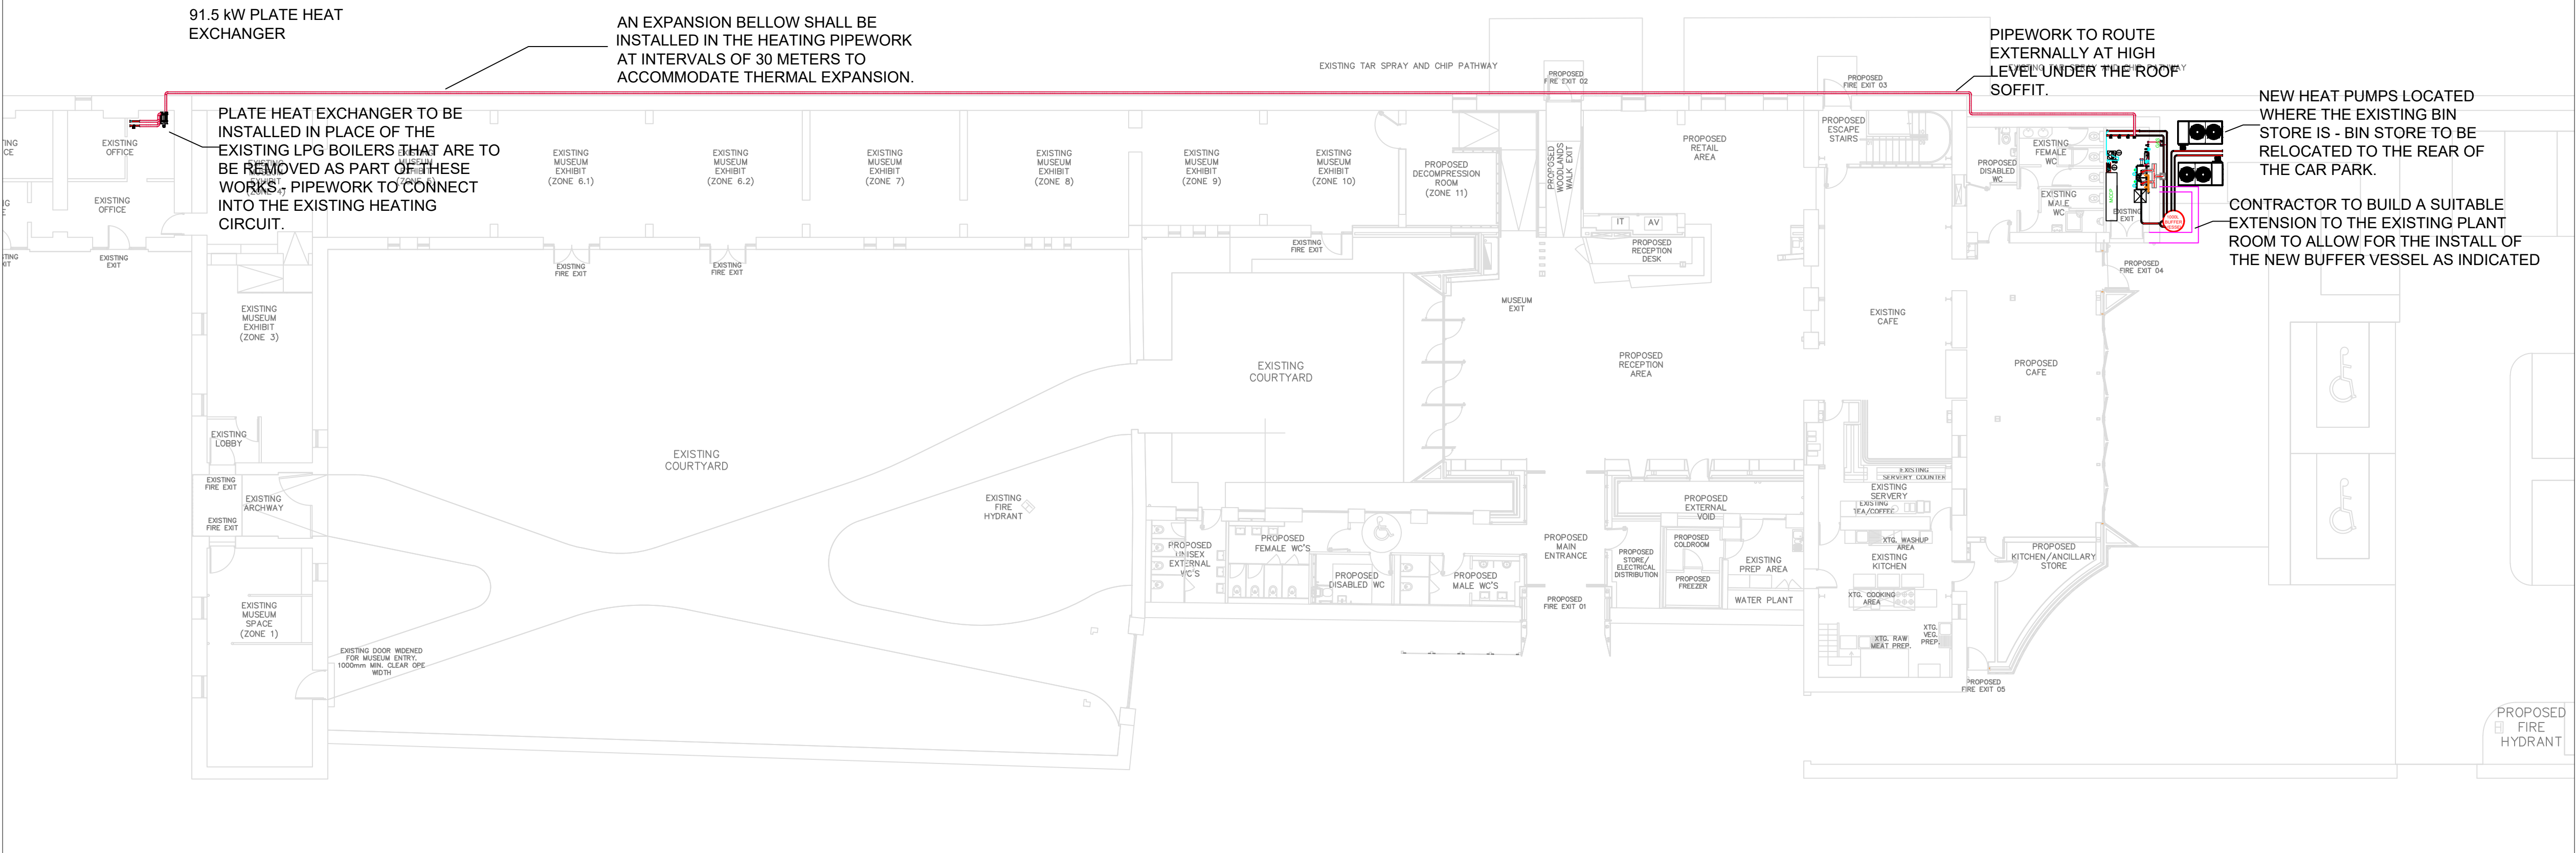

PROPOSED PLANT ROOM LAYOUT
SCALE -1:50 @ A1

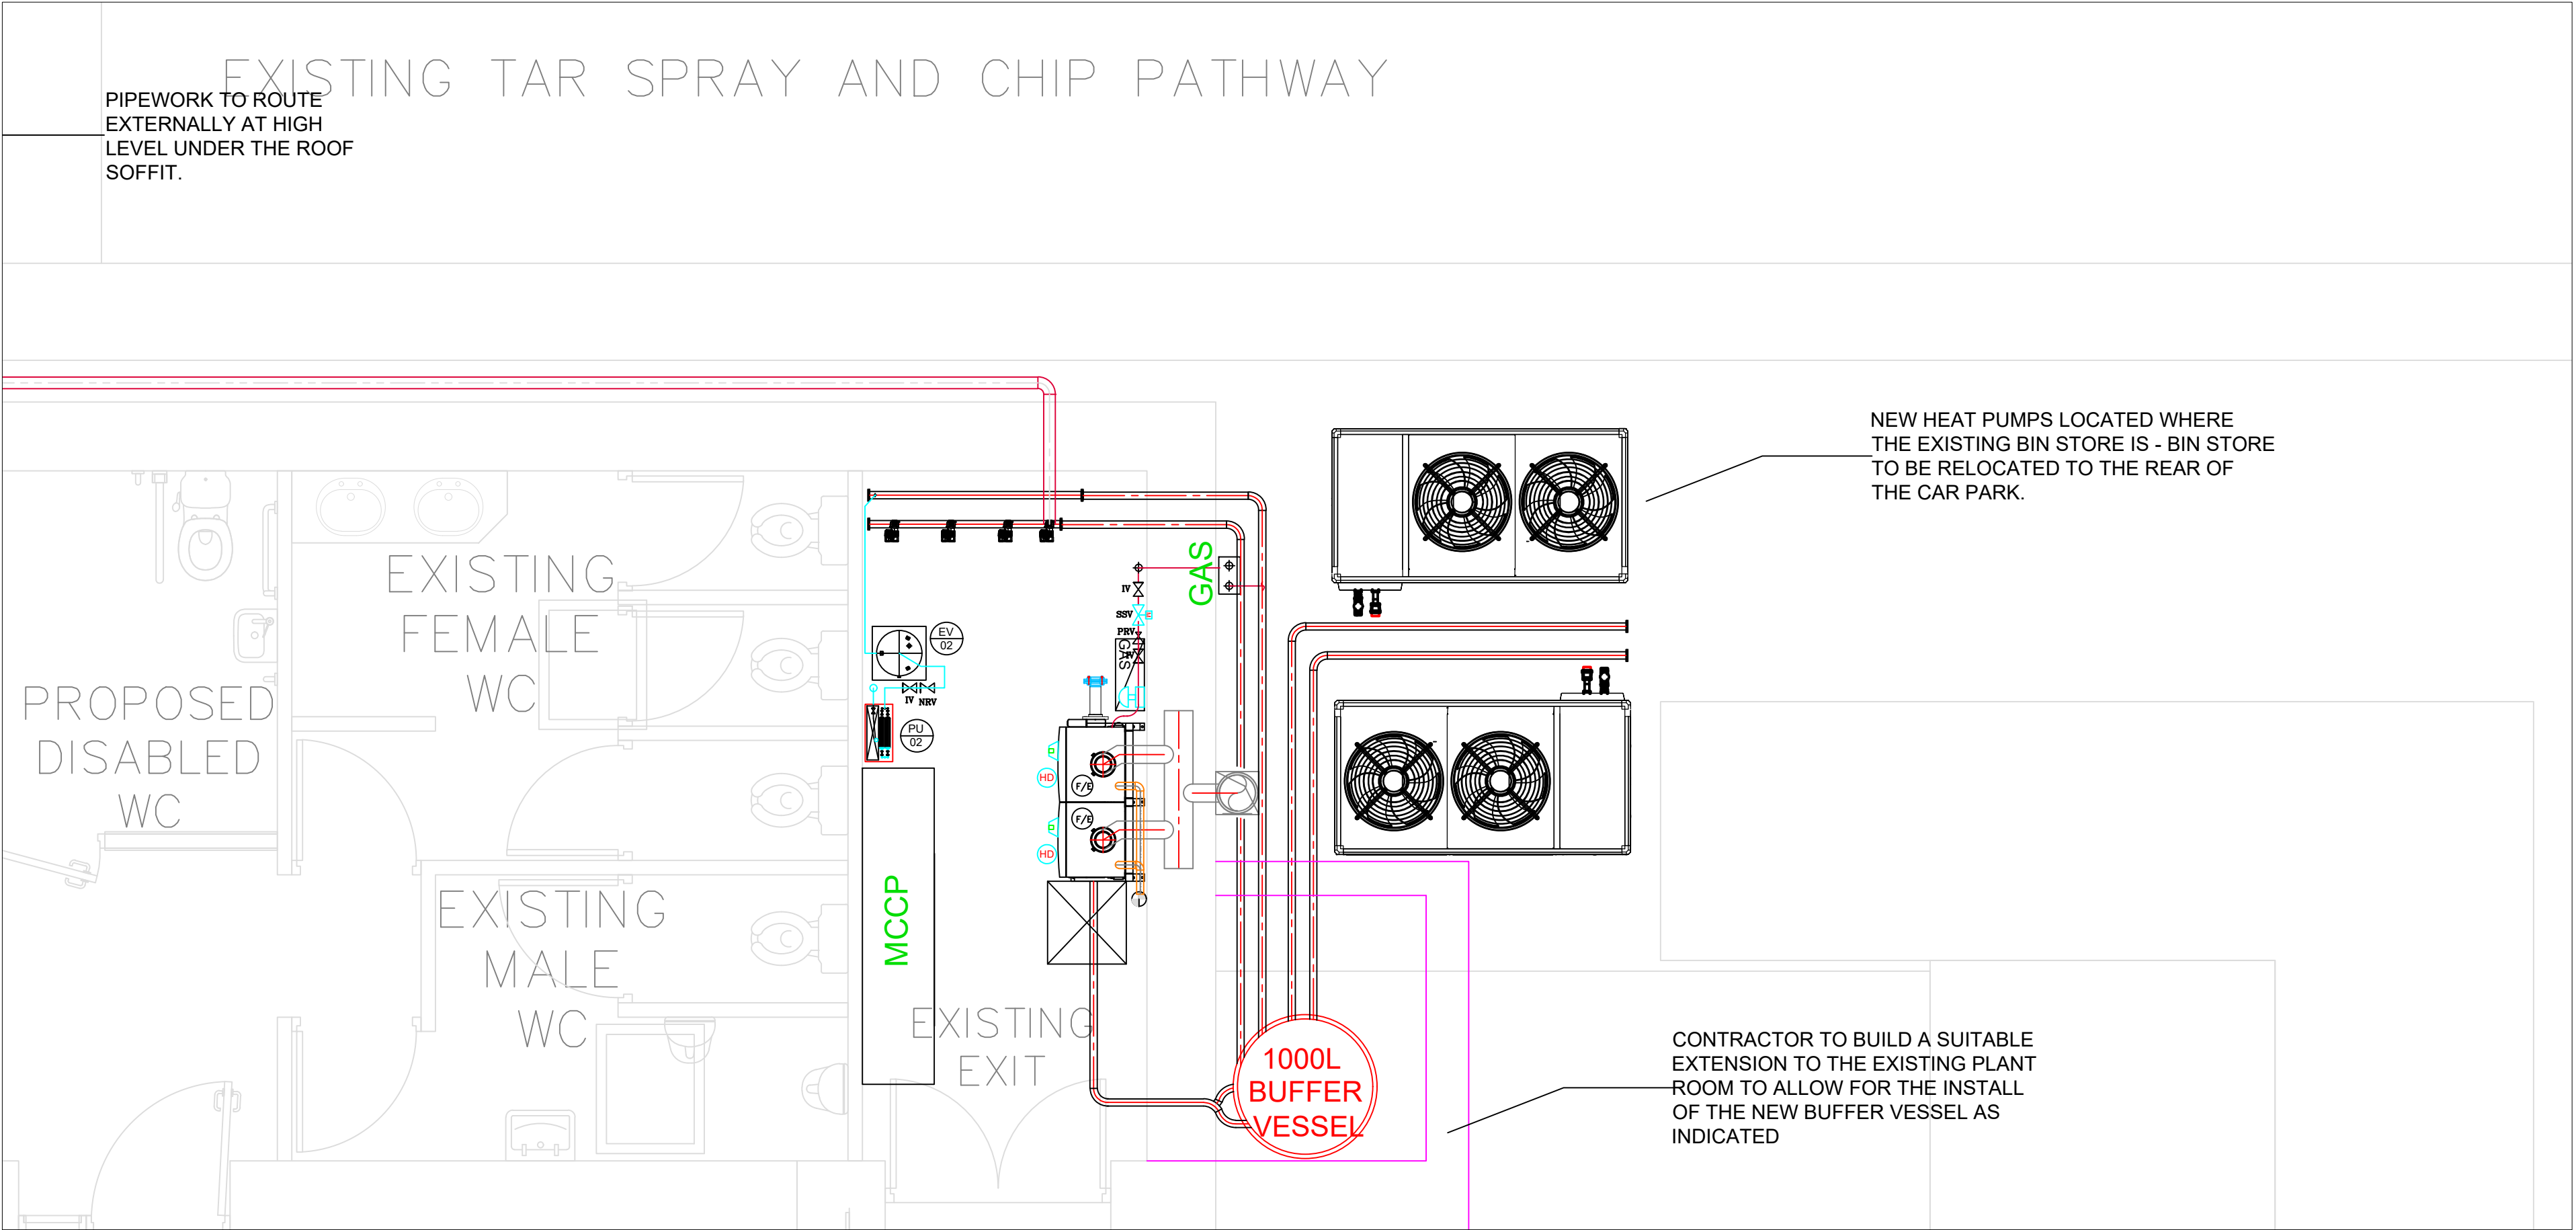

Original Drawing Size A1

Notes

Rev	Date	Drawn	Description	Ch'k'd
-----	------	-------	-------------	--------



seSYSTEMS
YOUR SUSTAINABILITY PARTNER

Client:
**IRISH HERITAGE TRUST
STROKESTOWN PARK, FAMINE MUSEUM
CO. ROSCOMMON**

Project :
**STROKESTOWN PARK - HEATING CENTRE
PLANT ROOM LAYOUT DRAWING**

Drawing Title :
PROPOSED PLANT ROOM LAYOUT

Designed: CG Drawn: CG Date: JAN 2026

Eng Chk: MS Dwg. Chk: JO'C Scale: 1:50 @ A1

Project. No: 601.2.1

Drawing No: PL-M56-001 Status: Preliminary Rev: 1