



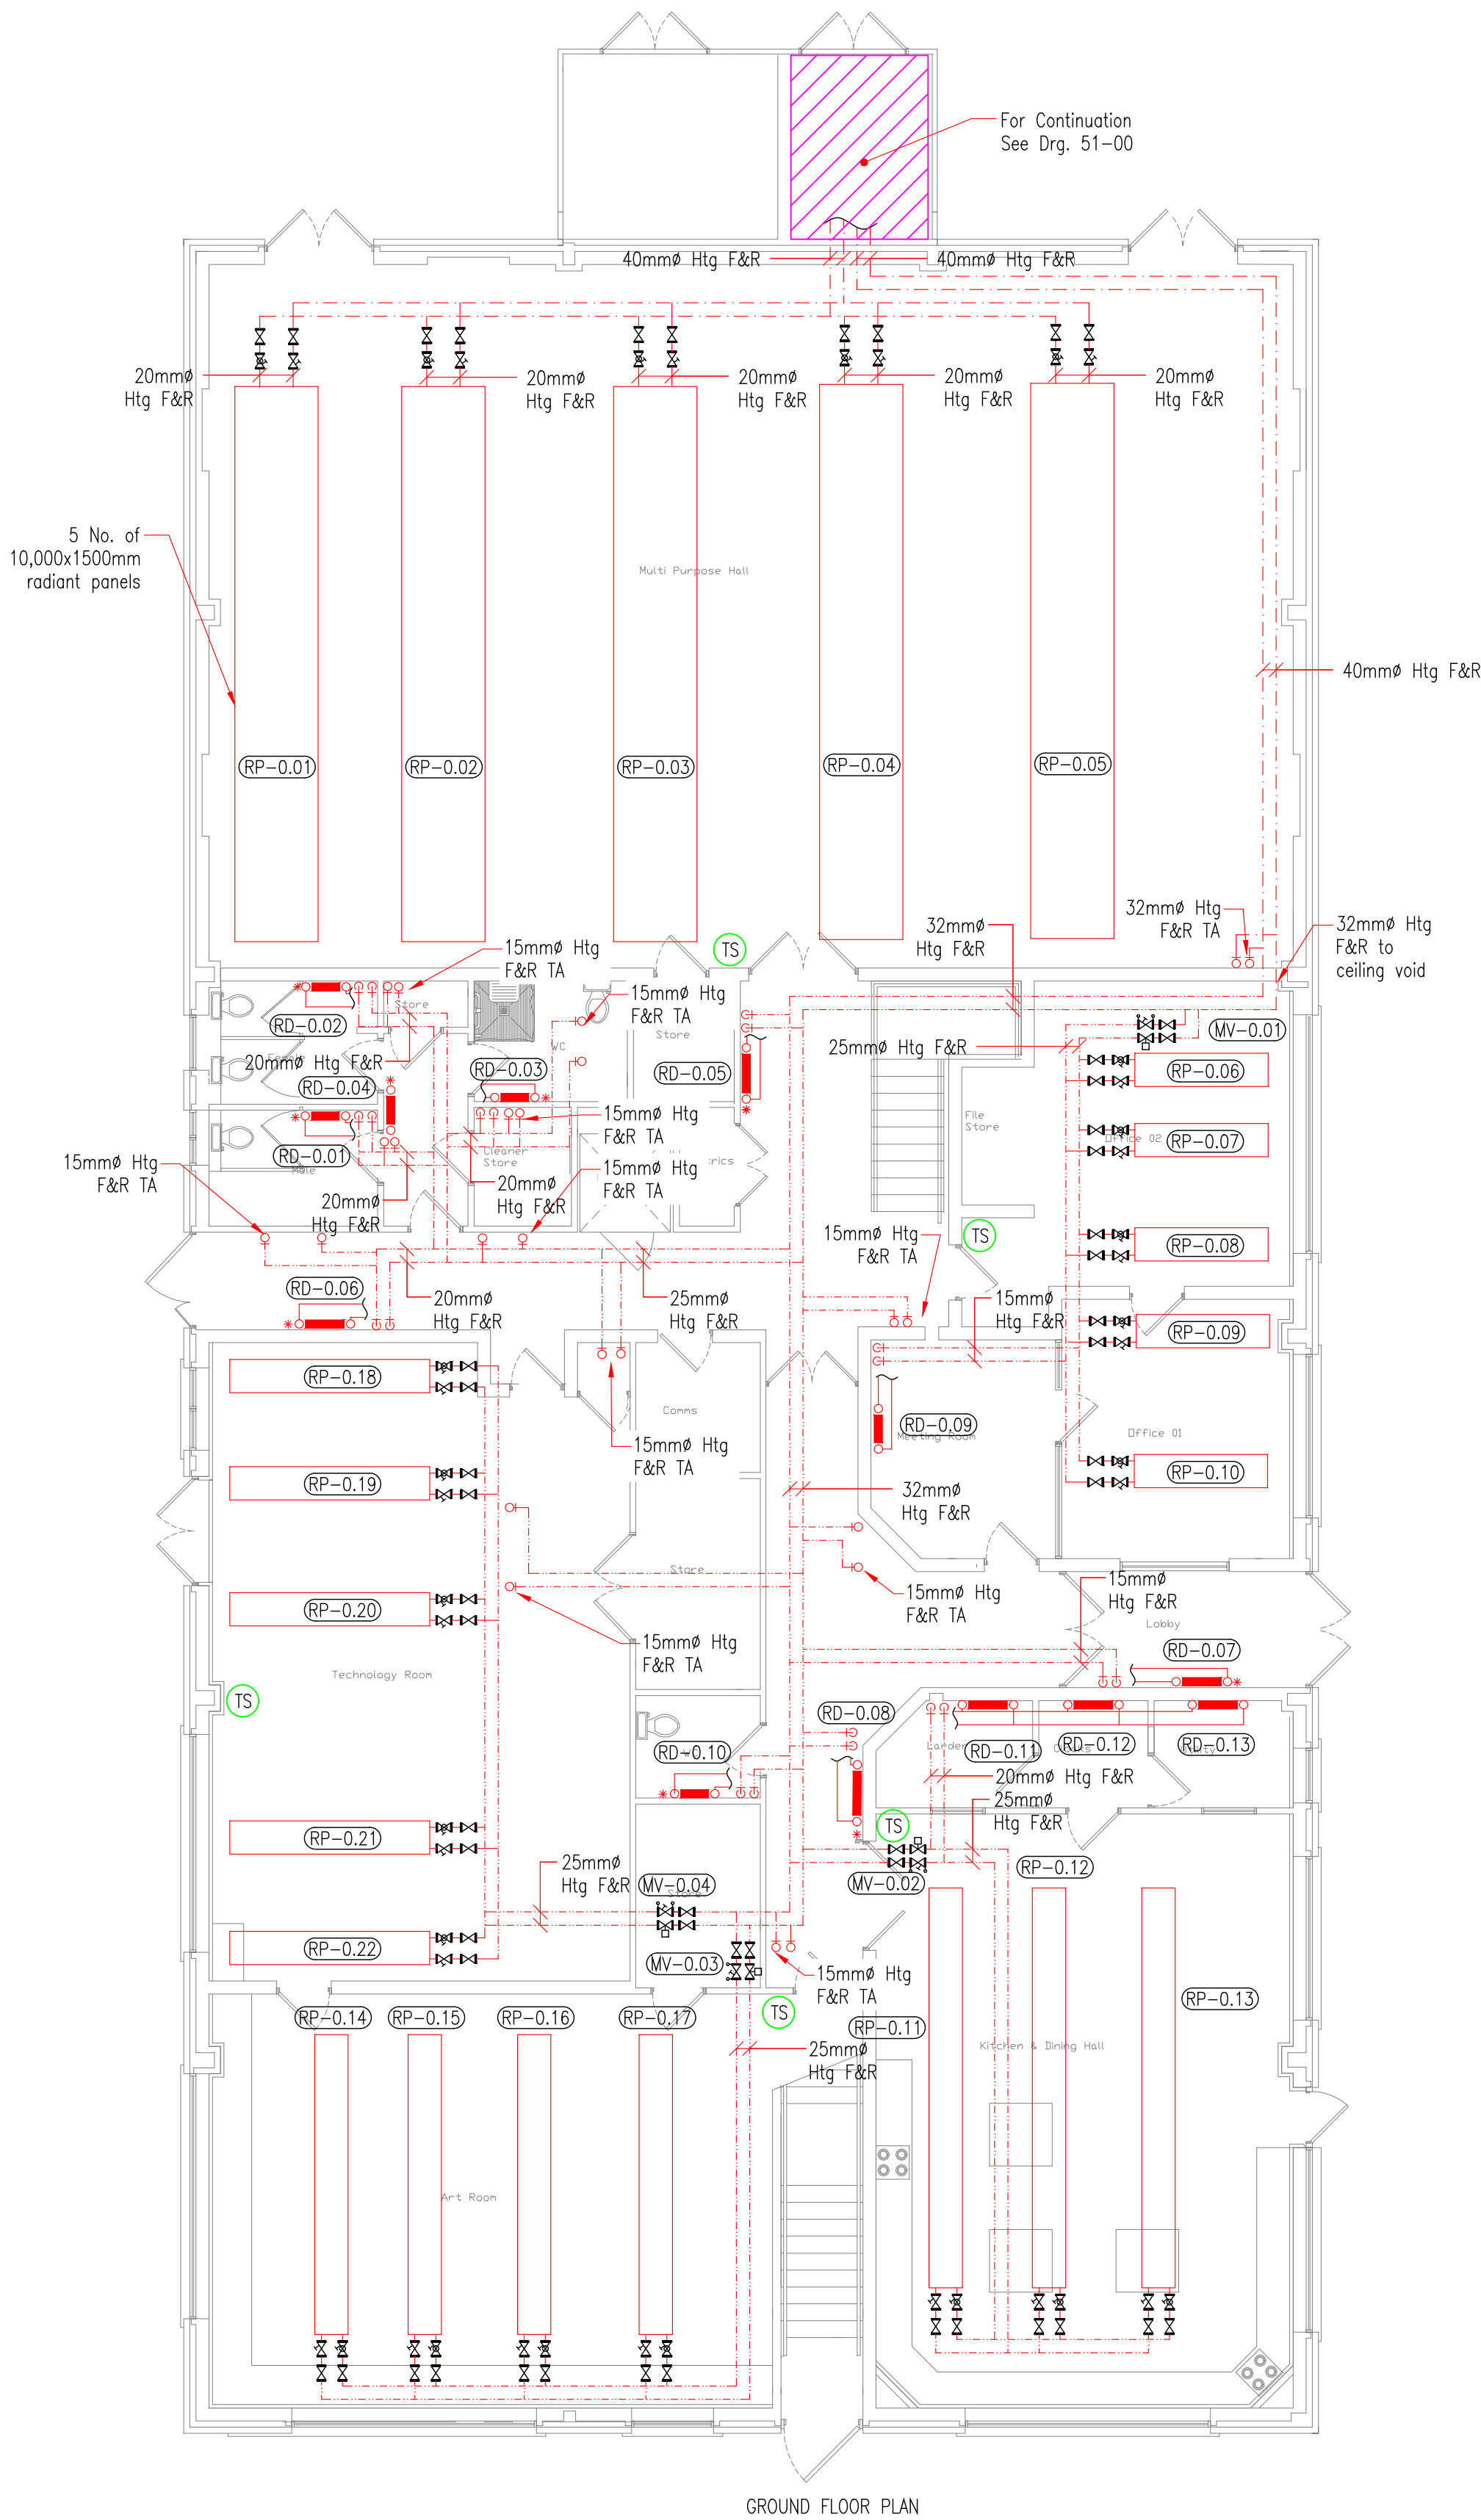

Ground Floor Plan

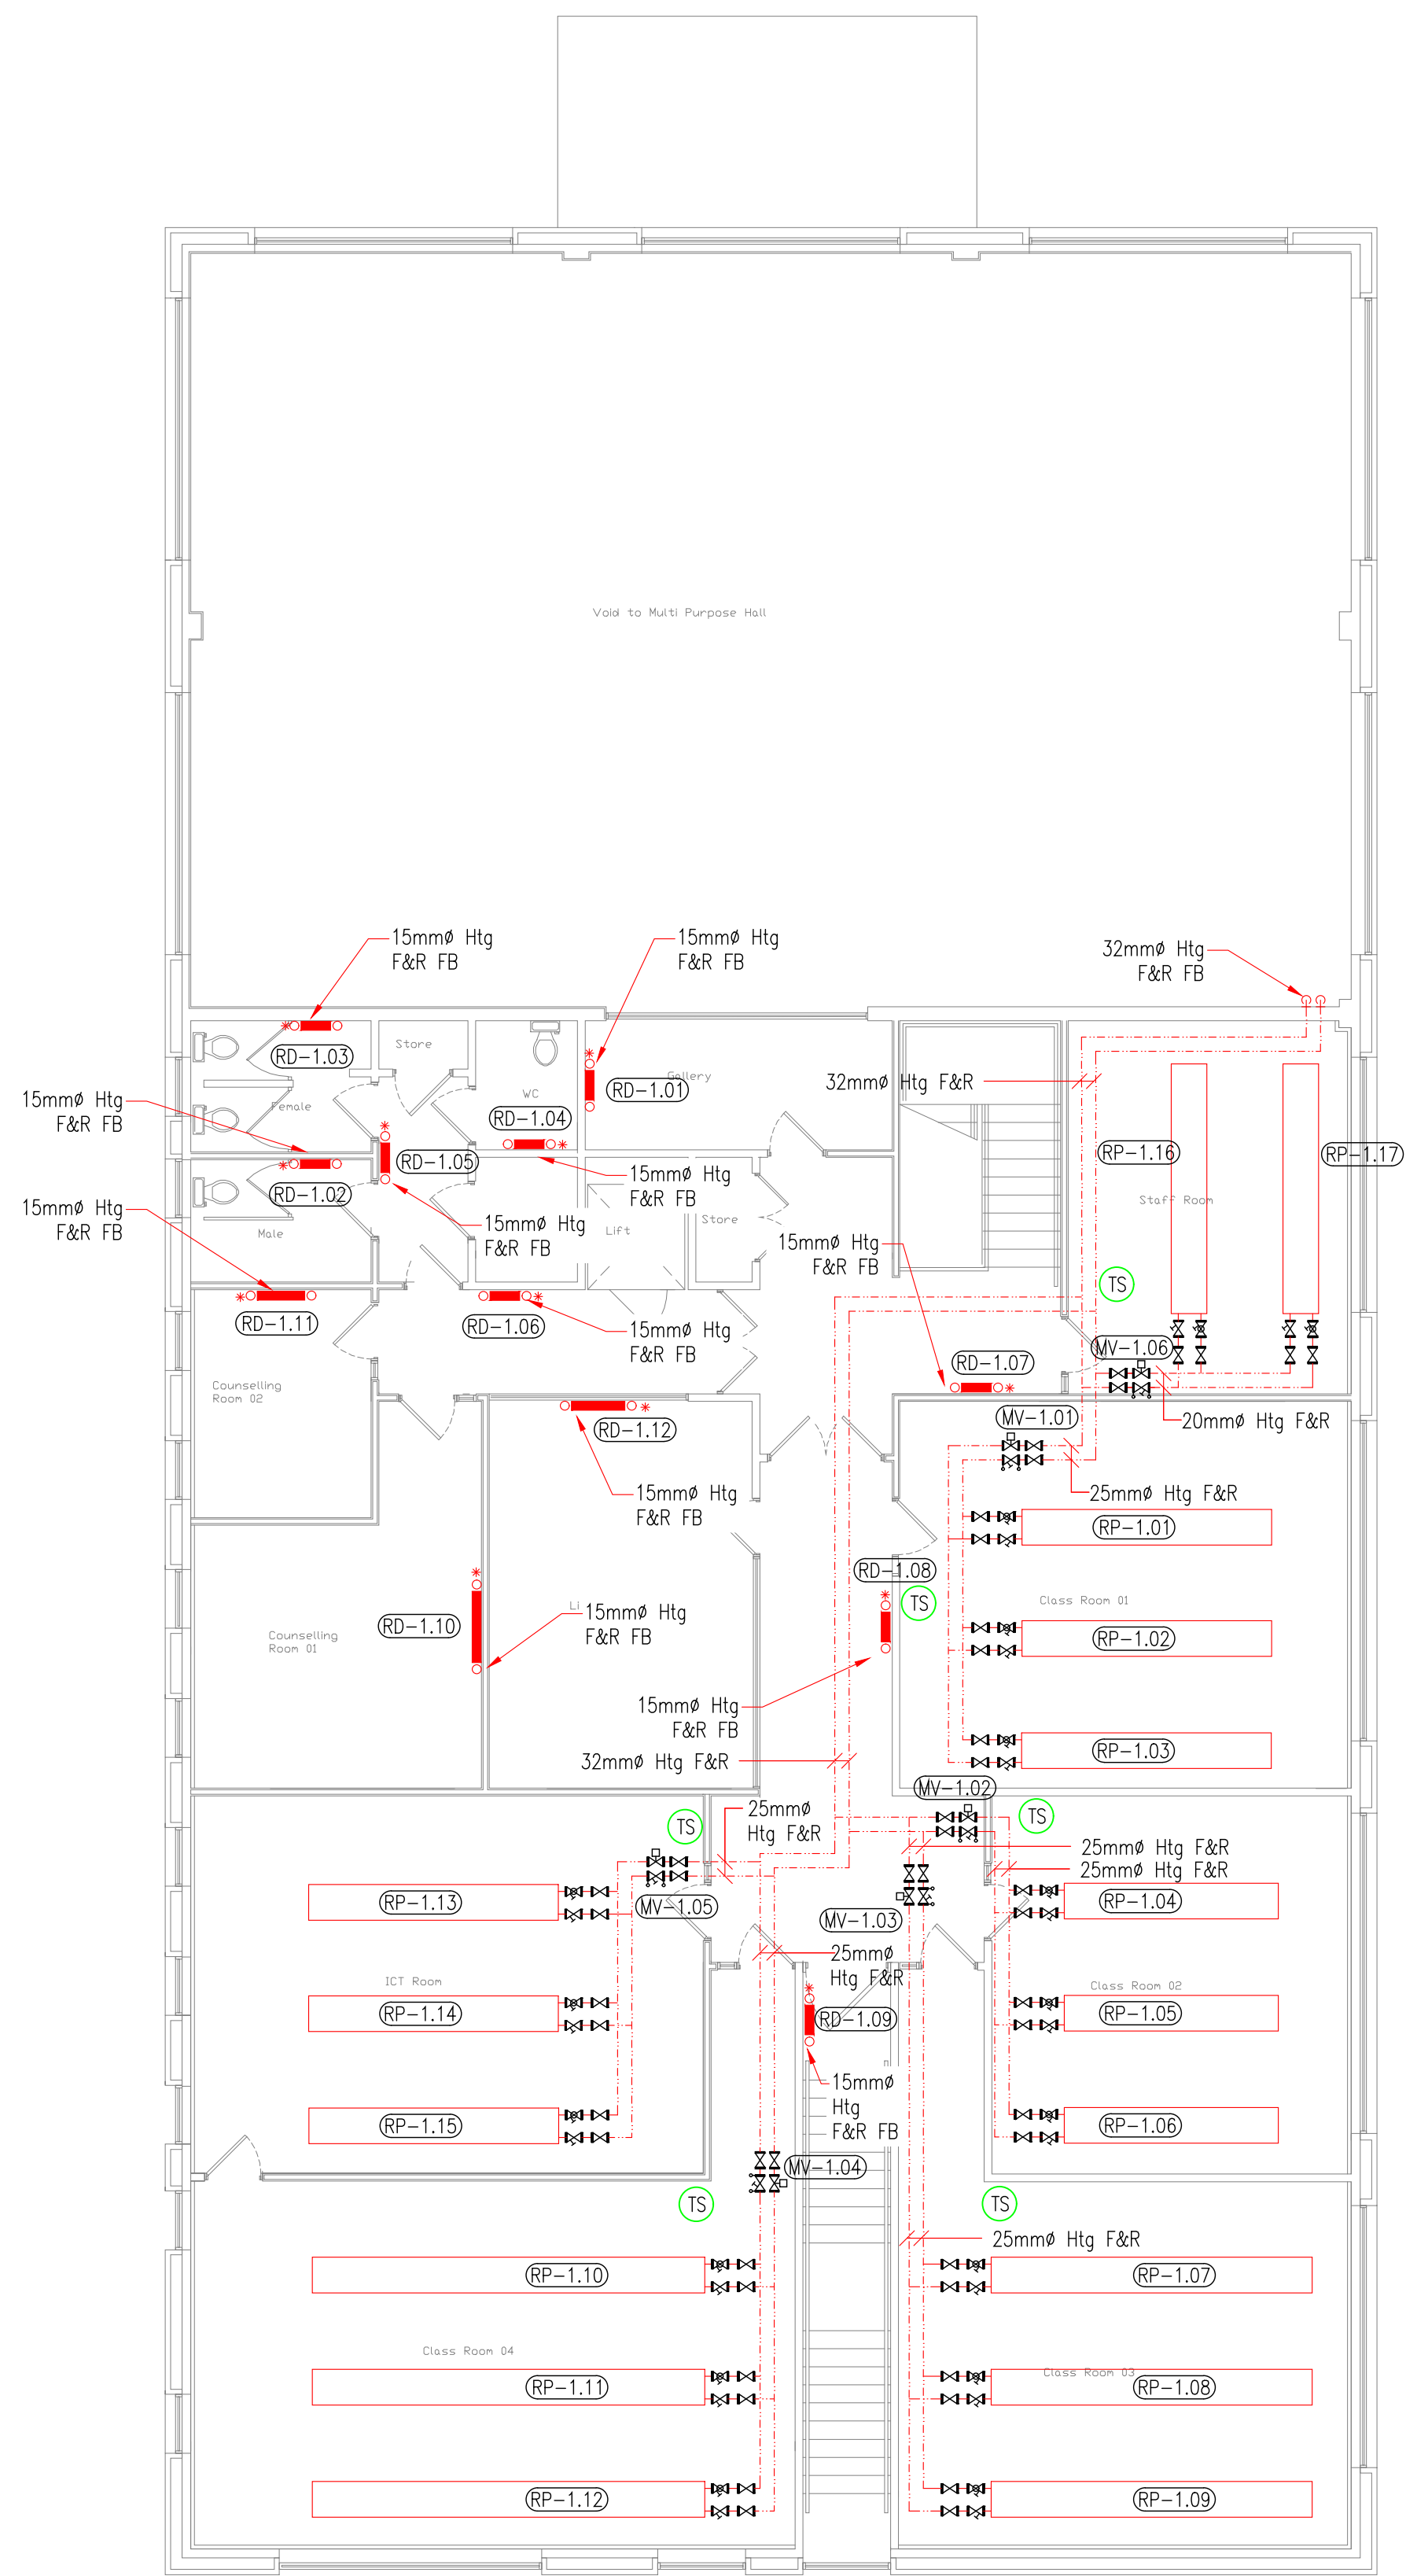

First Floor Plan

Notes:
This drawing is used for indicative purposes only. It should not be used for scaling under any circumstances. The contractor shall agree the exact locations of all equipment with the relevant parties – Client, Architect or Builder.

The contractor shall co-ordinate his services with all other trades prior to commencement of any works on site.

Discrepancies or contradictions in the information indicated on the drawings and contained in the specification should be brought to the Engineers attention and agreement reached before any works commence.

Abbreviations:

FA _____ From Above
TA _____ To Above
FB _____ From Below
TB _____ To Below
DTLL _____ Drop to Low Level
RTHL _____ Rise to High Level
RTFL _____ Rise to Floor Level
AFFL _____ Above Finished Floor Level
CV _____ Ceiling Void
CM _____ Ceiling Mounted
HL _____ High Level
LL _____ Low Level

Heating Services Legend:

..... Pipework ran in ceiling void
- - - - - Pipework ran at high level
_____ Pipework ran at low level
- - - - - Pipework ran underfloor or below ground
- - - - - Pipework in ceiling below or between joists

Isolating valve
Motorised valve
Commissioning Set
VSRK Valve – Return
VSRK Valve – Flow
Single head pump
Room Thermostat
Underfloor Heating Manifold
Radiator with TRV
Radiator without TRV
BMS control panel

T	04/06/26	TENDER ISSUE	JV	ML
REV	DATE	DESCRIPTION	DRAWN	CHECKED

DO NOT SCALE
This drawing is representative only.
To be read in conjunction with Architects drawings.

CONSULTING ENGINEER:

Bernard Smith
Consulting Engineers

Bernard Smith Consulting Engineers
Bracktown Business Park | Clonsilla | Dublin 15
t: 01-801 4127 | w: www.bernardsmith.ie | e: info@bernardsmith.ie

PROJECT:

**YOUTHREACH
CASTLEBLAYNEY
CO. MONAGHAN**

TITLE:

**LPHW
SERVICES LAYOUT
GROUND & FIRST FLOOR**

SCALE: 1:100@A1/1:200@A3	DRAWN BY: JV	JOB NO.: 26-022	DWG NO.: 56-00	REV.: T
DATE: 19/05/2026	CHECKED: ML			

TENDER