
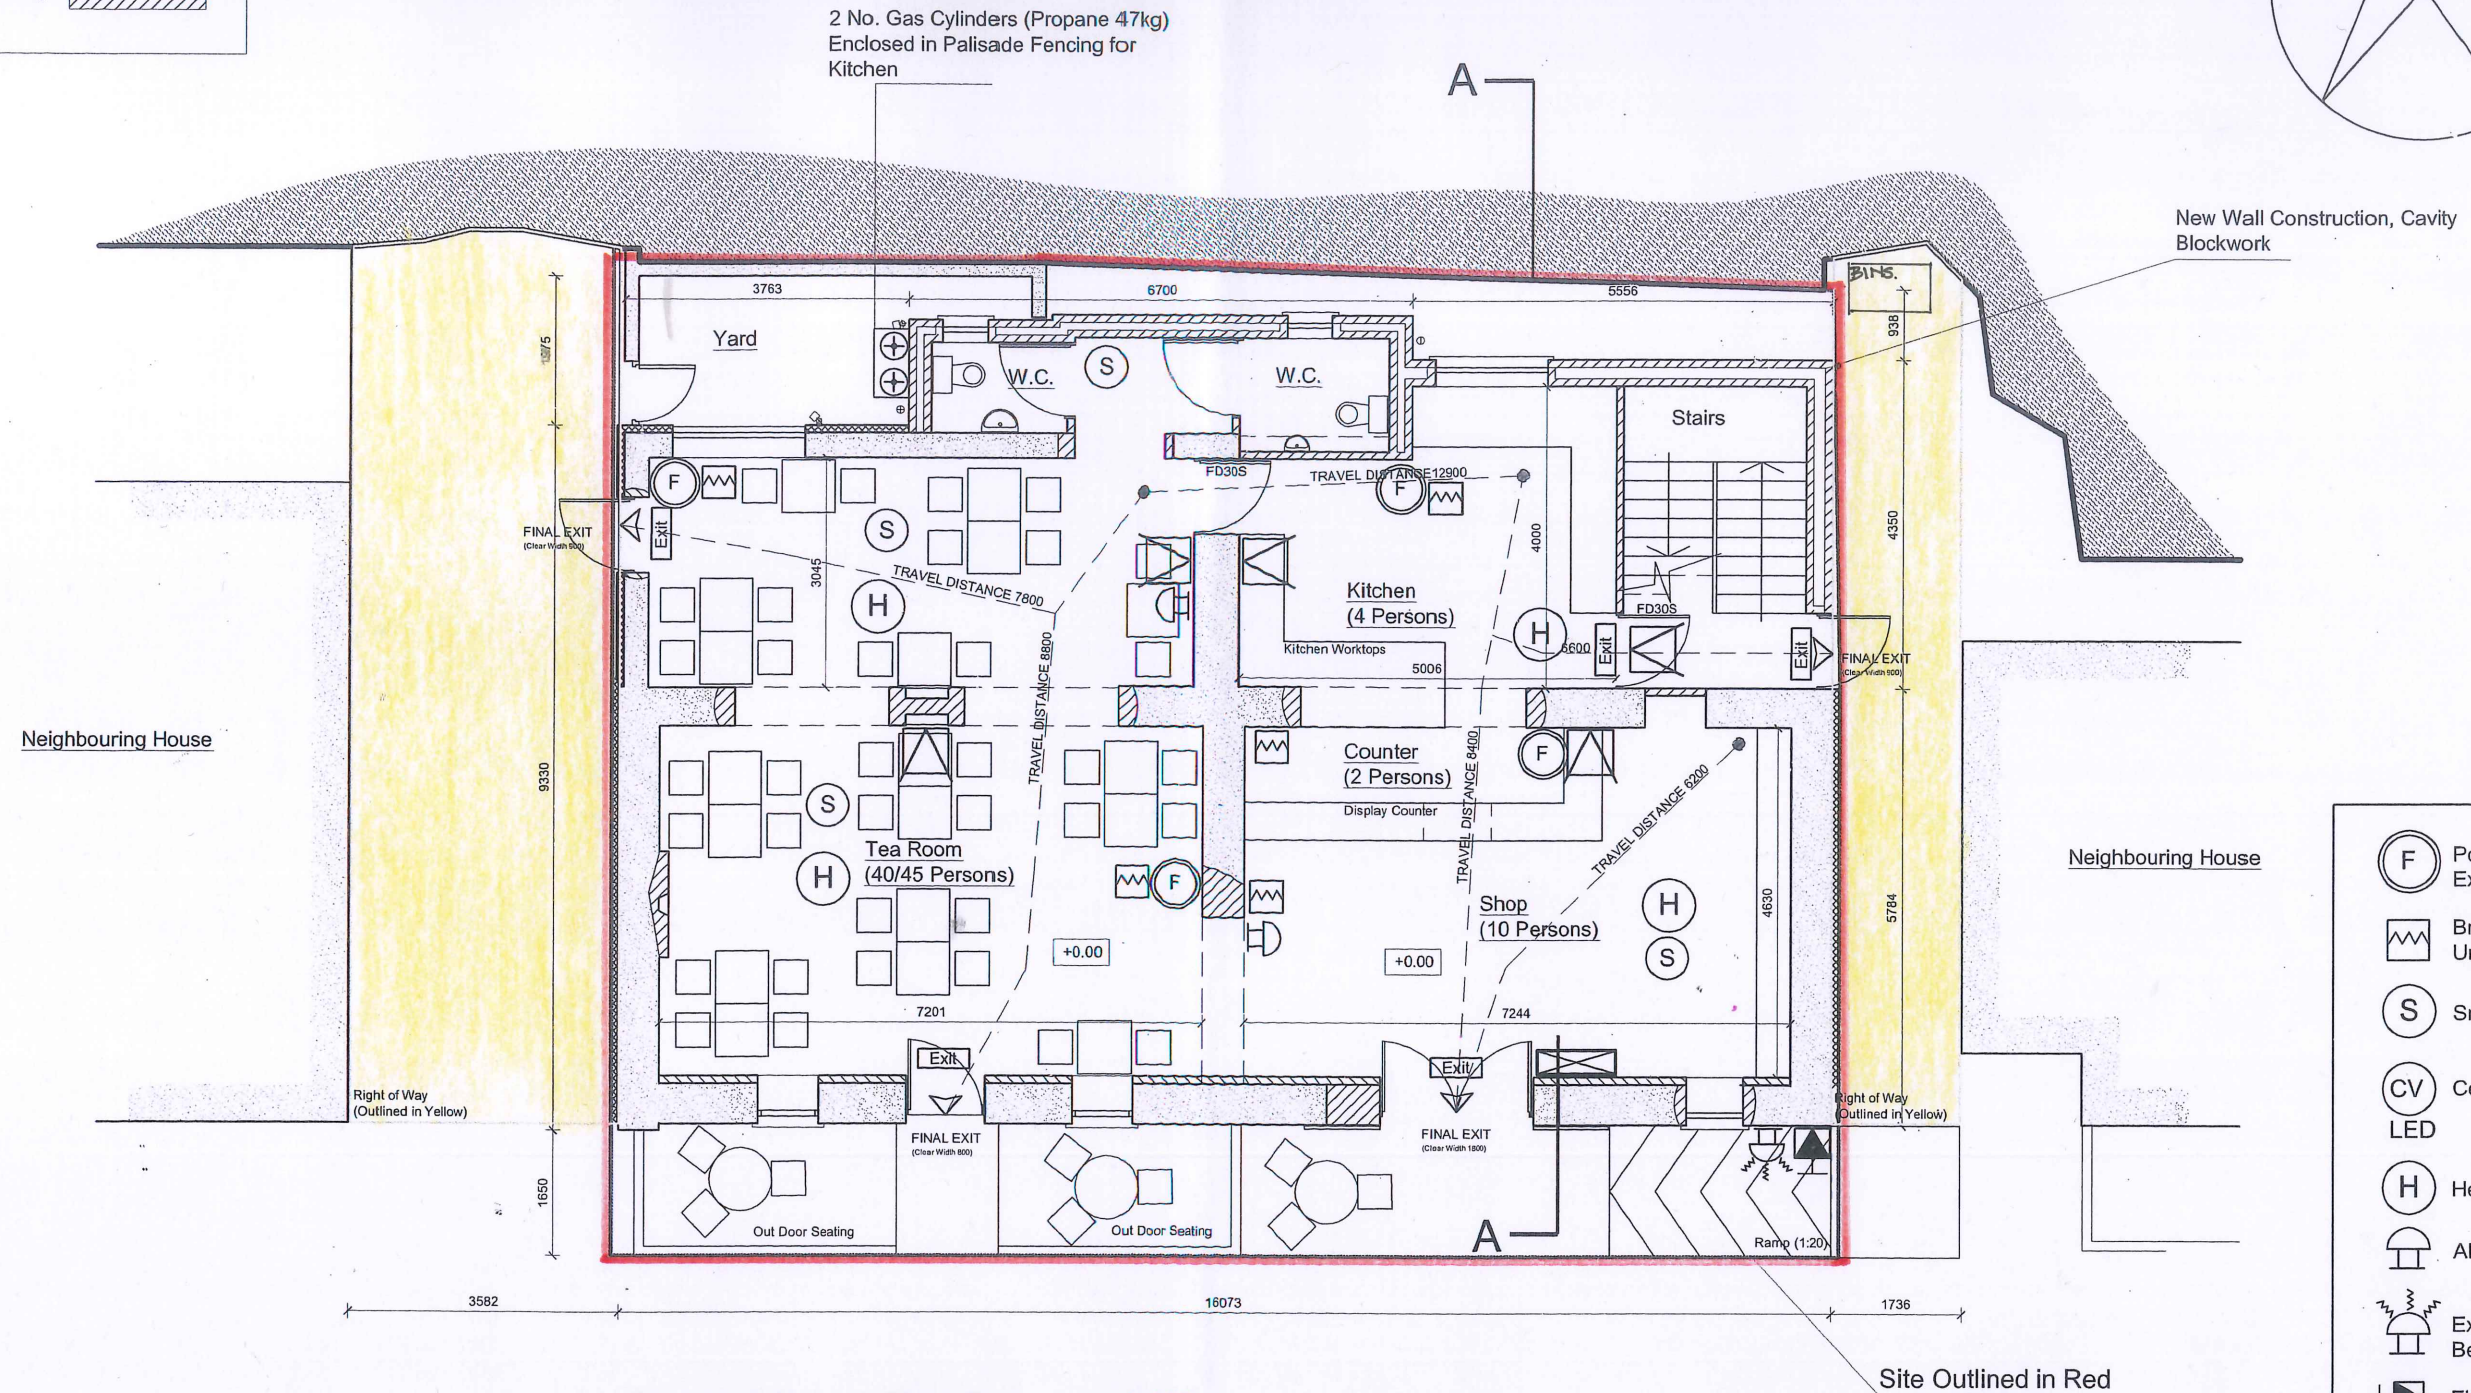
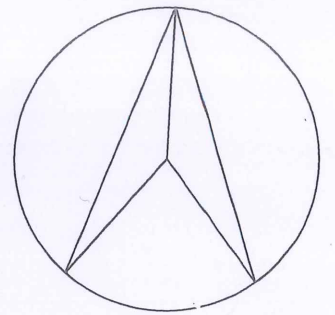


Existing Building
Proposed Masonry

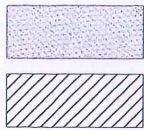

Proposed Ground Floor Plan scale 1:100

Fire Detection and Alarm System, Type L1

- (F) Portable Fire Extinguishers
- Break Glass Unit
- (S) Smoke Detector
- (CV) Ceiling Void LED
- (H) Heat Detector
- Alarm Bell
- External Sounder Beason
- Fireman's Switch
- Fuse Board/Circuit Breaker
- Fire Control Panel
- Emergency Escape Lighting

Client
GCDC
Glenmore Community
Development Comm.

Site
Cappagh,
Glenmore,
Co. Kilkenny.

Job
Proposed Tea Room and
Local Shop Development

Title
Proposed Ground Floor
Plan

Prepared by :
Michael Tobin MRIAI,
Haggard, Glenmore,
Co. Kilkenny.
0035387-2195257

Drg. No.23-9- 005 Rev.-
Scale 1:100
Drawn by: M. T.

Fire Safety Cert Application