


Existing Building

Proposed

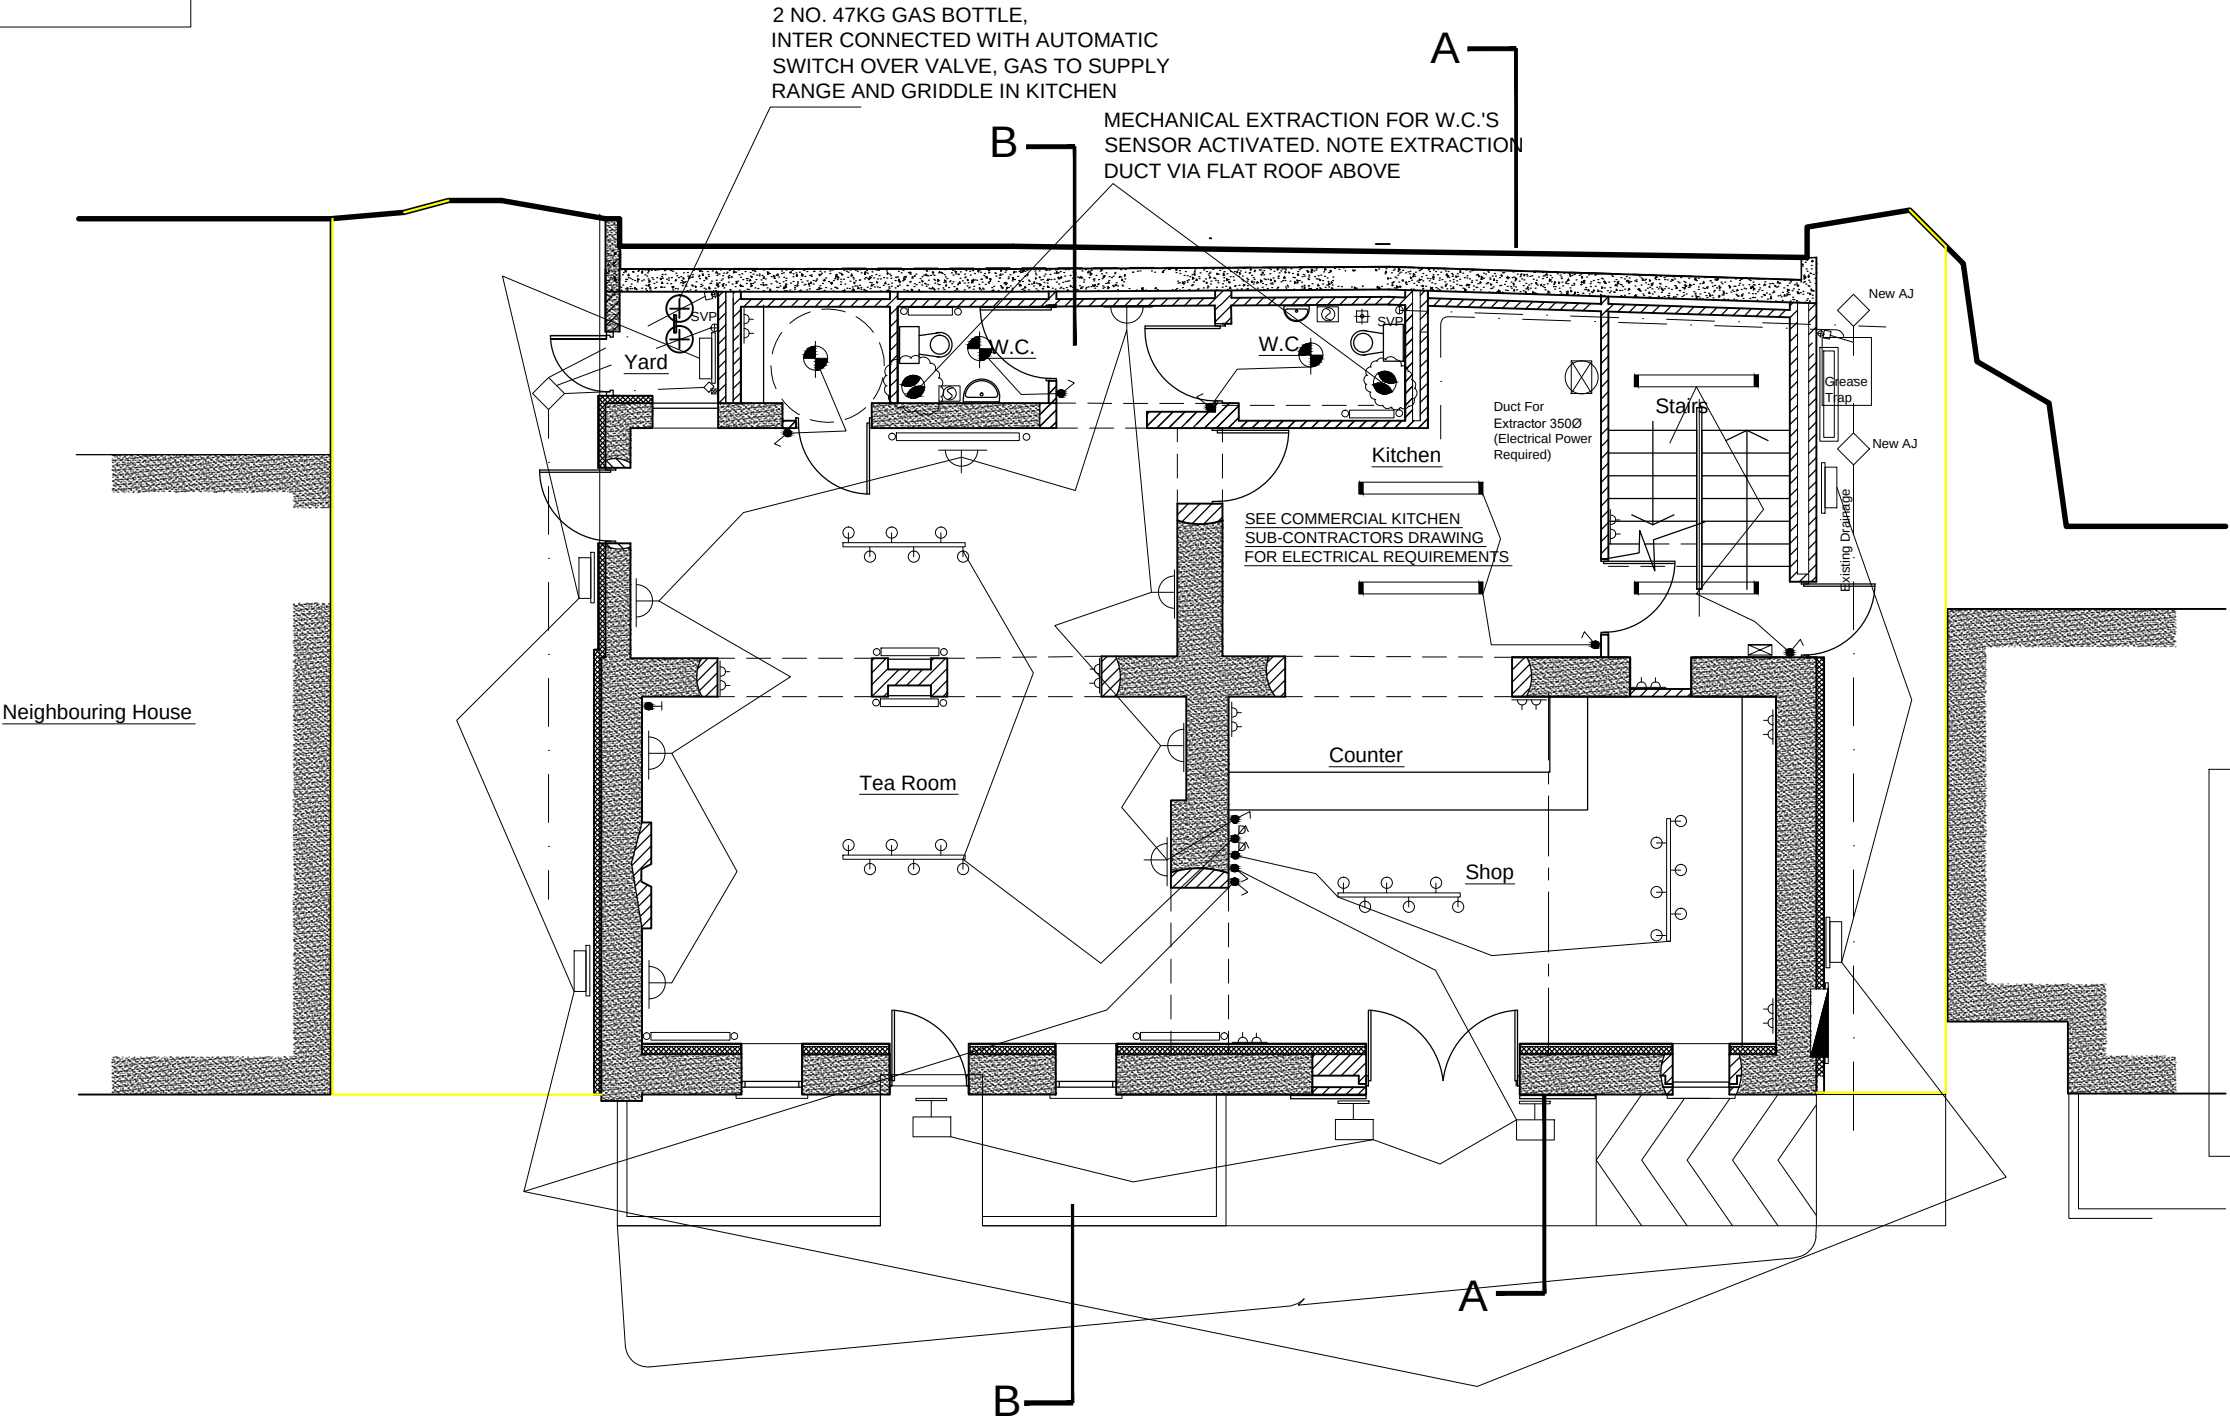

Electrical Key

Light Switch

Dimmable Light Switch

Double Switched Recessed Socket

Picture Lights
Lucande Dimitrij LED Picture Light
Curved Brass, Metal 540mm
Item No. 9626107

External LED Lights

Dual Speed Extraction Fan(Vent Axa)

Florescent Double Lights

Surface Mounted Steam Proof Light

New Fuse Board.

Alarm Main Entry Box

New Smart Retailer Meter

Tracked Lighting
Lindby single-circuit track lighting
system Linaro, GU10, White, 5 no.
bulb

Led External Signage Lighting

Electrical Hand Dryer

Disability Alarm Pull Cord

Space Heating

(See Attached Daikin Air to Water Heat Pump Report)

Daikin Air to Water Heat Pump

Water Buffer Storage Tank for Heat Pump

Radiator

Proposed Ground Floor Plan scale 1:100

FIRE SAFETY ELECTRICAL REQUIREMENTS
SEE FIRE SAFETY REPORT AND DRAWINGS

MICHAEL TOBIN

ARCHITECTURE

REGISTERED ARCHITECT

RAI

Client

GCDC
Glenmore Community
Development Comm.

Site

Cappagh,
Glenmore,
Co. Kilkenny.

Job

Proposed Tea Room and
Local Shop Development

Title

Proposed Ground Floor
Mech & Elec. Plan

Prepared by :

Michael Tobin MRAI,
Haggard, Glenmore,
Co. Kilkenny.
0035387-2195257

Drg. No.23-9- 005 Rev.-

Scale 1:100

Drawn by: M. T.

Tendering Drawings