


GROUND FLOOR

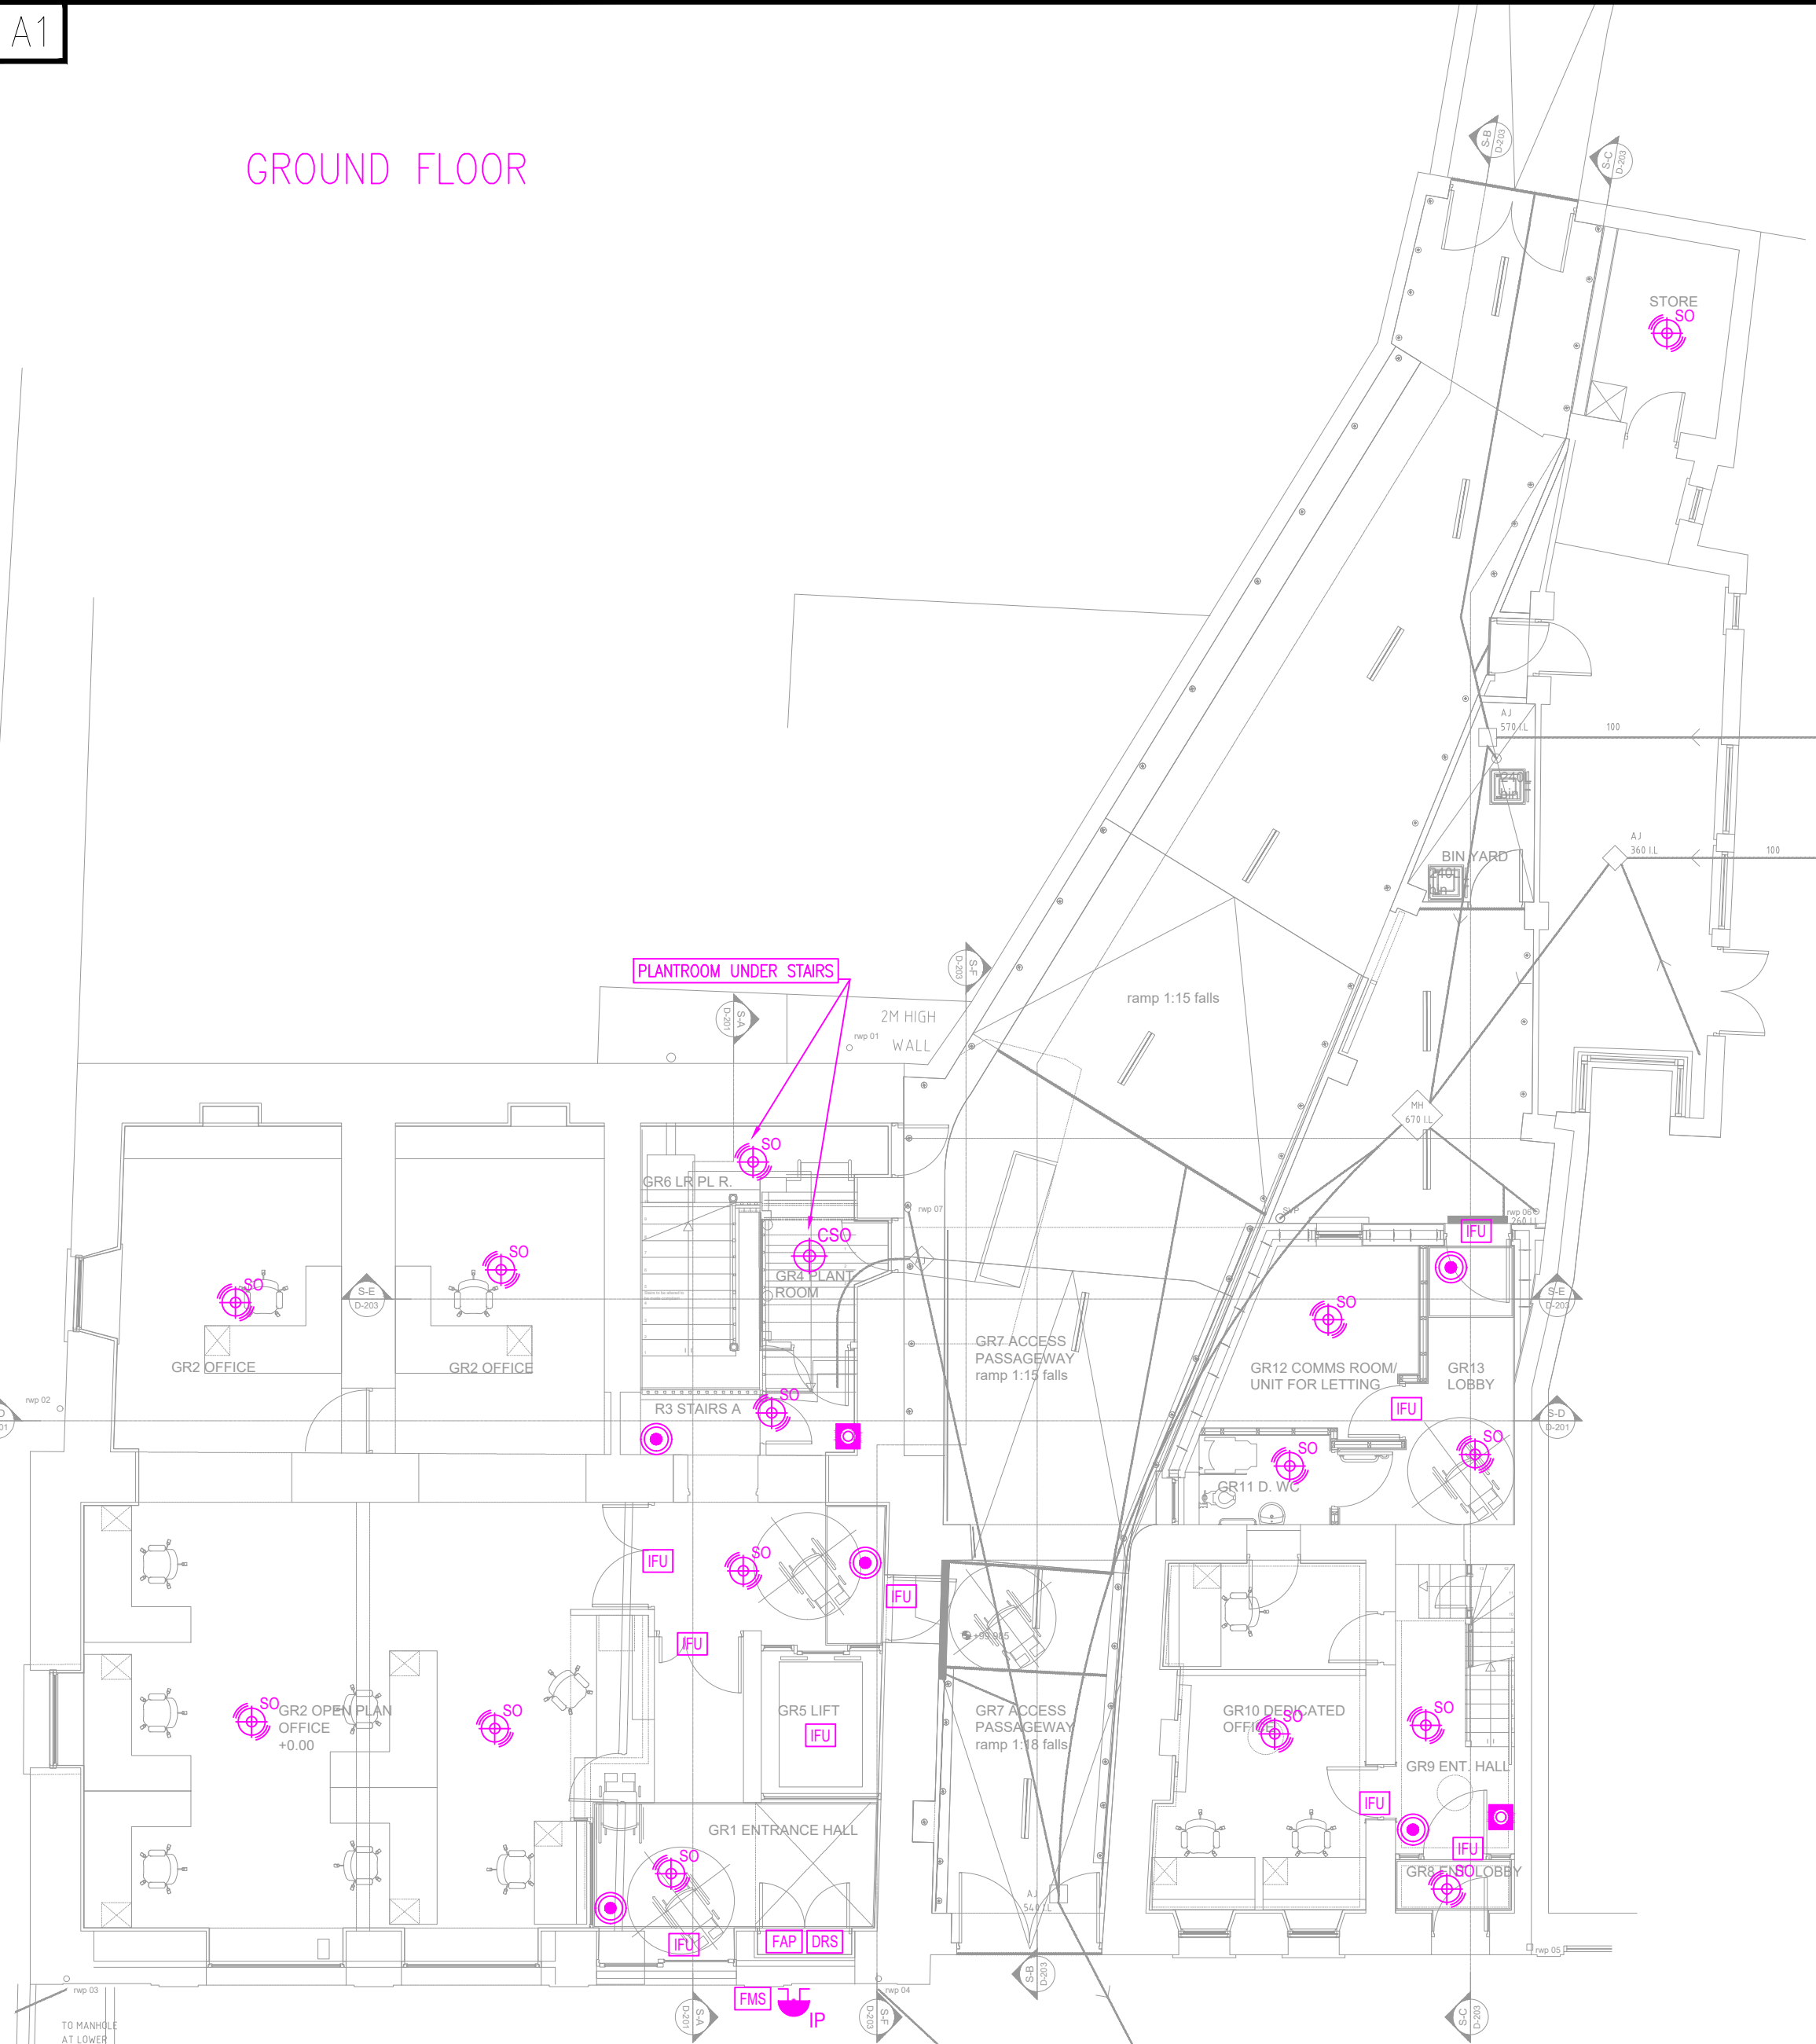

FIRST FLOOR



- LEGEND
- SMOKE DETECTOR WITH SOUNDER & STROBE WITH PROGRAMMABLE SOUND OUTPUT LEVEL
 - HEAT DETECTOR WITH SOUNDER & STROBE WITH PROGRAMMABLE SOUND OUTPUT LEVEL
 - ASPIRATING SMOKE DETECTOR C/W PIPE AND TEST POINT
 - SMOKE DETECTOR IN CEILING VOID WITH REMOTE INDICATOR
 - SMOKE DETECTOR
 - FIRE ALARM INTERFACE UNIT
 - FIRE ALARM PANEL
 - FIRE ALARM REPEATER PANEL
 - DISABLED REFUGE CALL POINT
 - DISABLED REFUGE STATION
 - FIRE ALARM SOUNDER
 - EXTERNAL FIRE ALARM SOUNDER
 - SMOKE VENT ACTIVATION BCU
 - MANUAL CALL POINT
 - FIREMAN'S SWITCH
 - ASPIRATING SMOKE DETECTOR
 - ELECTRO-MAGNETIC DOOR HOLD OPEN DEVICE INCL RELEASE BUTTON

- NOTES:
- DRAWING TO BE READ IN CONJUNCTION WITH ALL OTHER DRAWINGS AND DOCUMENTATION.
 - THE CONTRACTOR SHALL INSURE ALL SERVICES CO-ORDINATED.
 - ALL EQUIPMENT REQUIRED TO PROVIDE A COMPLETE AND WORKING FIRE ALARM SYSTEM AS INDICATED ON THE DRAWINGS IS TO BE SUPPLIED, INSTALLED AND COMMISSIONED UNDER THIS CONTRACT.
 - BREAKGLASS UNITS SHALL BE INSTALLED AT 900-1200mm A.F.F.L. AND SHALL BE LOCATED IN EASILY ACCESSIBLE, WELL ILLUMINATED AND CONSPICUOUS POSITIONS FREE FROM OBSTRUCTIONS.
 - ALL AUDIBLE WARNING DEVICES SHOULD HAVE A SIMILAR SOUND AND BE DISTINCT FROM ANY OTHER AUDIBLE ALARMS.

- NOTES:
- GENERAL NOTES:
- THIS DRAWING TO BE READ IN CONJUNCTION WITH ALL RELEVANT ARCHITECTS, C&S ENGINEERS DRAWINGS & SPECIFICATIONS.
 - ALL WORKS TO BE CARRIED OUT IN ACCORDANCE WITH THE RELEVANT BUILDING REGULATIONS.
 - DO NOT SCALE - WORK TO FIGURE DIMENSIONS ONLY.



Referenced drawings	
Dwg No.	Dwg Title

Issue register				
Rev.	Date	Description	Drawn	Checked

Client: TIPPERARY COUNTY COUNCIL

Job Description: CAHIR DIGITAL HUB

Status: TENDER

Drawing Title: FIRE ALARM SYSTEM LAYOUT

Project No: 21ME006 Drawing Ref: E-300 Rev: T2

Date: 13/09/21 Scale: 1:100 @ A1 (1:200@A3)

Drawn By: H.P. Checked By: N.B. Approved By: A.W.

Hayes Higgins Partnership

Gas House Lane, Kilkenny.

Gas House Lane, Kilkenny (056) 7764710 (056) 7723223 info@hhp.ie

The Gas House, 11 Gas Lane, SMOULLEN (01) 6612321 (01) 6612504 admin@hayeshiggins.ie

Scale: 1:100