

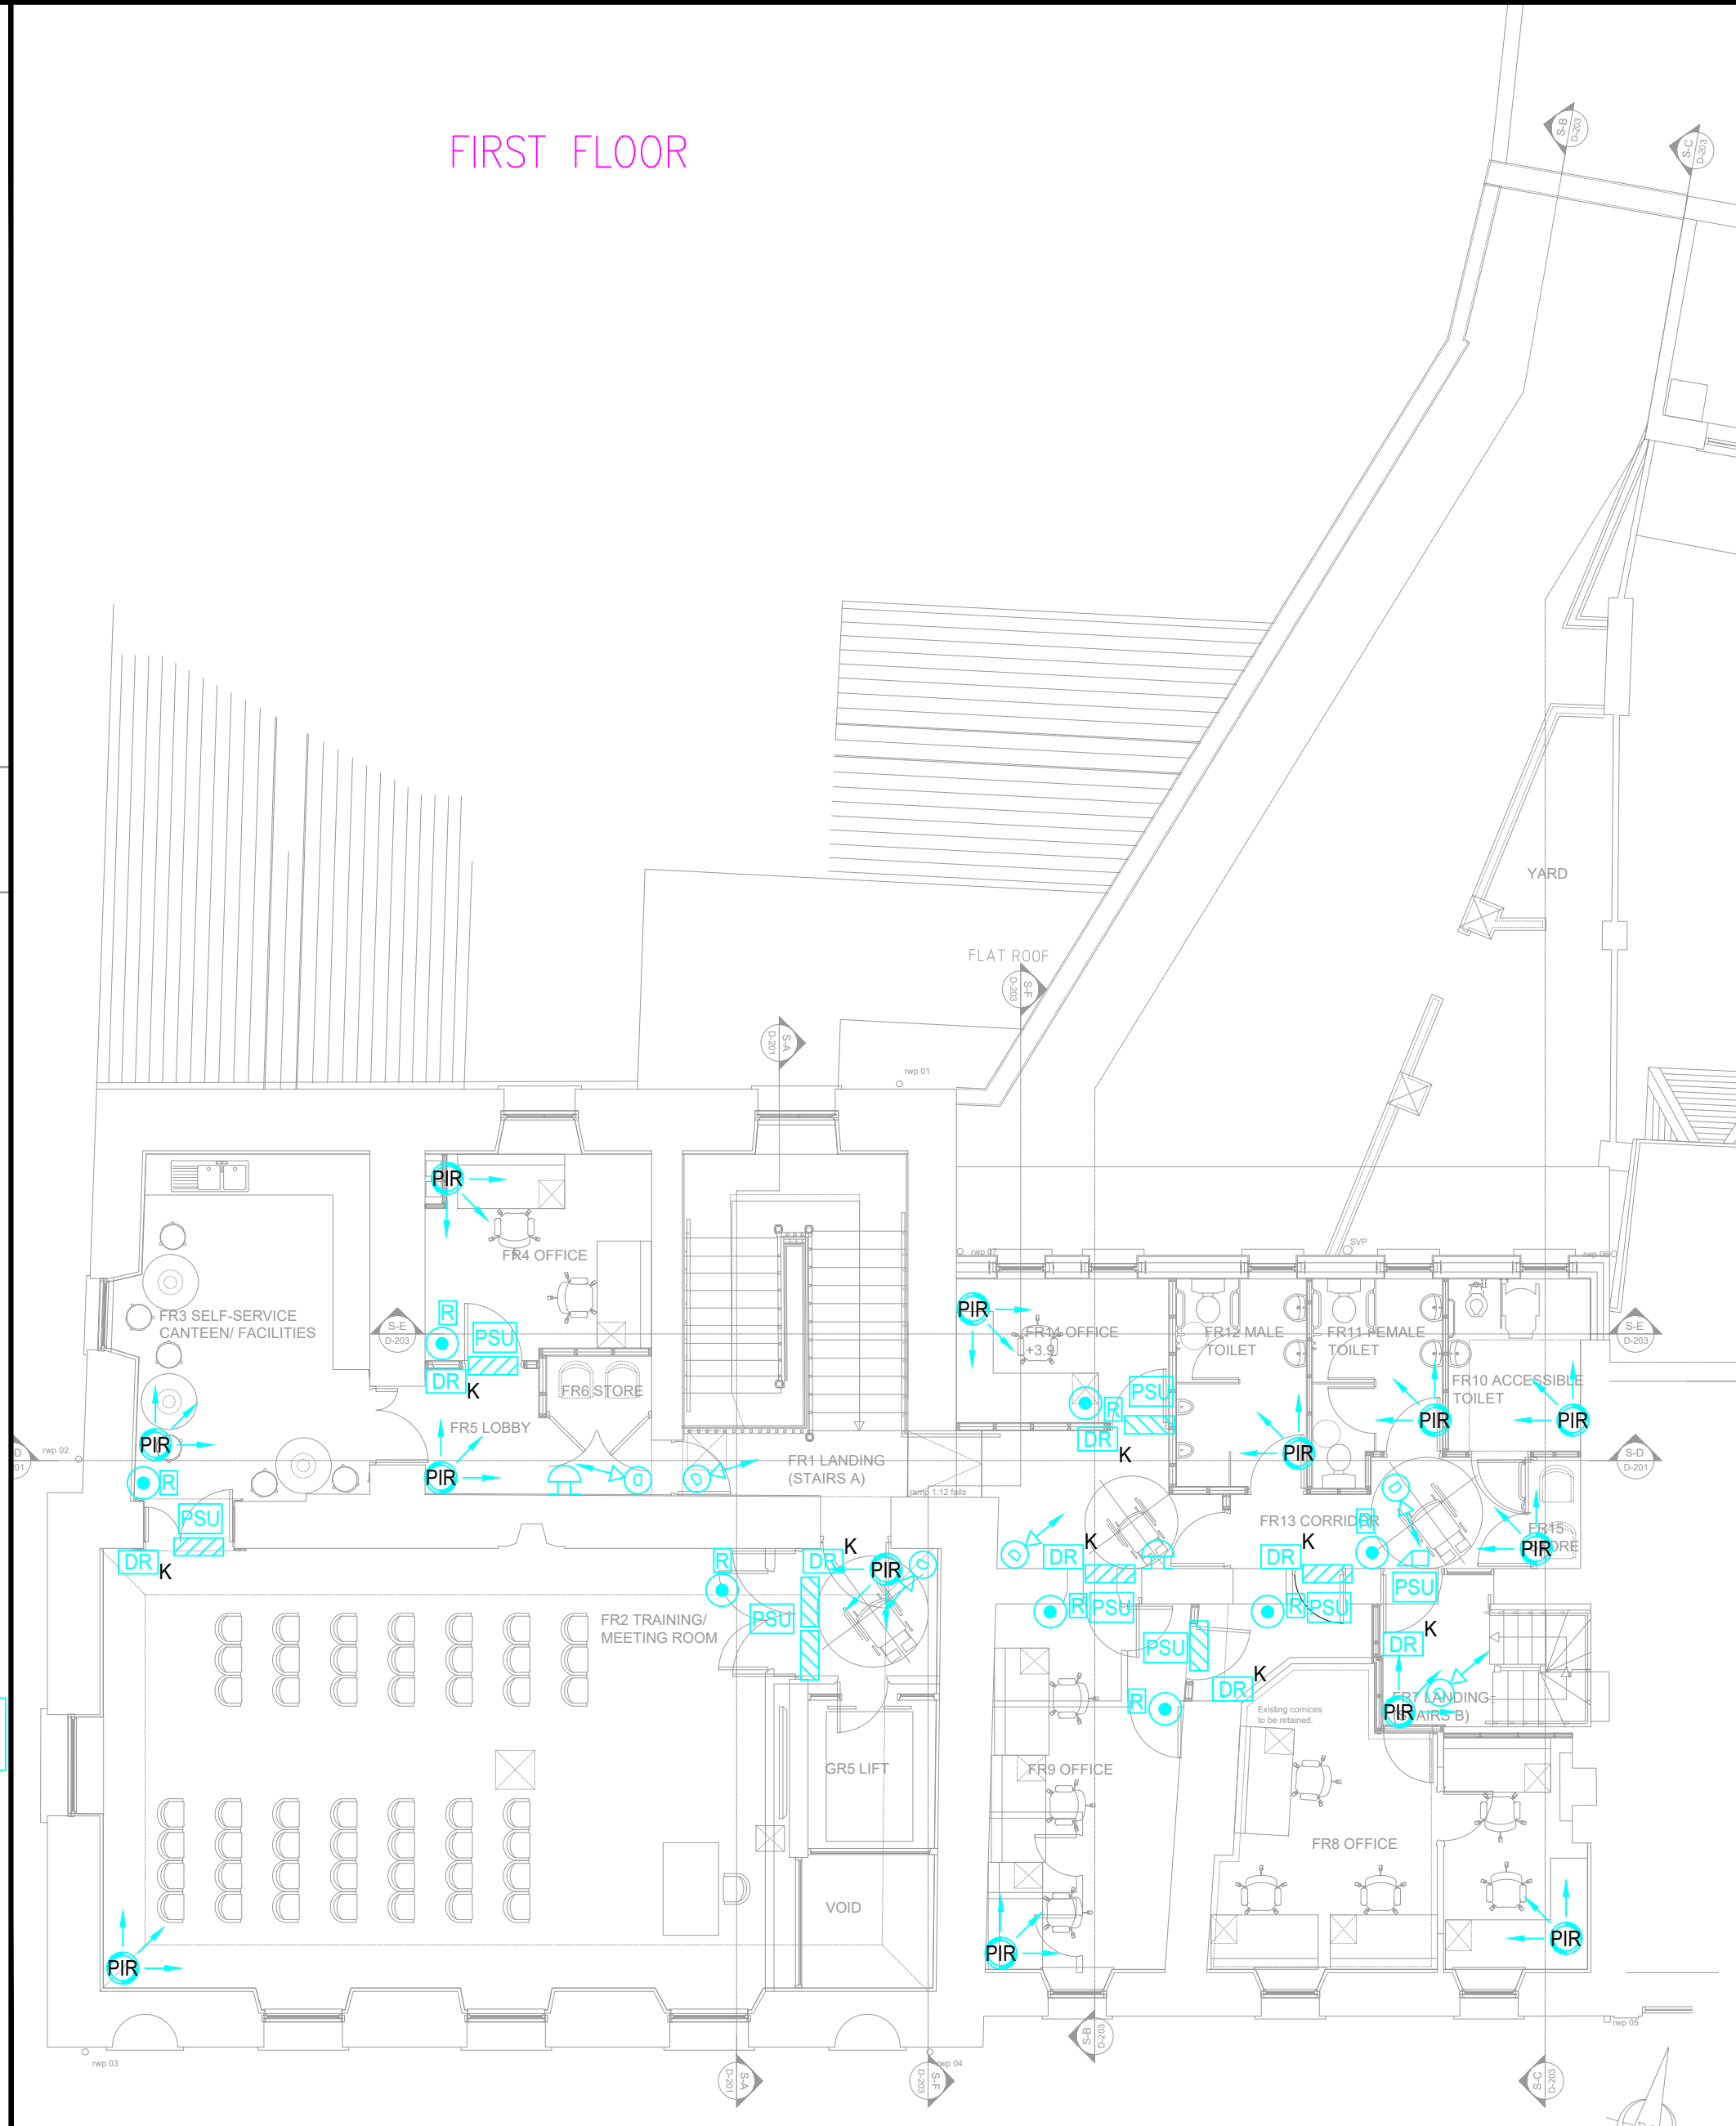
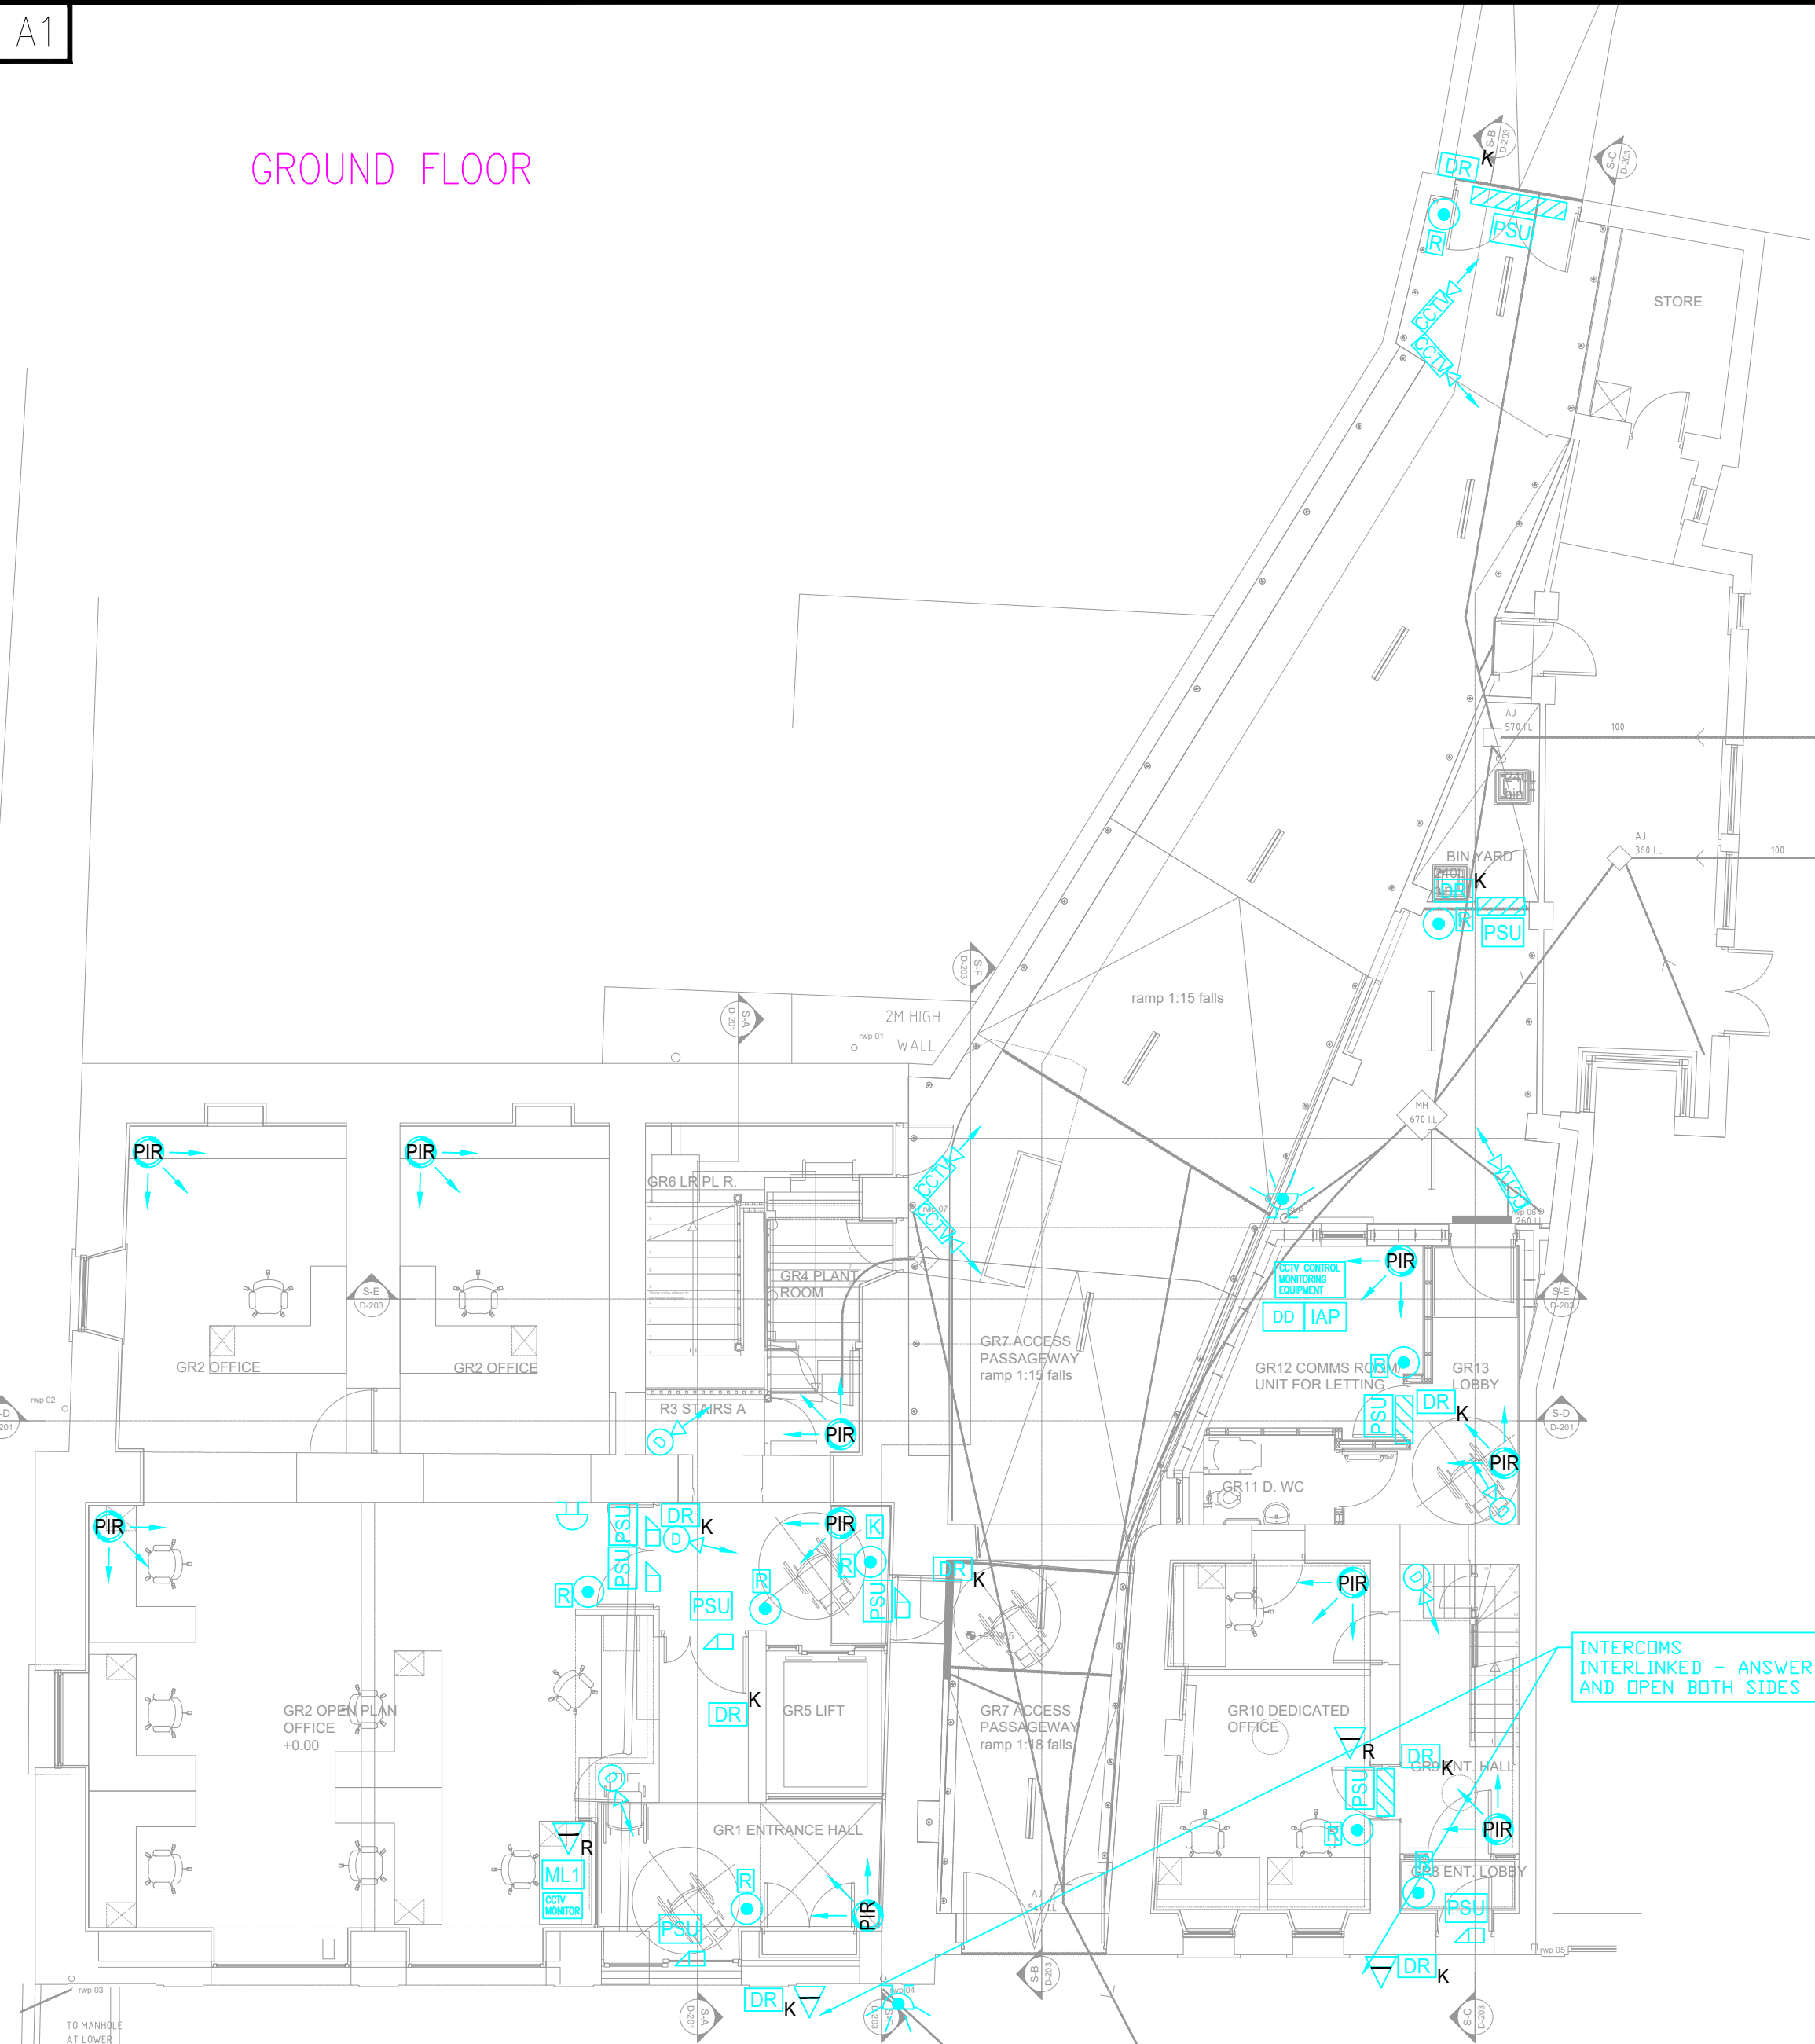


FIRST FLOOR

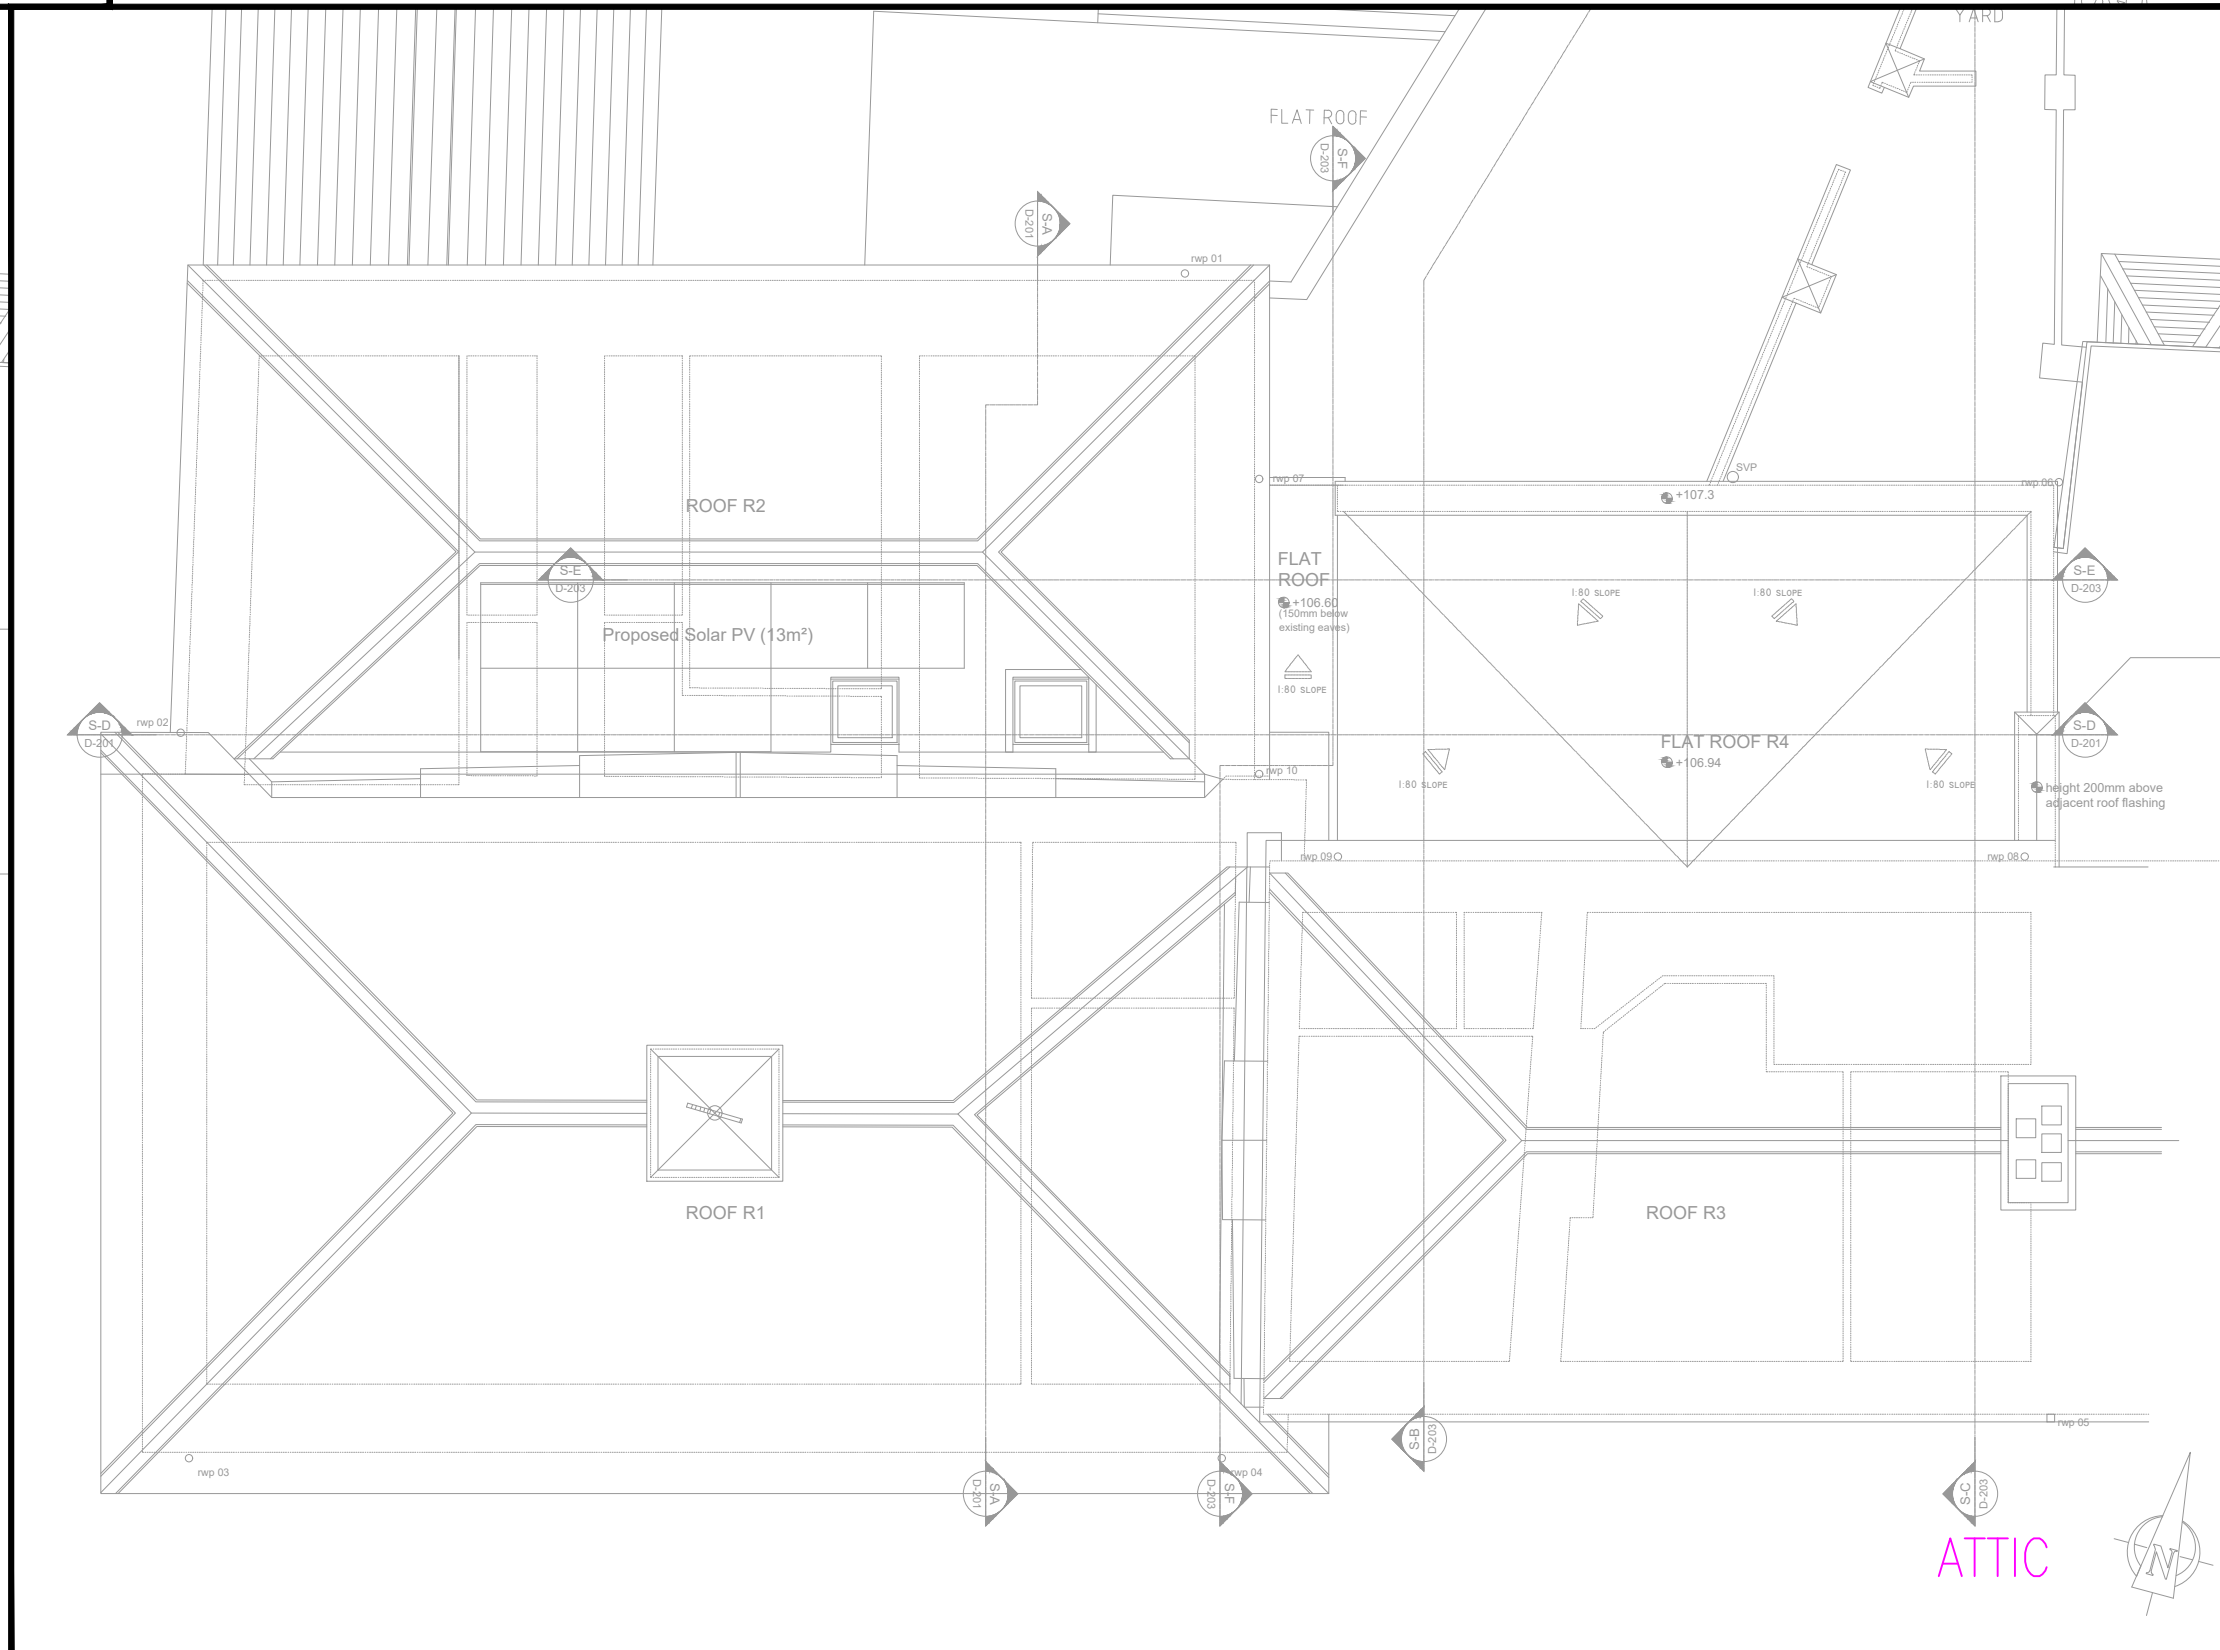

ATTIC

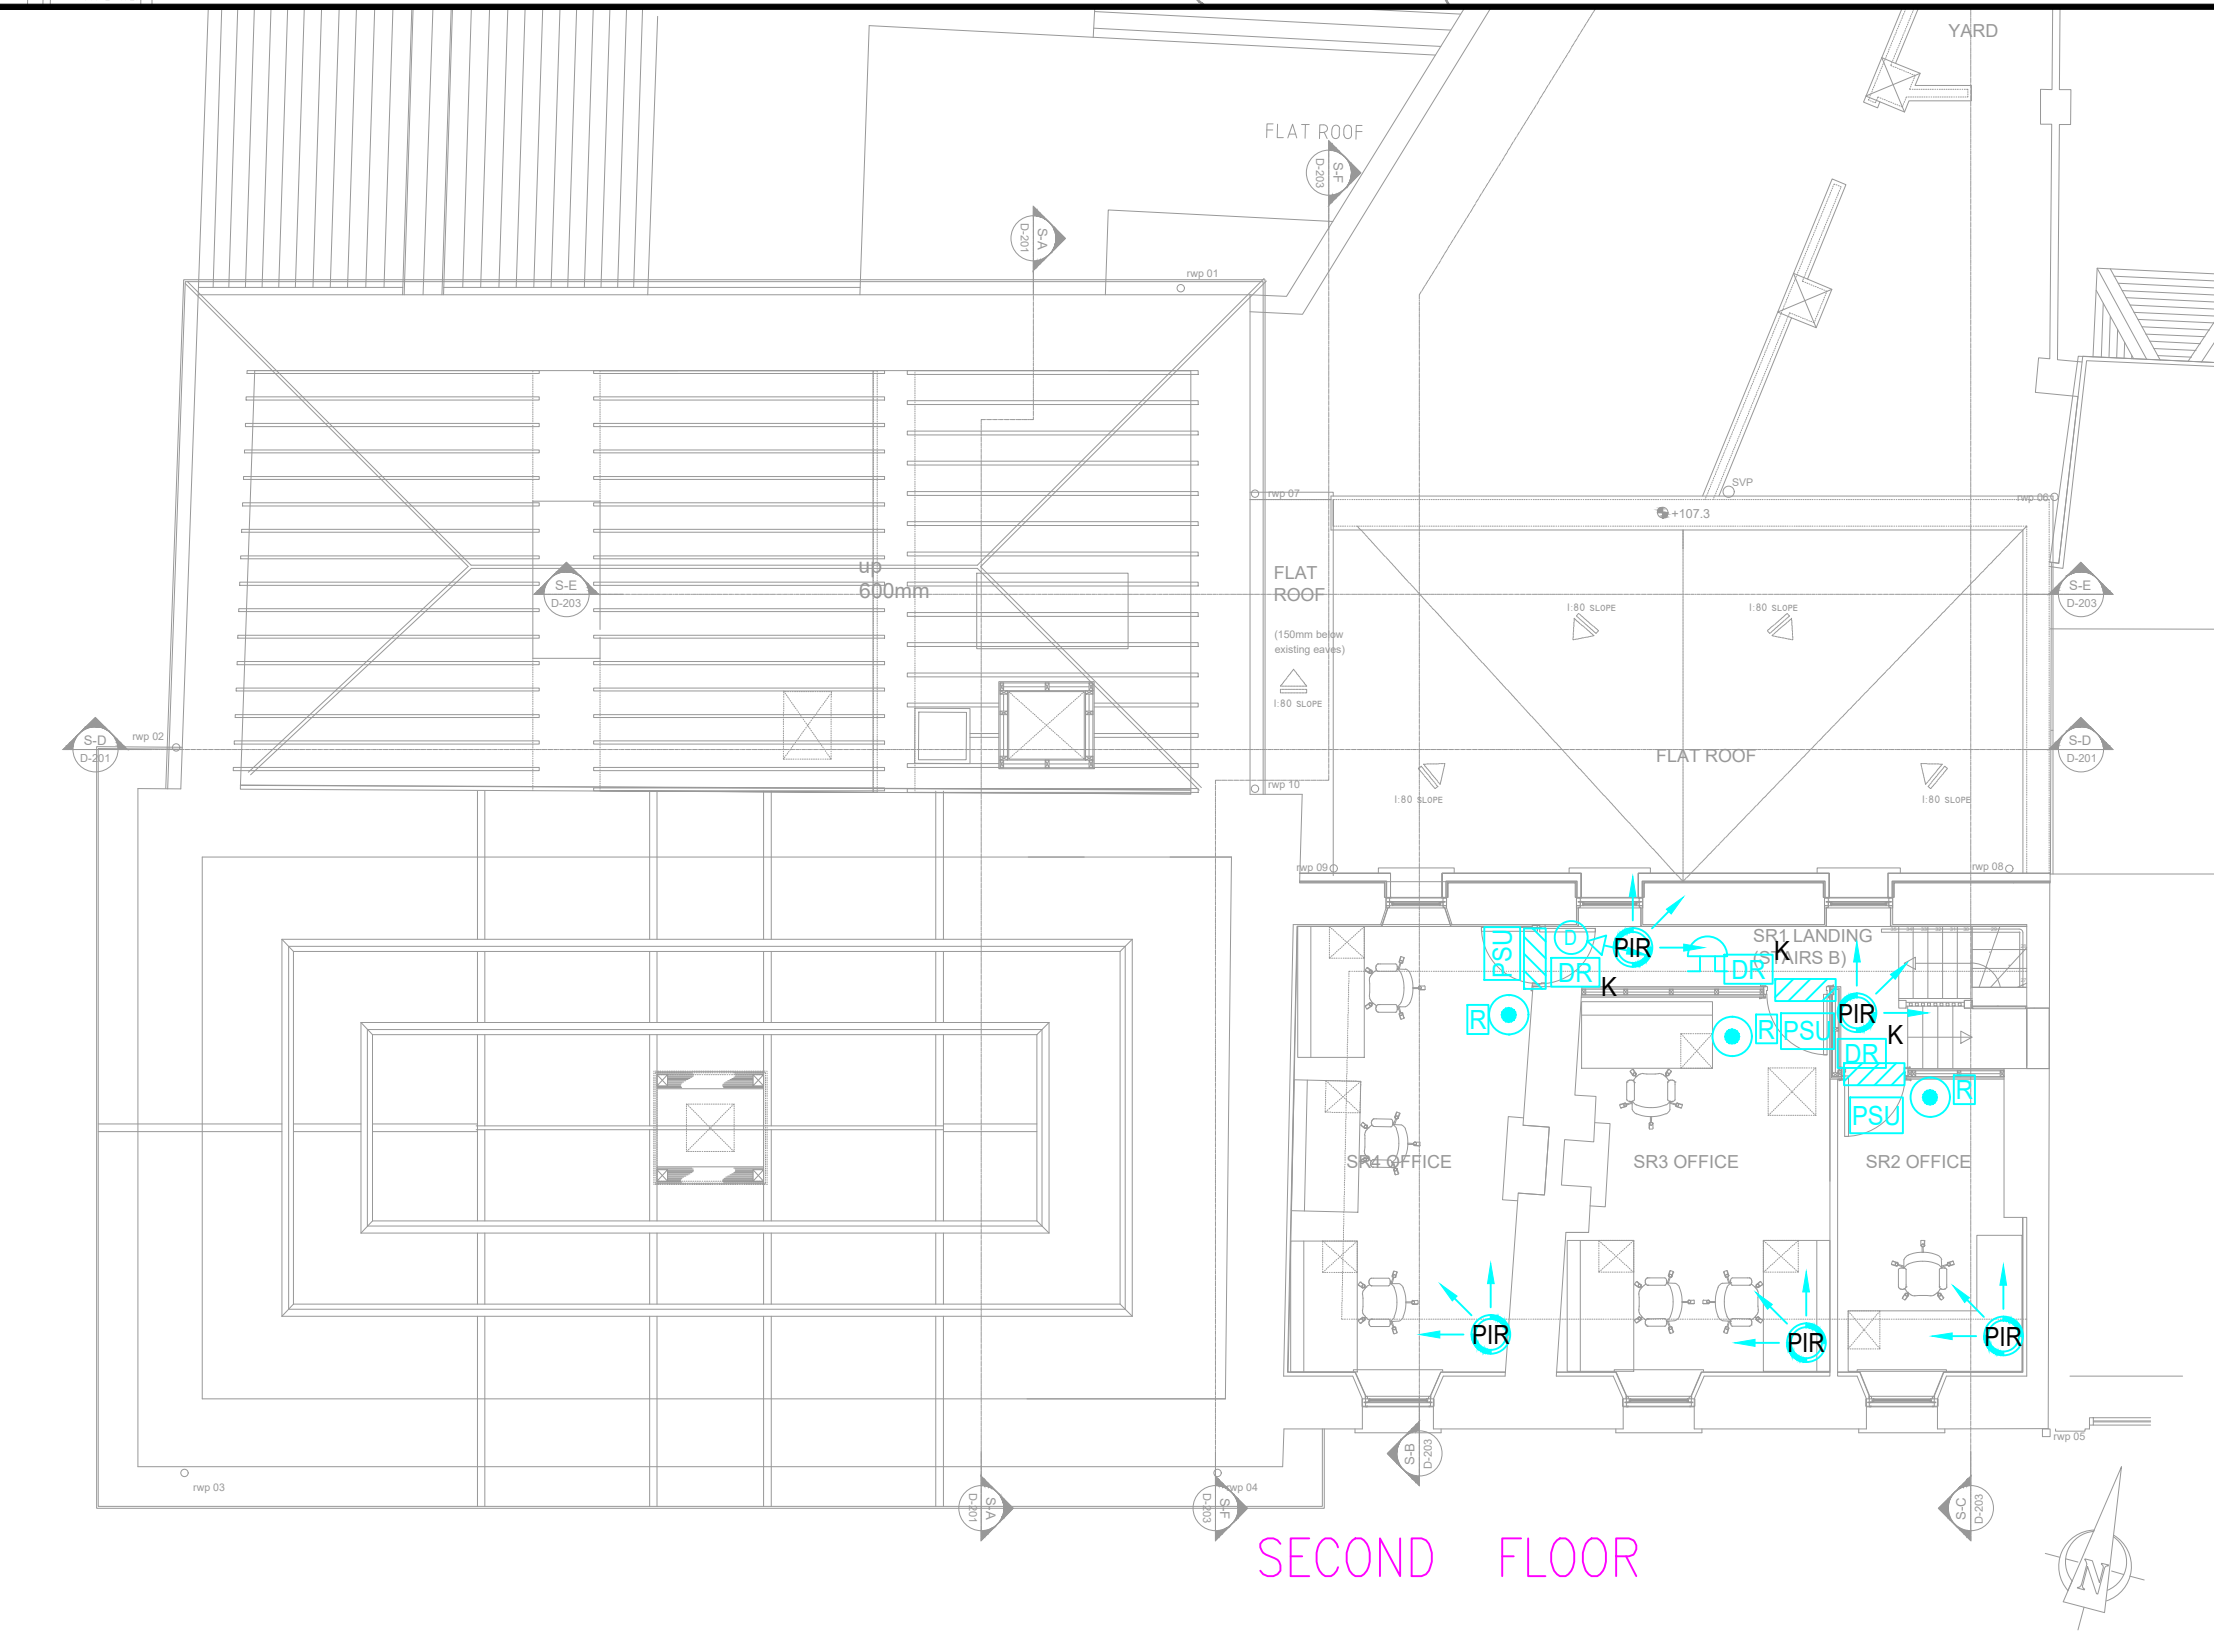

	INTRUDER ALARM PANEL
	INTRUDER ALARM DIGI-DIALLER
	INTRUDER ALARM KEYPAD
	DUAL TECH PASSIVE INFRA-RED DETECTOR
	INTRUDER ALARM INTERNAL SOUNDER
	INTRUDER ALARM EXTERNAL SOUNDER
	POWER SUPPLY UNIT
	MAGNETIC DOOR LOCK
	GREEN BREAK GLASS UNIT
	ACCESS CONTROL SYSTEM "REQUEST TO EXIT" BUTTON
	ACCESS CONTROL SYSTEM KEYPAD
	1 st CCD, 2MP INDOOR DOME CAMERA, IP65, IK10 30m IR, MIN 0.005lux
	OUTDOOR 2MP BULLET CAMERA, IK10, IP67, DUAL CMOS SENSOR, MIN 0.001lux, 100m IR
	CCTV MONITOR
	CCTV MONITORING EQUIPMENT
	ELECTRICAL LOCK SUITABLE FOR FINAL EXIT DOORS INTEGRATED WITH ACCESS CONTROL — REFER TO ARCHITECT SPECIFICATION
	MINI COUNTER INDUCTION LOOP
	TWO WAY INTERCOM WALL UNIT (STAINLESS STEEL)
	WALL MOUNTED INTERCOM RECEIVER UNIT WITH MAGNETIC DOOR LOCK RELEASE

GENERAL NOTES:

1. THIS DRAWING TO BE READ IN CONJUNCTION WITH ALL RELEVANT ARCHITECTS, C&S ENGINEERS DRAWINGS & SPECIFICATIONS.
2. ALL WORKS TO BE CARRIED OUT IN ACCORDANCE WITH THE RELEVANT BUILDING REGULATIONS.
3. DO NOT SCALE - WORK TO FIGURE DIMENSIONS ONLY.

[illegible][illegible]

Client:			
TIPPERARY COUNTY COUNCIL			
Job Description:			
CAHIR DIGITAL HUB			
Status:			
TENDER			
Drawing Title:			
SECURITY & PA SERVICES LAYOUT			
Project No:		Drawing Ref:	Rev:
21ME006		E-400	T2
Date:	Scale:		
13/09/21	1:100 @ A1 (1:200@A3)		
Drawn By:	Checked By:	Approved By:	
H.P.	N.B.	A.W.	

 Hayes Higgins
Partnership

Gas House Lane, Kilkenny.

 Gas House Lane, Kilkenny
11 Gas House, 11 Gas Lane, Seelbach,
Salem

 (056) 7764710

 (056) 7732323

 info@hh.ie

 (071) 6472321

 (071) 6420804

 admin@hayeshiggins.ie

1. DRAWINGS TO BE READ IN CONJUNCTION WITH ALL OTHER DRAWINGS AND DOCUMENTATION.
2. THE CONTRACTOR SHALL INSURE SERVICES ARE CO-ORDINATED.
3. BATTERY BACK-UP POWER SHALL BE PROVIDED FOR MAIN ENTRANCE ACCESS CONTROL DOORS.
4. ALL CALL POINTS SHALL BE INSTALLED WITH PROTECTIVE COVERS.
5. THE ALARM SHALL BE INSTALLED TO MEET THE REQUIREMENTS OF I.S. EN 50131/1:2006.
6. THE CONTRACTOR SHALL ALLOW FOR SETTING UP THE ALARM TO COMPLY WITH AN GARDA SIOCHÁNA INTRUDER ALARM POLICY.
7. THE FIRE ALARM SYSTEM SHALL BE CONNECTED TO THE DIGITAL COMMUNICATOR ON THE INTRUDER ALARM SYSTEM. WHEN THE FIRE ALARM TRIGGERS A FIRE, ALERT SHALL BE TRANSMITTED TO THE 24 HOUR CENTRAL STATION.
8. THE CONTRACTOR SHALL PROVIDE FOR ALL ASSOCIATED BUILDERS' WORK FOR TIE-INS TO THE EXISTING BUILDING, INCLUDING THE REMOVAL AND REINSTALLATION OF EXISTING CEILINGS TILES / CEILINGS.

A.3.4