


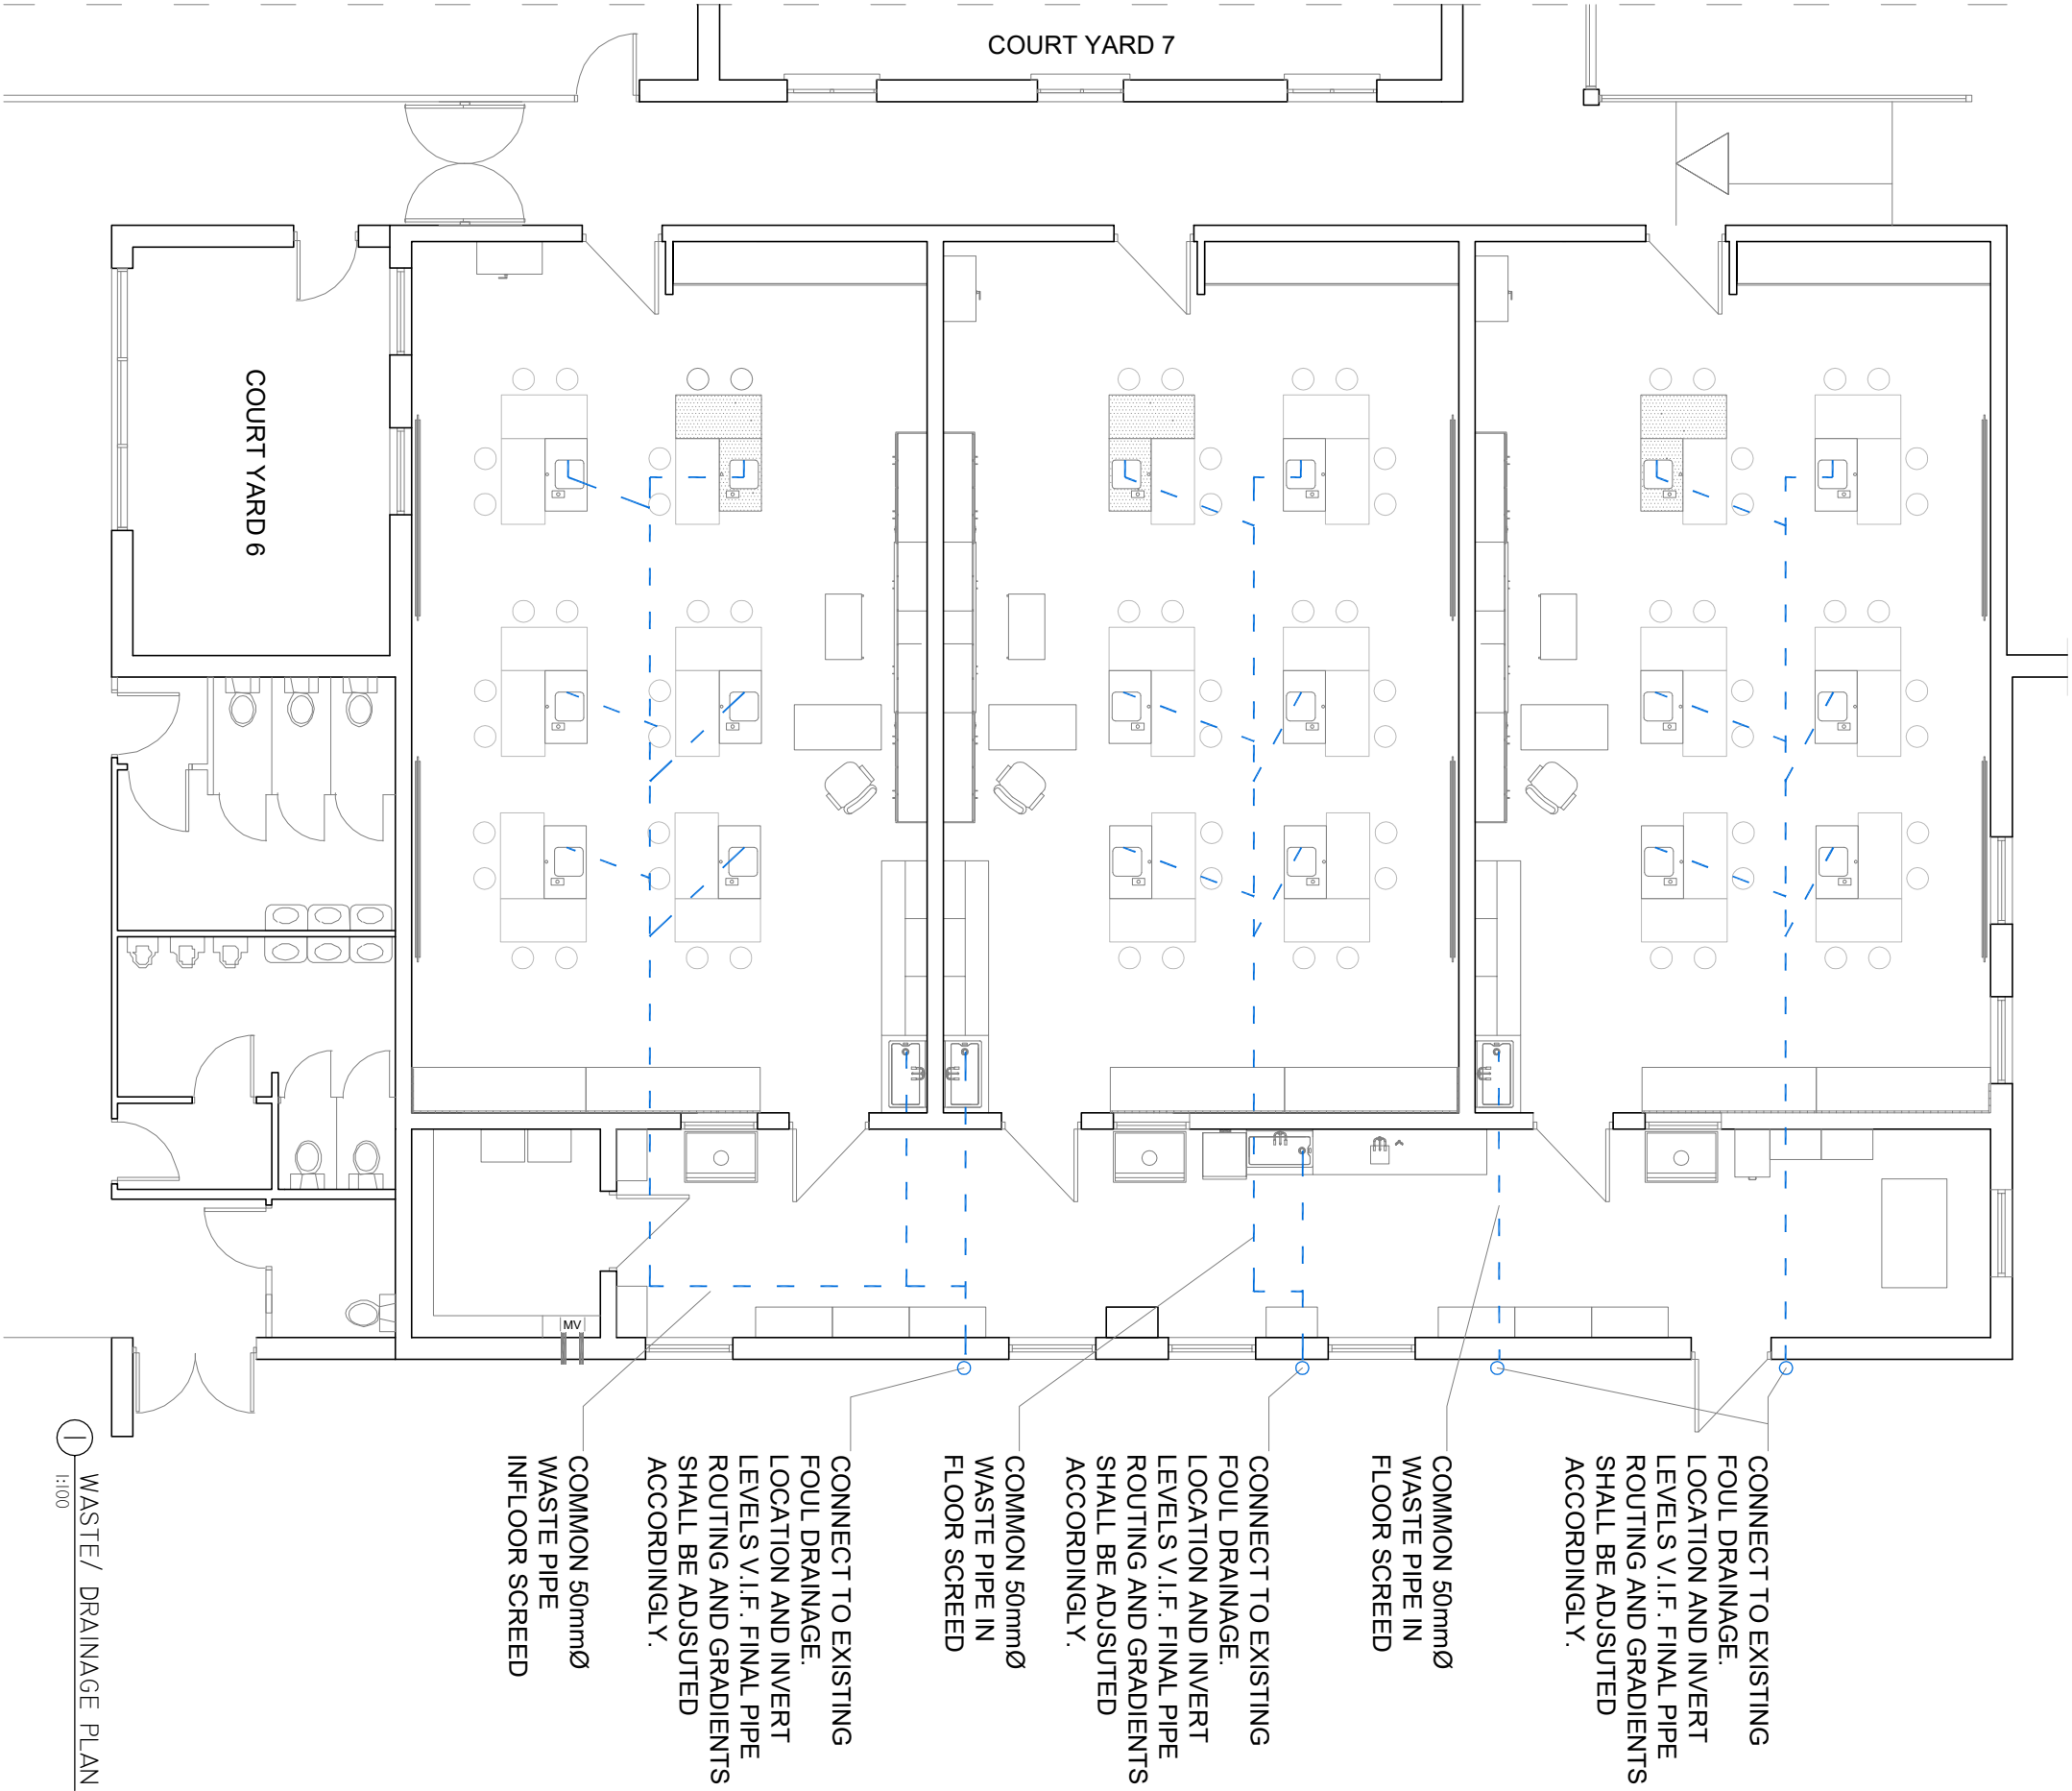

FOUL WATER DRAINAGE NOTES

- VERIFY ALL EXISTING FOUL DRAINAGE LOCATIONS, INVERT LEVELS AND PIPE SIZE ON SITE PRIOR TO COMMENCEMENT OF THE WORKS.
- THE PROPOSED DRAINAGE LAYOUT IN INDICATIVE. FINAL PIPE ROUTING SHALL BE ADJUSTED TO SUIT VERIFIED SITE CONDITIONS.
- NEW FOUL WATER DRAINAGE SHALL BE INSTALLED IN THE NEW FLOOR SCREED.
- ALL WORKS SHALL COMPLY WITH THE IRISH BUILDING REGULATIONS TGD Part H & I.S. EN 12056.
- REPORT ANY DISCREPANCIES TO THE DESIGN TEAM PRIOR TO INSTALLATION.

USE OF THIS DRAWING:			
do not scale from this drawing, use written dimension only. all dimensions and details to be checked on site by the contractor. all architects drawings, details and specifications to be cross referenced with other consultants information. all discrepancies to be brought to the attention of the architect immediately. this drawing is not suitable for construction purposes unless clearly indicated. this drawing, and any digital version, remains the copyright of paul dillon architects. only when the appropriate fee is paid to paul dillon architects is a licence to use a hard copy of this drawing in order to produce one original work, granted. this drawing can not be reproduced without this licence. this licence can only be transferred on the expressed written consent of paul dillon architects. any digital information on this drawing can only be used where paul dillon architects are the design team leaders.			
EV	02.07.26	by:	date:

A	TENDER	revision:	description:
---	--------	-----------	--------------

 paul dillon architects Maam Valley Connemara County Galway Ireland Tel. 00353 (0)87 6786244 info@pauldillonarchitects.com Fax. 00353 (0)94 9548768 www.pauldillonarchitects.com			
project:	ST TIERNANS CS, PARKVALE, BALALLY, DUBLIN		
client:	BOARD OF MANAGEMENT ST TIERNANS CS		
dwg title:	SCIENCE LAB WASTE/ DRAINAGE PLAN		
scale on A3:	1:100	started: FEB 26	by: PD dwg no: 144.29 rev: A