


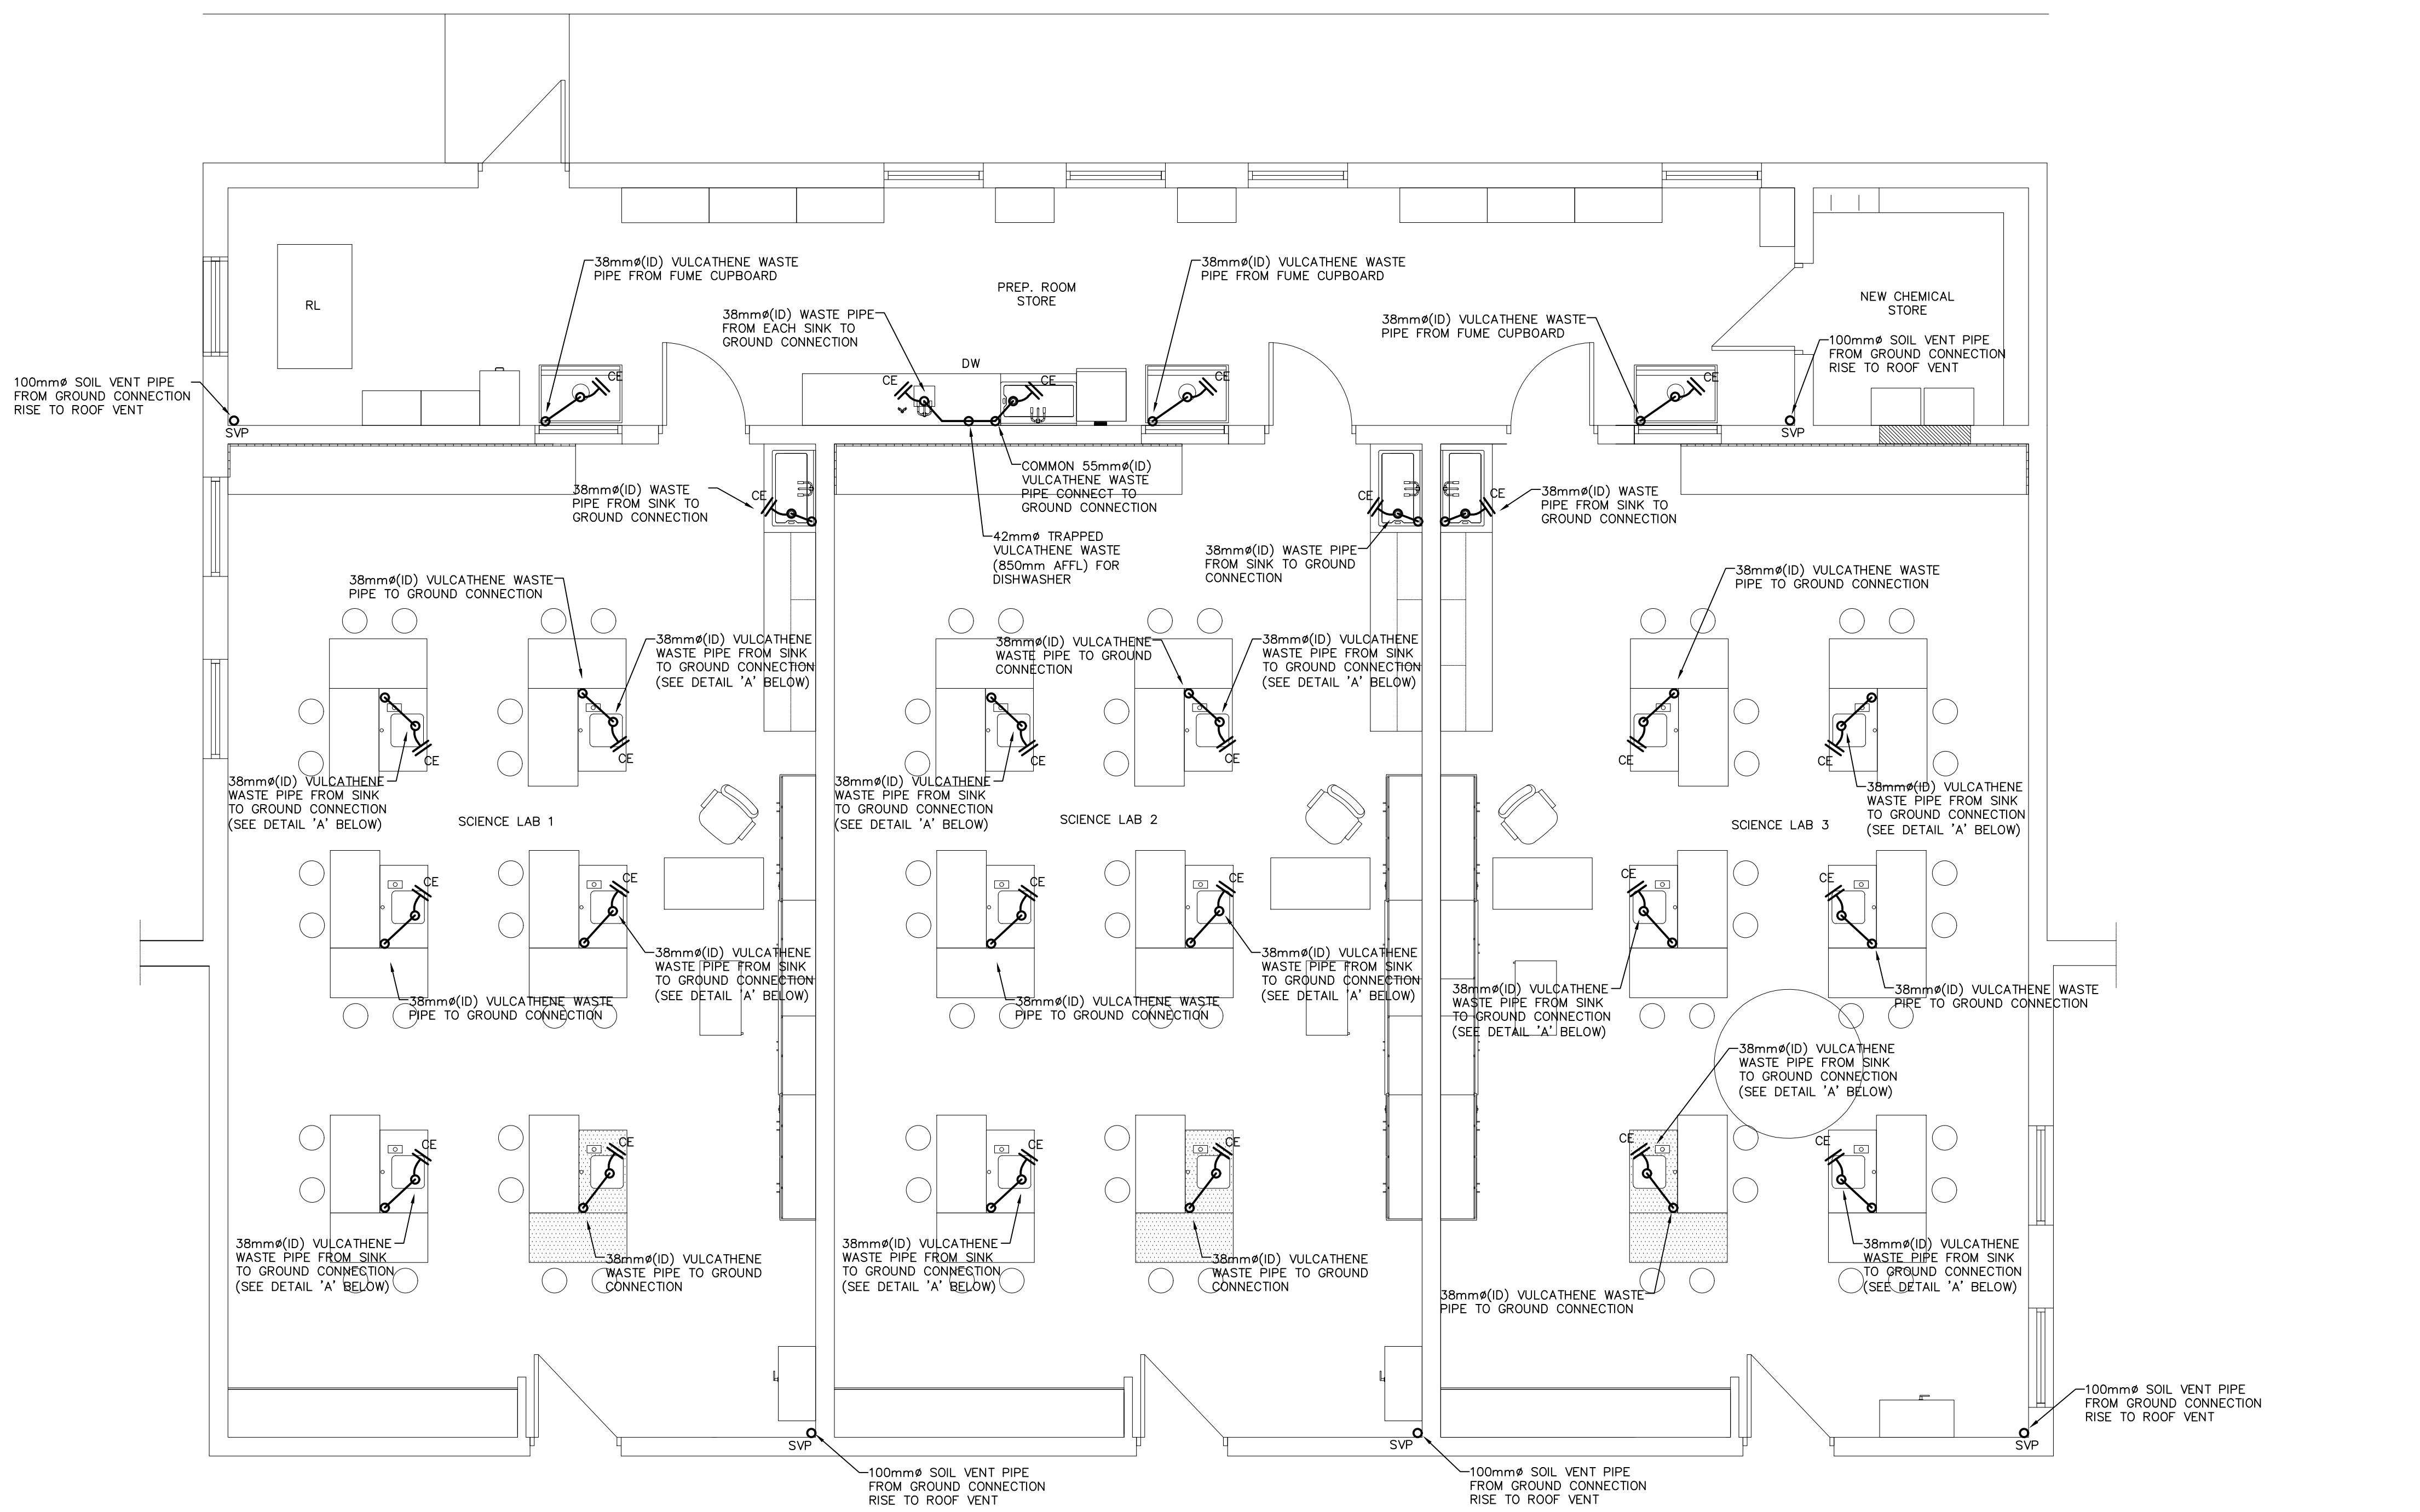

1
1:50 GROUND FLOOR PLAN

- NOTES
1. THE MECHANICAL CONTRACTOR SHALL CO-ORDINATE THE LOCATIONS OF THE GROUND CONNECTIONS TO THE UNDERGROUND DRAINAGE SYSTEM WITH THE MAIN CONTRACTOR ON SITE
 2. THE ABOVE GROUND SOILS & WASTES INSTALLATIONS SHALL COMPLY FULLY WITH THE REQUIREMENTS OF I.S EN 12056 (PART 1) 2000 & I.S EN 12056 (PART 2) 2000
 3. THE MECHANICAL CONTRACTOR SHALL SUPPLY & INSTALL ALL WC PAN CONNECTORS REQUIRED FOR THE SOIL CONNECTIONS BETWEEN THE WC & THE GROUND CONNECTIONS AS SPECIFIED & AS DETAILED ON THE DRAWINGS
 4. THE MAIN CONTRACTOR SHALL SUPPLY, ASSEMBLE & PLACE IN POSITION ALL SANITARY WARE, INCLUDING ALL WASTE OUTLETS, BOTTLE WASTE TRAPS ETC AS DETAILED IN THE ARCHITECTS SCHEDULE OF SANITARY WARE.
 5. ALL EXTERNAL SVPs SHALL BE BY THE MAIN CONTRACTOR AS INDICATED BY THE ARCHITECT'S DRAWINGS.

KEY	
○A	100mm (ID) SOIL PIPE TO FLOOR CONNECTION
○B	36mm (ID) WASTE PIPE TO FLOOR CONNECTION
○C	42mm (ID) WASTE PIPE TO FLOOR CONNECTION
○D	55mm (ID) WASTE PIPE TO FLOOR CONNECTION
■FG	FLOOR GULLY BY MAIN CONTRACTOR
⊗CE	CLEANING EYE
⊗FC	FIRE COLLAR

REV	BY	DATE	DESCRIPTION

VOLUME A.3.3.1

DRAFT TENDER

PROJECT:
CLIMATE ACTION - 3No SCIENCE LABORATORIES & 2No HOME ECONOMICS ROOM AT ST TIERNAN'S COMMUNITY SCHOOL, D16

TITLE:
LAYOUT OF ABOVE-GROUND SOILS & WASTE INSTALLATION - 3No. SCIENCE LABS

HEAVEY KENNY ASSOCIATES CONSULTING ENGINEERS
Mechanical and Electrical Building Services
6 Liosban Business Park, 23E First Floor,
Tuam Road, Galway Tel: (091) 566004/565184
E-mail: admin@heaveykennyassociates.ie
Website: www.heaveykennyassociates.ie

DESIGNED: JC
DRAWN BY: LP
DATE: JUNE 2026
SCALE: AS SHOWN

ARCH: PAUL DILLON ARCHITECTS, MAAM VALLEY, Co. GALWAY
CHECKED BY:

DRG.No. **6940/M52/01**

REV. -