


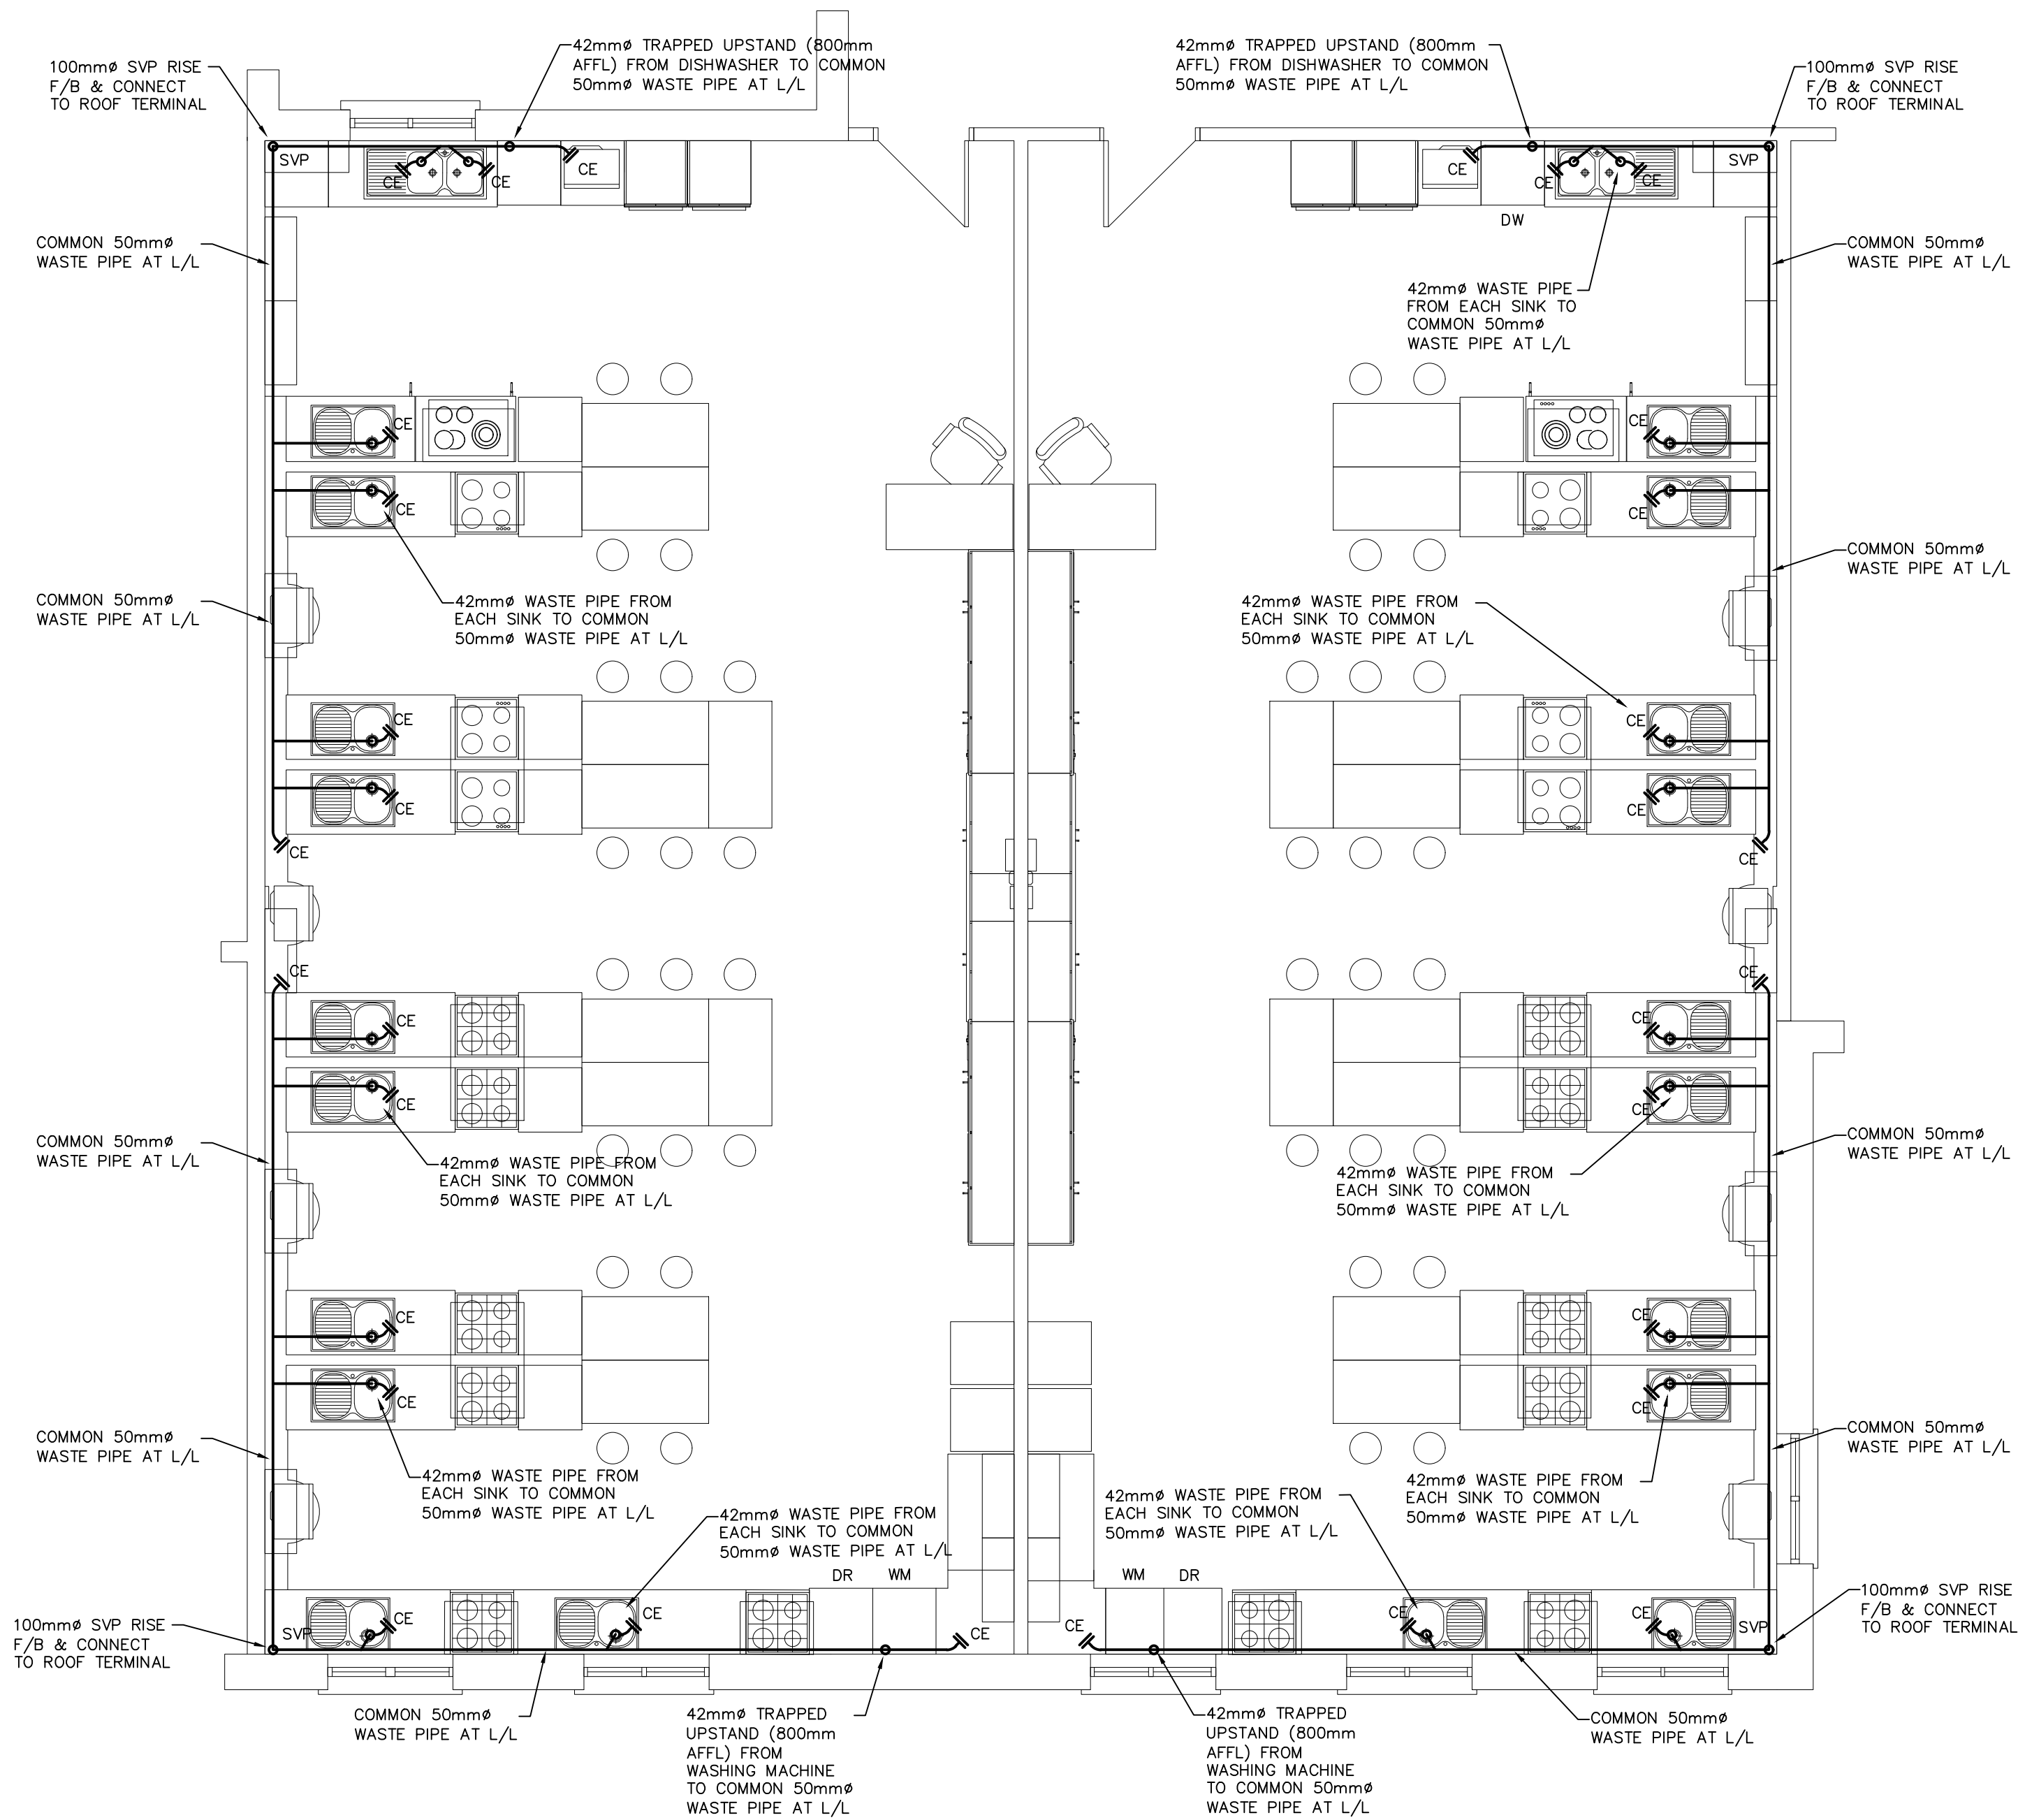

1  
1:50 GROUND FLOOR PLAN – 2N0 HOME ECONOMIC ROOMS

#### NOTES

1. THE MECHANICAL CONTRACTOR SHALL CO-ORDINATE THE LOCATIONS OF THE GROUND CONNECTIONS TO THE UNDERGROUND DRAINAGE SYSTEM WITH THE MAIN CONTRACTOR ON SITE
2. THE ABOVE GROUND SOILS & WASTES INSTALLATIONS SHALL COMPLY FULLY WITH THE REQUIREMENTS OF I.S EN 12056 (PART 1) 2000 & I.S EN 12056 (PART 2) 2000
3. THE MECHANICAL CONTRACTOR SHALL SUPPLY & INSTALL ALL WC PAN CONNECTORS REQUIRED FOR THE SOIL CONNECTIONS BETWEEN THE WC & THE GROUND CONNECTIONS AS SPECIFIED & AS DETAILED ON THE DRAWINGS
4. THE MAIN CONTRACTOR SHALL SUPPLY, ASSEMBLE & PLACE IN POSITION ALL SANITARY WARE, INCLUDING ALL WASTE OUTLETS, BOTTLE WASTE TRAPS ETC AS DETAILED IN THE ARCHITECTS SCHEDULE OF SANITARY WARE.
5. ALL EXTERNAL SVPs SHALL BE BY THE MAIN CONTRACTOR AS INDICATED BY THE ARCHITECT'S DRAWINGS.

#### KEY

|    |                                      |
|----|--------------------------------------|
| OA | 100mmØ SOIL PIPE TO FLOOR CONNECTION |
| OB | 36mmØ WASTE PIPE TO FLOOR CONNECTION |
| OC | 42mmØ WASTE PIPE TO FLOOR CONNECTION |
| OD | 55mmØ WASTE PIPE TO FLOOR CONNECTION |
| FG | FLOOR GULLY BY MAIN CONTRACTOR       |
| CE | CLEANING EYE                         |
| FC | FIRE COLLAR                          |

REV BY: DATE: DESCRIPTION:

### VOLUME A.3.3.1

### DRAFT TENDER

PROJECT:  
CLIMATE ACTION - 3N0 SCIENCE LABORATORIES & 2N0 HOME ECONOMICS ROOM AT ST TIERNAN'S COMMUNITY SCHOOL, D16

TITLE:  
LAYOUT OF ABOVE-GROUND SOILS & WASTE INSTALLATION - 2N0 HOME ECONOMIC ROOMS

**HEAVEY KENNY ASSOCIATES**  
**CONSULTING ENGINEERS**  
Mechanical and Electrical Building Services  
6 Liosban Business Park, 23E First Floor,  
Tuum Road, Galway Tel: (091) 566004/565184  
E-mail: admin@heaveykennyassociates.ie  
**Website: www.heaveykennyassociates.ie**



HEAVEY KENNY ASSOCIATES SHALL HAVE NO RESPONSIBILITY FOR ANY USE MADE OF THIS DOCUMENT OTHER THAN FOR THAT WHICH IT WAS PREPARED AND ISSUED. ALL DIMENSIONS SHOULD BE CHECKED ON SITE. DO NOT SCALE FROM THIS DRAWING. ANY DRAWING ERRORS OR OMISSIONS SHOULD BE BROUGHT TO THE ATTENTION OF HEAVEY KENNY ASSOCIATES AT THE ADDRESS ABOVE.

|                                                                    |                                                                            |
|--------------------------------------------------------------------|----------------------------------------------------------------------------|
| DESIGNED: JC<br>DRAWN BY: LP<br>DATE: JUNE 2026<br>SCALE: AS SHOWN | ARCH: PAUL DILLON ARCHITECTS,<br>MAAM VALLEY,<br>Co. GALWAY<br>CHECKED BY: |
|--------------------------------------------------------------------|----------------------------------------------------------------------------|

|                               |           |
|-------------------------------|-----------|
| DRG.No.<br><b>6940/M52/02</b> | REV.<br>- |
|-------------------------------|-----------|